

**LEGEND:**


- RECTANGULAR DUCTWORK (AT ALL LEVELS)
- FIRE DAMPER
- FLEXIBLE CONNECTION

- NOTES:**
- THIS DRAWING SHALL BE READ IN CONJUNCTION WITH ALL OTHER M&E SERVICES DRAWINGS, TOGETHER WITH THE ARCHITECTS & STRUCTURAL DRAWINGS AND ASSOCIATED SPECIFICATIONS.
  - ALL SERVICES PASSING THROUGH FIRE COMPARTMENT WALLS WILL BE IN ACCORDANCE WITH THE RELEVANT SPECIFICATION & BRITISH STANDARDS.
  - FLEXIBLE DUCTWORK LENGTHS SHALL NOT EXCEED 500mm AND SHALL NOT BE USED FOR CHANGES OF DIRECTION.
  - THE RESPONSIBILITY FOR THE SUPPORT OF THE ENTIRE DUCTWORK SYSTEMS AND ASSOCIATED PLANT SHALL BE THAT OF THE MECHANICAL CONTRACTOR.

**SAFETY, HEALTH AND ENVIRONMENTAL INFORMATION**

NO SIGNIFICANT RISK WHICH REQUIRES TO BE COMMUNICATED TO A COMPETENT CONTRACTOR HAS BEEN IDENTIFIED IN RELATION TO THIS DRAWING.

THESE NOTES ARE BASED ON THE USE OF EXPERIENCED AND COMPETENT CONTRACTORS CARRYING OUT THE WORK USING AN APPROVED SAFE METHOD OF WORKING.

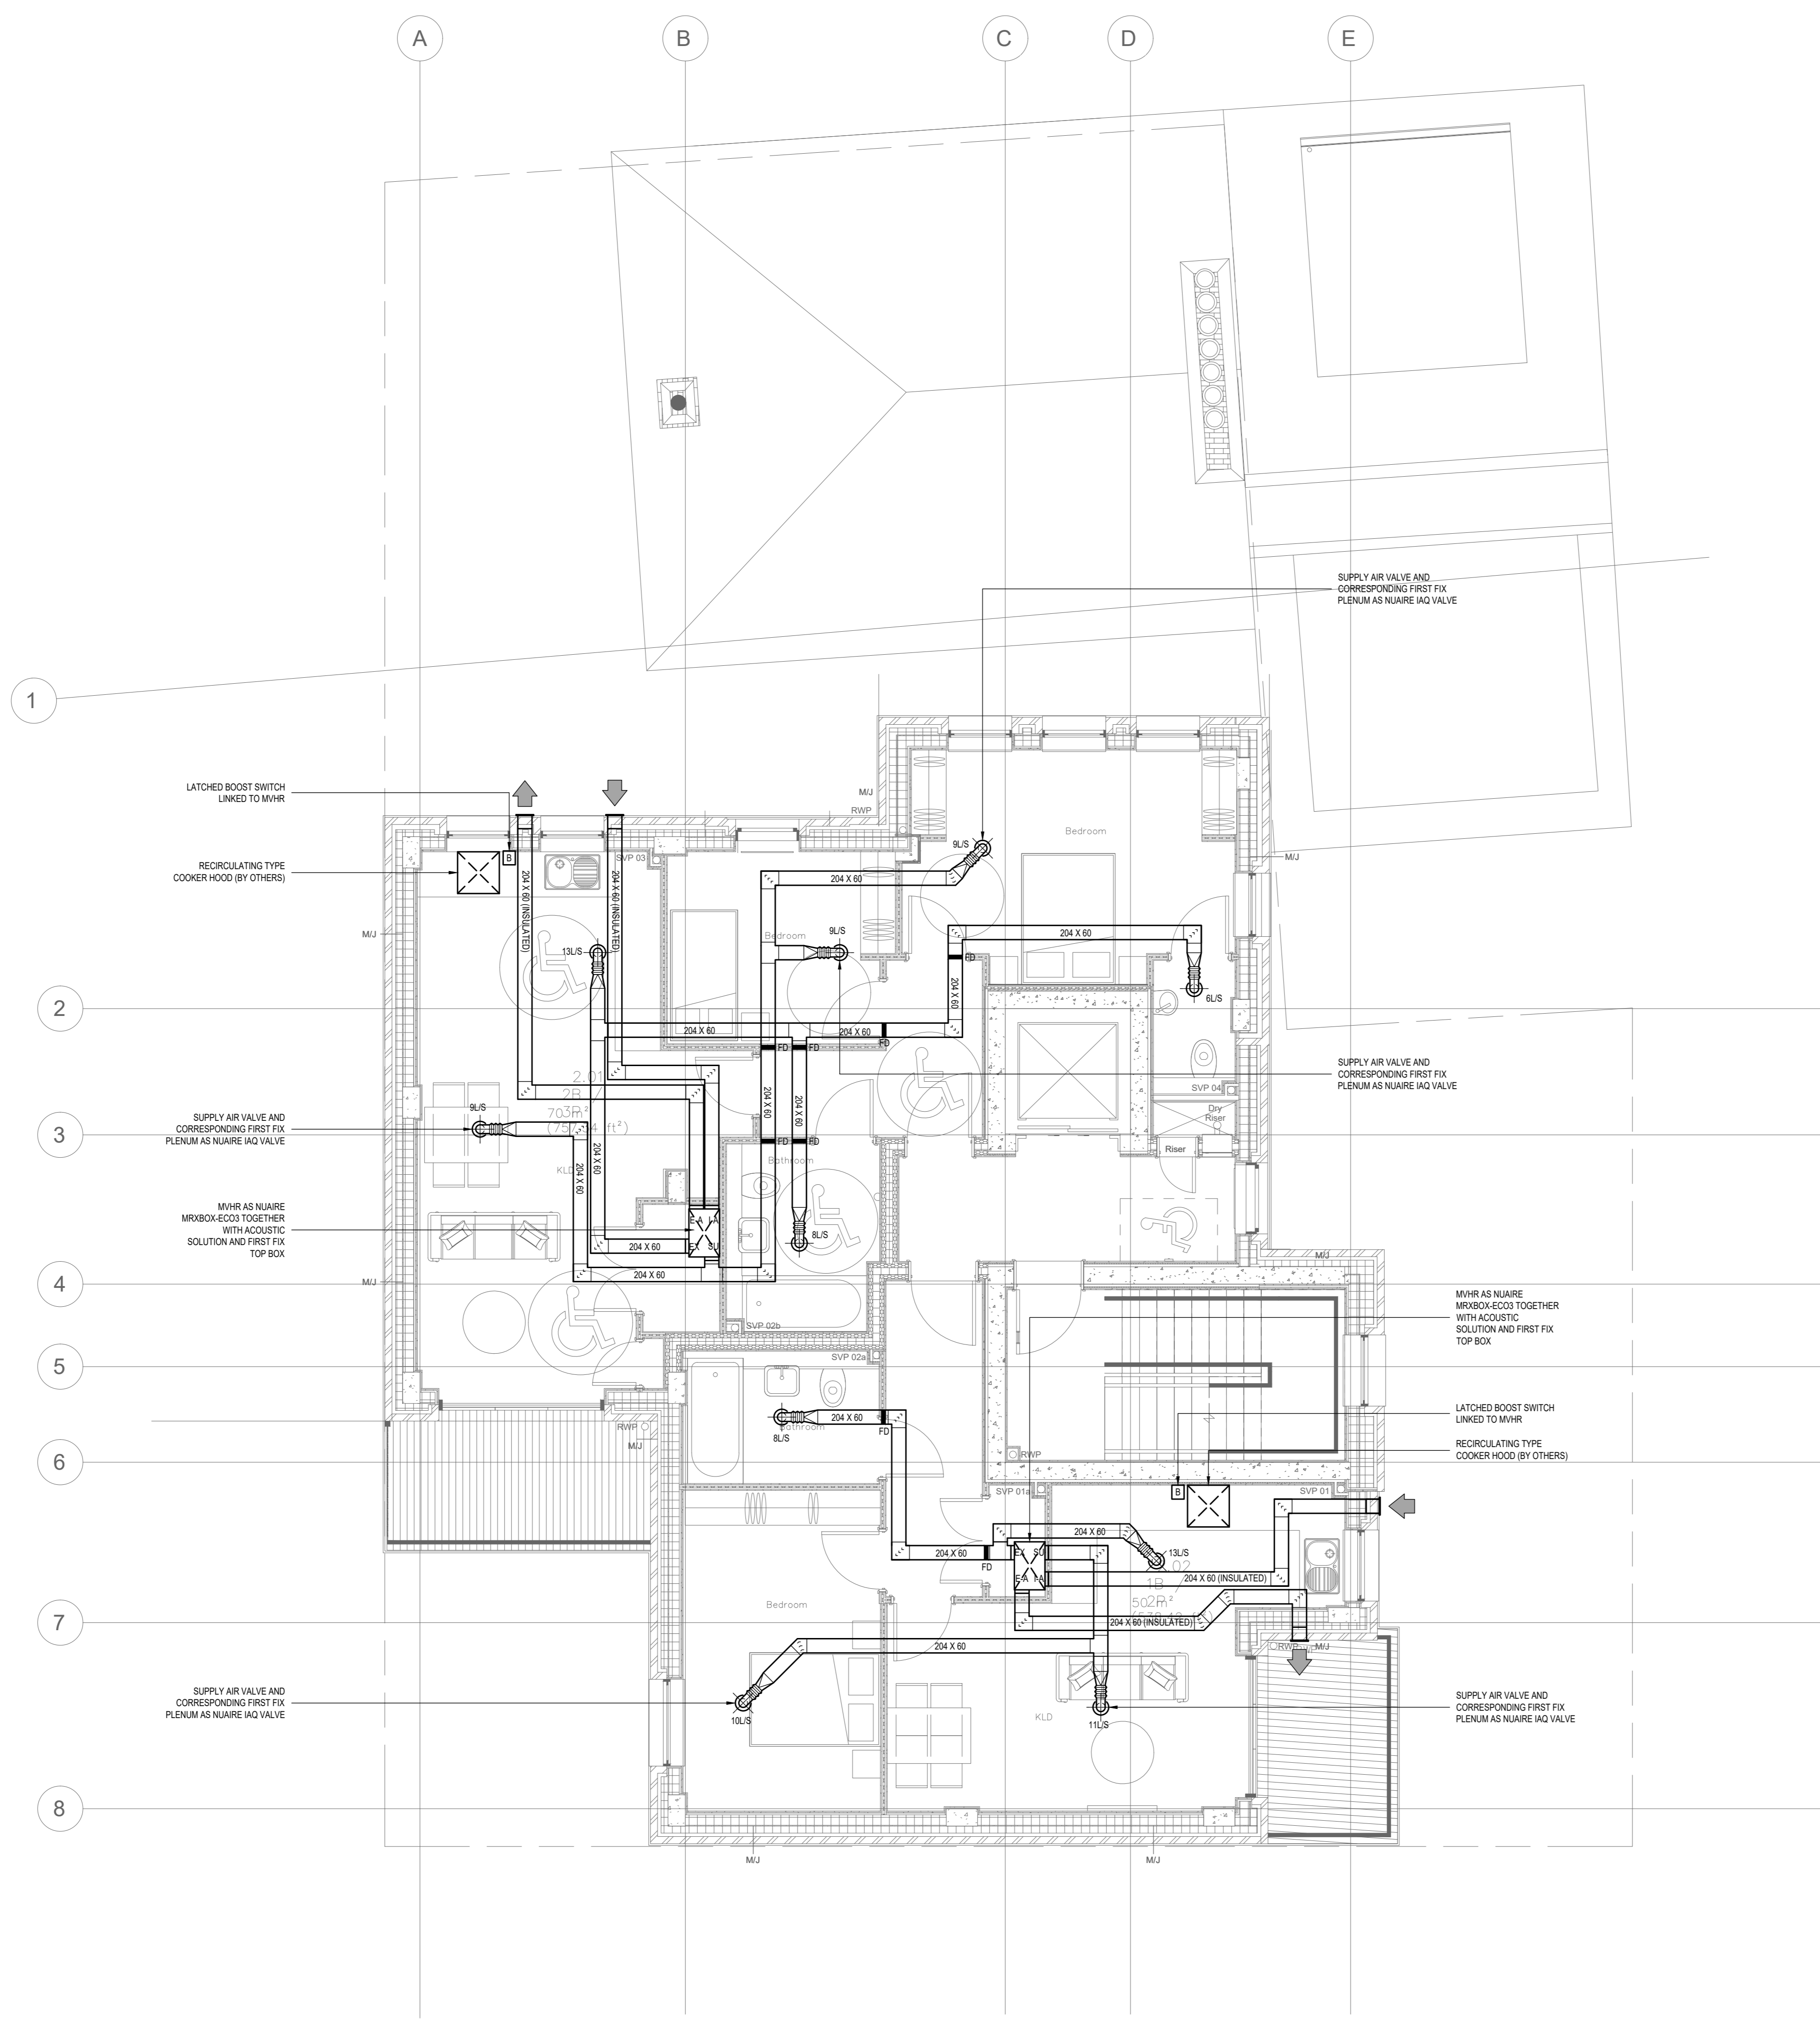

No.	Description	Origin	Drawn	Checked	Date
T2	TENDER ISSUE	J.I.	J.I.	J.I.	31/05/24
T1	TENDER ISSUE	J.I.	J.I.	J.I.	09/02/24

Revisions:

Approval Process:

Checked by: \_\_\_\_\_ Date: \_\_\_\_\_

A - Approved  
 B - Approved with comments  
 C - Revised with comments & re-submit  
 D - Do not use



Drawing Status: **TENDER ISSUE**

Client: **KK4 LTD**

Project Title: **BIRD IN HAND WEST END LANE NW6 4NX**

Drawing Title: **VENTILATION LAYOUT SECOND FLOOR**

Scale @ A0:	Originator:	Drawn by:	Checked:
1:50	J.I.	J.I.	J.I.
Project No.:	Date:		
IP23040	JAN 24		
Drawing No.:	Revision:		
IP23040-L-M-213	T2		

DO NOT SCALE FROM THIS DRAWING  
ALL DIMENSIONS TO BE CONFIRMED ON SITE