 




SAFETY, HEALTH AND ENVIRONMENTAL INFORMATION

NO SIGNIFICANT RISK WHICH REQUIRES TO BE COMMUNICATED TO A COMPETENT CONTRACTOR HAS BEEN IDENTIFIED IN RELATION TO THIS DRAWING.


THESE NOTES ARE BASED ON THE USE OF EXPERIENCED AND COMPETENT CONTRACTORS CARRYING OUT THE WORK USING AN APPROVED SAFE METHOD OF WORKING.

LEGEND:

-  RECTANGULAR DUCTWORK (AT ALL LEVELS)
-  FIRE DAMPER
-  FLEXIBLE CONNECTION

NOTES:

1. THIS DRAWING SHALL BE READ IN CONJUNCTION WITH ALL OTHER M&E SERVICES DRAWINGS, TOGETHER WITH THE ARCHITECTS & STRUCTURAL DRAWINGS AND ASSOCIATED SPECIFICATIONS.
2. ALL SERVICES PASSING THROUGH FIRE COMPARTMENT WALLS WILL BE IN ACCORDANCE WITH THE RELEVANT SPECIFICATION & BRITISH STANDARDS.
3. FLEXIBLE DUCTWORK LENGTHS SHALL NOT EXCEED 500mm AND SHALL NOT BE USED FOR CHANGES OF DIRECTION.
4. THE RESPONSIBILITY FOR THE SUPPORT OF THE ENTIRE DUCTWORK SYSTEMS AND ASSOCIATED PLANT SHALL BE THAT OF THE MECHANICAL CONTRACTOR.

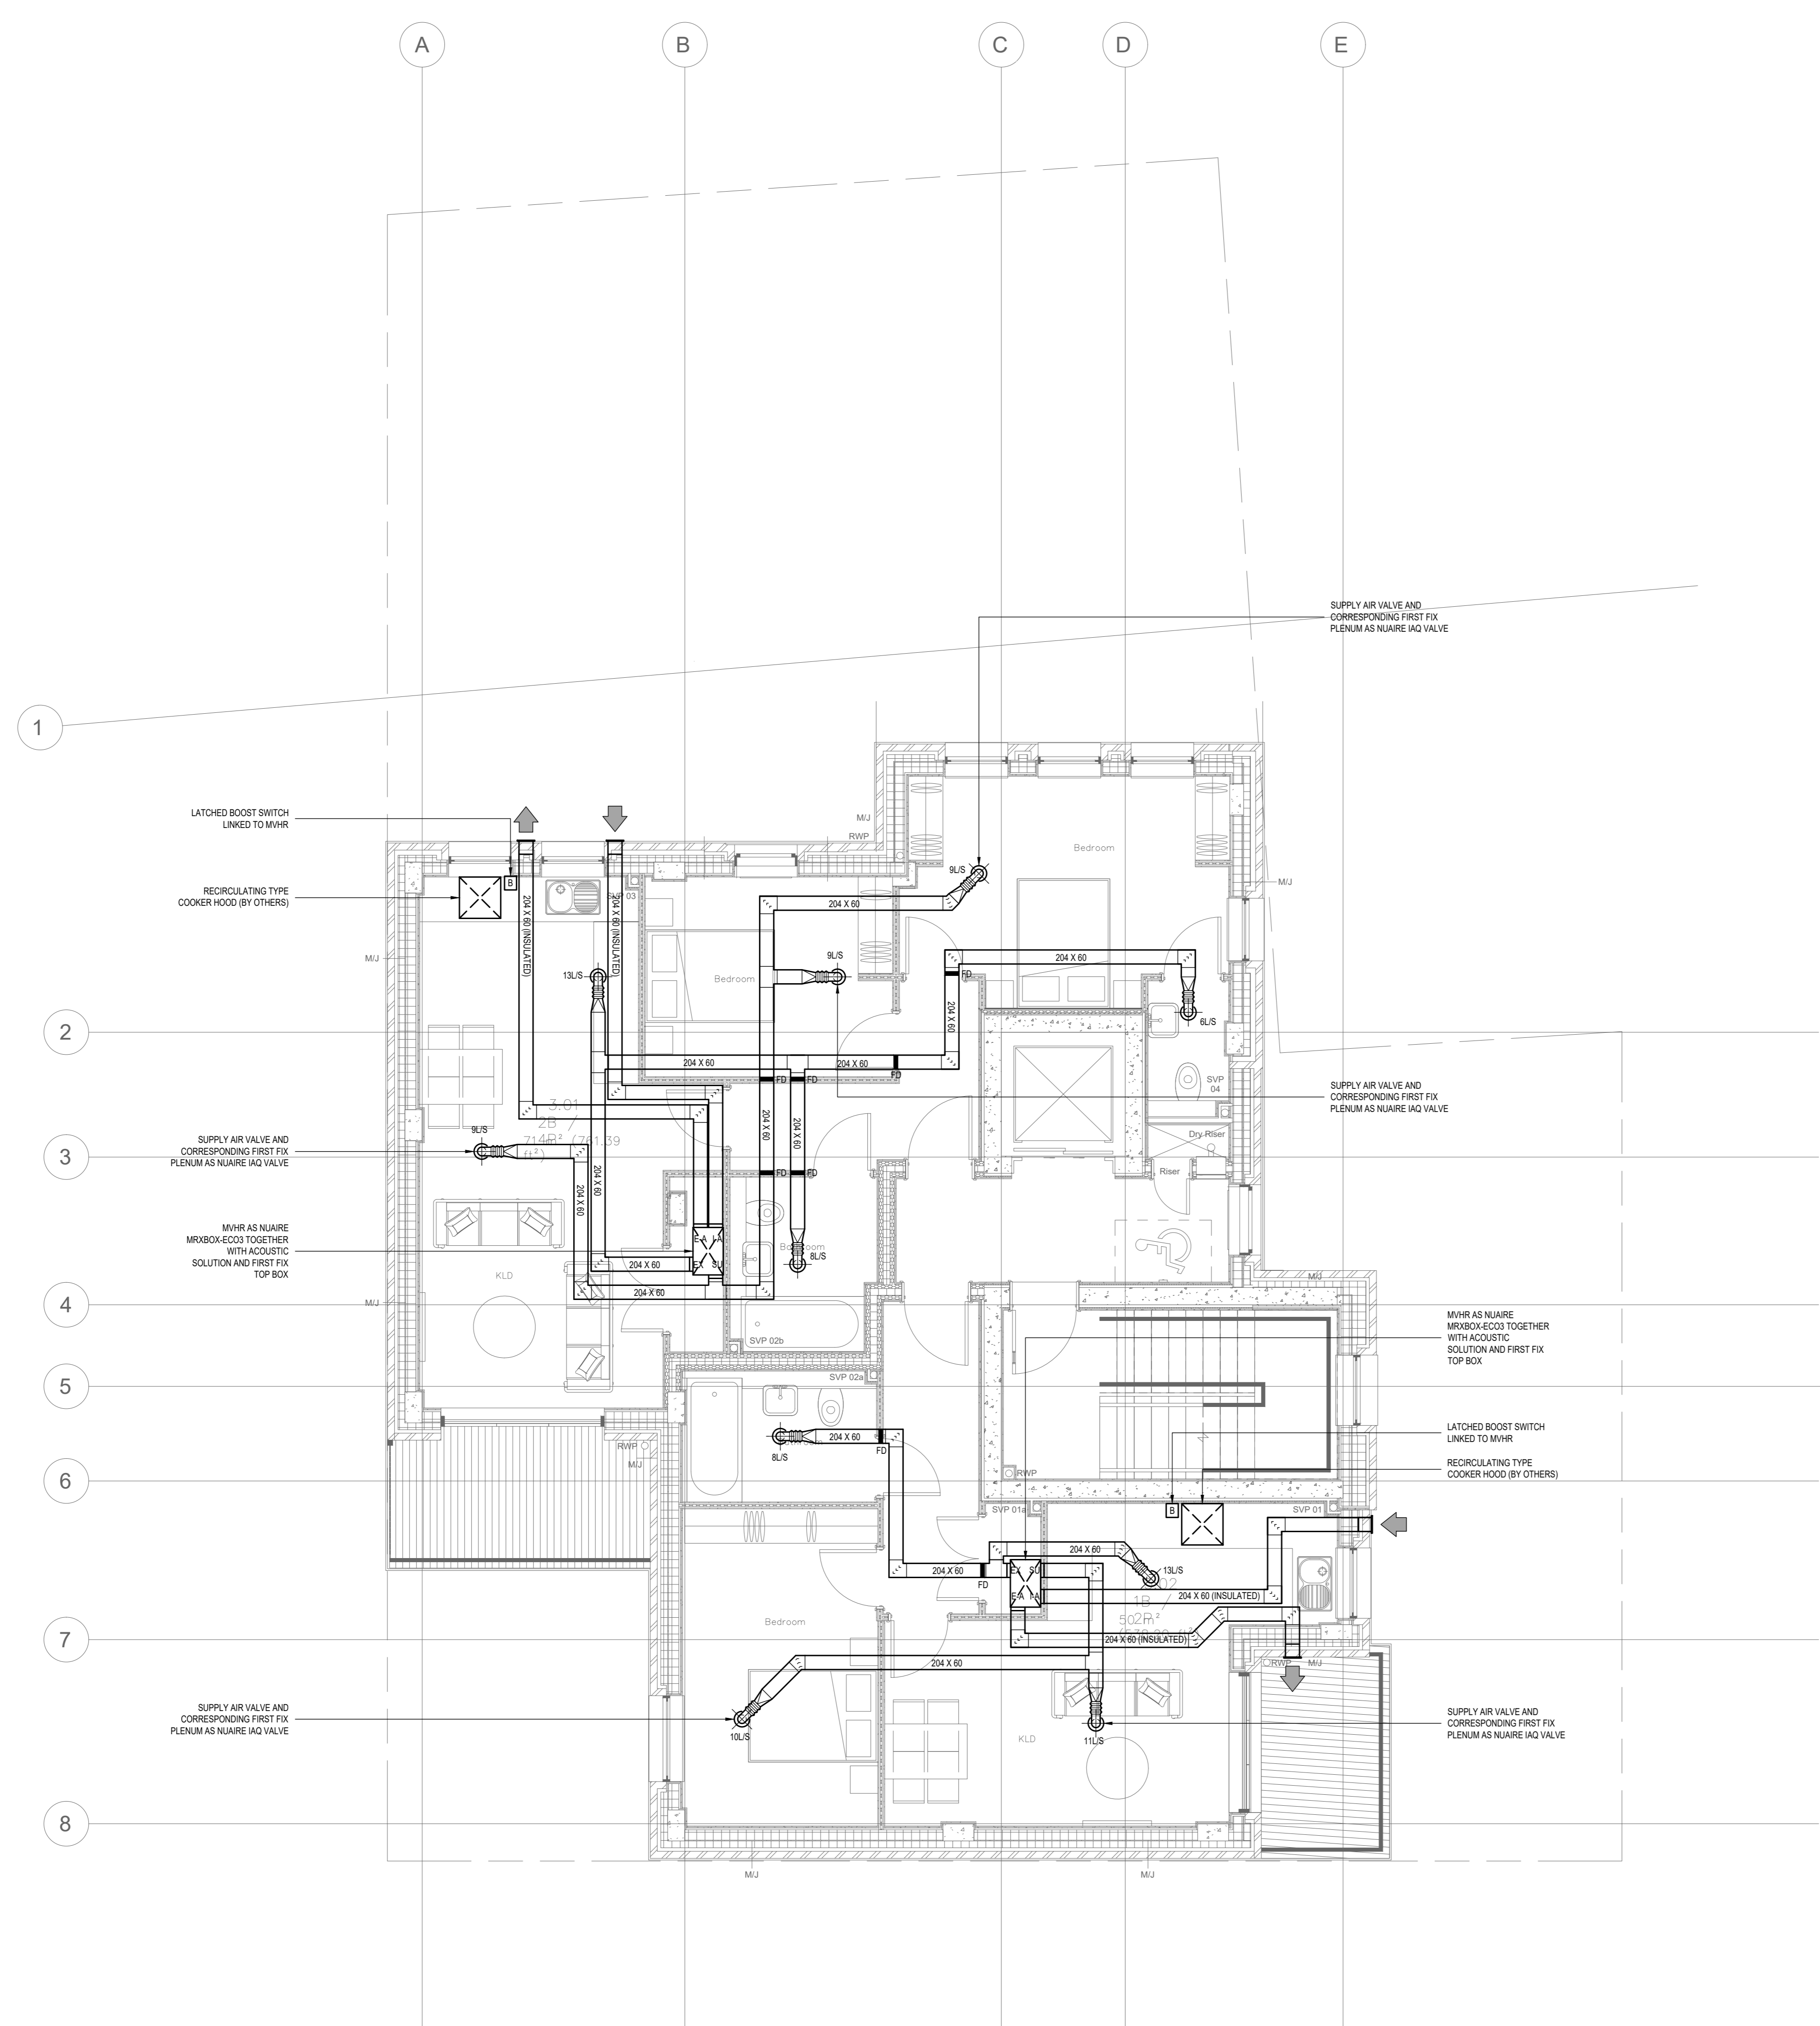

No.	Description	Origin	Drawn	Check	Date
T2	TENDER ISSUE	J.I.	J.I.	J.I.	31/05/24
T1	TENDER ISSUE	J.I.	J.I.	J.I.	09/02/24

Revisions:

Checked by	Date
A - Approved	
B - Approved with comments	
C - Revised with comments & re-submit	
D - Do not use	



Drawing Status:
TENDER ISSUE

Client:
KK4 LTD

Project Title:
**BIRD IN HAND
 WEST END LANE
 NW6 4NX**

Drawing Title:
**VENTILATION LAYOUT
 THIRD FLOOR**

Scale @ A0	Originator	Drawn by	Checked
1:50	J.I.	J.I.	J.I.
Project No:	IP23040		Date: JAN 24
Drawing No:	IP23040-L-M-214		Revision: T2

DO NOT SCALE FROM THIS DRAWING
 ALL DIMENSIONS TO BE CONFIRMED ON SITE