



















1 Woburn Place,  
Bloomsbury, London,  
WC1H 0LQ

KEY	
FIRE SYSTEM (refer to specialist drawings)	
	6100 Fire Alarm Panel
	Disabled Alarm Panel
	CAP Assist Pull Cord
	Disabled Alarm Reset
	Heat Detector
	Optical Smoke Detector C/W Sounder/Beacon
	Ionisation Smoke Detector
	Ionisation Smoke Detector With Integral Sounder
	Heat Detector With Integral Sounder
	8 Watt Surface Mounted Chrome Decorative Non-Maintained 3 Hour Emergency Luminaire C/W Exit Legend, To Bs 549
	Break Glass Call Point
	Surface Mounted Bulkhead Emergency Light Fitting
	Ceiling Mounted LED Emergency Light Fitting
	Emergency Light Fitting Integrated into Track Lighting
	PIR Control Of All Back Of House Areas And WCs



1 PROPOSED GROUND FLOOR PLAN  
Scale: 1:100

Notes	
	The area where licensable activities will take place
	Site Boundary
	CO2 and FOAM Extinguishers

The location and type of any fire safety and any other safety equipment is shown as at present. This may be varied from time to time with the agreement of the Fire Officer or after a fire risk assessment.  
Anything shown on this plan which is not required by the Plan Regulations is for illustrative purposes only, and does not form part of the Premises Licence

Project Farmer J - Bloomsbury			
Drawing Proposed Ground Floor Plan Licensing			
Job Number 23035	Drawing Number 21000	Rev P1	
Drawn AL	Date 08/05/2024	Status INFO.	Scale @ A3 1:100


















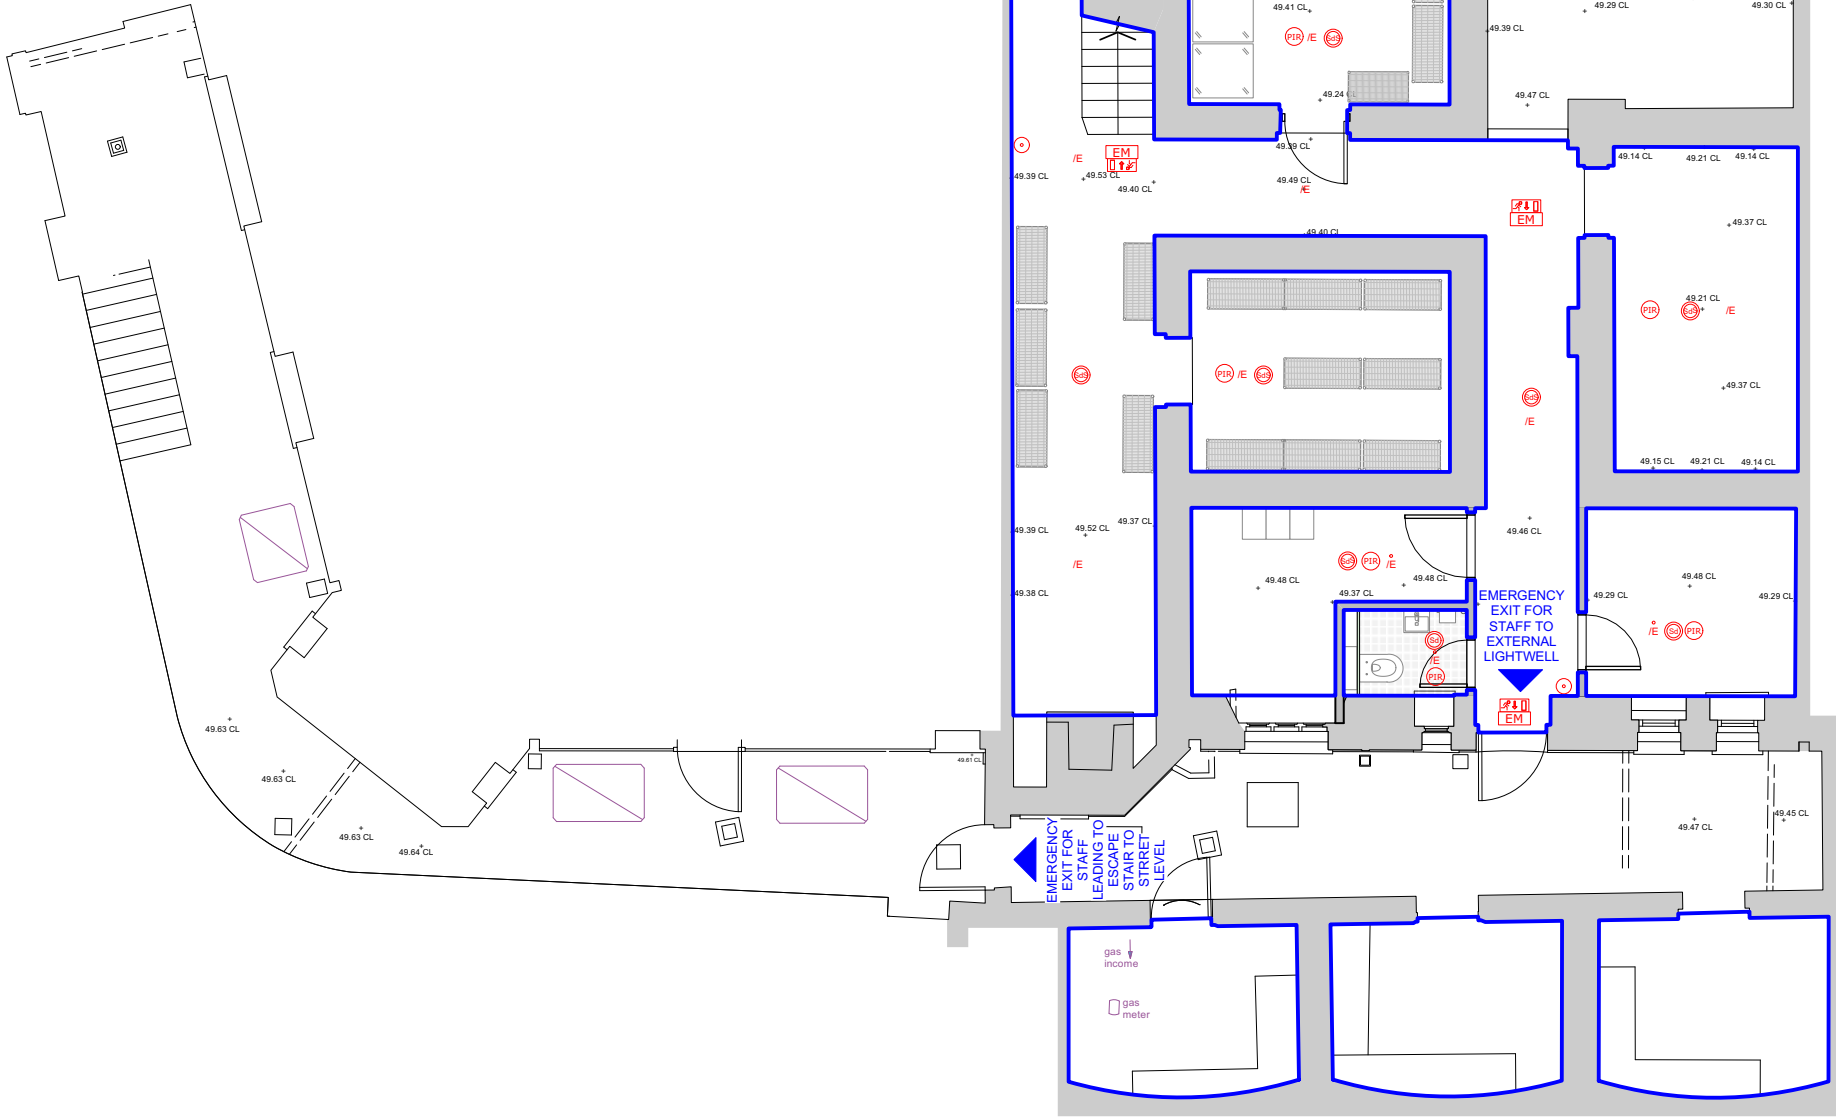
Client

**Holland Harvey Architects**  
Unit 1.4  
1-5 Vyner Street  
London E2 9DG  
hello@hollandharvey.com  
+44 203 327 0340

Farmer J




1 Woburn Place,  
Bloomsbury, London,  
WC1H 0LQ

KEY	
FIRE SYSTEM (refer to specialist drawings)	
	6100 Fire Alarm Panel
	Disabled Alarm Panel
	CAP Assist Pull Cord
	Disabled Alarm Reset
	Heat Detector
	Optical Smoke Detector C/W Sounder/Beacon
	Ionisation Smoke Detector
	Ionisation Smoke Detector With Integral Sounder
	Heat Detector With Integral Sounder
	8 Watt Surface Mounted Chrome Decorative Non-Maintained 3 Hour Emergency Luminaire C/W Exit Legend, To Bs 549
	Break Glass Call Point
	Surface Mounted Bulkhead Emergency Light Fitting
	Ceiling Mounted LED Emergency Light Fitting
	Emergency Light Fitting Integrated into Track Lighting
	PIR Control Of All Back Of House Areas And WCs



2

**PROPOSED GROUND FLOOR PLAN**  
Scale: 1:100

Notes		The area where licensable activities will take place
		Site Boundary
		CO2 and FOAM Extinguishers

The location and type of any fire safety and any other safety equipment is shown as at present. This may be varied from time to time with the agreement of the Fire Officer or after a fire risk assessment.  
Anything shown on this plan which is not required by the Plan Regulations is for illustrative purposes only, and does not form part of the Premises Licence

© Copyright Holland Harvey Architects 2022

P1	08/05/2024	ISSUED FOR LICENSING
REV	DATE	DESCRIPTION

AS	AB
BY	CHK

Project Farmer J - Bloomsbury			
Drawing Proposed Basement Plan Licensing			
Job Number 23035	Drawing Number 21001		Rev P1
Drawn AL	Date 08/05/2024	Status INFO.	Scale @ A3 1:100



**Holland Harvey** Architects  
Unit 1.4  
1-5 Vyner Street  
London E2 9DG  
hello@hollandharvey.com  
+44 203 327 0340

Client

Farmer J