



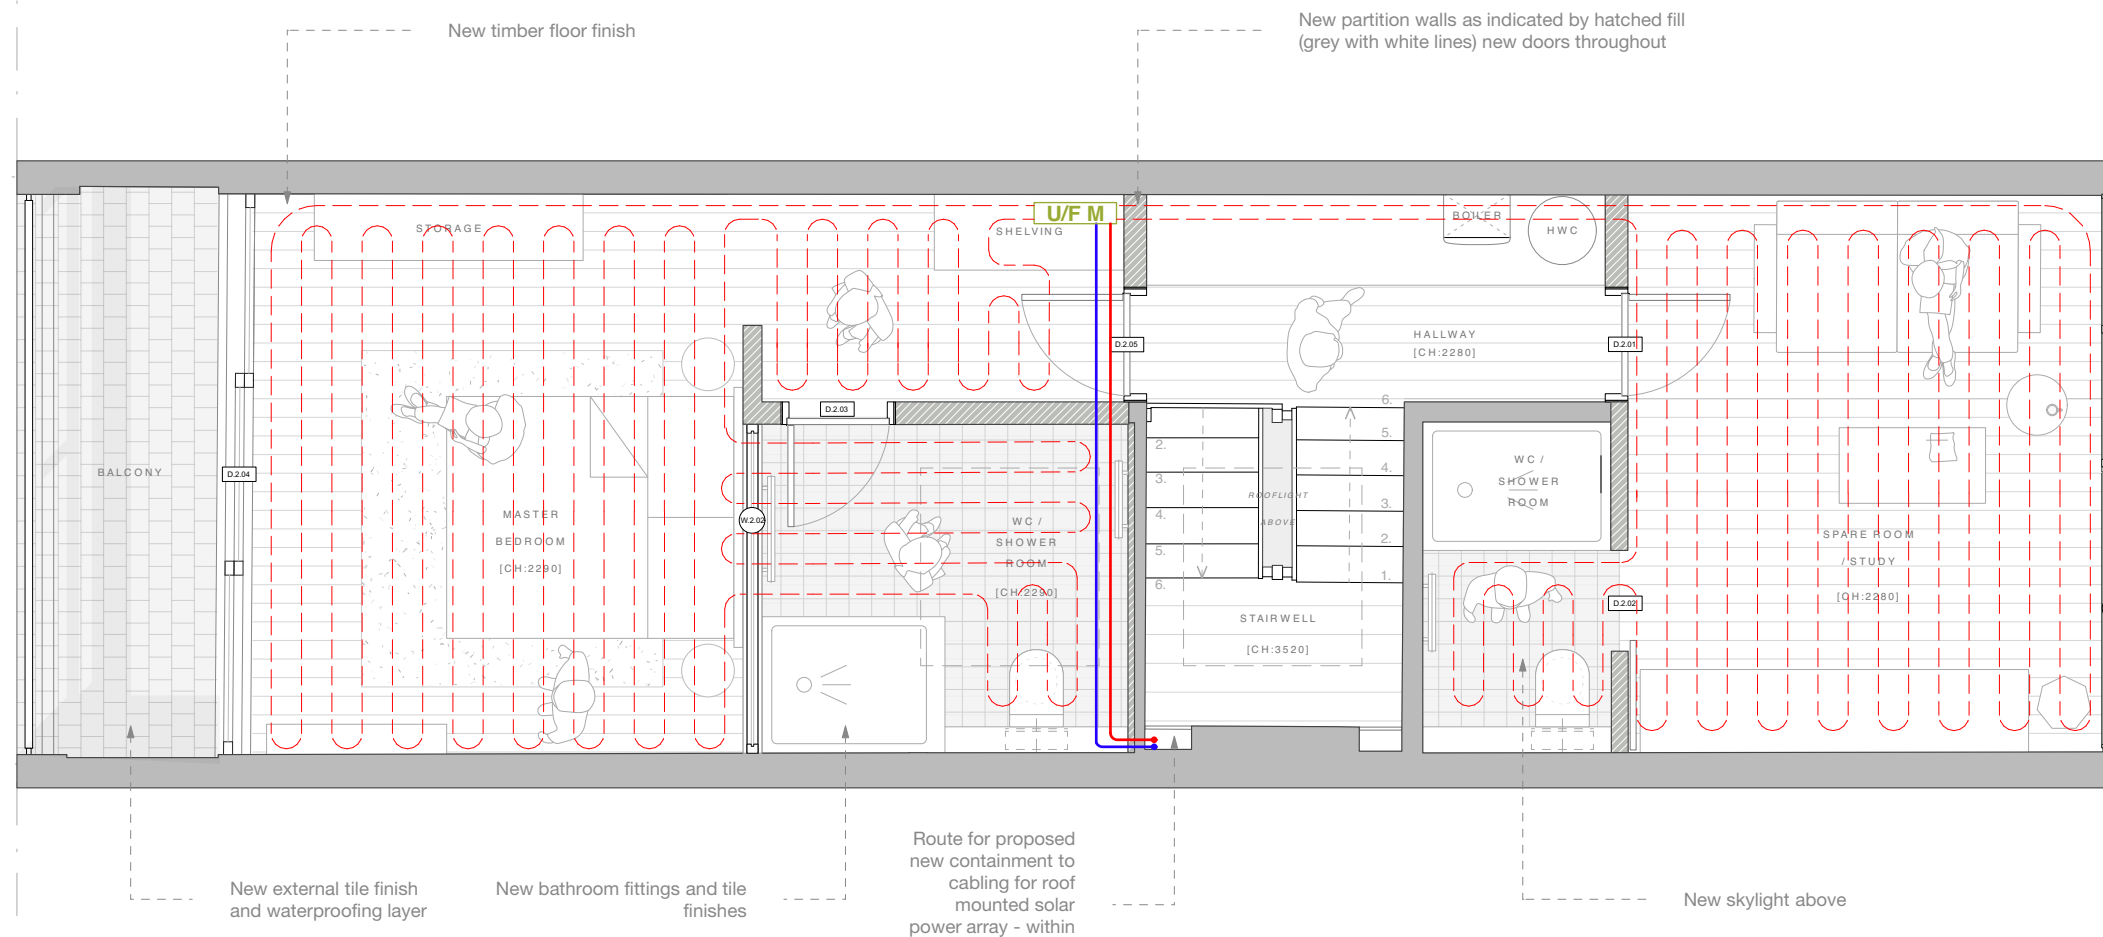

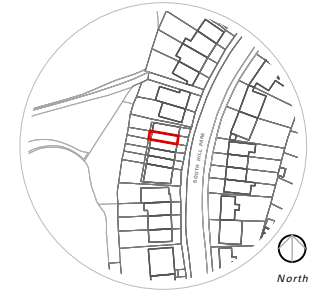


PRELIMINARY INFORMATION

This drawing has been produced for N Knight for architectural services alone and is not intended for use by any other person or for any other purpose. Drawings remain copyright of Well St Studio and may not be reproduced without written consent or licence. All drawings to be read in conjunction with relevant details, specifications and schedule information. WSS assume no responsibility for survey dimensional accuracy and corresponding site dimensions. This Drawing is not for construction. Contractor to check all dimensions on site, report any discrepancies immediately and prior to commencement of setting or any out execution of relevant works. Do not scale from drawings.




- Heating & Mechanical Plan Key:**
-  Water Fed Under Floor Heating
  -  Mains Hot / Cold Water
  -  Underfloor Heating Manifold
  -  Electrical Underfloor Heating
  -  Powered Extract Fan & Ducting

Second Floor Plan  
As Proposed 1:50  
UFH Layout

**Well St Studio**  
Architecture & Design

238b, Well St  
London E9 6QT  
  
+44 (0)208 432 9521  
contact@wellststudio.co.uk  
wellststudio.co.uk

Revision History		
Rev	Date	Description

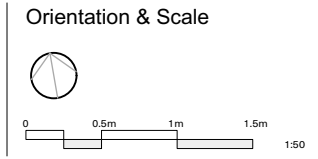

Project	88 South Hill Park - NW3 2SN
Drawing Title	Second Floor Plan - As Proposed - Underfloor Heating Planning Layout
Drawing No.	23_SHPII_A_P_20.02.01

Drawn by	RG
Date	16.06.23
Scale	1:50 @ A3