
 


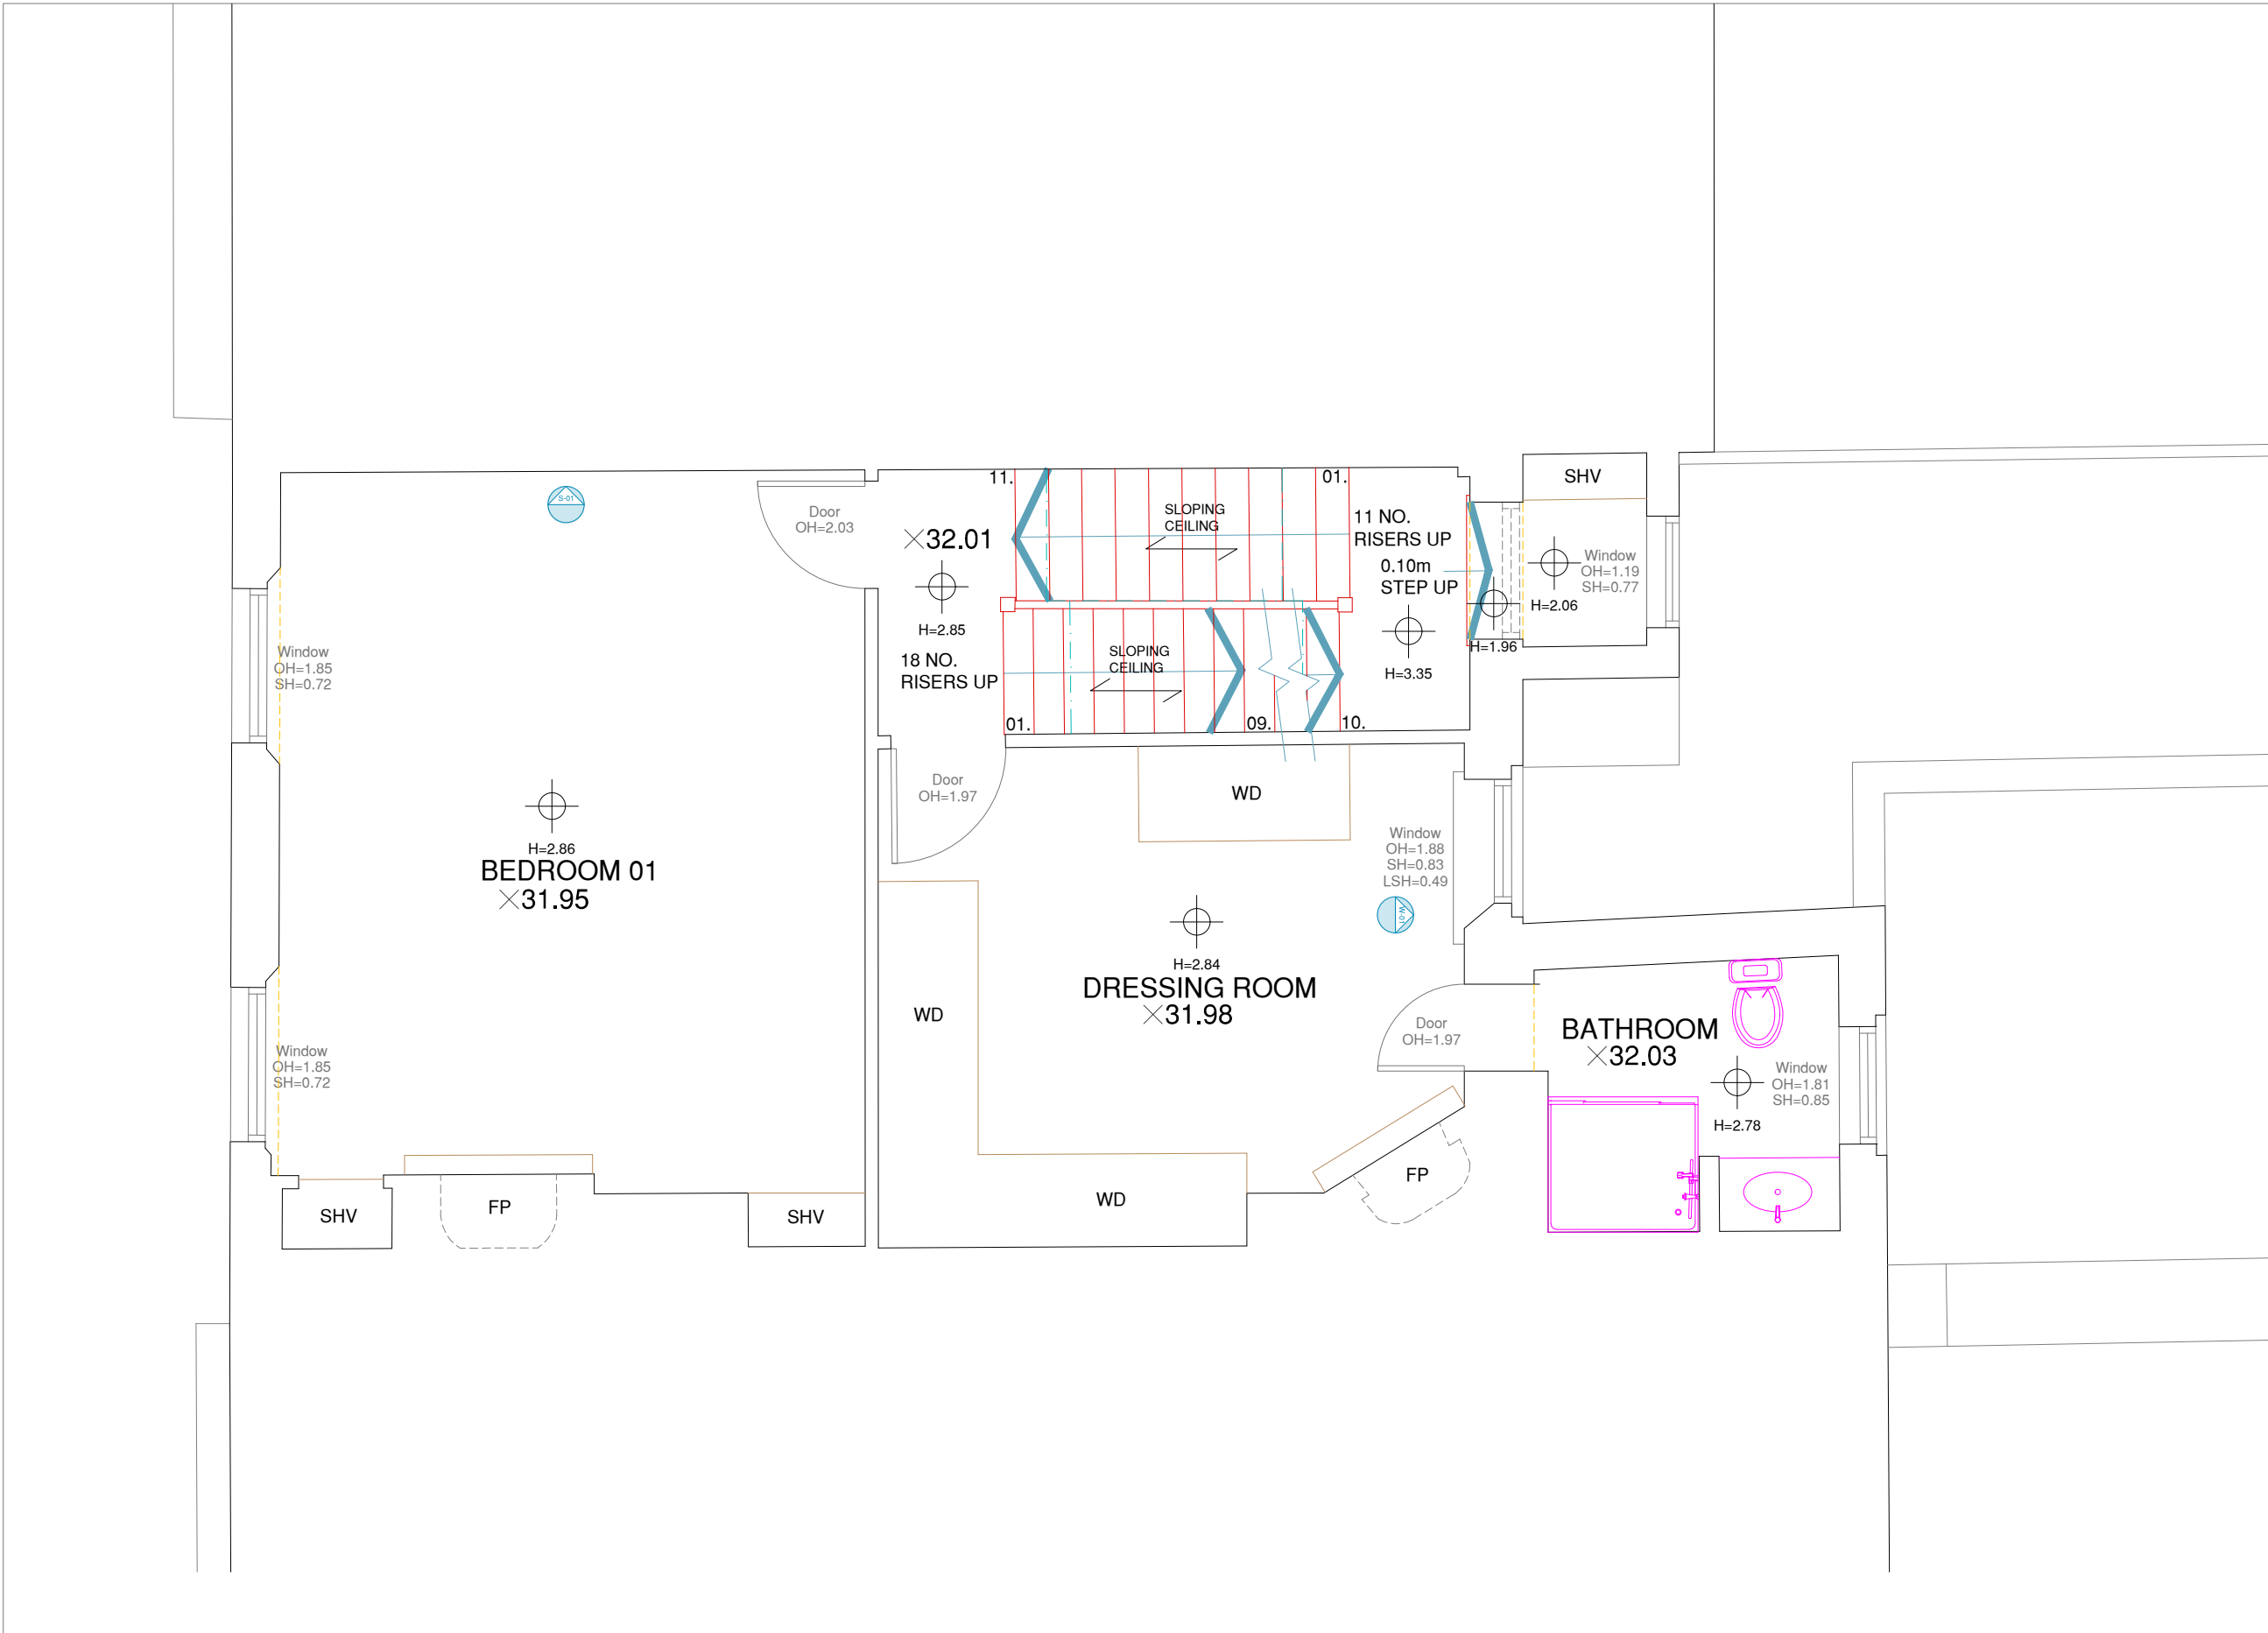

SECOND FLOOR PLAN

1:50 Scale



THIS DRAWING IS TO BE READ IN CONJUNCTION WITH ALL RELEVANT SPECIFICATIONS AND DRAWINGS ISSUED. FOR DISCREPANCIES OR OMISSIONS CONTACT MOBILE CAD SURVEYING SOLUTIONS LTD PRIOR TO WORK COMMENCING. THE CONTRACTOR IS TO CHECK AND VERIFY ALL BUILDING AND SITE DIMENSIONS AND LEVELS BEFORE WORK COMMENCES.

© COPYRIGHT MOBILE CAD SURVEYING SOLUTIONS LTD 2024

DO NOT SCALE THIS DRAWING - CHECK ALL DIMENSIONS ON SITE

Note:
Areas drawn indicatively noted and indicated by grey dashed line as line below

LEVEL DATUM & ORIENTATION

GEOGRAPHICAL ORIENTATION & NORTH POINT SHOWN ARE INDICATIVE ONLY.

ARBITRARY LEVELS CO-ORDINATED TO LOCAL STATIONS POSITIONED ON SITE DURING SURVEY.

ABBREVIATIONS & LEGEND:	
LEVELS & HEIGHTS	SERVICES
CL - COVER LEVEL	BT - BRITISH TELECOMS
IL - INVERT LEVEL	CTV - CABLE TELEVISION
L - LEVEL	ER - EARTHING ROD
HT - HEIGHT	ES - ELECTRICAL SUPPLY
STN - SURVEY STATION	FI - FIRE HYDRANT
BM - BEAM	GS - GAS SUPPLY
CE - CEILING	PO - POST OFFICE TELEPHONE
JA - JOISTS	SV - STOP VALVE
RA - RAFTERS	TSSU - TRAFFIC LIGHT SIGNALS
E - EAVES	
F - FENCE	DRAINAGE
US - UNDERSIDE OF	DC - DRAINAGE CHANNEL
RL - RIDGE LINE	G - GULLY
FR - FLAT ROOF	IC - INSPECTION CHAMBER
HL - HP LINE	MH - MANHOLE
VL - VALLEY LINE	RE - RISING EYE
PW - PARAPET WALL	RWP - RAIN WATER PIPE
SL - SLAB	UTL - UNABLE TO LIFT
SF - SOFFIT	S-VP - SOIL & VENT PIPE
T - TREE	ST - STOP TAP
THR - THRESHOLD	WM - WATER METER
To - TOP OF	
W - WALL	TYPICAL DRAWING SYMBOLS
HH - HEAD HEIGHT	SPOT LEVEL
OH - OPENING HEIGHT	STN 01
SH - SILL HEIGHT	4325.03.251
	HT: 95.142
GENERAL NOTES	SURVEY STATION
AB - ADVERTISING BOARD	MANHOLE /
AC - AIR CONDITIONING UNIT	INSPECTION CHAMBER
AHU - AIR HANDLING UNIT	
AP - INTRUDER ALARM PANEL	
B - BOLLARD	
BA - BARRIER	
BE - BENCH	
BS - BUS STOP	
BLR - BOILER	
BIO - BOWING OUT	
CAN - CEILING ACCESS HATCH	
CHY - CHIMNEY	
CPD - CURB/DROP	
DB - DOG WASTE BIN	
DW - DWAP WALL	
DK - DROP KERB	
EDB - ELECTRICAL DISTRIBUTION BOARD	
EG - EXTRACT GRILLE	
EM - ELECTRIC METER	
FB - FUSE BOX	
FP - FIREPLACE	
FU - FLUE	
FAP - FIRE ALARM PANEL	
GR - GRASS	
GU - GUARDING	
GM - GAS METER	
HWC - HOT WATER CYLINDER	
LB - LITTER BIN	
LP - LAMP POST	
PC - PELICAN CROSSING	
PS - PAVING SLABS	
PL - PAVEMENT LIGHT	
PLT - PLANTING	
PB - POST BOX	
RD - RAILING	
RS - ROAD SIGN	
RFL - ROOF LIGHT	
SB - SPEED BUMP	
SG - SIGNAGE	
SN - STREET NAME SIGN	
SWR - SHOWER	
SHV - SHELTER	
TB - TELEPHONE BOX	
THR - THRESHOLD	
TL - TRAFFIC LIGHT	
TM - TICKET MACHINE	
TP - TELEGRAPH POLE	
VE - VEGETATION	
WA - WATER	
WD - WARDROBE	
WH - WATER HEATER	
ZC - ZEBRA CROSSING	

REV	DATE	AMENDMENTS
-----	------	------------

PROJECT: MEASURED BUILDING SURVEY
ADDRESS: 36 LAMBS CONDUIT STREET,
LONDON,
WC1N 3LD

DWG NO.: 4325 - 05
DWG TITLE: SECOND FLOOR PLAN
DWG DATE: JUNE 2024
DWG SIZE: 1:50 @ A3
DRAWN: BS
CHECKED: PC