


- KEY**
- Pendant Light
 - Recessed Spot Light (c80mm diameter)
 - Heat / Smoke Alarm (c150mm dia hard wired, surface fixed)
 - Flushmount Speaker (c250mm diameter)
 - Extractor Diffuser (c150mm diameter)
 - Ventilation louvre

Radiator Casing

Previously consented as per application Ref: 2019/4759/L & 2019/3867/P

Amendment to consented scheme

DISCLAIMER: Drawings provided for information only. Corstorphine & Wright Architects accepts no responsibility for accuracy. Based on site survey by others.

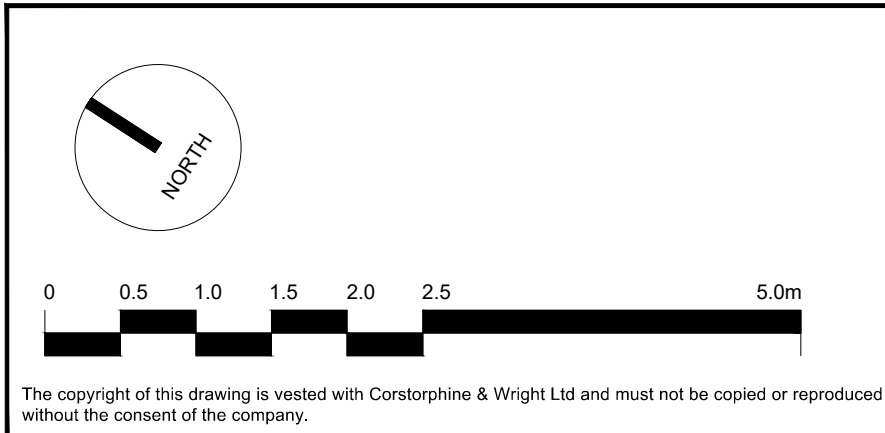

| | | | | |
|------|---------------------|----------|------|------|
| P01 | Issued for Planning | 30.01.24 | GB | HJ |
| Rev. | Description | Date | Drw. | Chk. |

Client
West Hill Projects

Project
16 Cleveland Street
WIT 4HX

Drawing Title
Proposed
Ground Floor Plan

Drawing Status
PLANNING

Corstorphine & Wright

London Studio
21-27 Lamb's Conduit Street, Holborn, London, WC1N 3NL
020 7642 0820
corstorphine-wright.com

| | | | | |
|---------------------------|---------------|------------------|---------------|------------------|
| Drawing No. 24067-1002 | | | | Revision P01 |
| Drawn GB | Checked HJ | Paper Size A1 | Scale 1:50 | Date 26.01.24 |