


- NOTES:
1. REFER TO WATKINS CAMDEN GOOD YARD INSTALLATION SPECIFICATION FOR QUALITY MEASURES TO BE INCORPORATED.
 2. DRAWINGS TO BE READ IN LINE WITH THE MTT SPECIFICATION AND STGNL QUALITY STANDARDS.
 3. FINAL LOCATION OF CAR PARK IMPULSE FANS AND EQUIPMENT SELECTIONS SHALL BE PROVIDED BY SPECIALIST CONTRACTOR.
 4. FOR DUCTWORK MATERIAL AND GENERAL INSTALLATION REQUIREMENTS, REFER TO THE MECHANICAL AND PUBLIC HEALTH TECHNICAL SUBMISSIONS.
 5. SPECIFICATION FOR DUCTS TO SERVE CHEMICAL STORE TO BE CONFIRMED BY POOL PLANT SPECIALIST.
 6. ALL MEASUREMENTS SHOULD BE TAKEN FROM FFL TO BOTTOM OF PIPE/DUCT. DATUM FOR FFL IS TO BE PROVIDED BY OTHERS.

For Continuation See Drg No. CGY0B-WAT-0B-B1-DR-M-02008

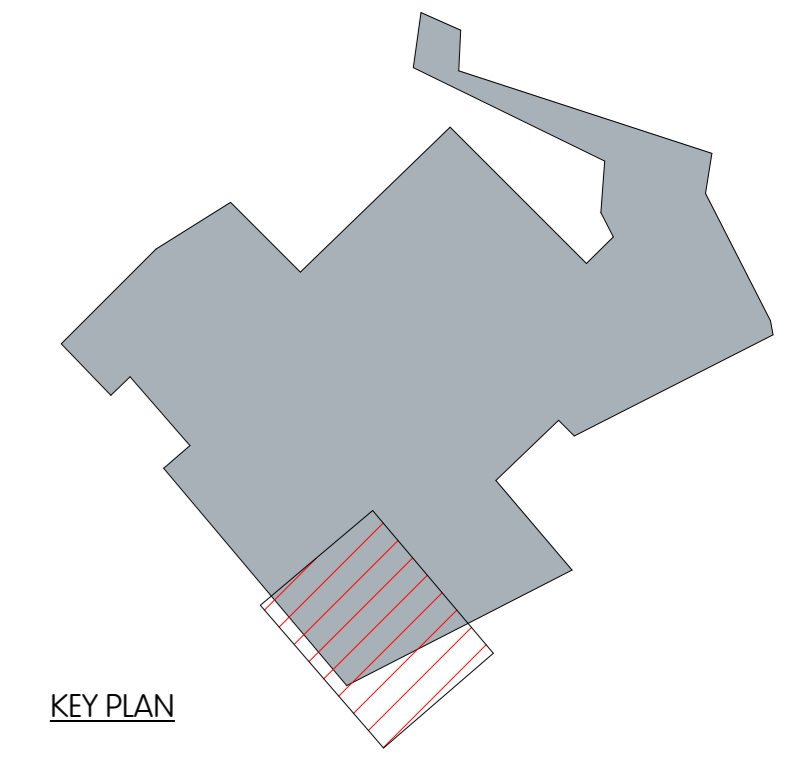

watkins Integrated Mechanical, Electrical & Plumbing Services

Watkins House, Leigh Road
 White Business Park,
 Ramsgate, Kent, CT12 5EU
 TEL : 01843 852 277
 info@watkins.co.uk, watkins.co.uk

CONSTRUCTION DRAWING

For Continuation See Drg No. CGY0B-WAT-0B-B1-DR-M-02011

REVISIONS	CLIENT	CONSULTING ENGINEER	CONTRACT	DRAWING TITLE	DATE	DRAWN-DESIGNER
R1 10.05.2024 ISSUED FOR APPROVAL R2 20.06.2024 ISSUED FOR CONSTRUCTION	ST GEORGE - BERKELEY GROUP LLP Berkeley House, 19 Portsmouth Road Cobham, Surrey KT11 1JG	MTT 9 Kingsway London WC2B 6XF	ST GEORGE, BERKELEY GROUP LLP Camden Goods Yard Stephenson Street, Camden NW1 8EH	MECHANICAL SERVICES BLOCK E - LEVEL B1 VENTILATION LAYOUT SHEET 1 OF 2	22.02.2024	MC
					SCALE 1:50 @ A0	APPROVER CW
					DRG No. CGY0B-WAT-0B-B1-DR-M-02010	Rev C1

COPYRIGHT ©
 This drawing is copyright and may not be altered, reproduced, copied, lent, borrowed or sold without the express permission of C Watkins Plumbing Ltd.

RELATED DOCUMENTS
 This drawing should be read with the appropriate Specification (S) and Schedule (S) and all other standard documentation.

WARNING
 Do Not Scale from this drawing. Verify all dimensions, levels and structural details on site.