



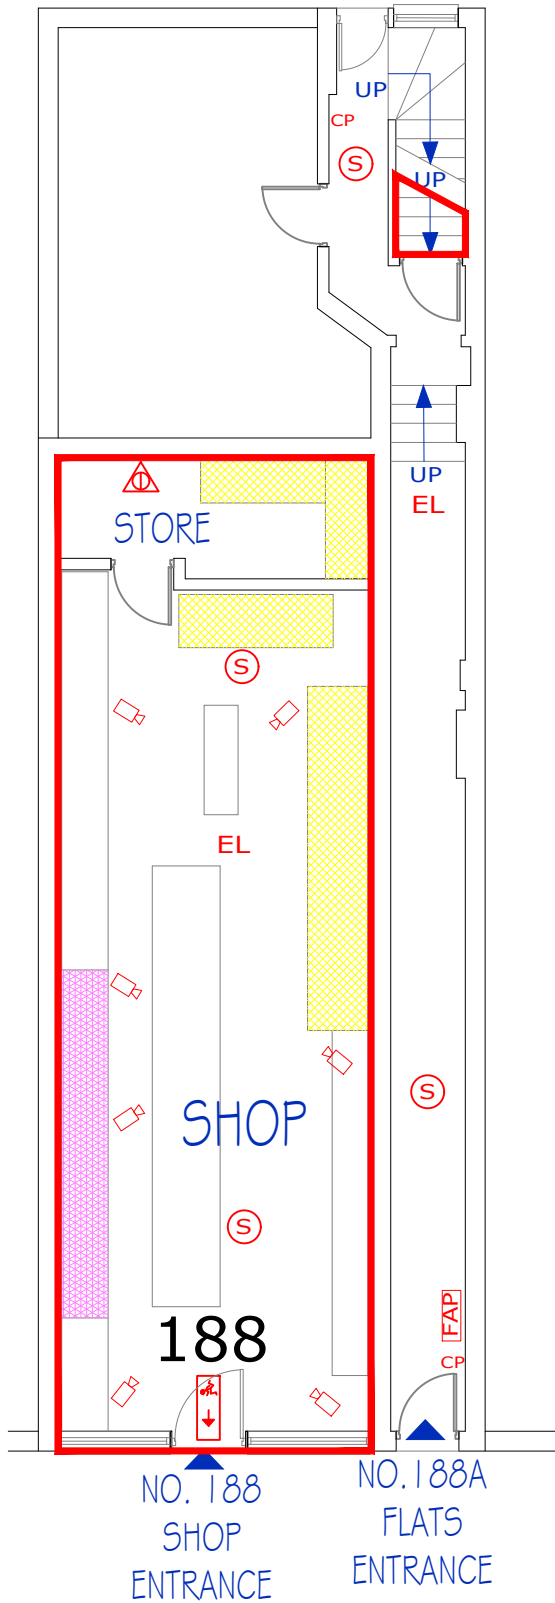

GROUND FLOOR PLAN
SCALE 1:100

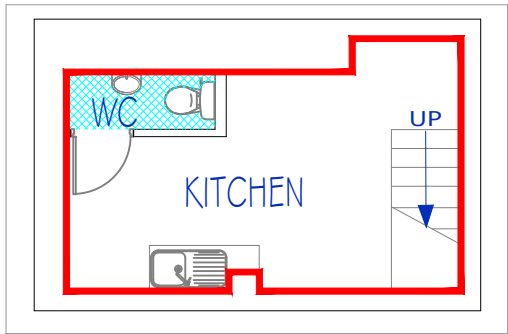

BASEMENT FLOOR PLAN
SCALE 1:100

KEY Description

	BIN STORAGE AREA
	FIRE ALARM PANEL
	FIRE DOOR
	FIRE ALARM CALL POINT
	EMERGENCY LIGHT
	FIRE ALARM SOUNDER
	SMOKE DETECTOR
	HEAT DETECTOR
	CCTV
	FIRE BLANKET
	FIRE EXTINGUISHER - CARBON DIOXIDE
	FIRE EXTINGUISHER - DRY POWDER
	FIRE EXTINGUISHER - FOAM
	FIRE EXIT
	GAS METER
	ELECTRIC METER
	CARBON MONOXIDE DETECTOR
	BOILER
	FIRE EXTINGUISHER - WATER
	WC AREA
	FRIDGES
	ALCOHOL STORE
	AMBIT OF LICENSED PREMISES