


- Notes:**
- Do not scale this drawing (printed or electronic version).
 - This drawing indicates design intent only and shall not be used as a working drawing or installation drawing. The Contractor shall be responsible for producing his own fully coordinated working drawings.
 - Contractor must check all dimensions on site prior to ordering materials or commencing work. Any discrepancies must be reported to the engineer immediately.
 - This drawing is copyright and is for use on this site only.
 - All structural & architectural elements, where indicated, have been inspected from the engineers drawings and reference should be made to the structural, structural architectural drawings for exact dimensions.
 - This drawing should be read in conjunction with all relevant conditions, specialist sub-conditions, supply chain drawings and specifications for exact setting out, size and type of component.
 - Discrepancies and/or ambiguities within this drawing, between it and information given elsewhere, must be reported immediately to Ingleton Wood for clarification before proceeding.
 - All works to be carried out in accordance with the latest British Standards/Codes of Practice/Building Regulations unless specifically directed otherwise in the specification.
 - Responsibility for the reproduction of this drawing in paper form, or if issued in electronic form, lies with the recipient to check that all information has been replicated in full and is correct when compared to the original paper or electronic image.
 - Graphical representations of equipment on this drawing have been indicated, but are representative only. Please refer to specifications and/or details for actual sizes and/or specific contractor construction information.
 - All builders work associated with the mechanical and electrical services installation must be included for.
 - Contractor to review site Asbestos register prior to commencing work.
 - All power and control wiring associated with the mechanical services installation must be included for.
 - The position of all equipment shown is indicative only. Final positions to be determined & indicated on working drawings.
 - Refer to mechanical drawings for extraction fan details.
 - Refer to mechanical drawings for position of outlets to mechanical plant.
 - Cable containment (if indicated) is shown as indicative only. Contractor to determine cable containment routes and sizes to suit the installation.

- Note:-**
- HVI conductor shall be painted to match the existing stone/brickwork.
 - Where HVI conductors are installed behind/adjacent RWP's these shall be coloured black.

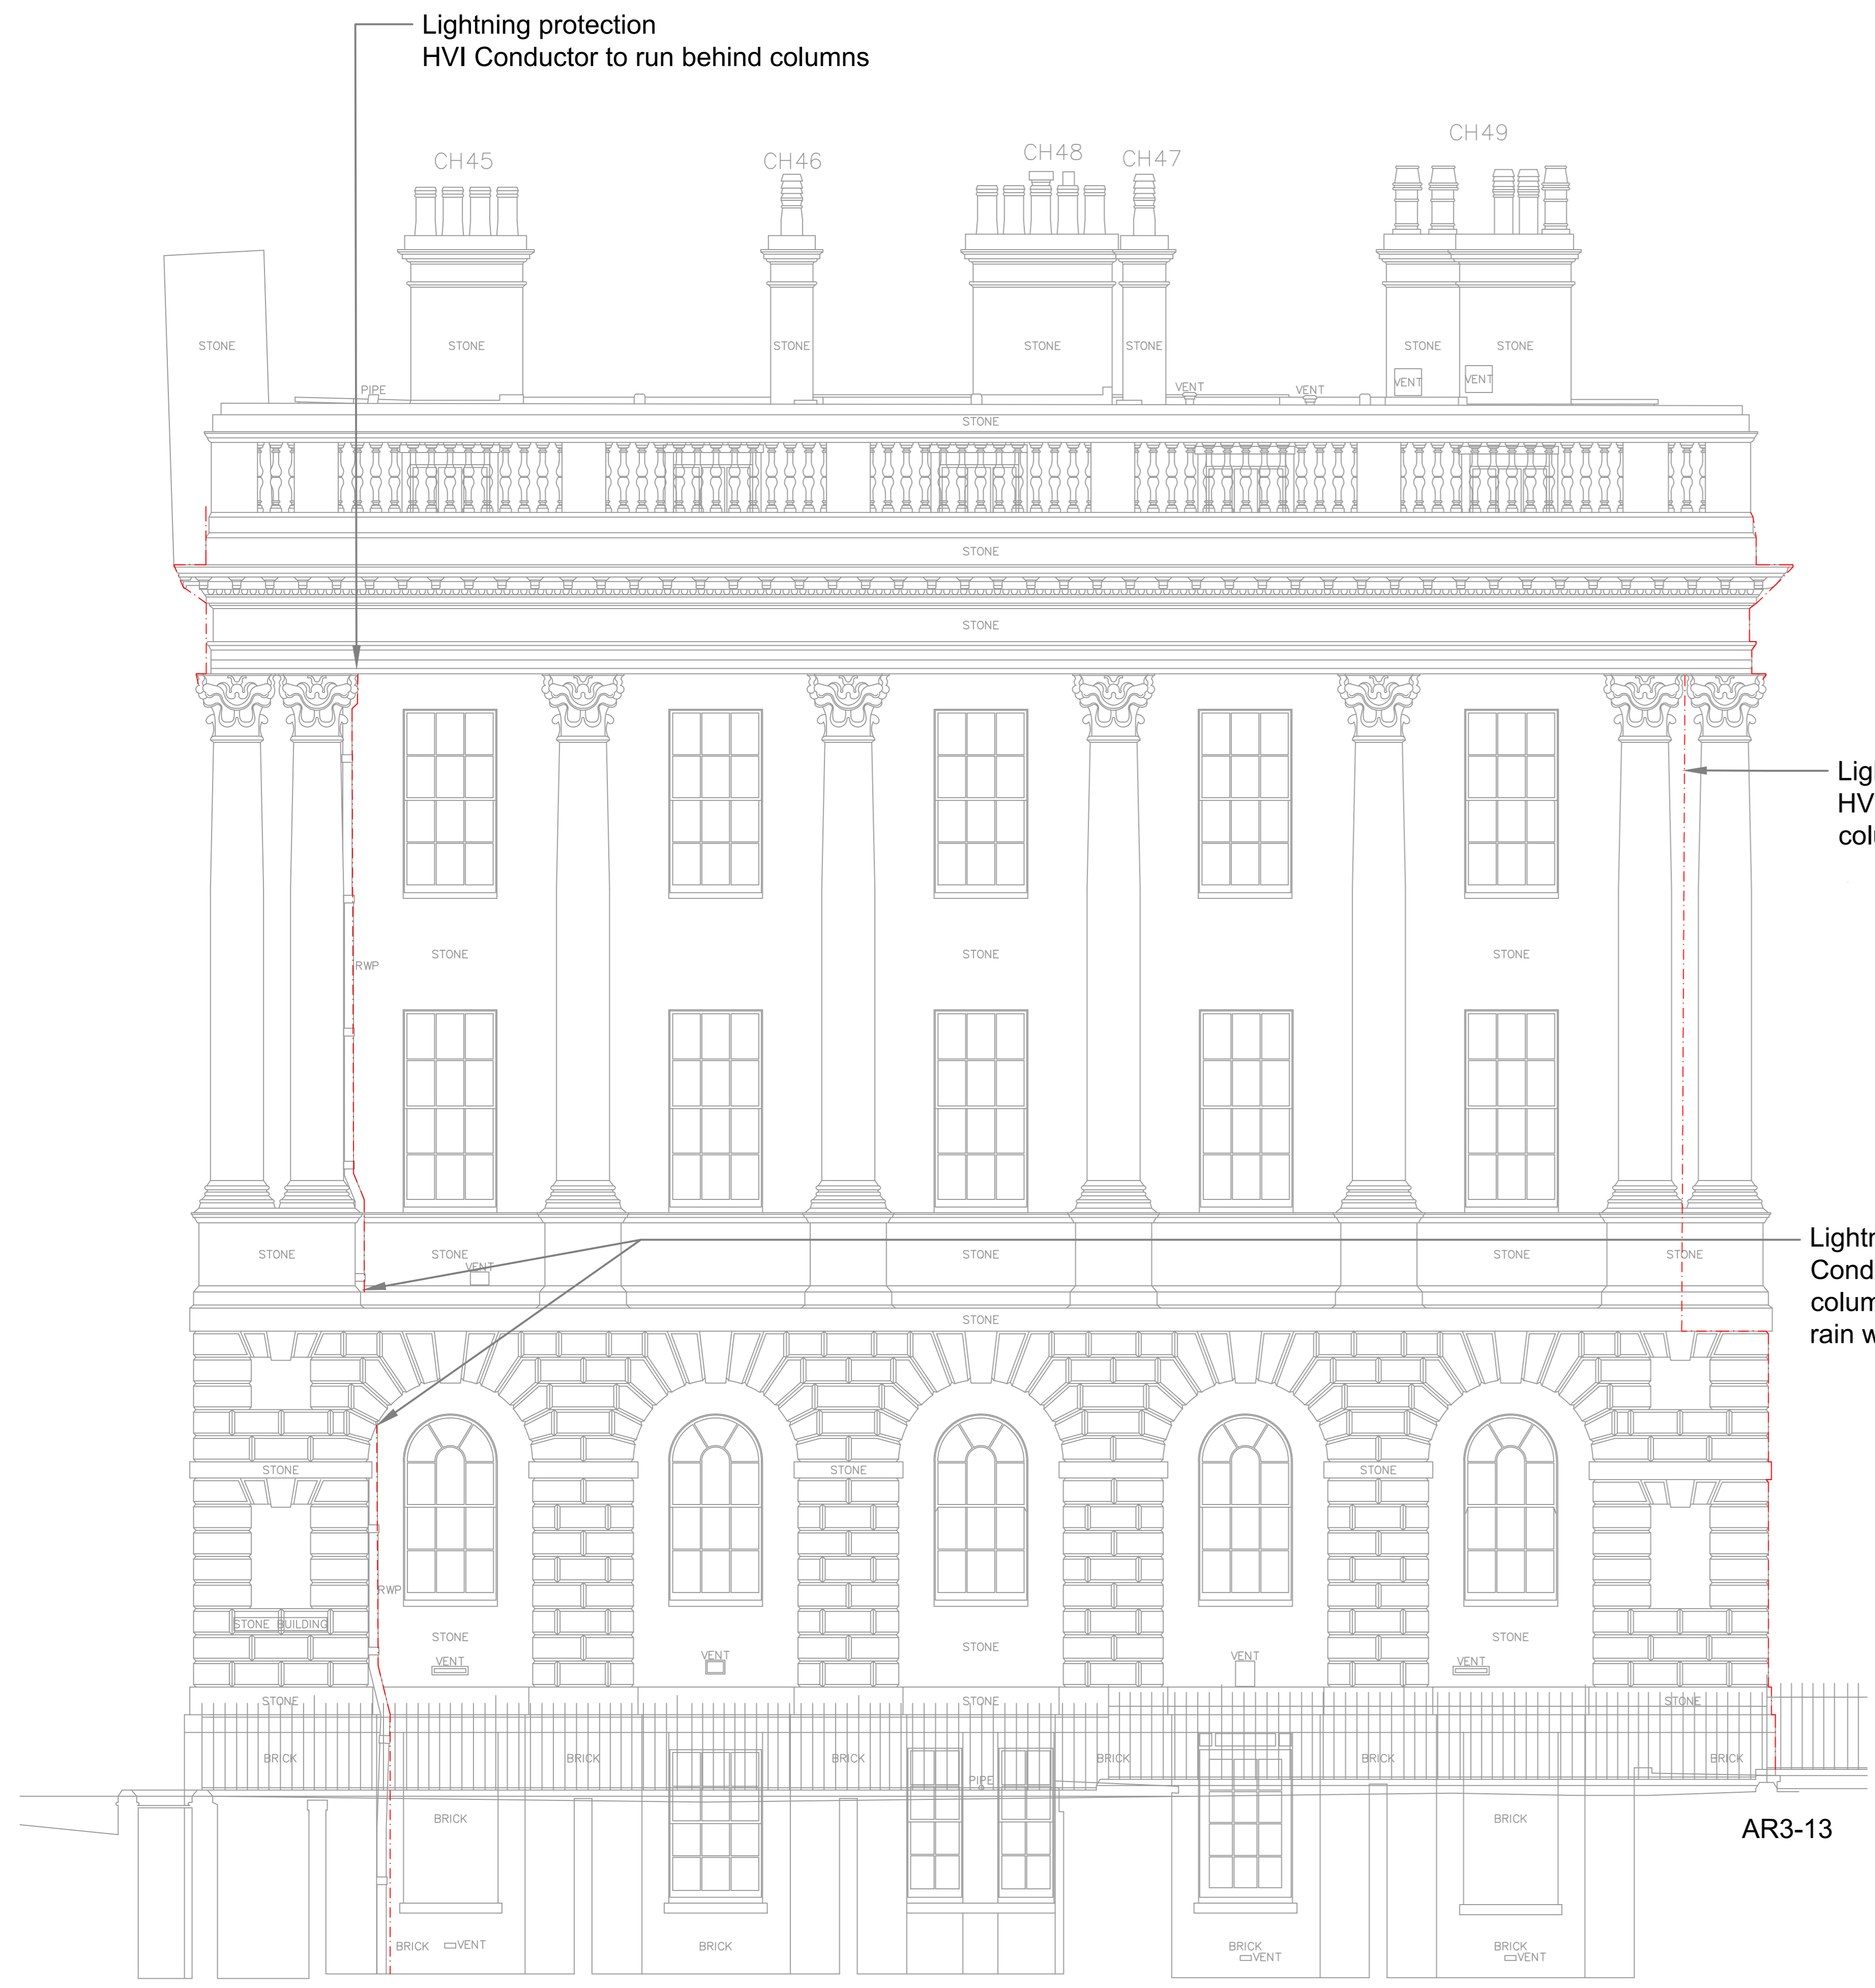

Lightning protection HVI Conductor to run behind columns

Lightning protection HVI Conductor to run behind columns and down rain water pipe

Legend:
 - - - - - Lightning protection HVI Conductor



DATUM=17.00m
ELEVATION 1

DATUM=17.00m
ELEVATION 6

PROJ	Scale Bar Added	01/02/2011	NH	PC
REV	Information Issue	11/05/2011	NH	PC
REV	Description	Date	Drawn By	Checked By
	502705	Scale @ A1: 1:50		JP

Ingleton Wood Property and Construction Consultants
 100, 102, 104, 998, 1000

Project: **HSLI Stone Building Lightning Protection System**
 Stone Buildings London WC2A 3TL
 Client: **Honourable Society of Lincoln's Inn**
 Title: **Lightning Protection Elevation 1 & 6**
 Drawing Number: **HSLIB-IWD-XX-XX-DR-E-6810**
 Status: **S2** Purpose of this drawing: **Information** Revision: **P02**