


NOTES

- THIS DRAWING IS FOR TENDER PURPOSES ONLY
ALL DIMENSIONS ARE TO BE VERIFIED ON SITE
PRIOR TO COMMENCEMENT OF WORKS
- THIS DRAWING TO BE READ IN CONJUNCTION WITH
ALL CURRENT m e design consultancy ltd DRAWINGS
AND ARCHITECTS CURRENT COORDINATED
CEILING LAYOUTS

- P1A-D INDOOR UNITS ARE HIGH LEVEL
FAN COIL UNITS WITH DUCTING TO
LINEAR SLOT DIFFUSERS
P1A - 1307 X 430 X 220H
P1B,C,D - 938 X 430 X 220H
- P1E UNIT IS FLOOR MOUNTED
P1E - 579 X 129 X 1135H
- P1F-H UNITS ARE WALL MOUNTED
PF,G,H,I - 845 X 180 X 275H
- P1D,H,J TEMPORARILY POSITIONED
IN CONSERVATORY UNTIL
THIRD FLOOR EXTENSION COMPLETE

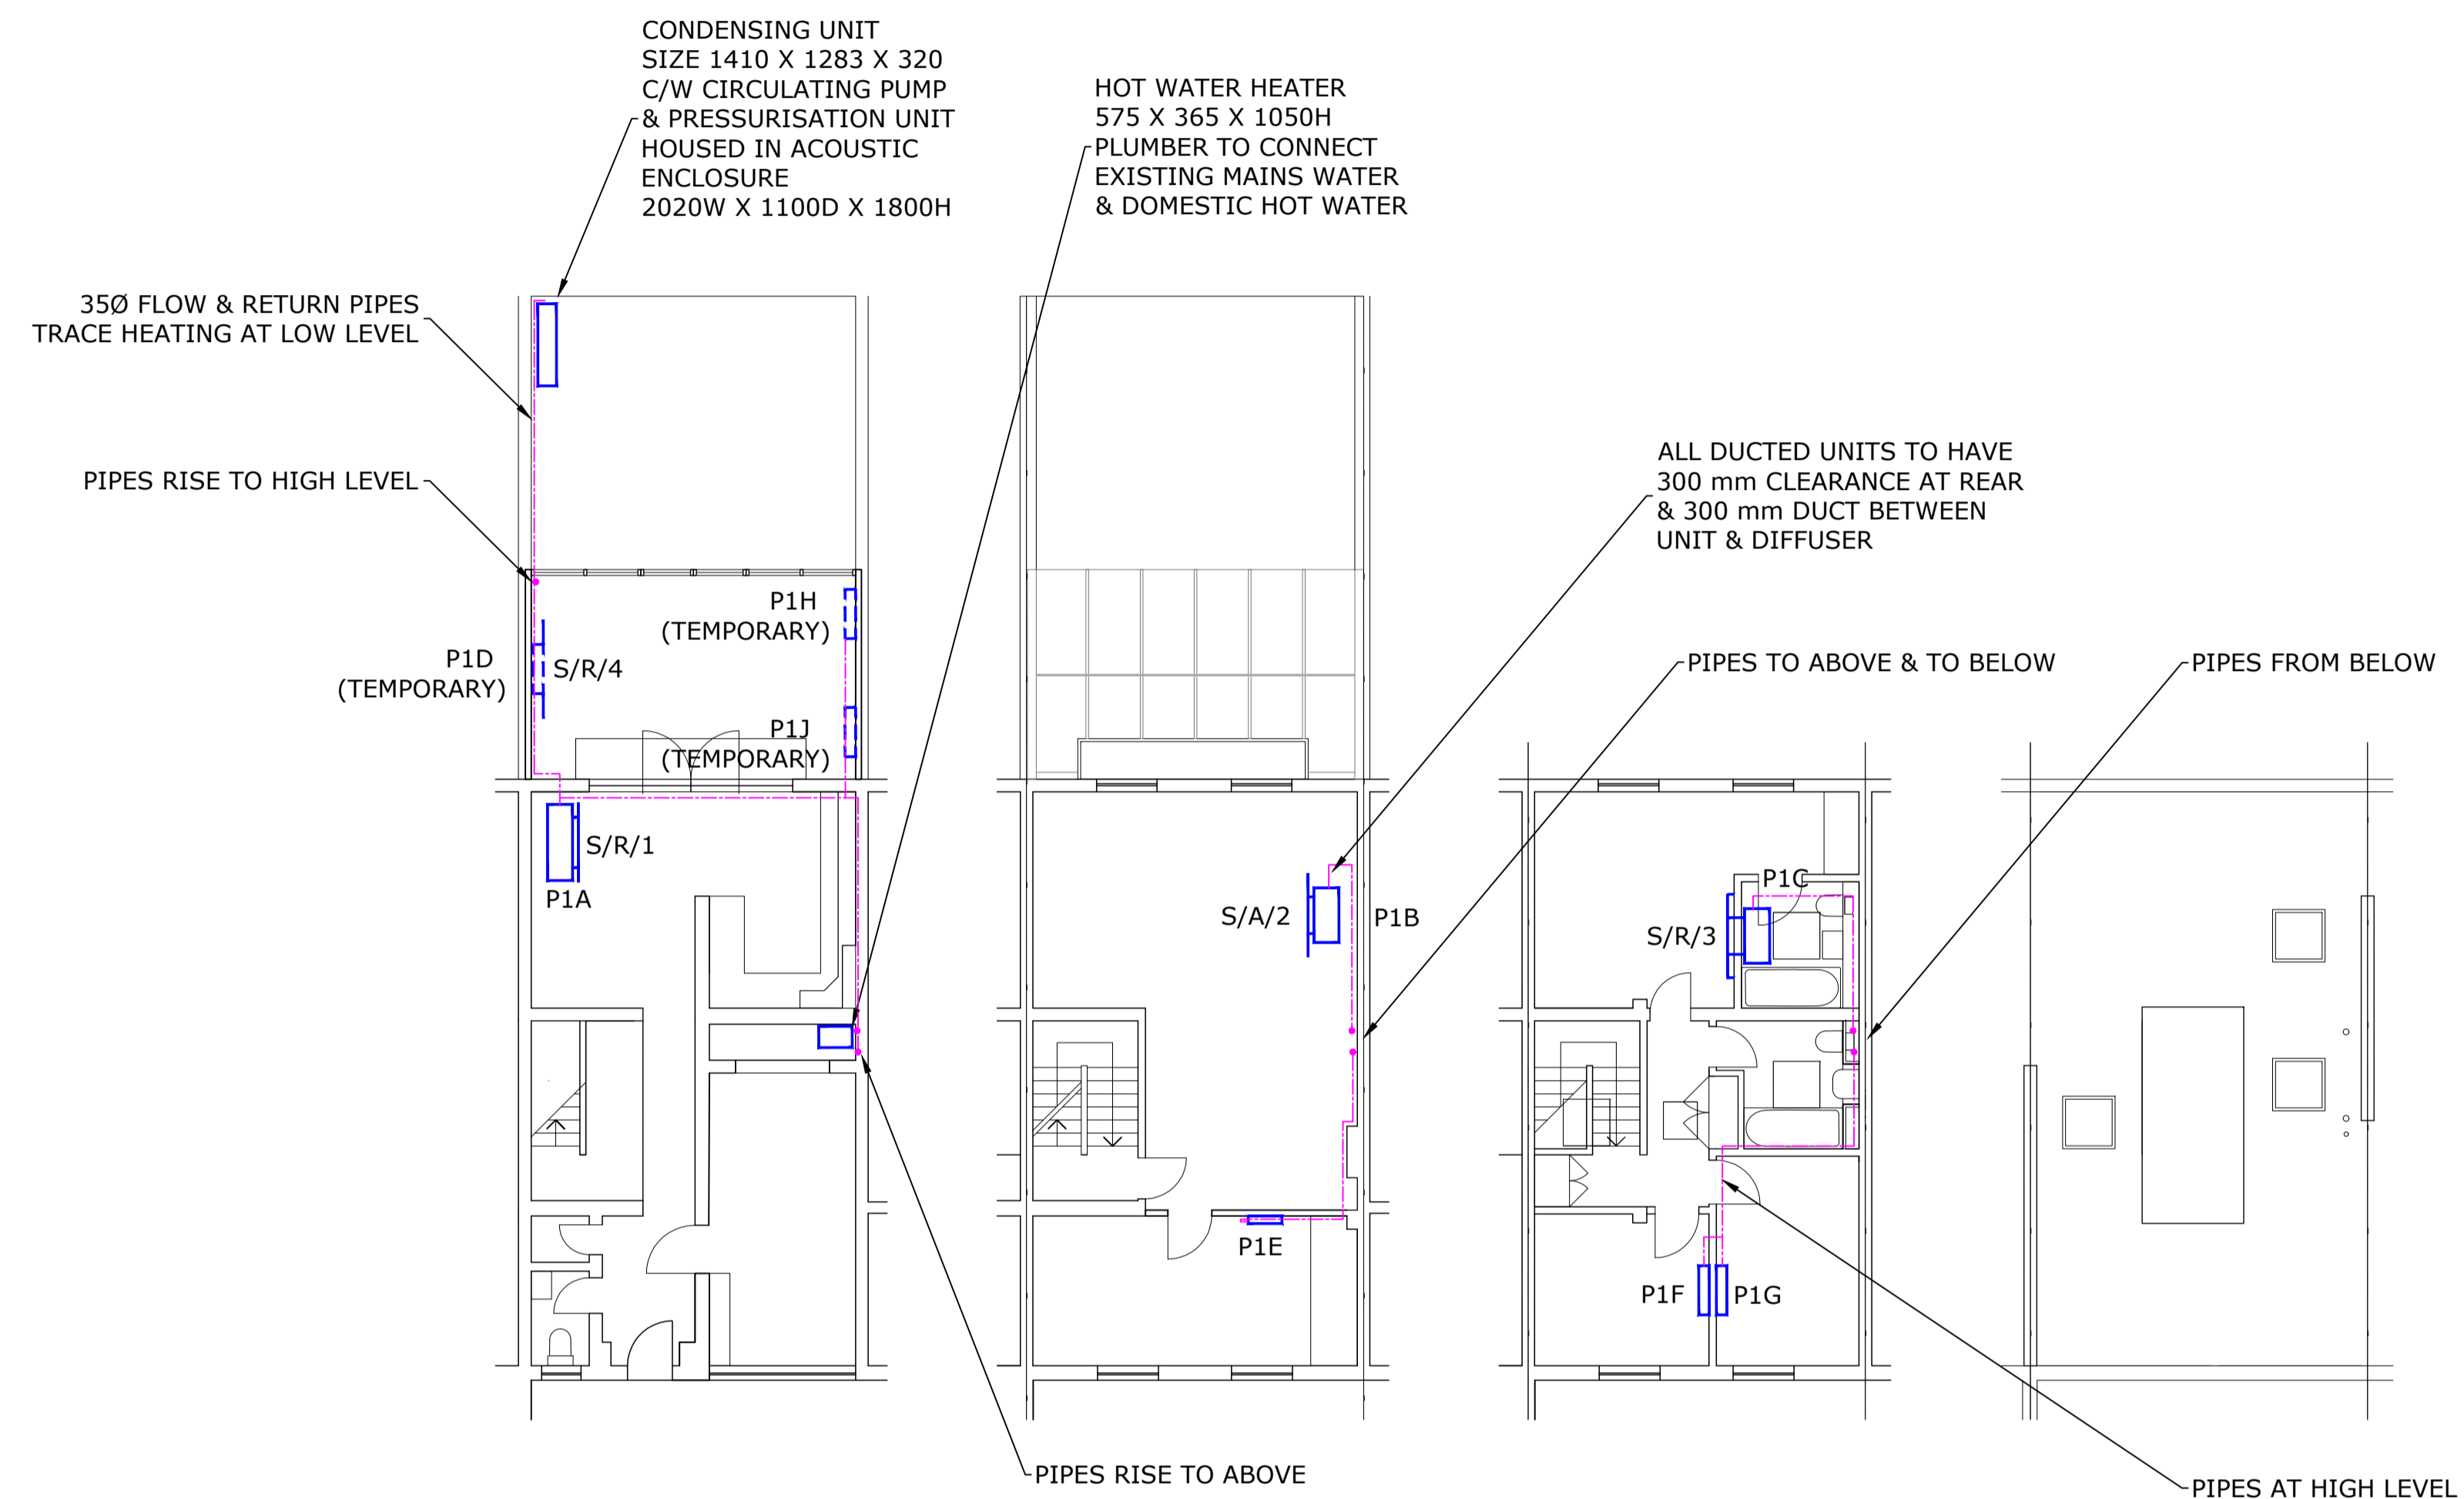

601 Indiana Building
Deals Gateway, Deptford Bridge
London SE13 7QD
t: +44 (0)203 723 8538
e: mail@medesignconsultancy.co.uk

CLIENT

NATHAN PIPER

PROJECT

6 BRIARY CLOSE
LONDON, NW3 3JZ

TITLE

PROPOSED
HVAC LAYOUT

rev	date	description	rev	date	description

SCALE 1:100 @A1

DATE 07/23

DRAWN P.O

m e design consultancy ltd

2308/M101