


NOTES

1. THIS DRAWING IS FOR TENDER PURPOSES ONLY
ALL DIMENSIONS ARE TO BE VERIFIED ON SITE
PRIOR TO COMMENCEMENT OF WORKS
2. THIS DRAWING TO BE READ IN CONJUNCTION WITH
ALL CURRENT m e design consultancy ltd DRAWINGS
AND ARCHITECTS CURRENT COORDINATED
CEILING LAYOUTS

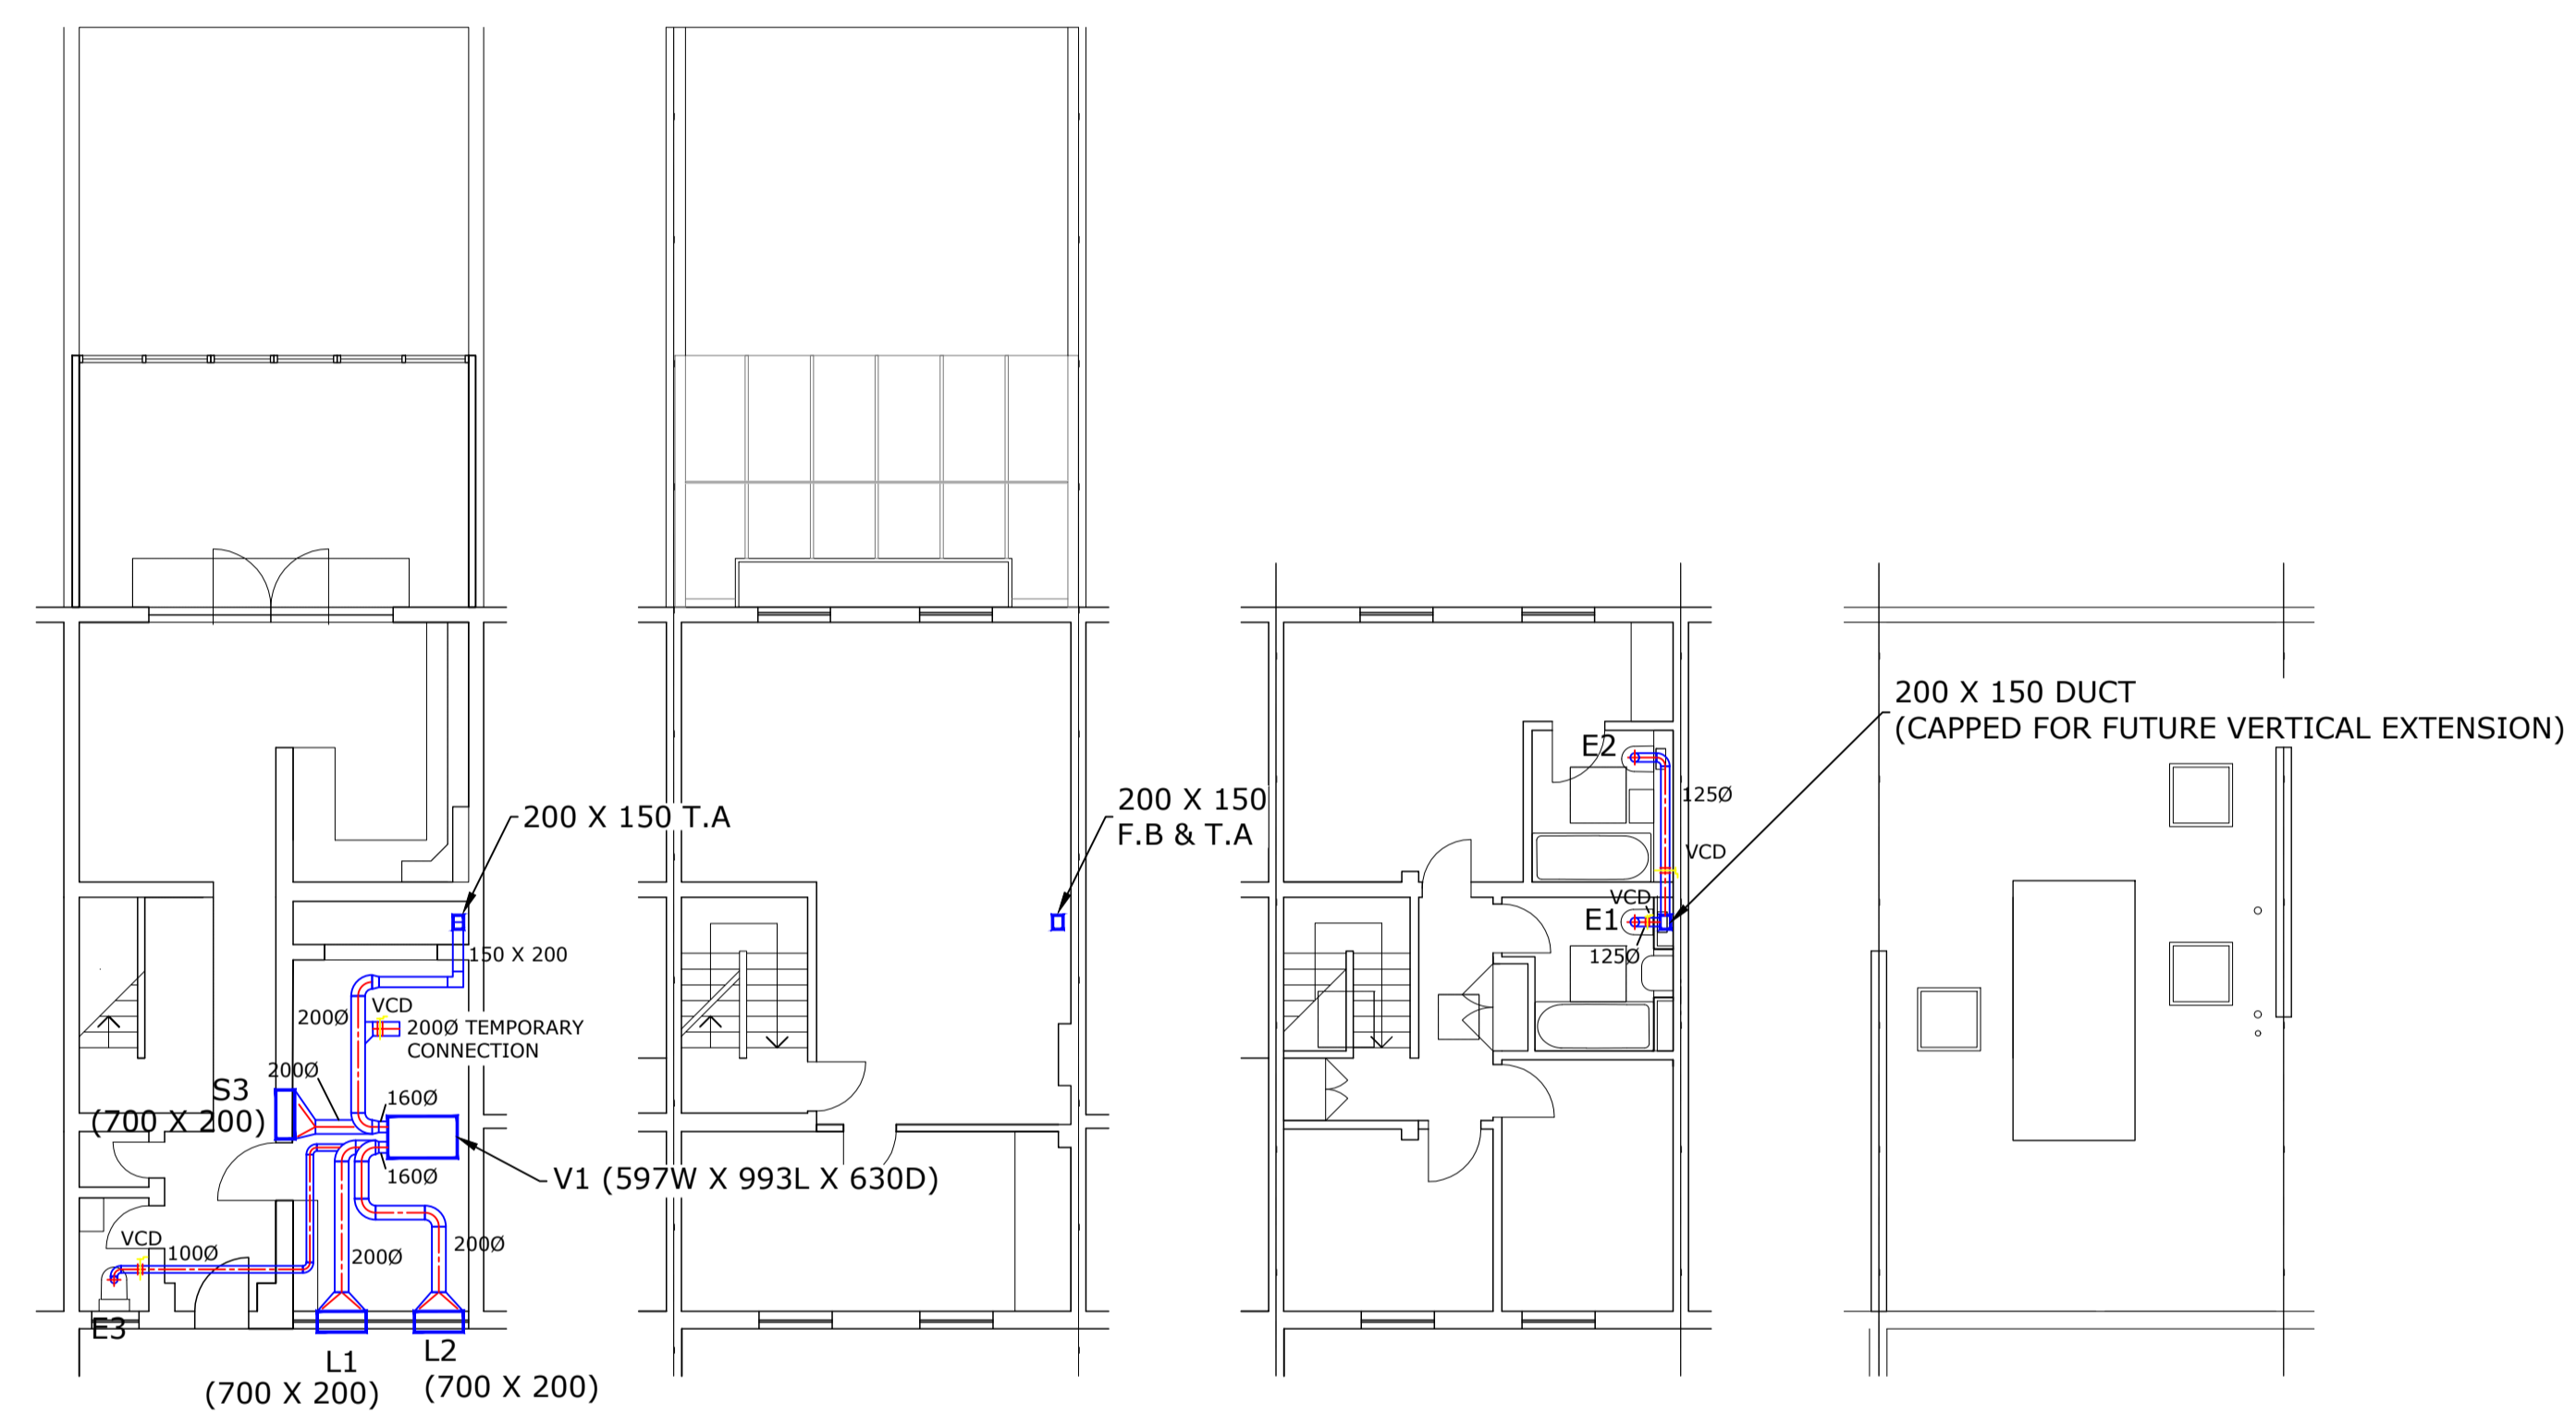

601 Indiana Building
Deals Gateway, Deptford Bridge
London SE13 7QD
t: +44 (0)203 723 8538
e: mail@medesignconsultancy.co.uk

CLIENT

NATHAN PIPER

PROJECT

6 BRIARY CLOSE
LONDON, NW3 3JZ

TITLE

PROPOSED
VENTILATION LAYOUT

rev	date	description	rev	date	description

SCALE 1:100 @A1

DATE 07/23

DRAWN P.O

m e design consultancy ltd

2308/M103