




Existing Elevation
1:100

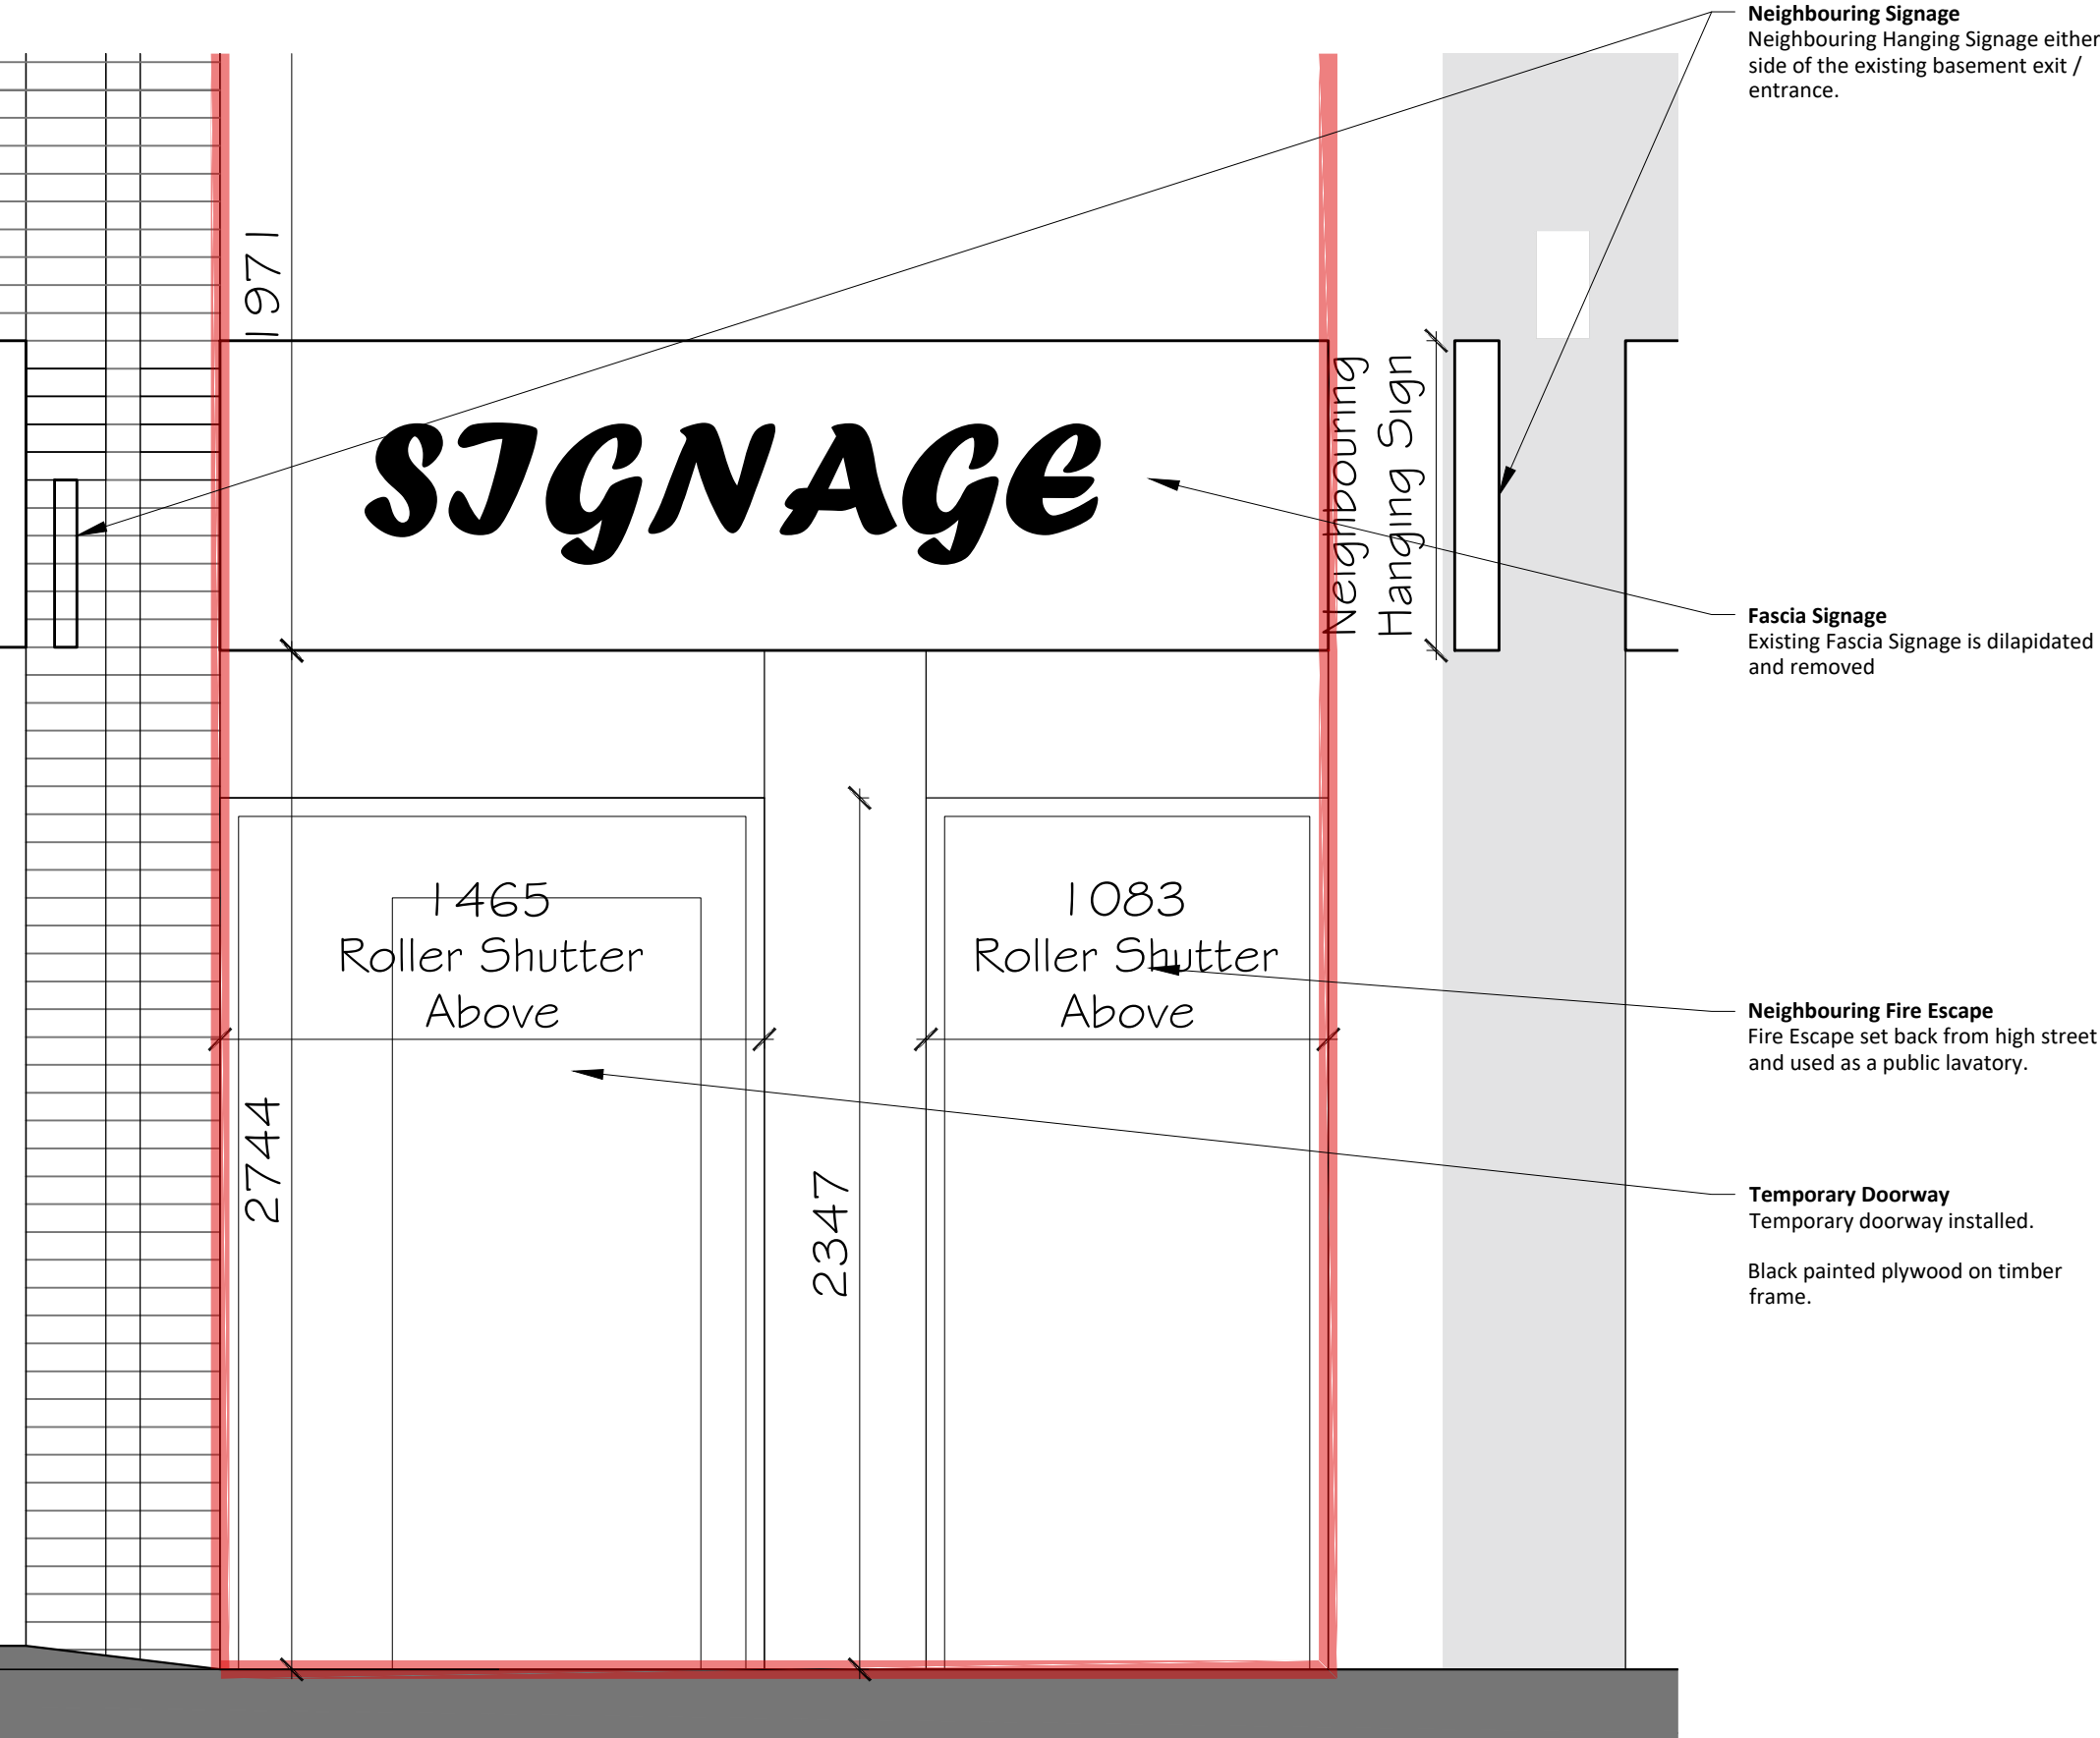


Existing Elevation
1:20

Notes:


Do not scale from these drawings. Figured dimensions only are to be used. All critical dimensions are to be checked on site before work proceeds. If in doubt ask.

All drawings are to be read in conjunction with all other relevant consultants and / or specialists drawings or documents.

Inconsistencies, errors and omissions found within documents (and also in relation to other consultants/specialists documents) are to be notified immediately to RSK Consulting

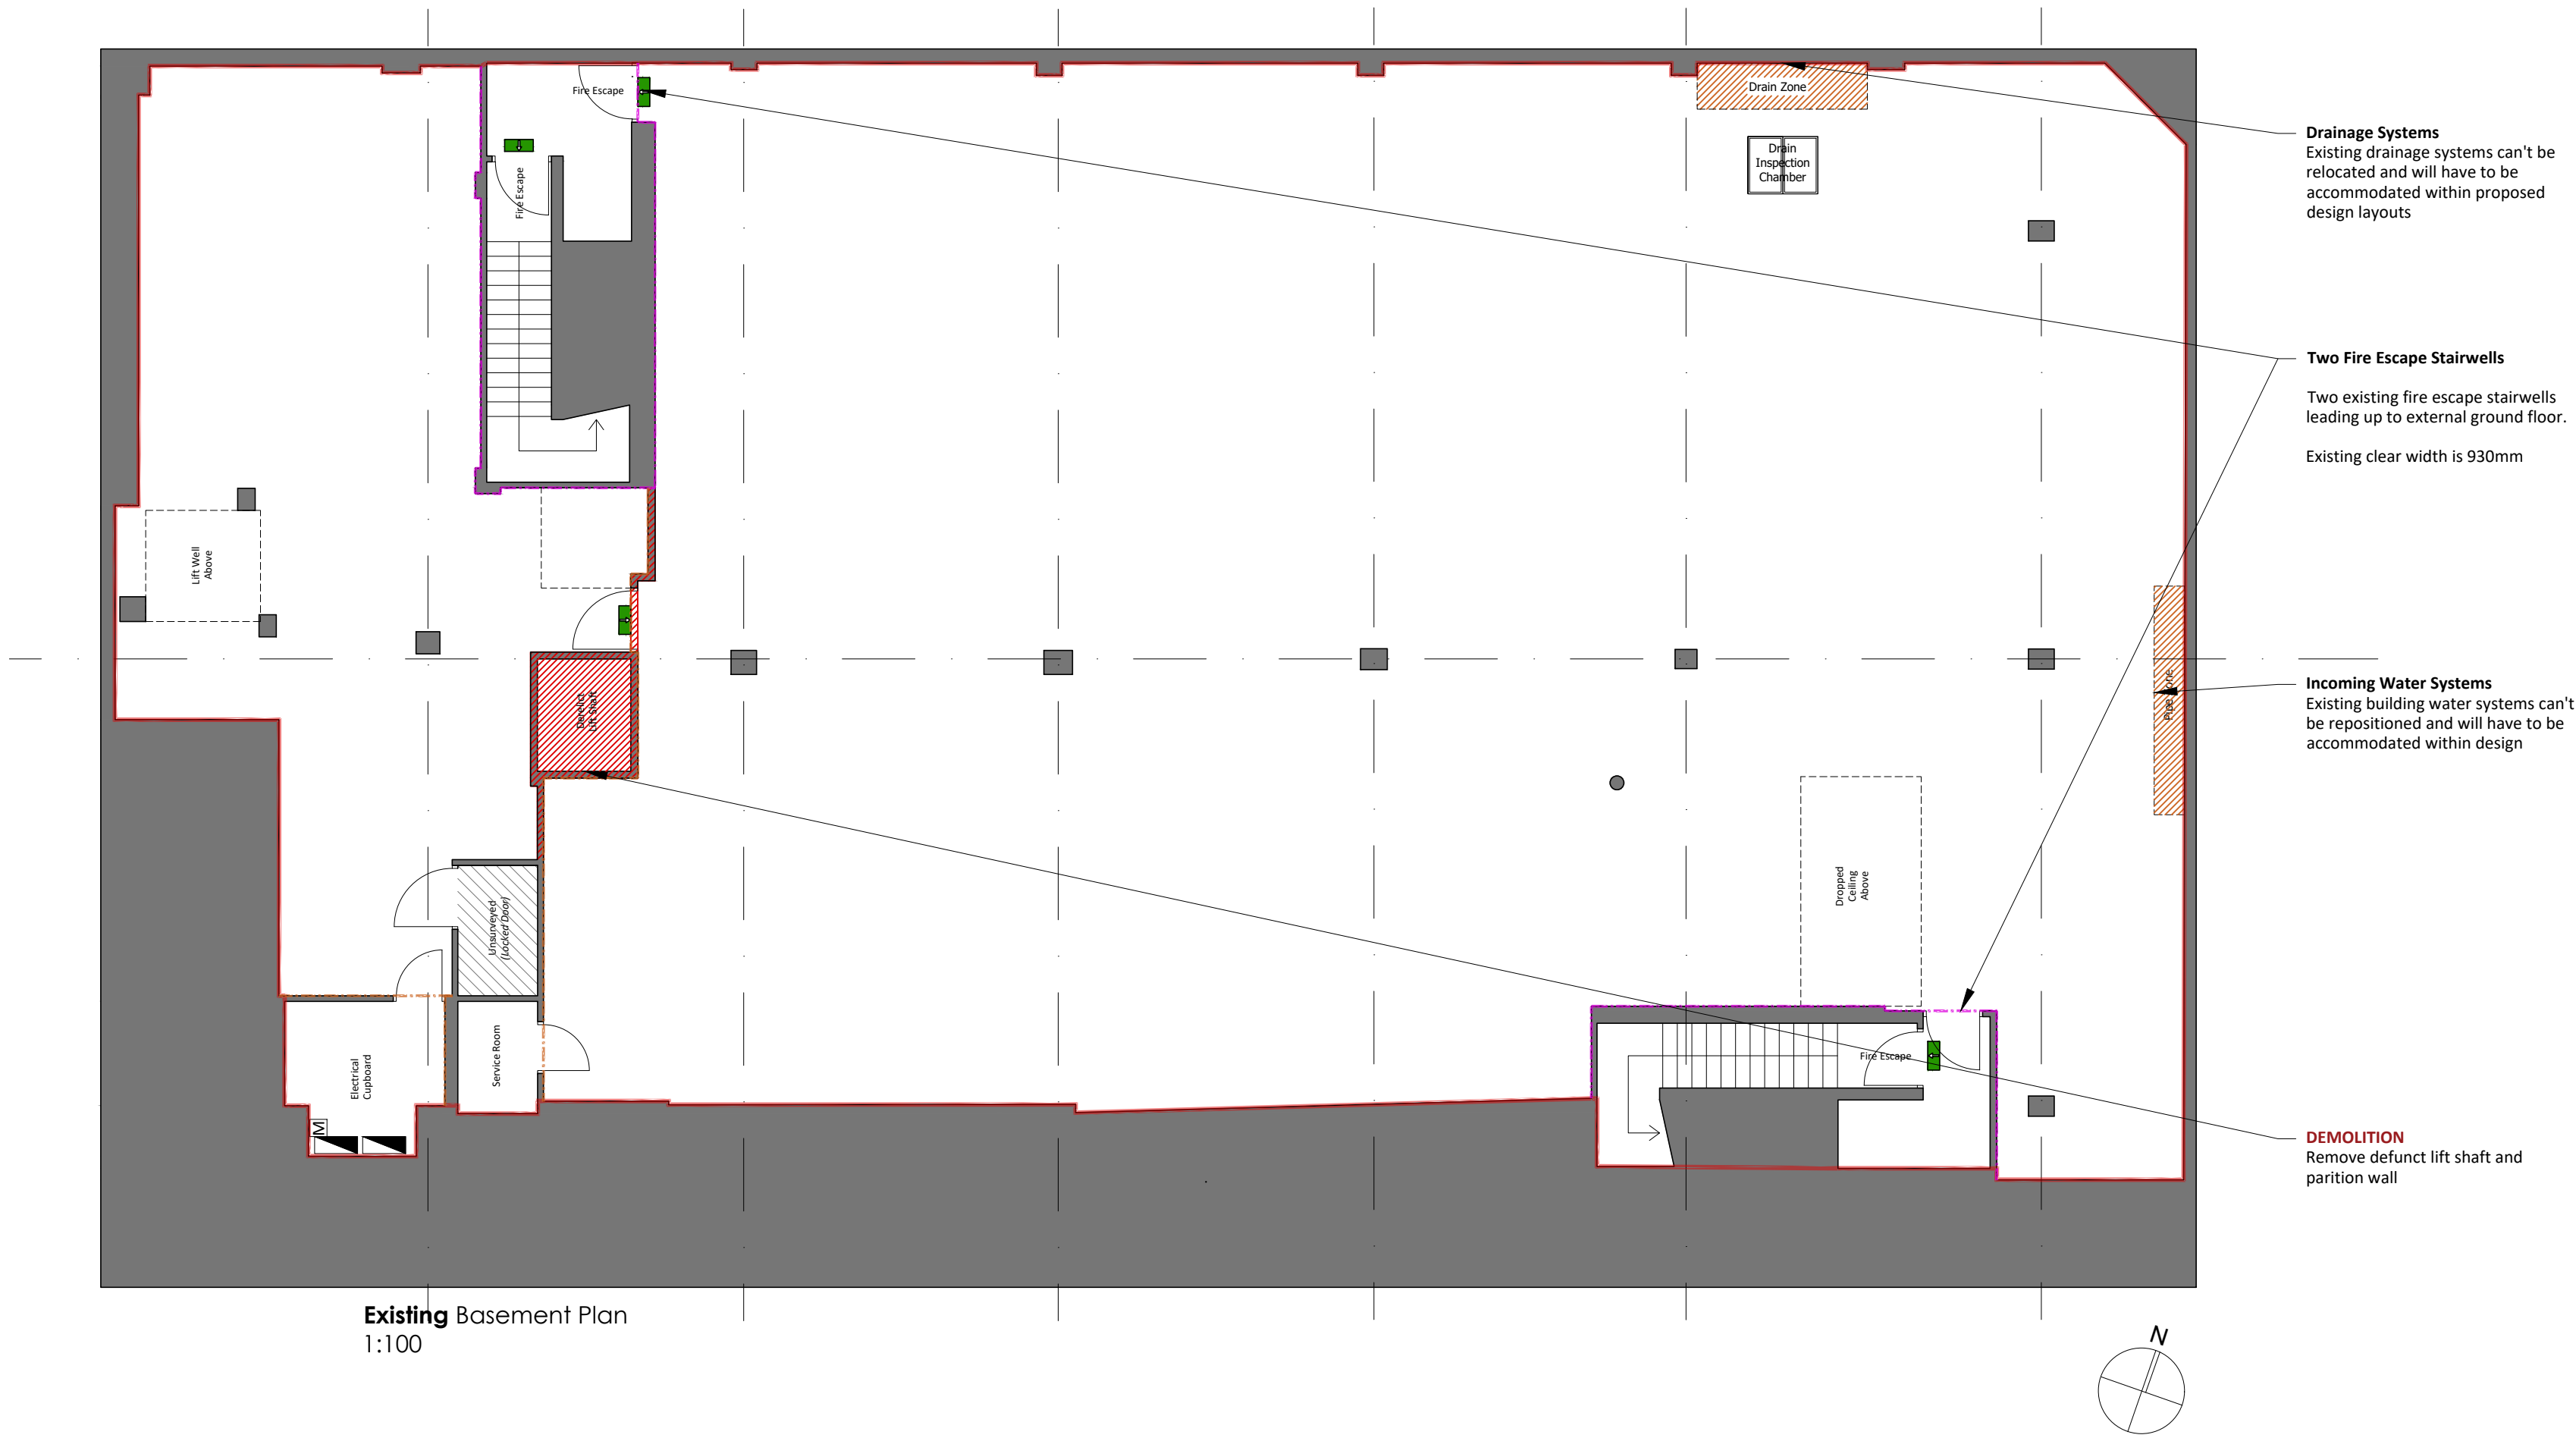

Existing Basement Plan
1:100

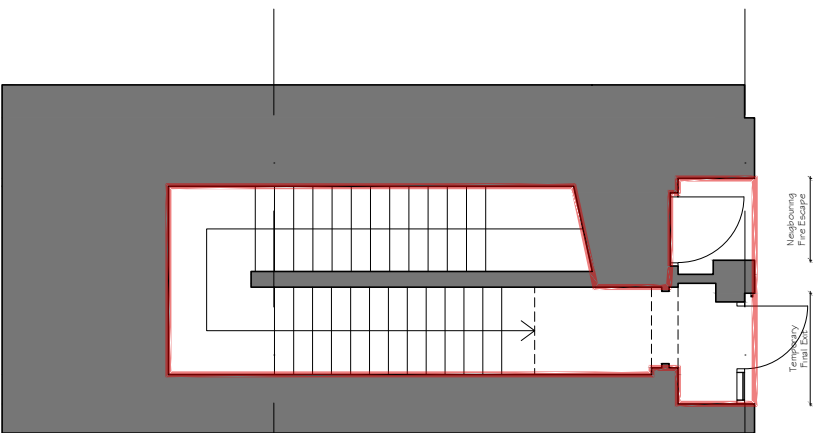


Existing Ground Plan
1:100



Photo Of existing entrance
N1s

- Electrical Legend**
Indication Only - Refer to Electrical Contractors Drawing
- Distribution board
 - Meter / Incoming Supply
- Smoke & Fire Detection**
Indication only - Refer to Fire Detection Sub-Contractors Drawing
- Ceiling Void - Smoke detector
 - Smoke Detector
 - Call Point
 - Flashing Beacon
 - Fire Alarm Panel
 - Fire Escape Signage
- Fire Resistance**
Indication only - Refer to Fire Detection Sub-Contractors Drawing
- Compartment Wall 30min Fire Resistance
 - Compartment Wall 60min Fire Resistance
 - Existing Wall
 - New Wall
 - Demolish Existing Wall

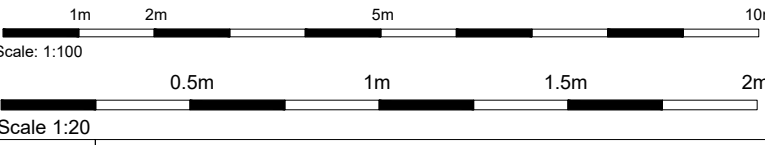

Revisions:

| | | | |
|-----------------|------------------------------|------|----------|
| Job | ECLIPSO - 213 Camden High St | | |
| Title | Existing Basement | | |
| Scale | 1:100 1:20 | Date | 17/09/24 |
| Drawn By | Status | | |
| Drwg. No. | 2260_101 | | |
| Revisions | | | |
| RSK Consultants | | | |