 




GROUND FLOOR FLAT OUTLINED IN RED

GIA = 111.7 sq.m

scale bar - metric



 scale bar - imperial

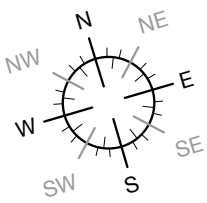

KEY:

- socket outlet (lighting)
- fuse + switch
- double socket outlet (switched)
- single pole one way switch
- pendant light
- lighting points
- multiple spotlights
- wall lights
- wall lights
- telephone socket
- Temperature Thermostat
- floor to cill, cill to head window height
- ceiling Level
- Floor Level

		CAD Surveys Ltd. Suite 2 KPC House Canterbury Road Willesborough Ashford TN24 0BP	
www.cadsurveys.co.uk		01233 635089	
Project : Flat B, 9 Downside Crescent London NW3 2AN		Drawn by : SE	
Drawing title : Existing Ground Floor and Site Plan			
Scale: 1:100@A3/1:50@A1	Date : 05/10/2021	Ref : 1122-S05-01	