




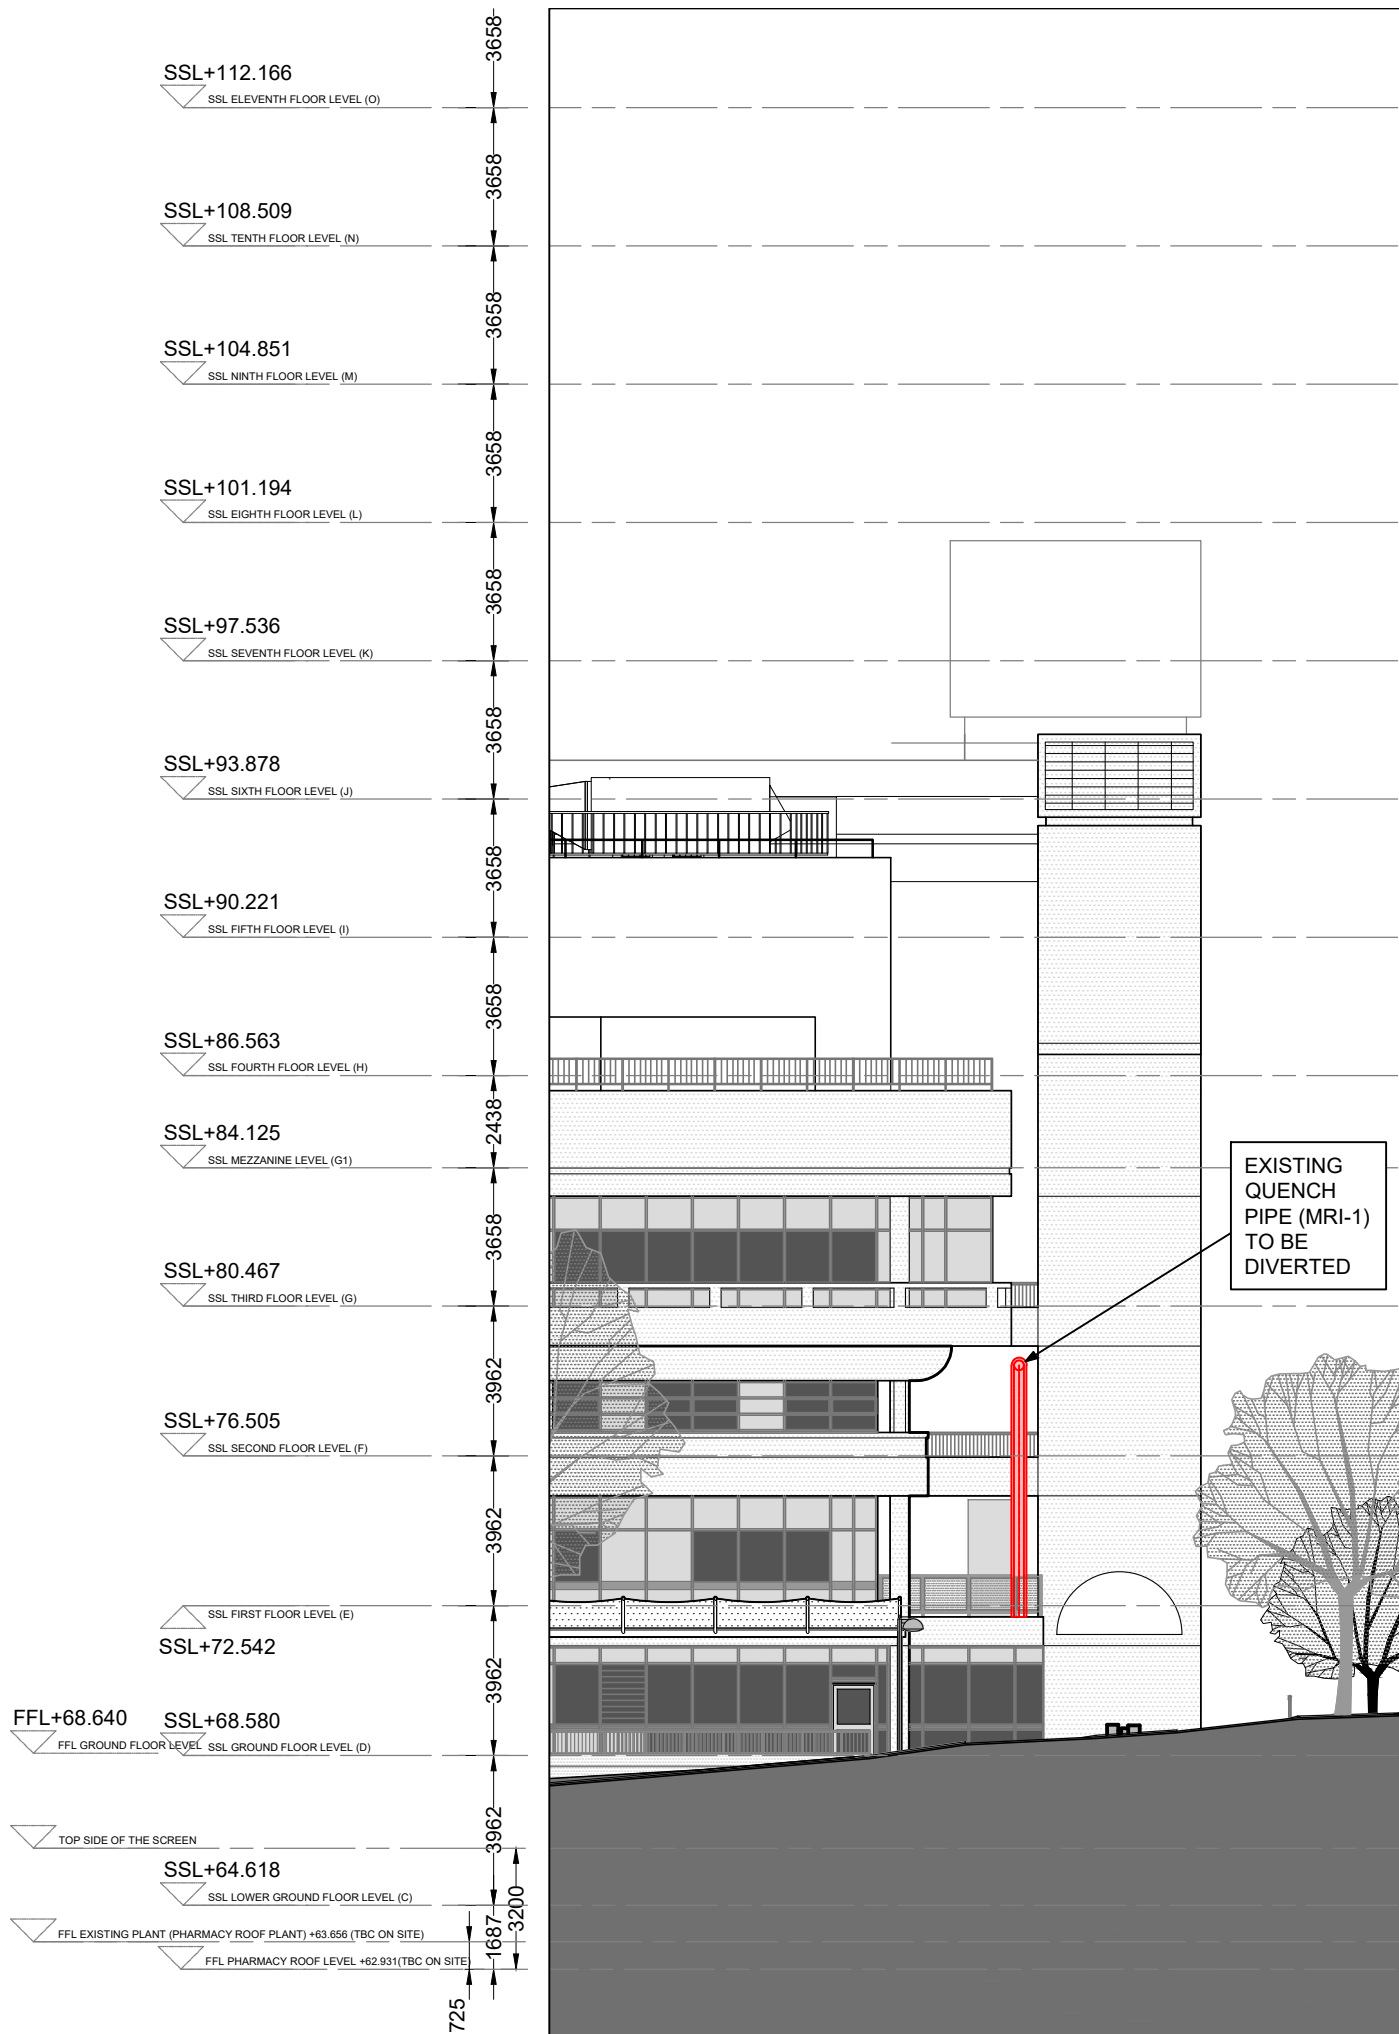


01 Existing North Elevation - Permanent works
(02)011 1:200 @ A3

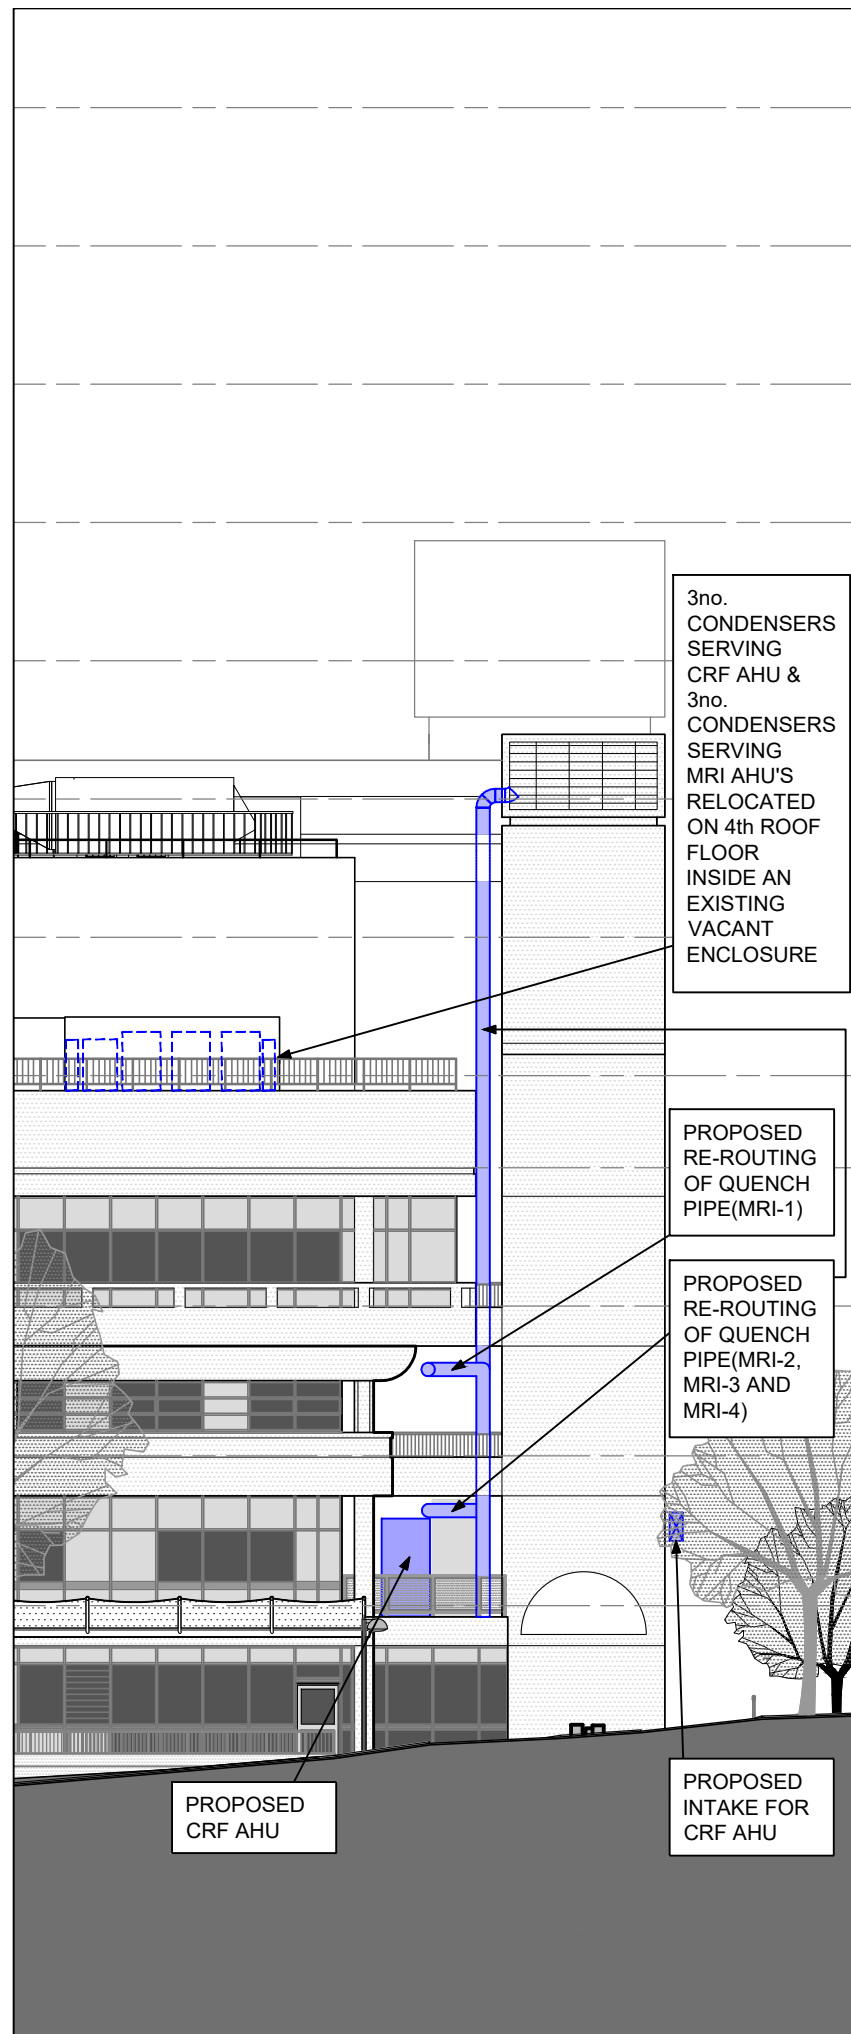

02 Proposed North Elevation - Permanent works
(02)011 1:200 @ A3

THIS DRAWING IS PROTECTED BY COPYRIGHT - FIGURED DIMENSIONS ONLY TO BE TAKEN FROM THIS DRAWING. DIMENSIONS TO BE CHECKED ON SITE AND ANY DISCREPANCIES REPORTED TO THE ARCHITECT IMMEDIATELY.				
PURPOSE OF ISSUE: (I)Info/Comment (S)Sign Off (P)Planning (B)Building Control (T)Tender (C)Construction (F)Final Revision				
Rev	Rev Date	Revision Description	Drawn/Checked	Purpose of Issue
/	13/09/2024	Issued for planning	FY	.
A	20/09/2024	Issued for planning (Draft-for comments) Enabling works included	FY	.
B	27/09/2024	Issued for planning. 3no. condensing units associated with 3no. existing MRI AHU's (permanently relocated to level 04)	FY	.

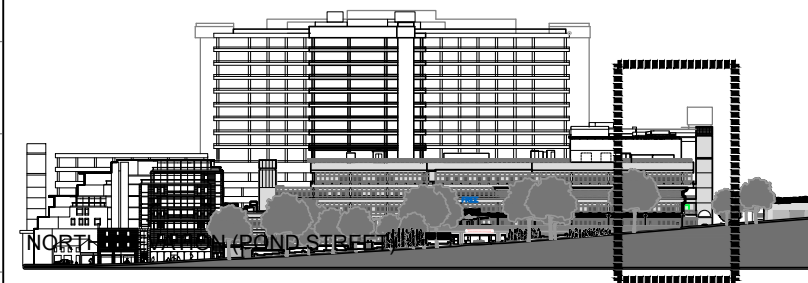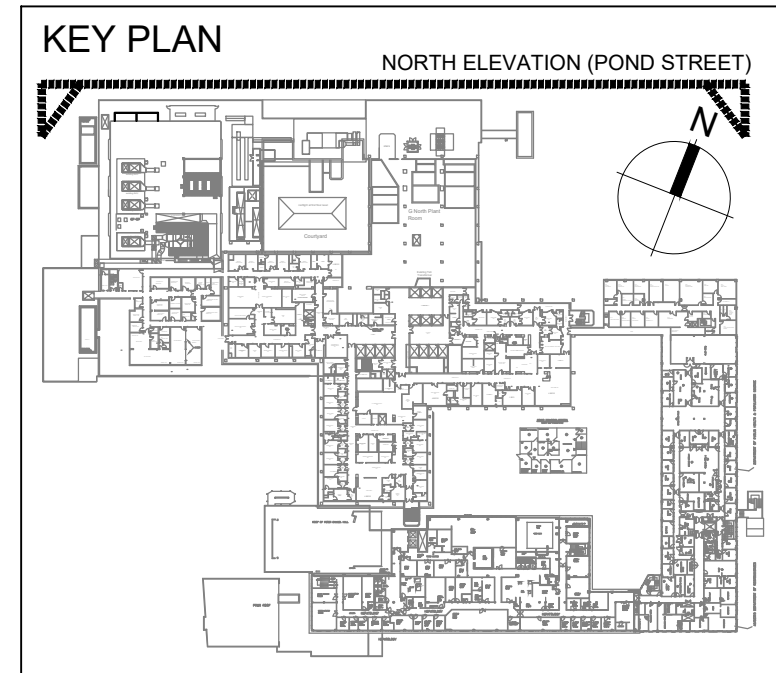

Legend :	
	Existing quench pipes (permanent works). Current routes
	Vacant space left by 2no. Chillers and 10no. condensers relocated (3no. MRI AHU's condensers permanently relocated on 4th roof floor-vacant enclosure & 7no. existing condensers, serving ancillary MRI areas, to be temporary relocated on Ground floor)
	Proposed CRF plant, ducting & rerouted quench pipes (permanent works)

FOR PLANNING		0 2 4 6 8 10m
Exist. & Prop. North Elevation - Permanent works: New CRF AHU unit & diversion of Quench pipes (MRI-1, 2, 3 and 4)		For 1:200 scale
Royal Free London CRF	24009 JOB NUMBER	(02)011 DRAWING NUMBER
Sept 2024 DATE	1:200 @A3 SCALE	B REV

Ansell & Bailey Ltd Chartered Architects 99-101 Farringdon Road London EC1R 3BN 020 7387 0141 architects@ansellandbailey.com

ANSELL + BAILEY