




EXISTING

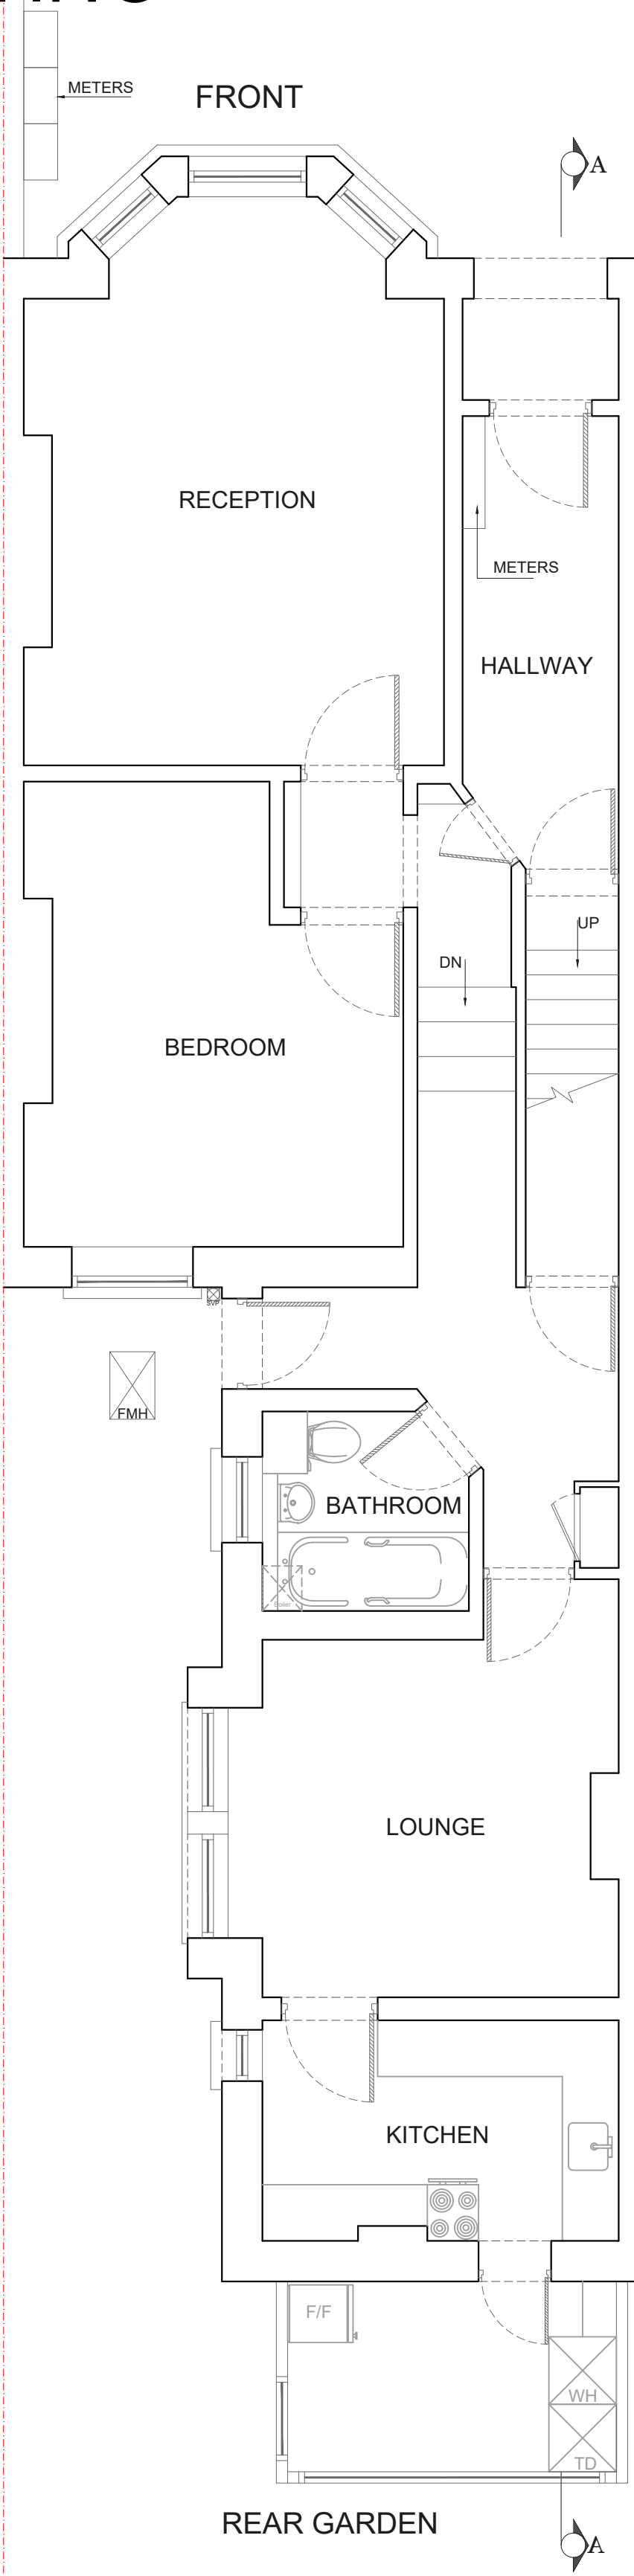


GROUND FLOOR PLAN
Area ca. 74.96 m²

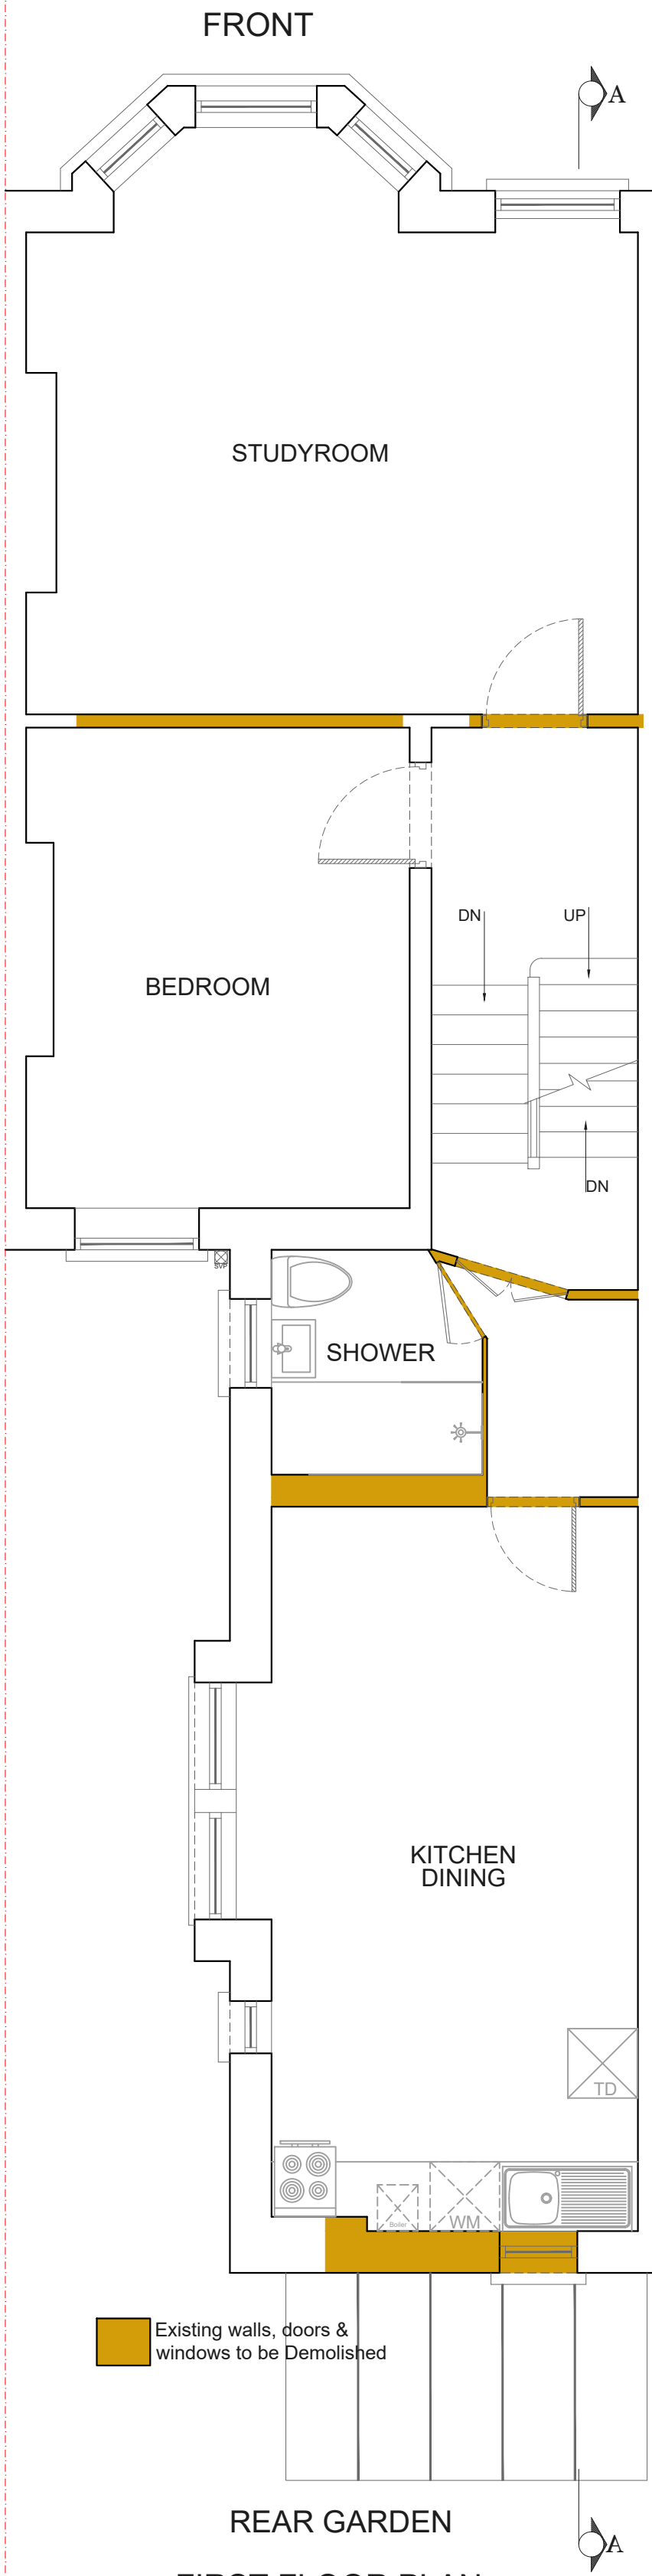


FIRST FLOOR PLAN
Area ca. 74.96 m²

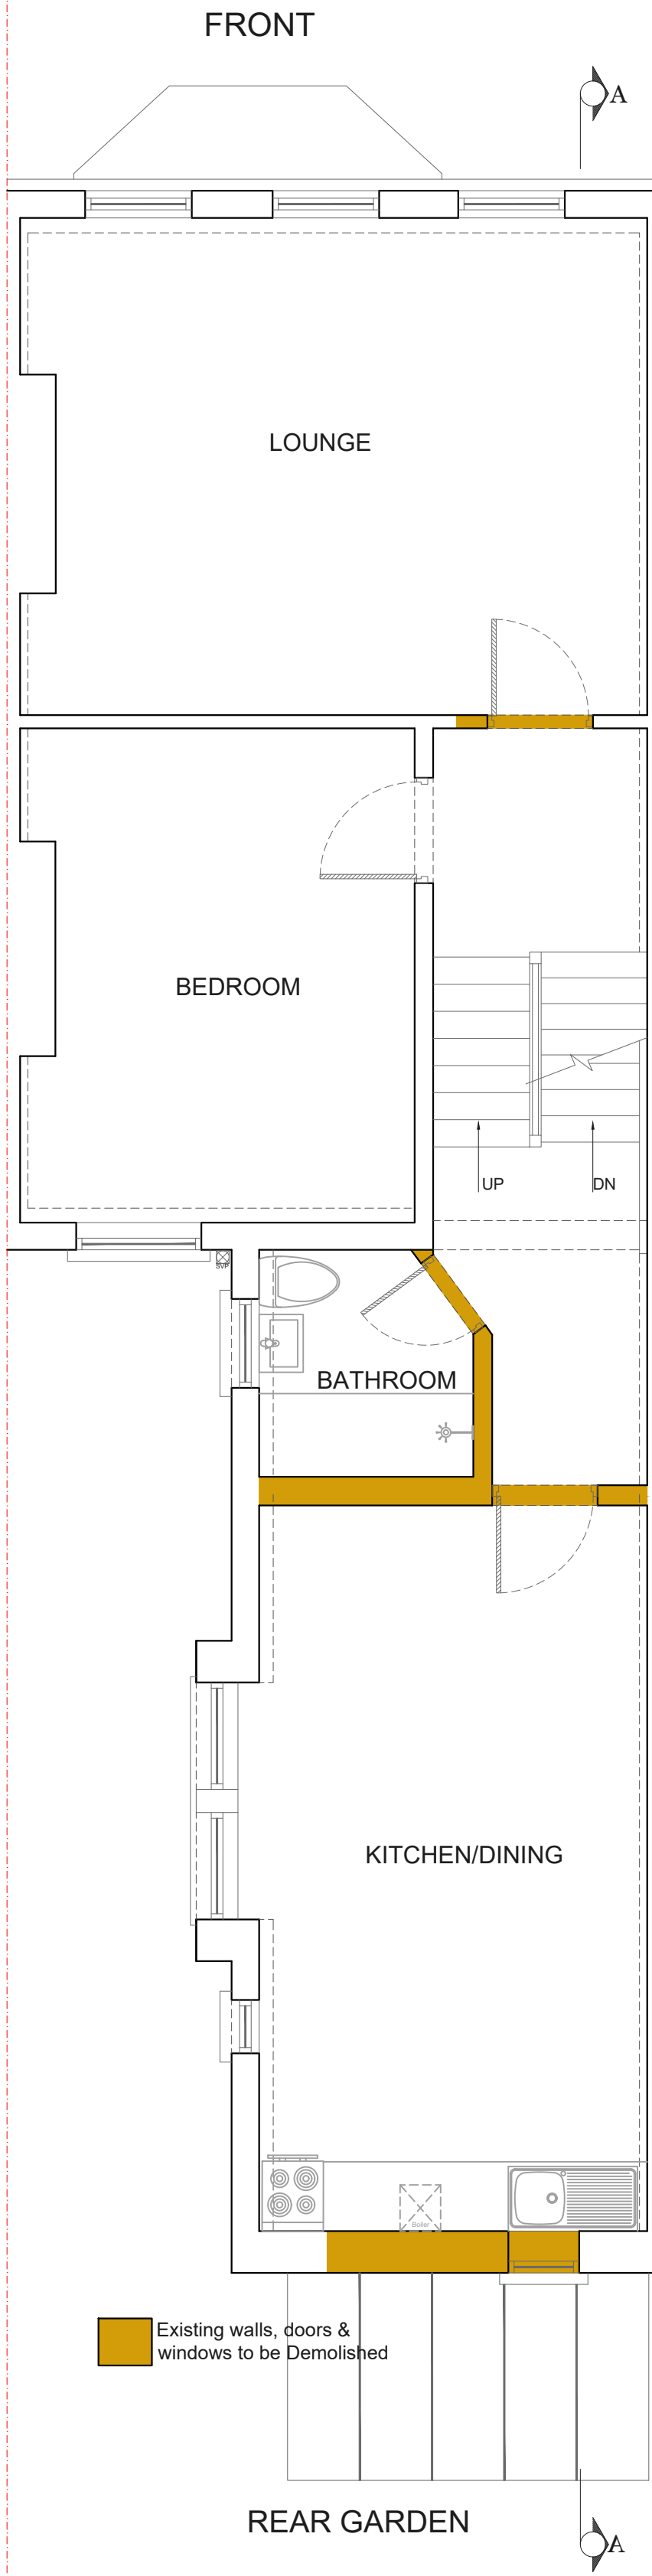


SECOND FLOOR PLAN
Area ca. 76.63 m²

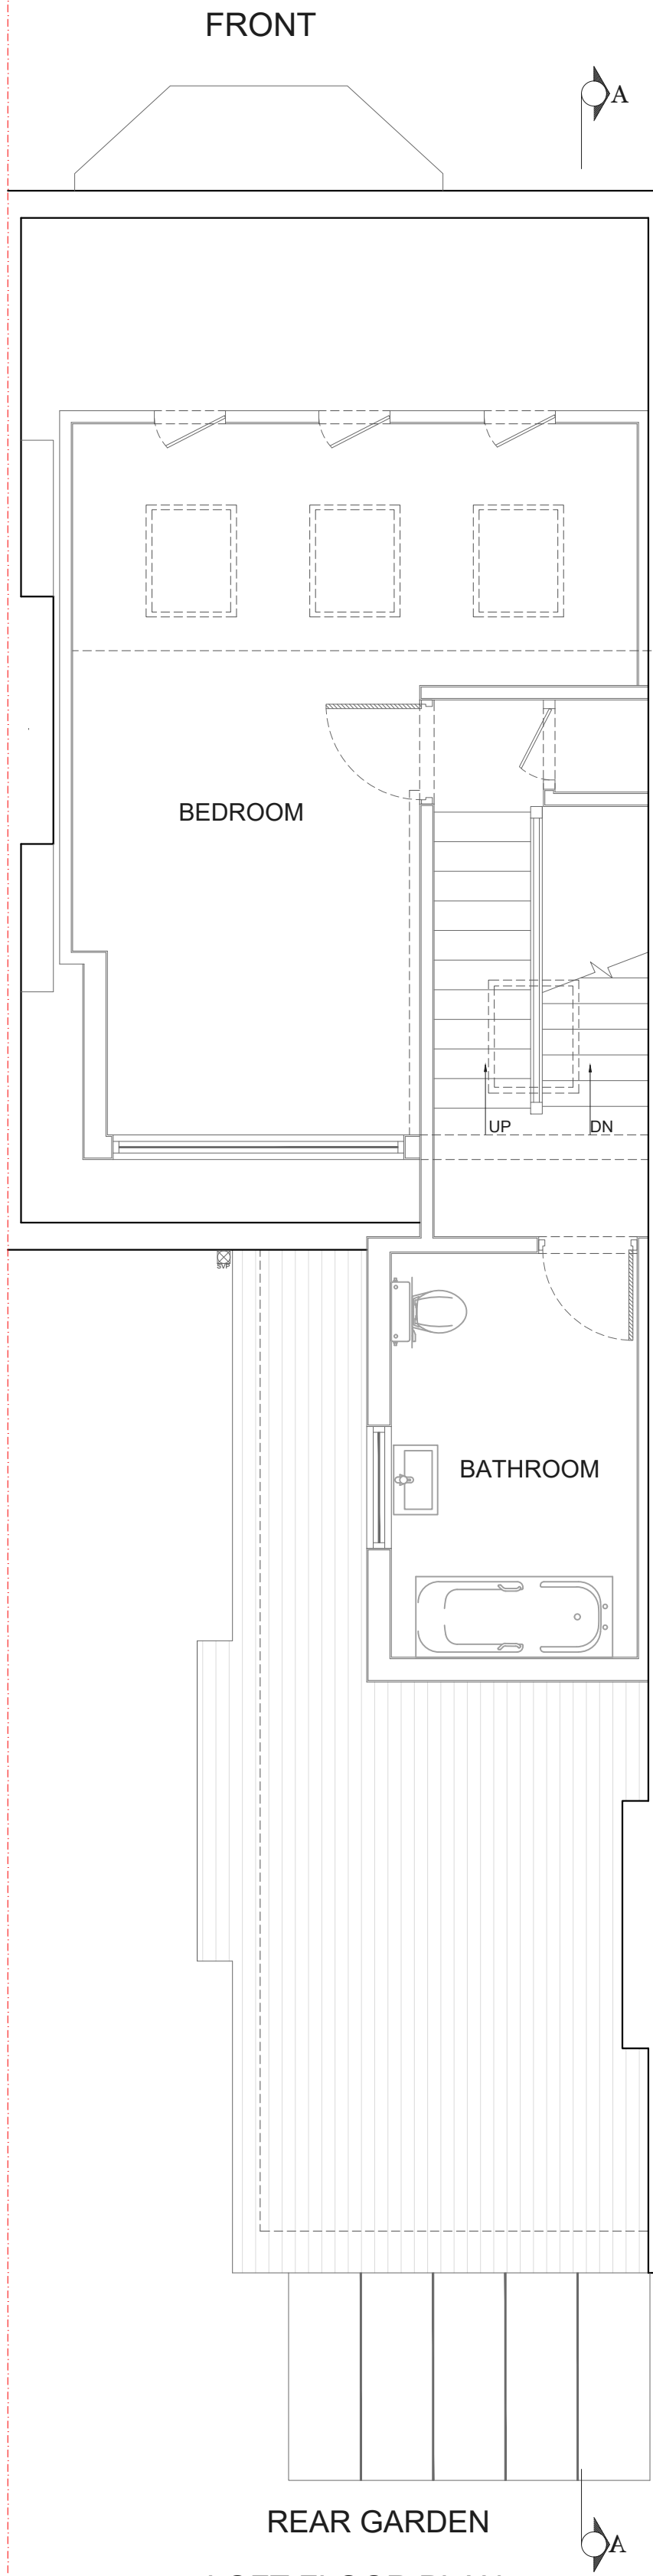

LOFT FLOOR PLAN
Area ca. 35.47 m²

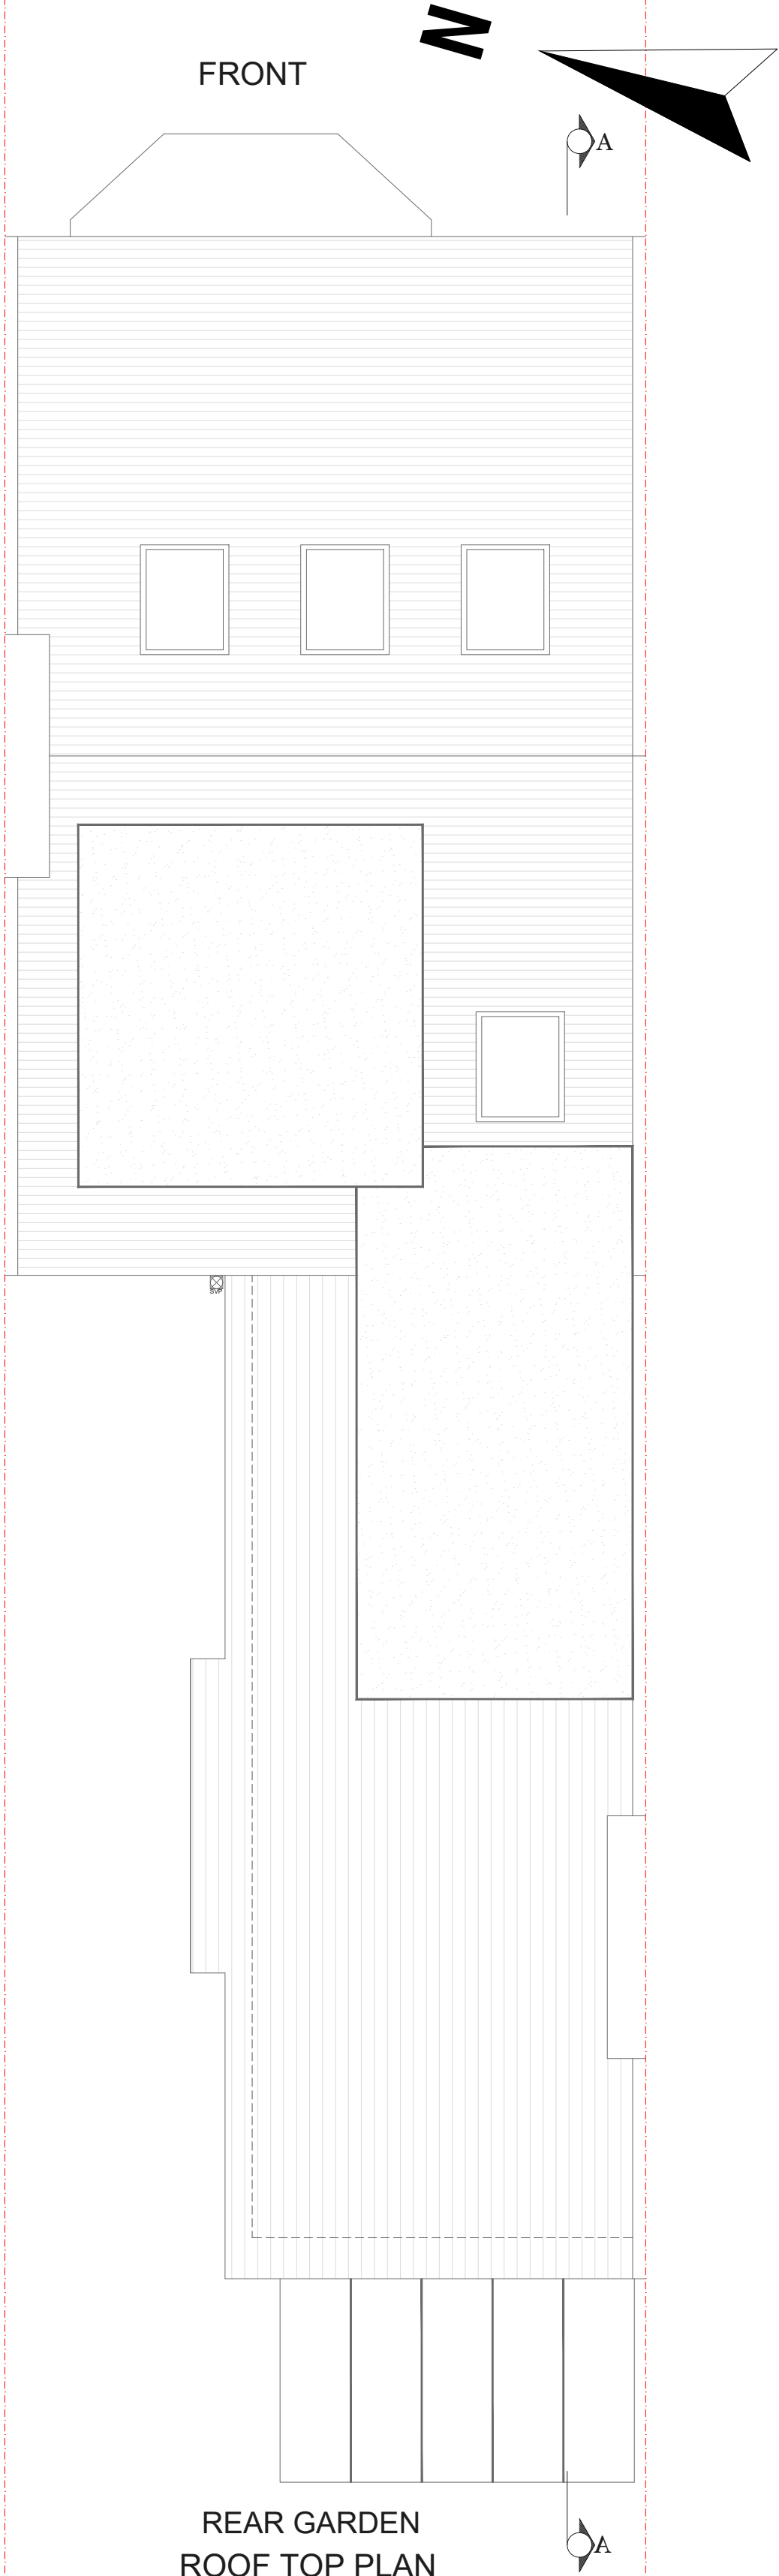

REAR GARDEN
ROOF TOP PLAN

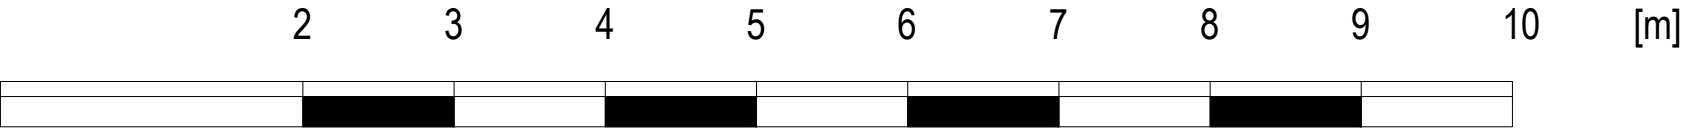

Drawn by:
ZF

Client:

Project:
32 MAZENOD AVENUE NW6 4LR

Drawing Title:
EXISTING PLANS

Date:

Scale @A1:
1:50

No.:
PP-01

Rev:







Page:

...\\logo\\Simply_Loft.jpg

AS APPROVED

Symbol Key:

- Proposed wall
- Boundary line
- Details above
- Waste drainage layout
- Demolished
- Rainwater layout

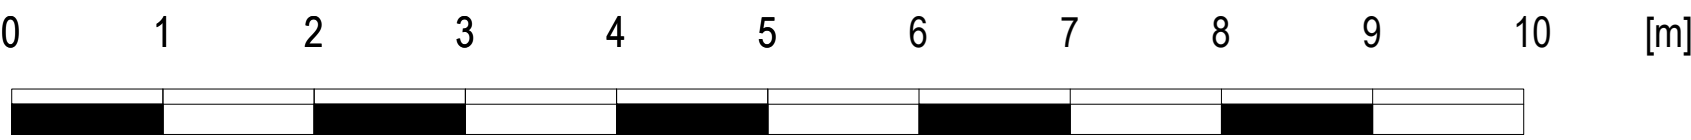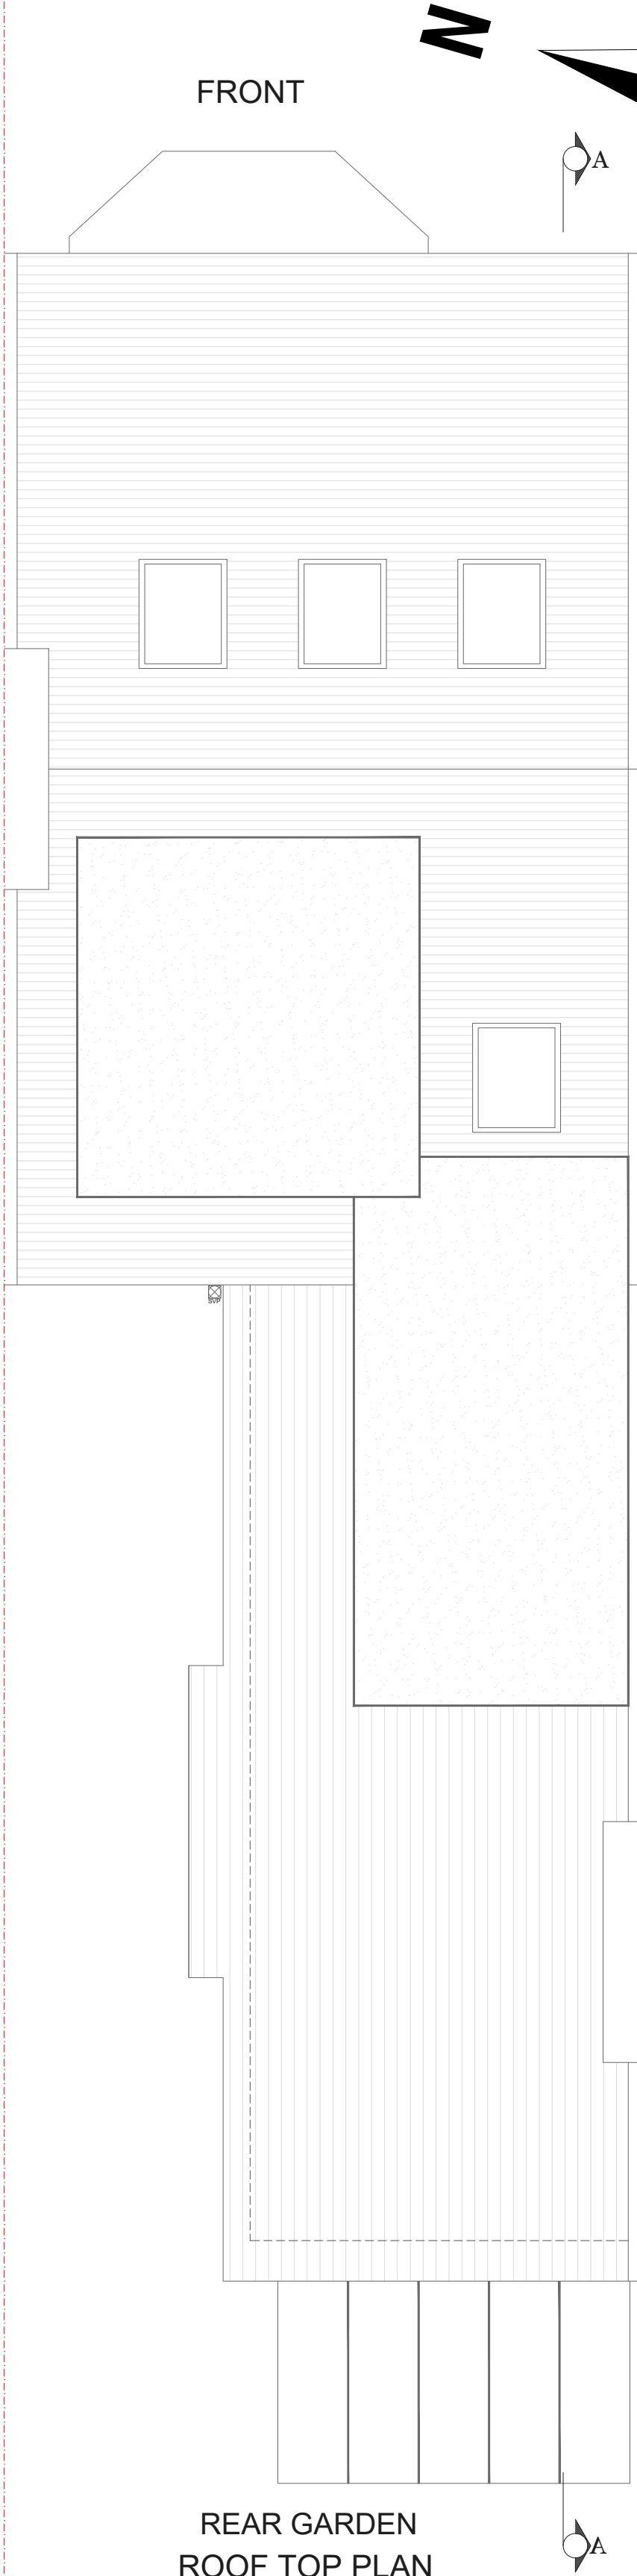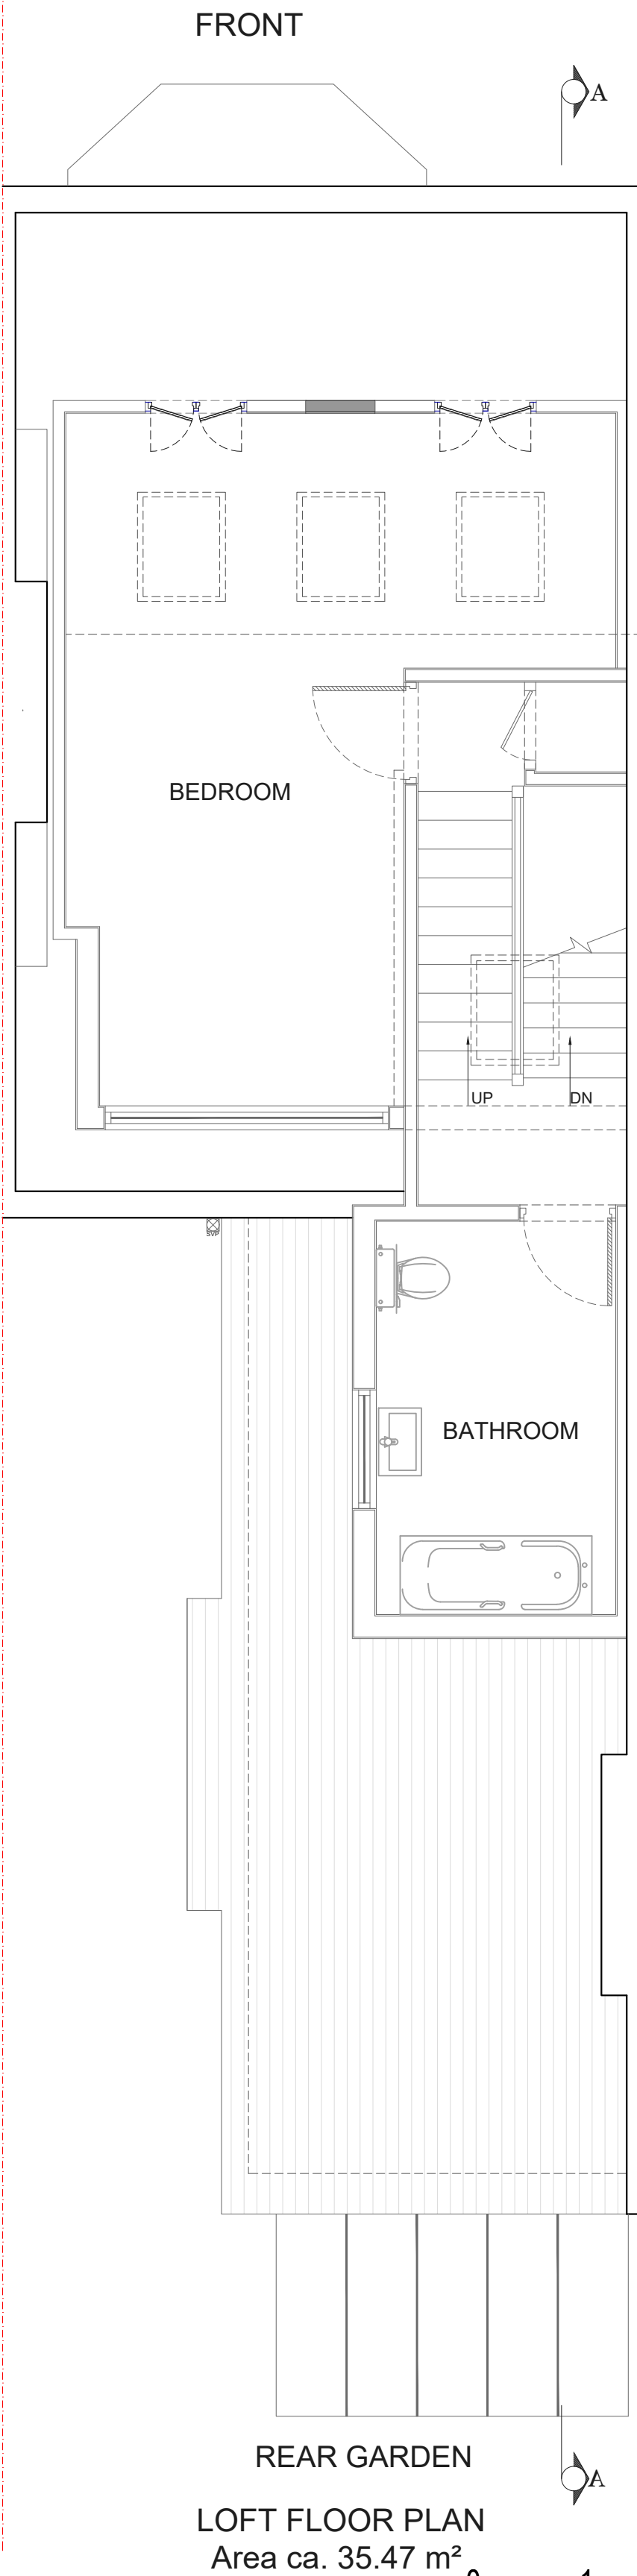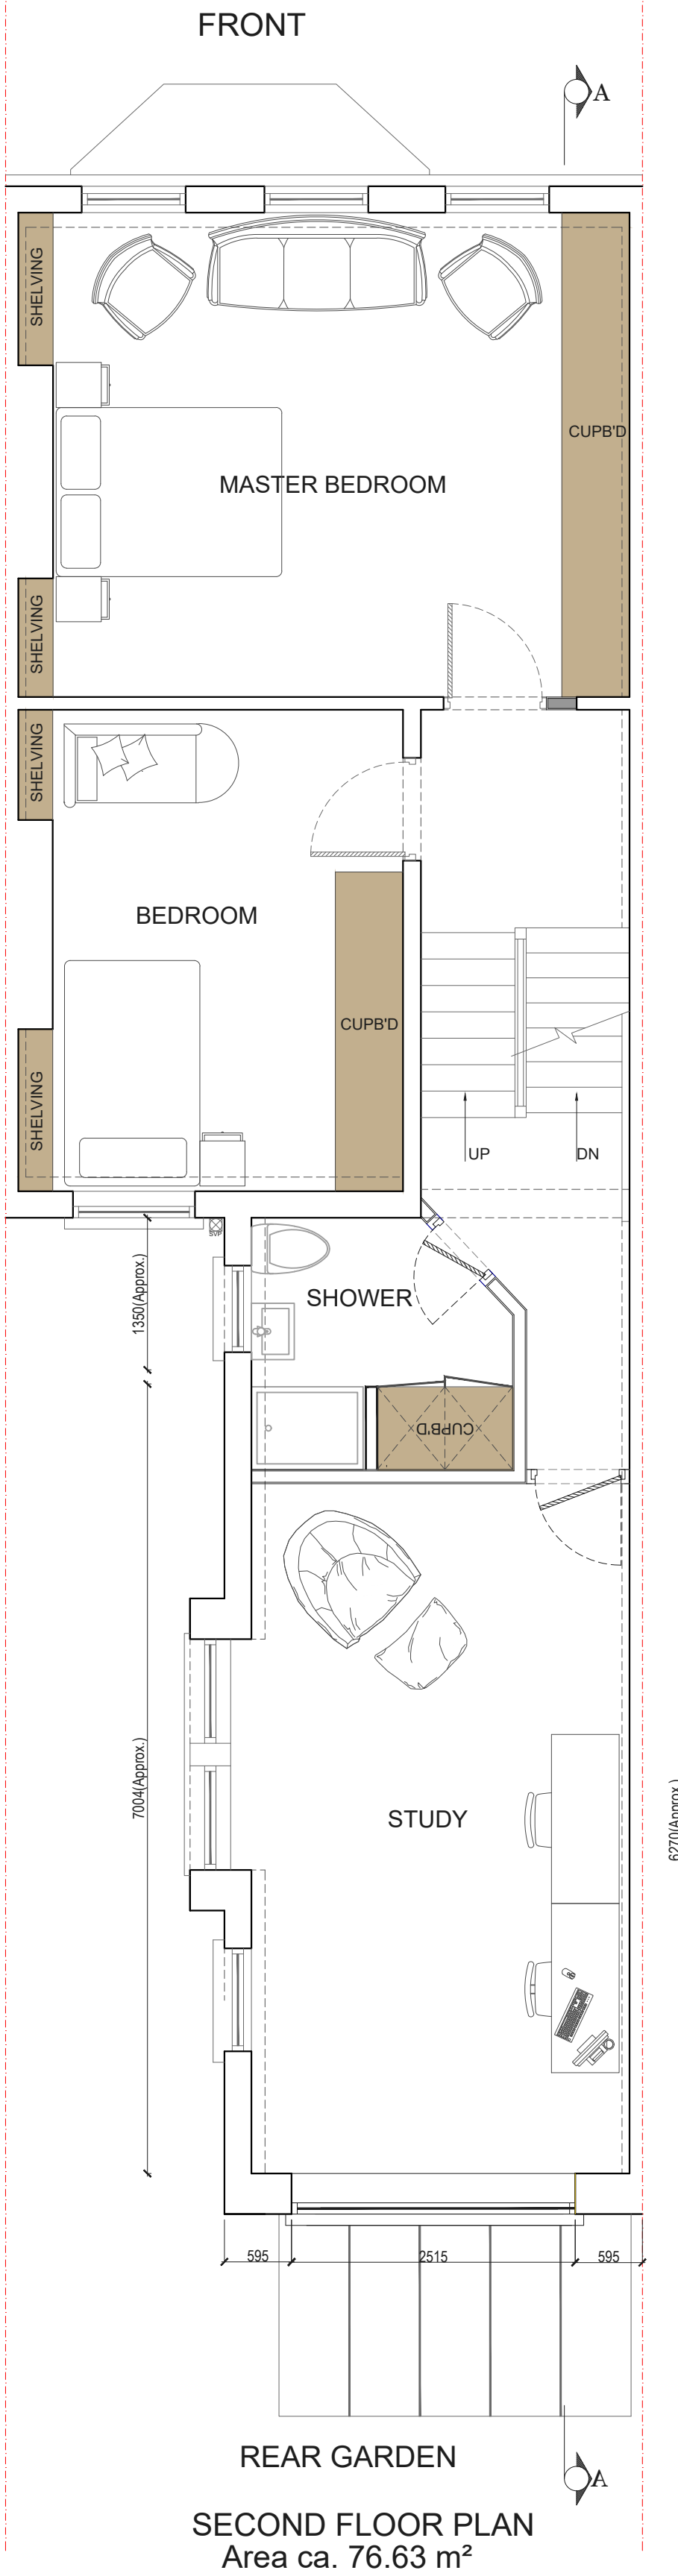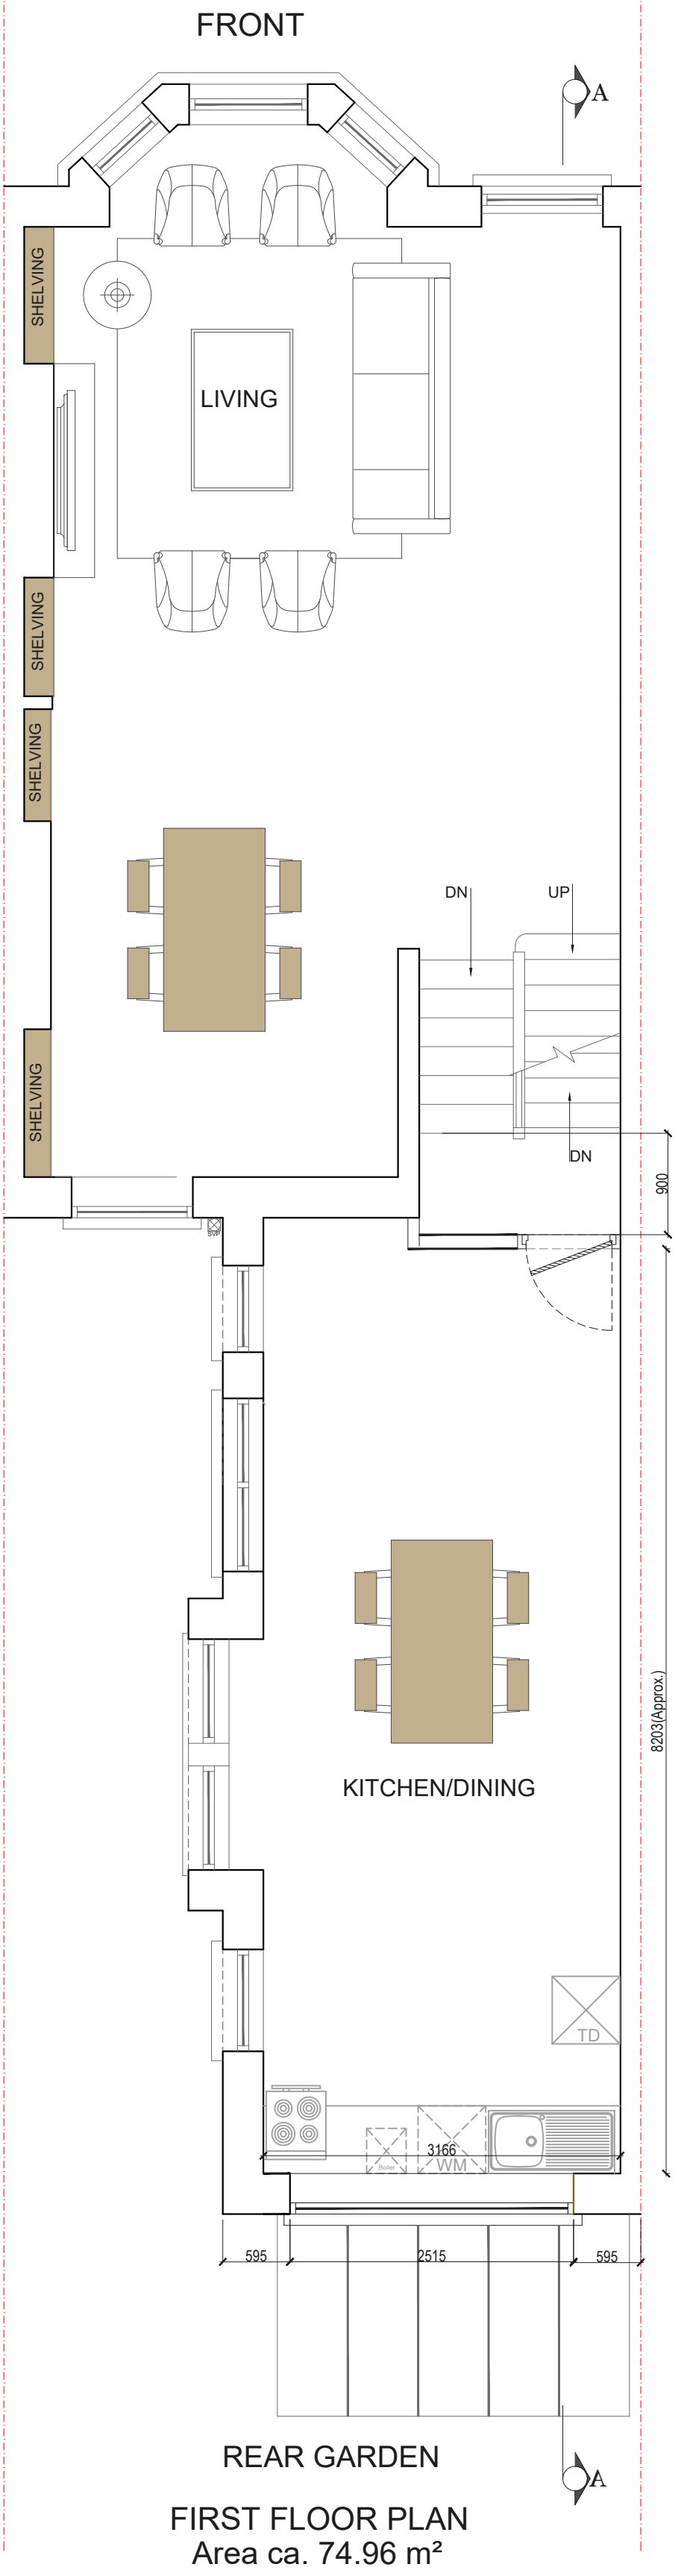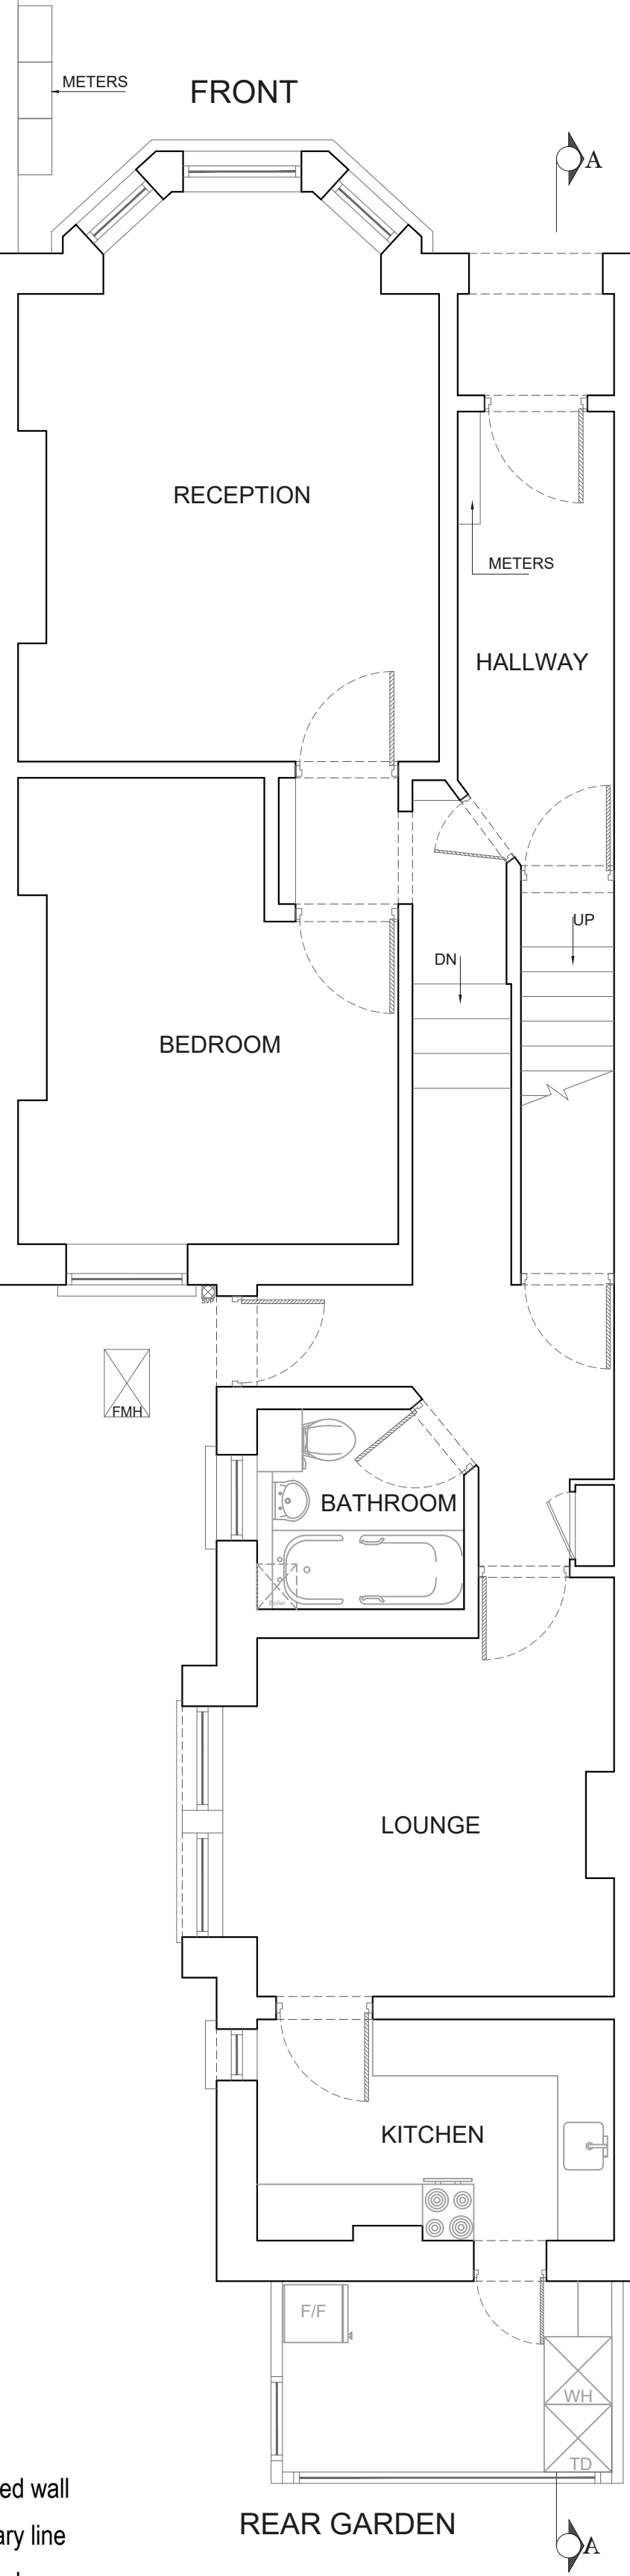

Drawn by:
ZF

Client:

Project:
32 MAZENOD AVENUE NW6 4LR

Drawing Title:
PROPOSED PLANS

Date:

Scale @A1:
1:50


No.:
PP-02

Rev:

Page:




EXISTING

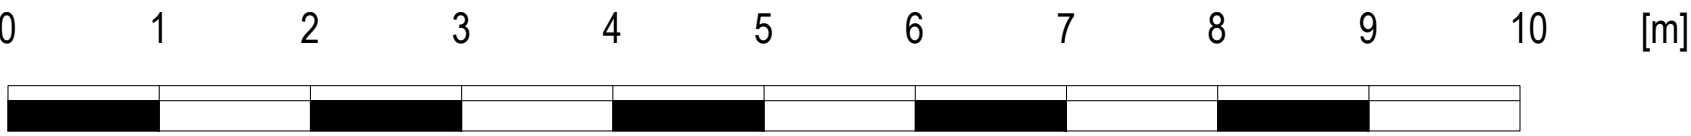

AS APPROVED

Proposed Materials:
Walls: Tiles to match existing
Flat roof: Ply membrane

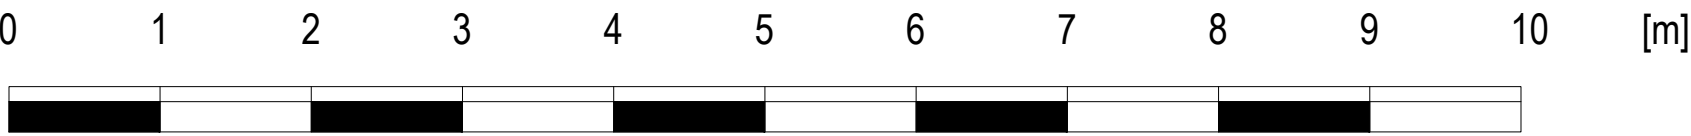

Drawn by:
ZF

Client:

Project:
32 MAZENOD AVENUE NW6 4LR

Drawing Title:
PROPOSED ELEVATIONS

Date:

Scale @A1:
1:50


No.:
PP-04

Rev:

Page:






EXISTING &
AS APPROVED

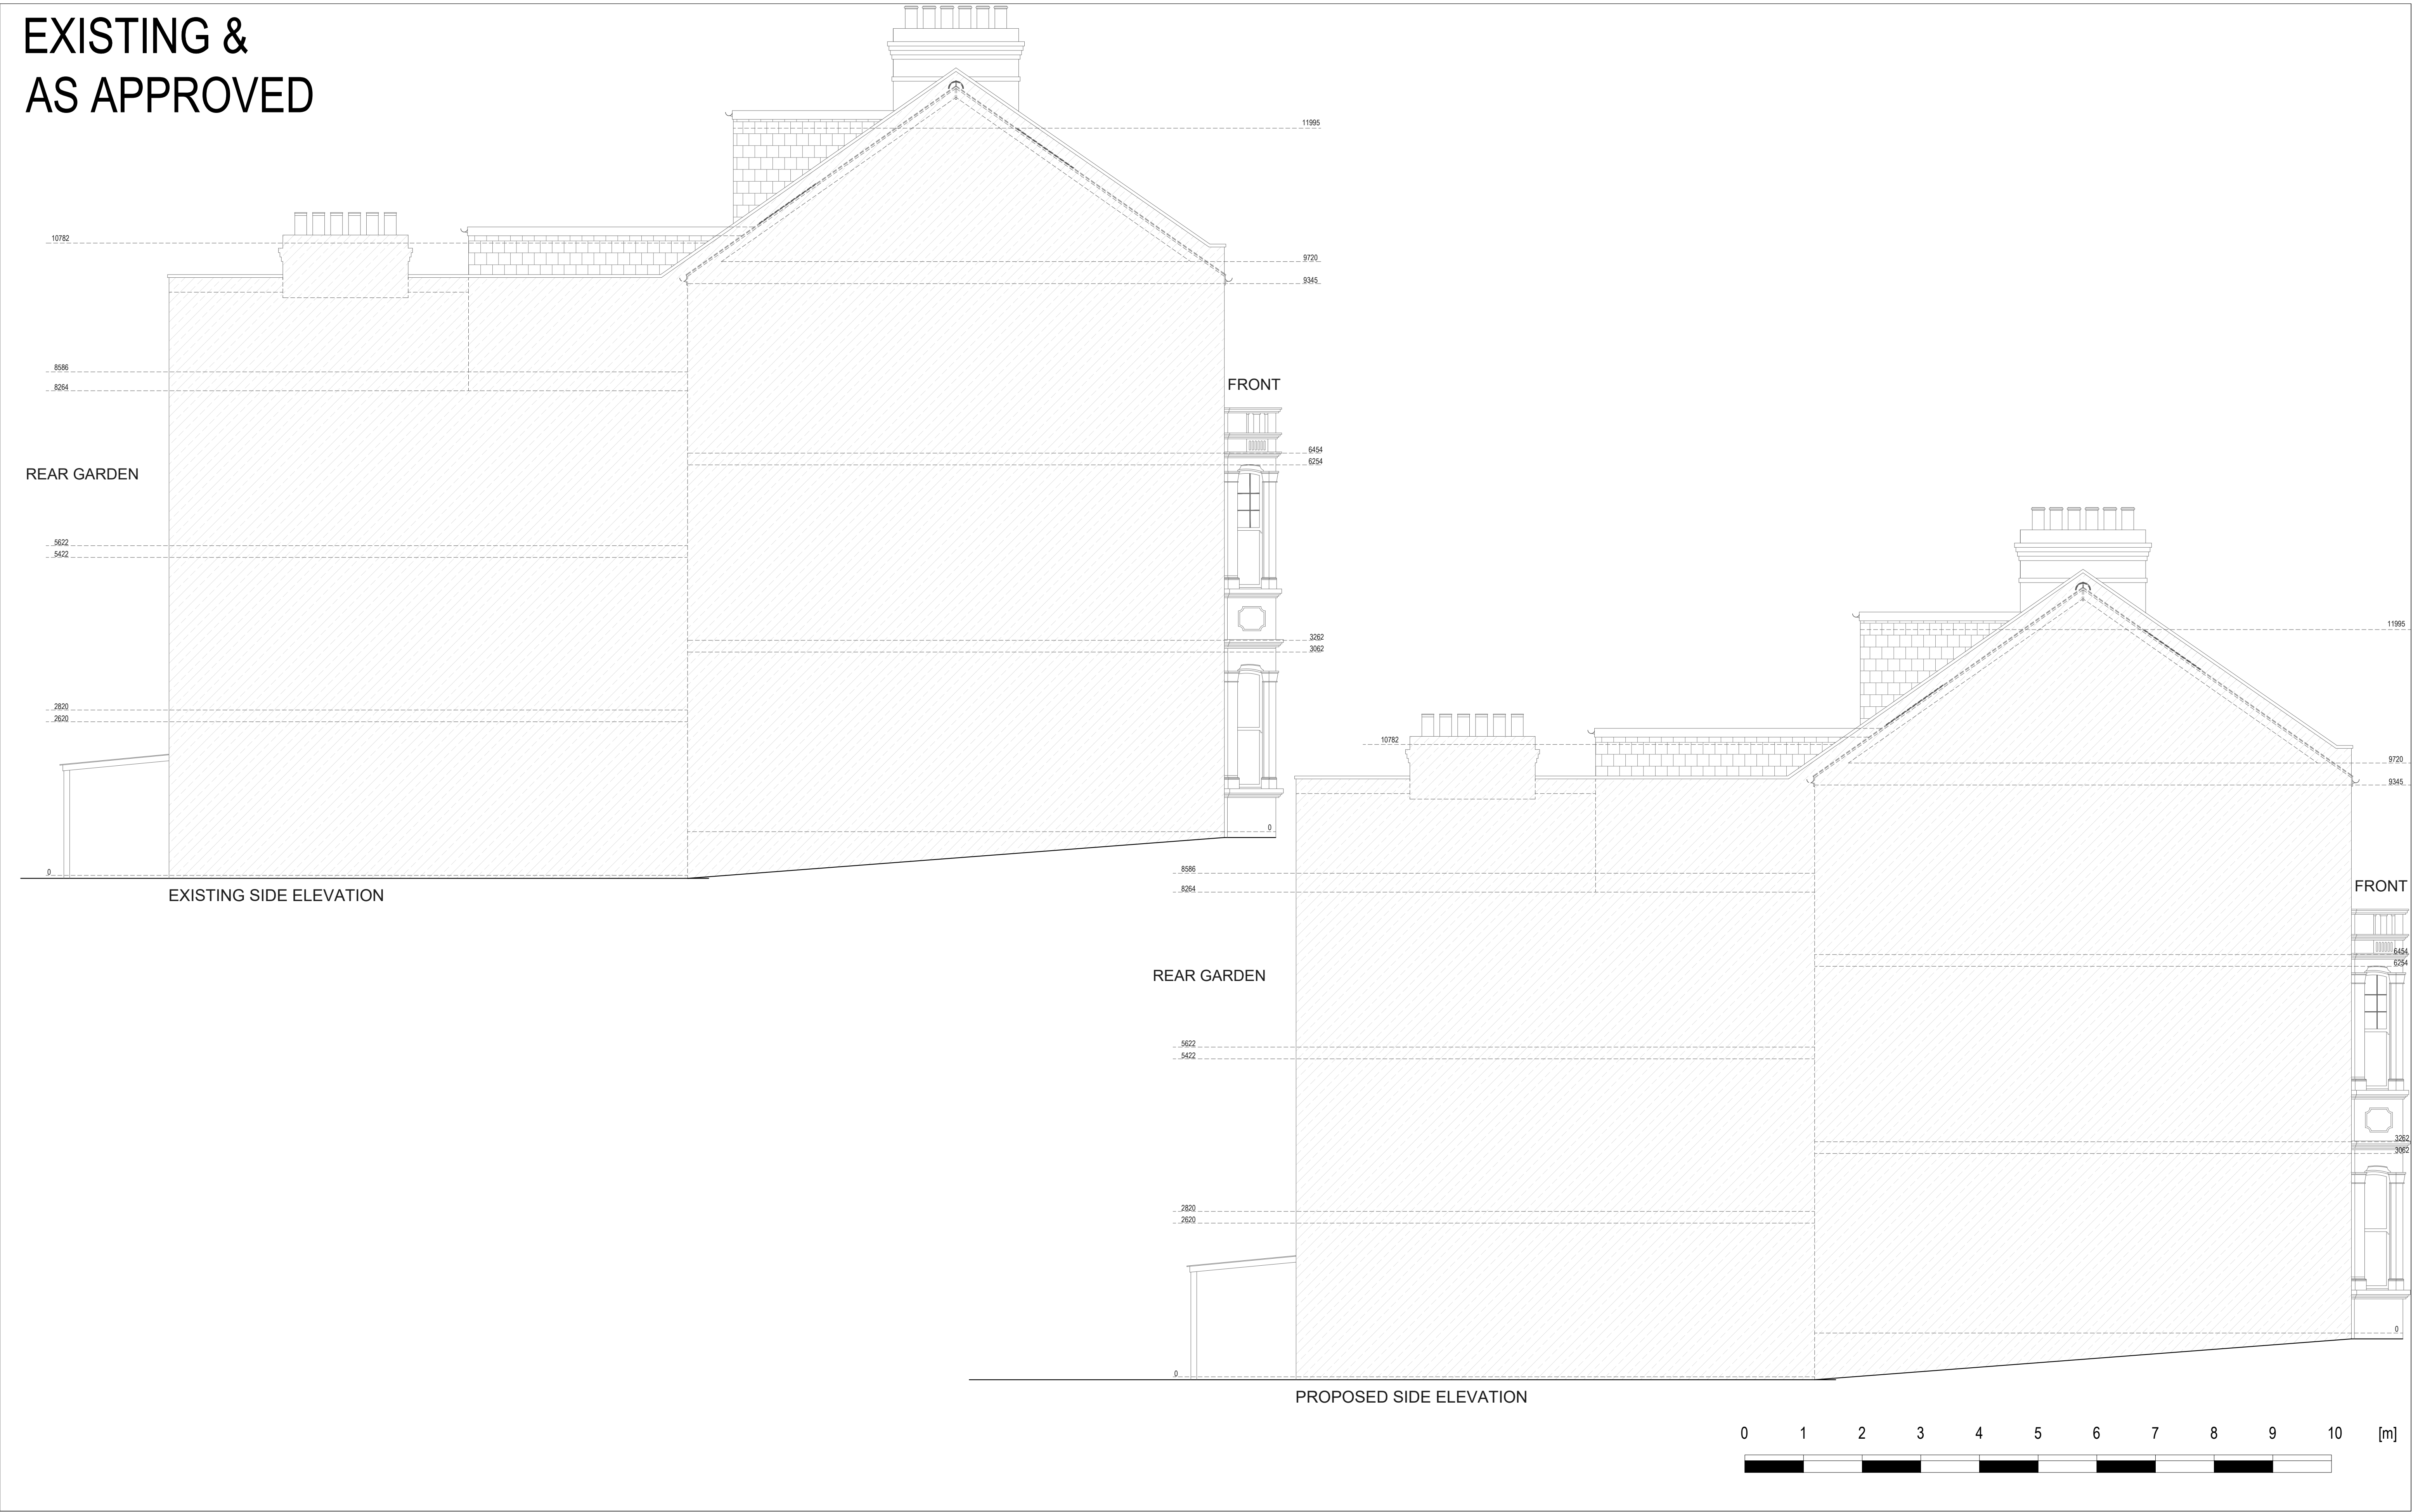

	Drawn by: ZF	Project: 32 MAZENOD AVENUE NW6 4LR	Date:	No.: PP-05	
	Client:	Drawing Title: EXISTING AND PROPOSED SIDE ELEVATIONS	Scale @A1: 1:50	Rev: Page:	

EXISTING &
AS APPROVED

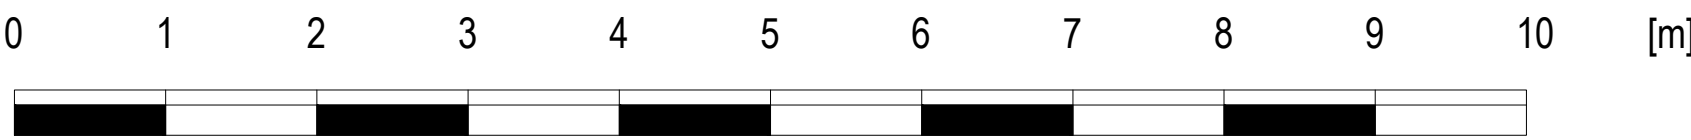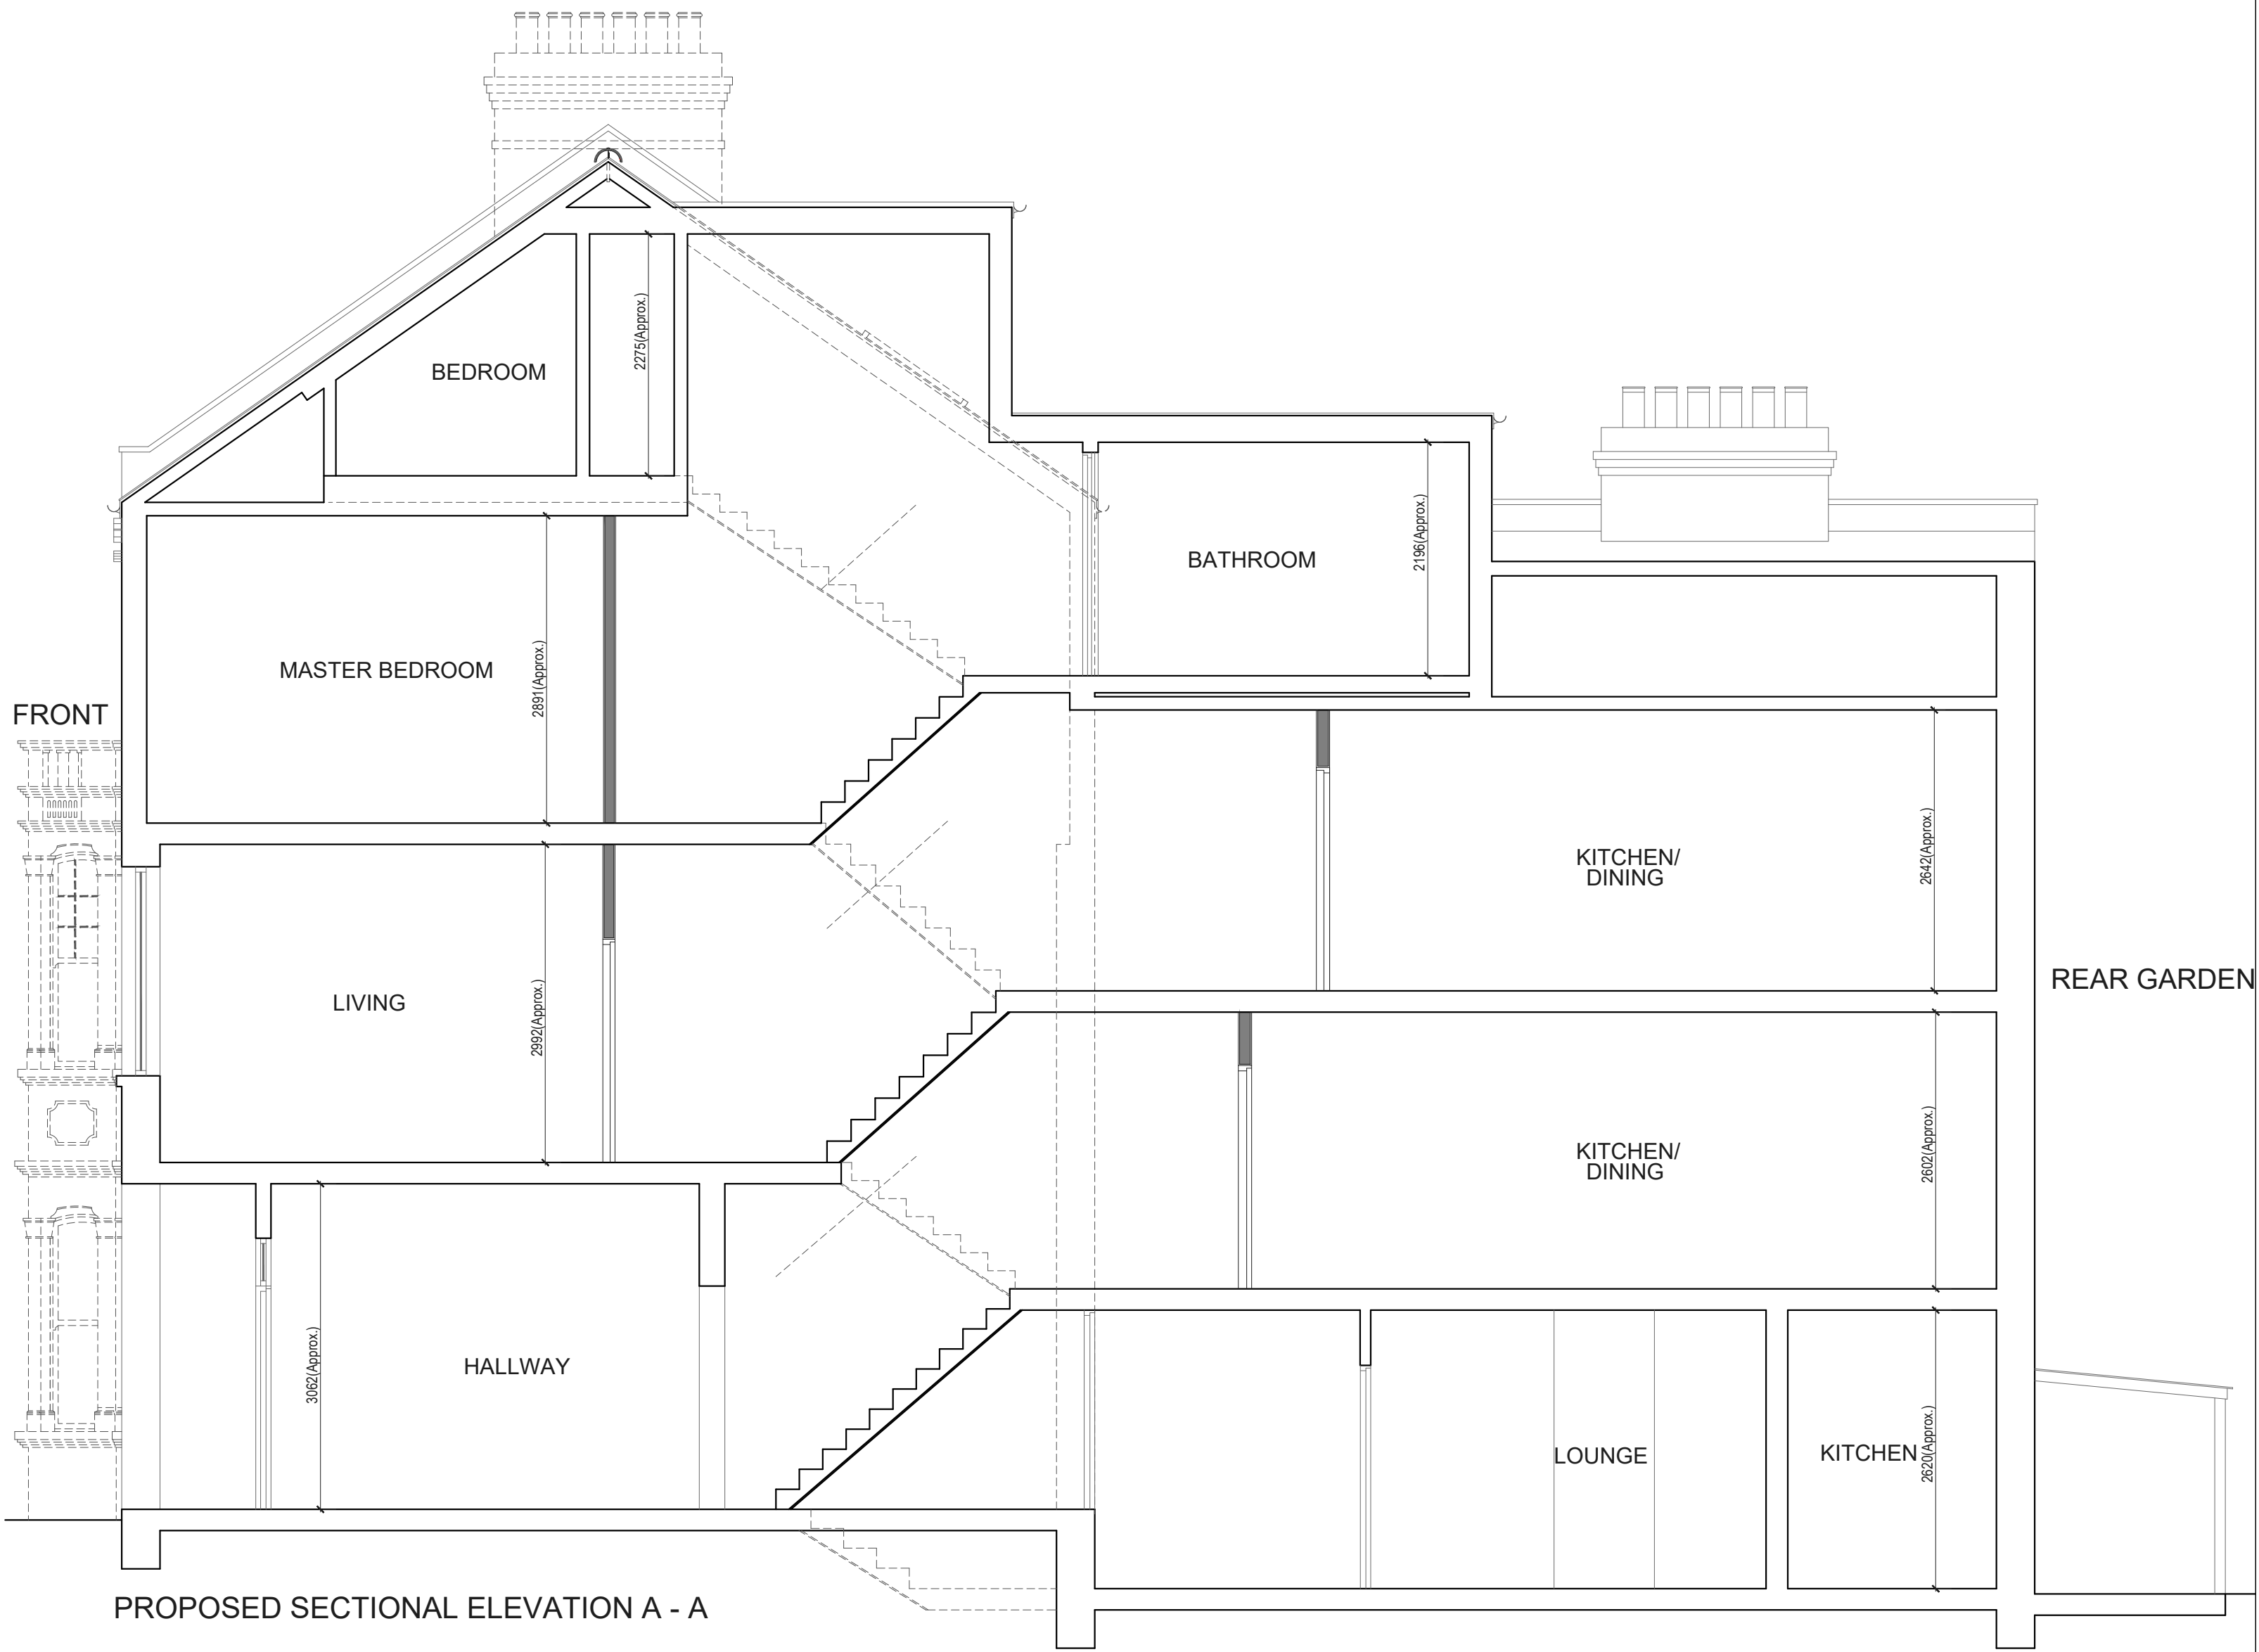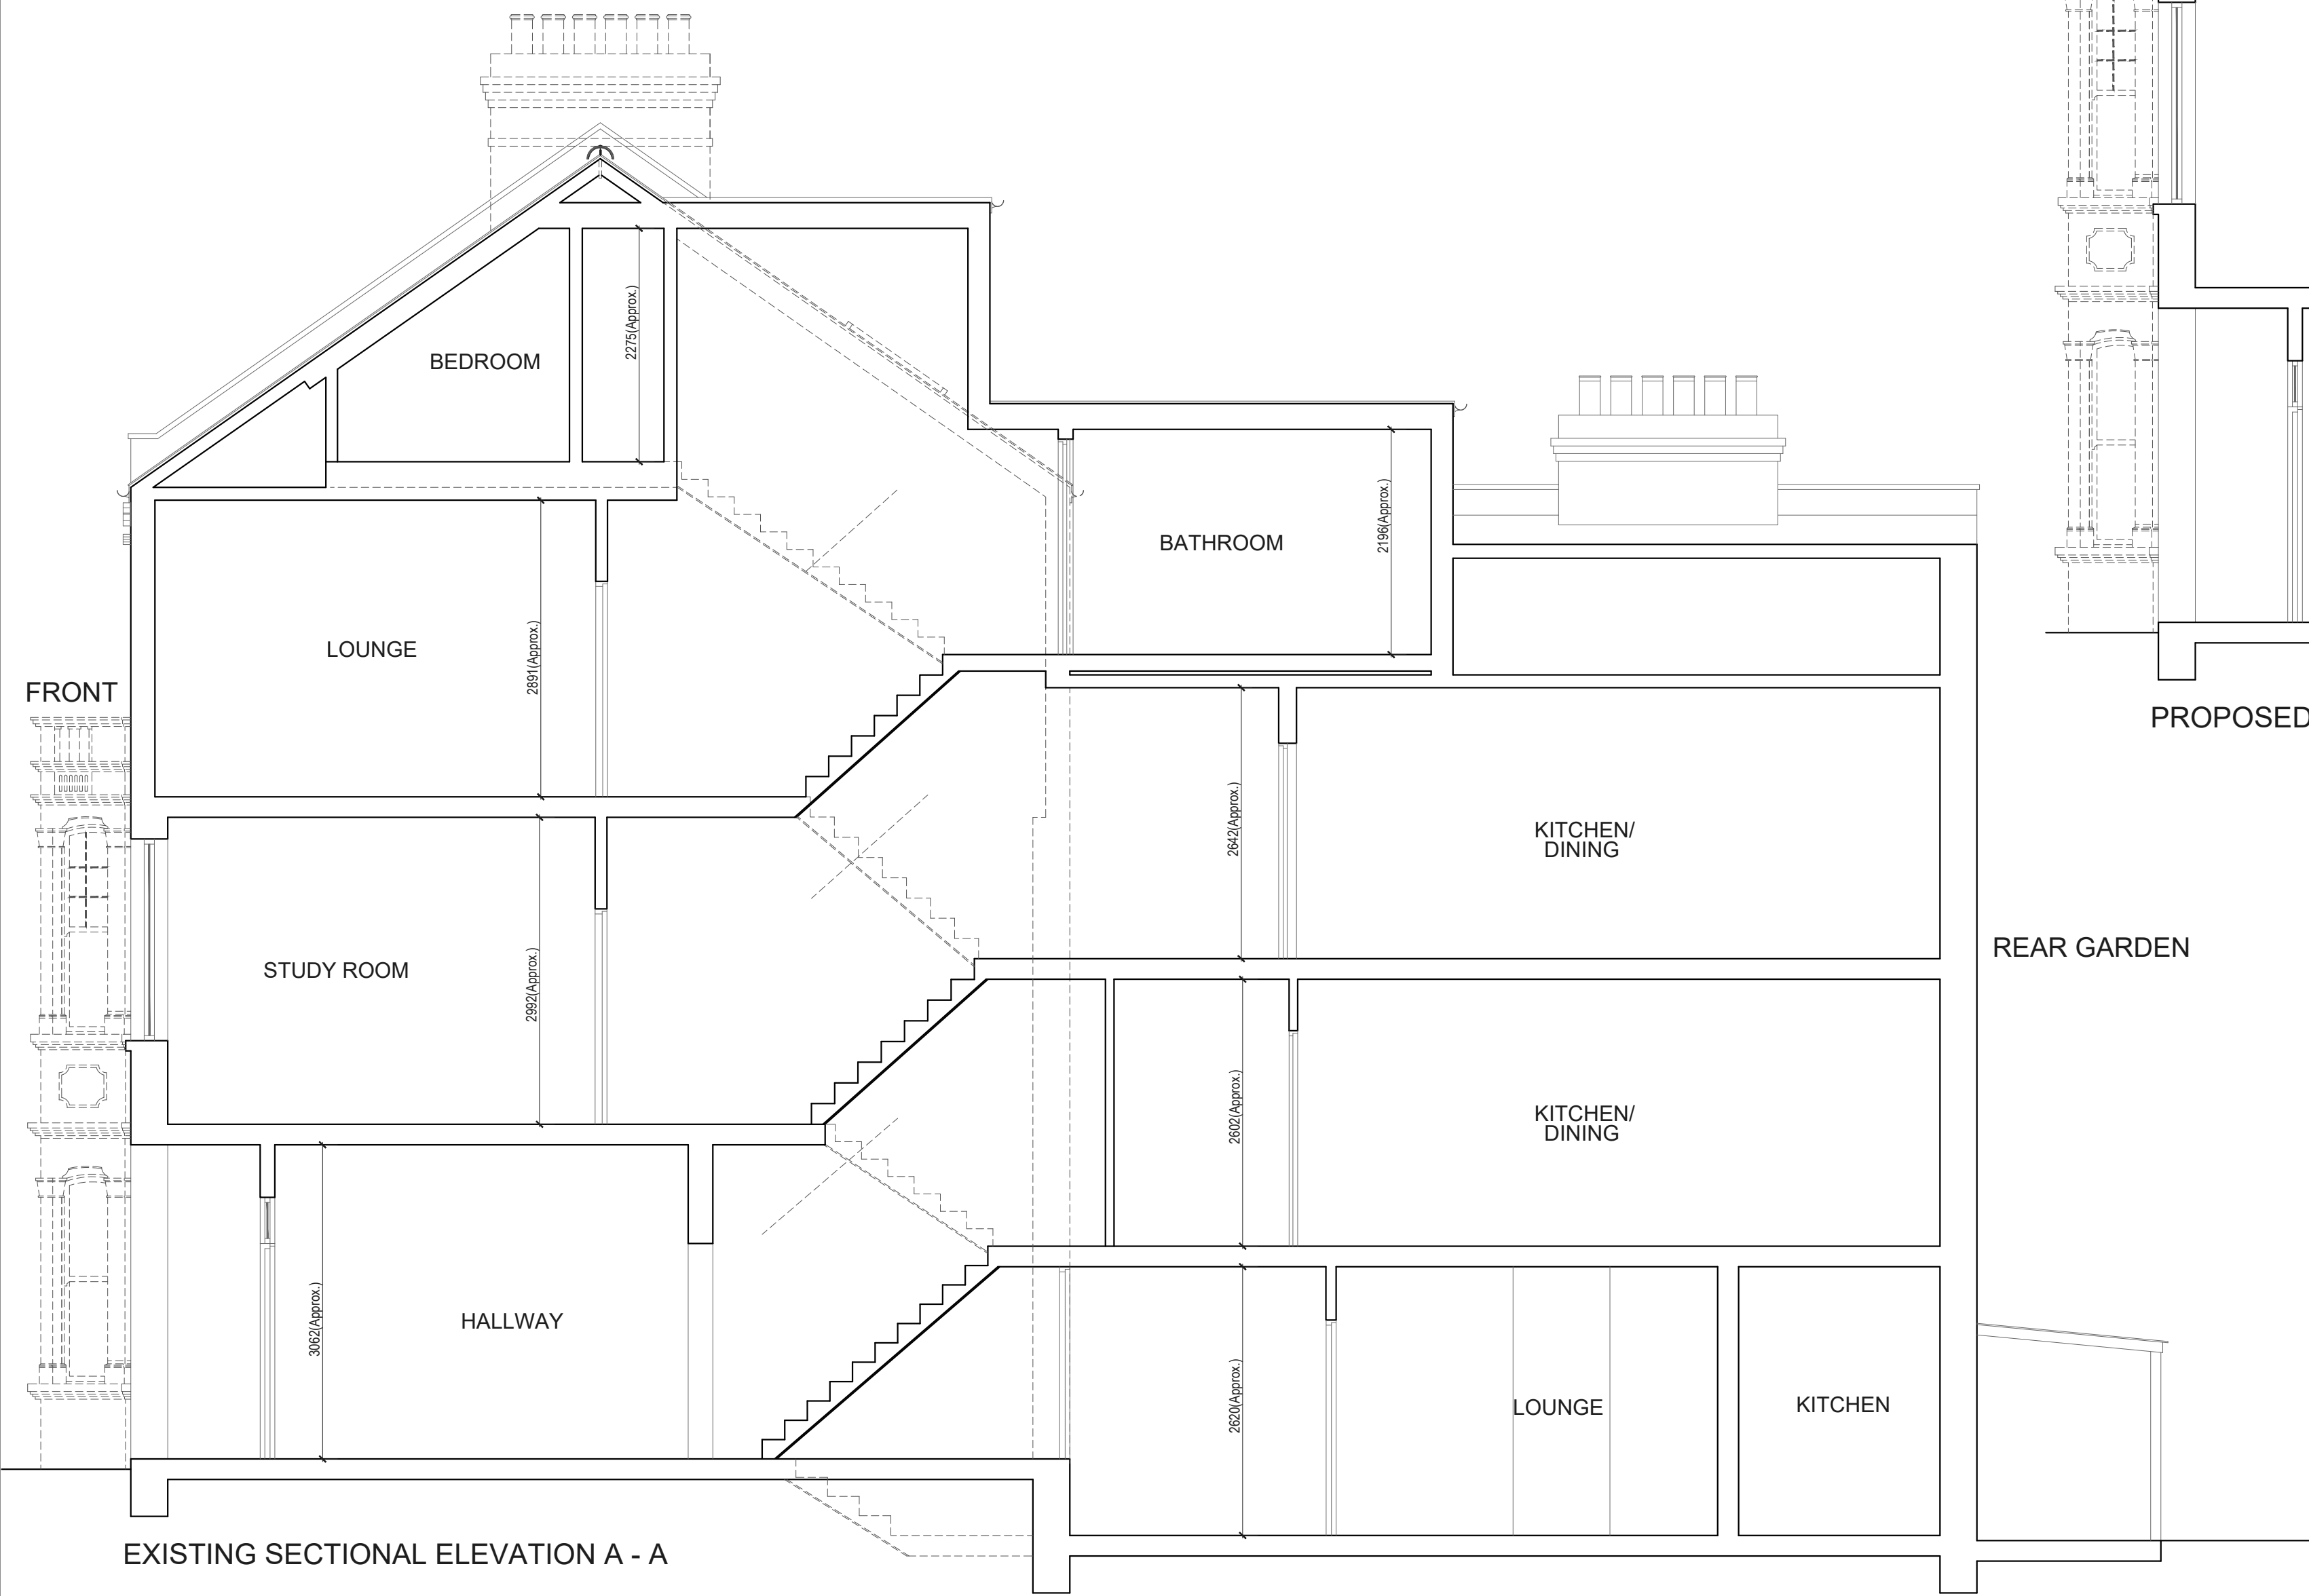

Drawn by:
ZF

Client:

Project:
32 MAZENOD AVENUE NW6 4LR

Drawing Title:
SECTION A-A

Date:

Scale @A1:
1:50


No.:
PP-06

Rev:


Page:



EXISTING &
AS APPROVED

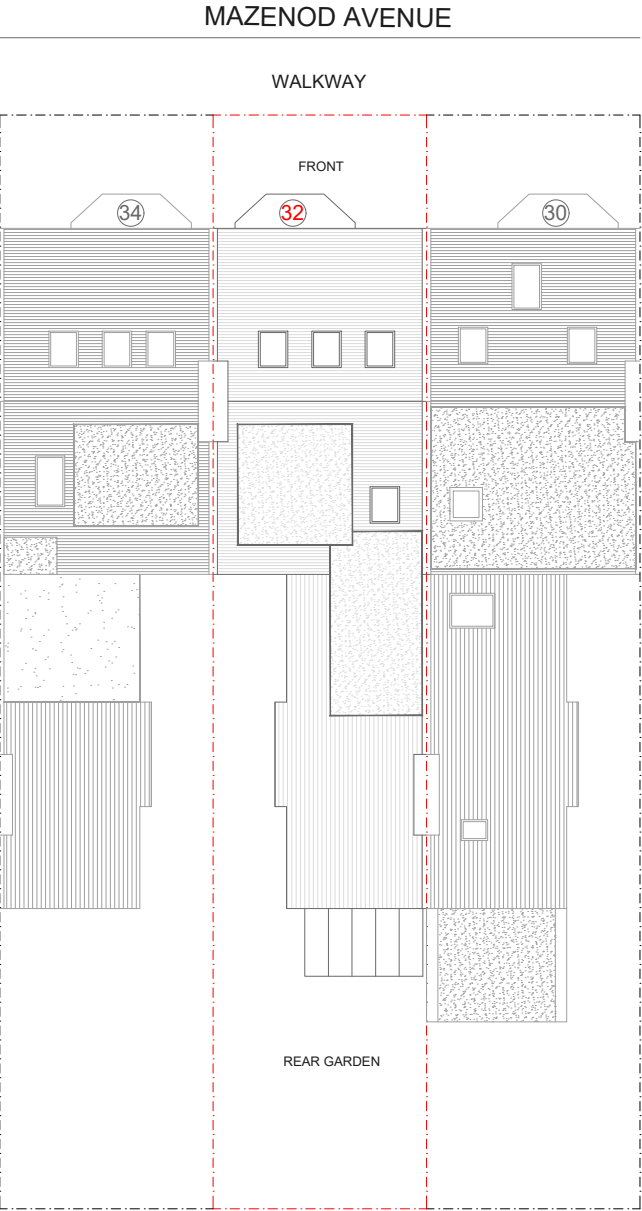

EXISTING SITE/BLOCK PLAN

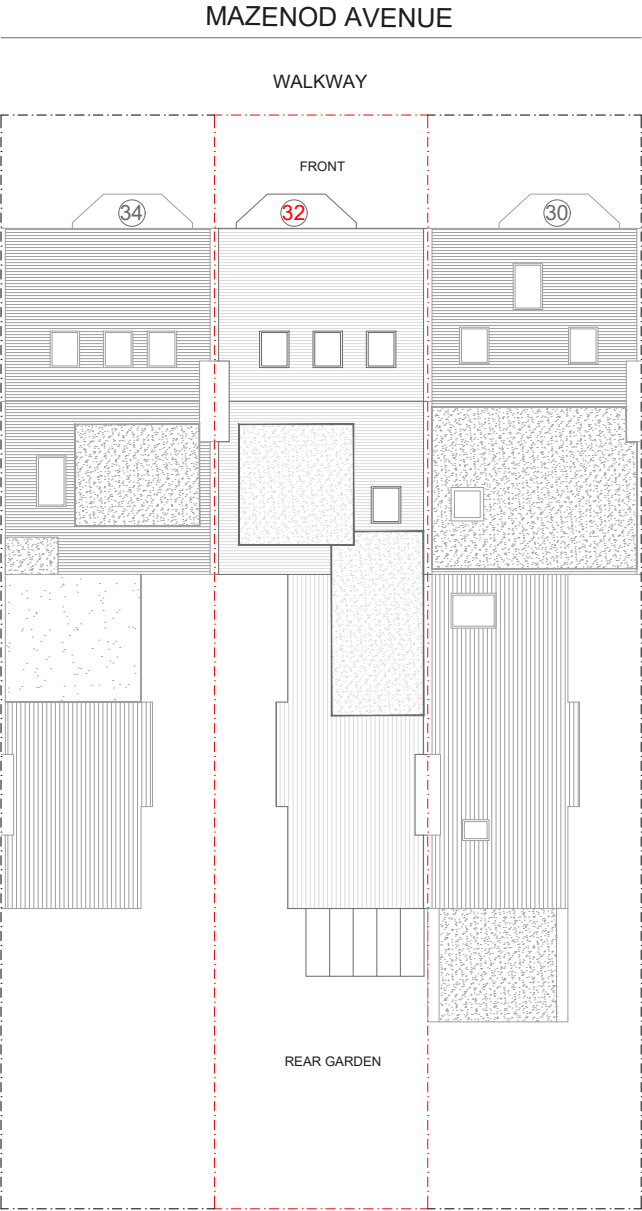

PROPOSED SITE/BLOCK PLAN



Drawn by:
ZF

Client:

Project:
32 MAZENOD AVENUE NW6 4LR

Drawing Title:
SITE PLAN

Date:
24.10.2024

Scale @A3:
1:200

No.:
PP-07

Rev:
Page:

