


Rear wall bows out Ground to 3rd

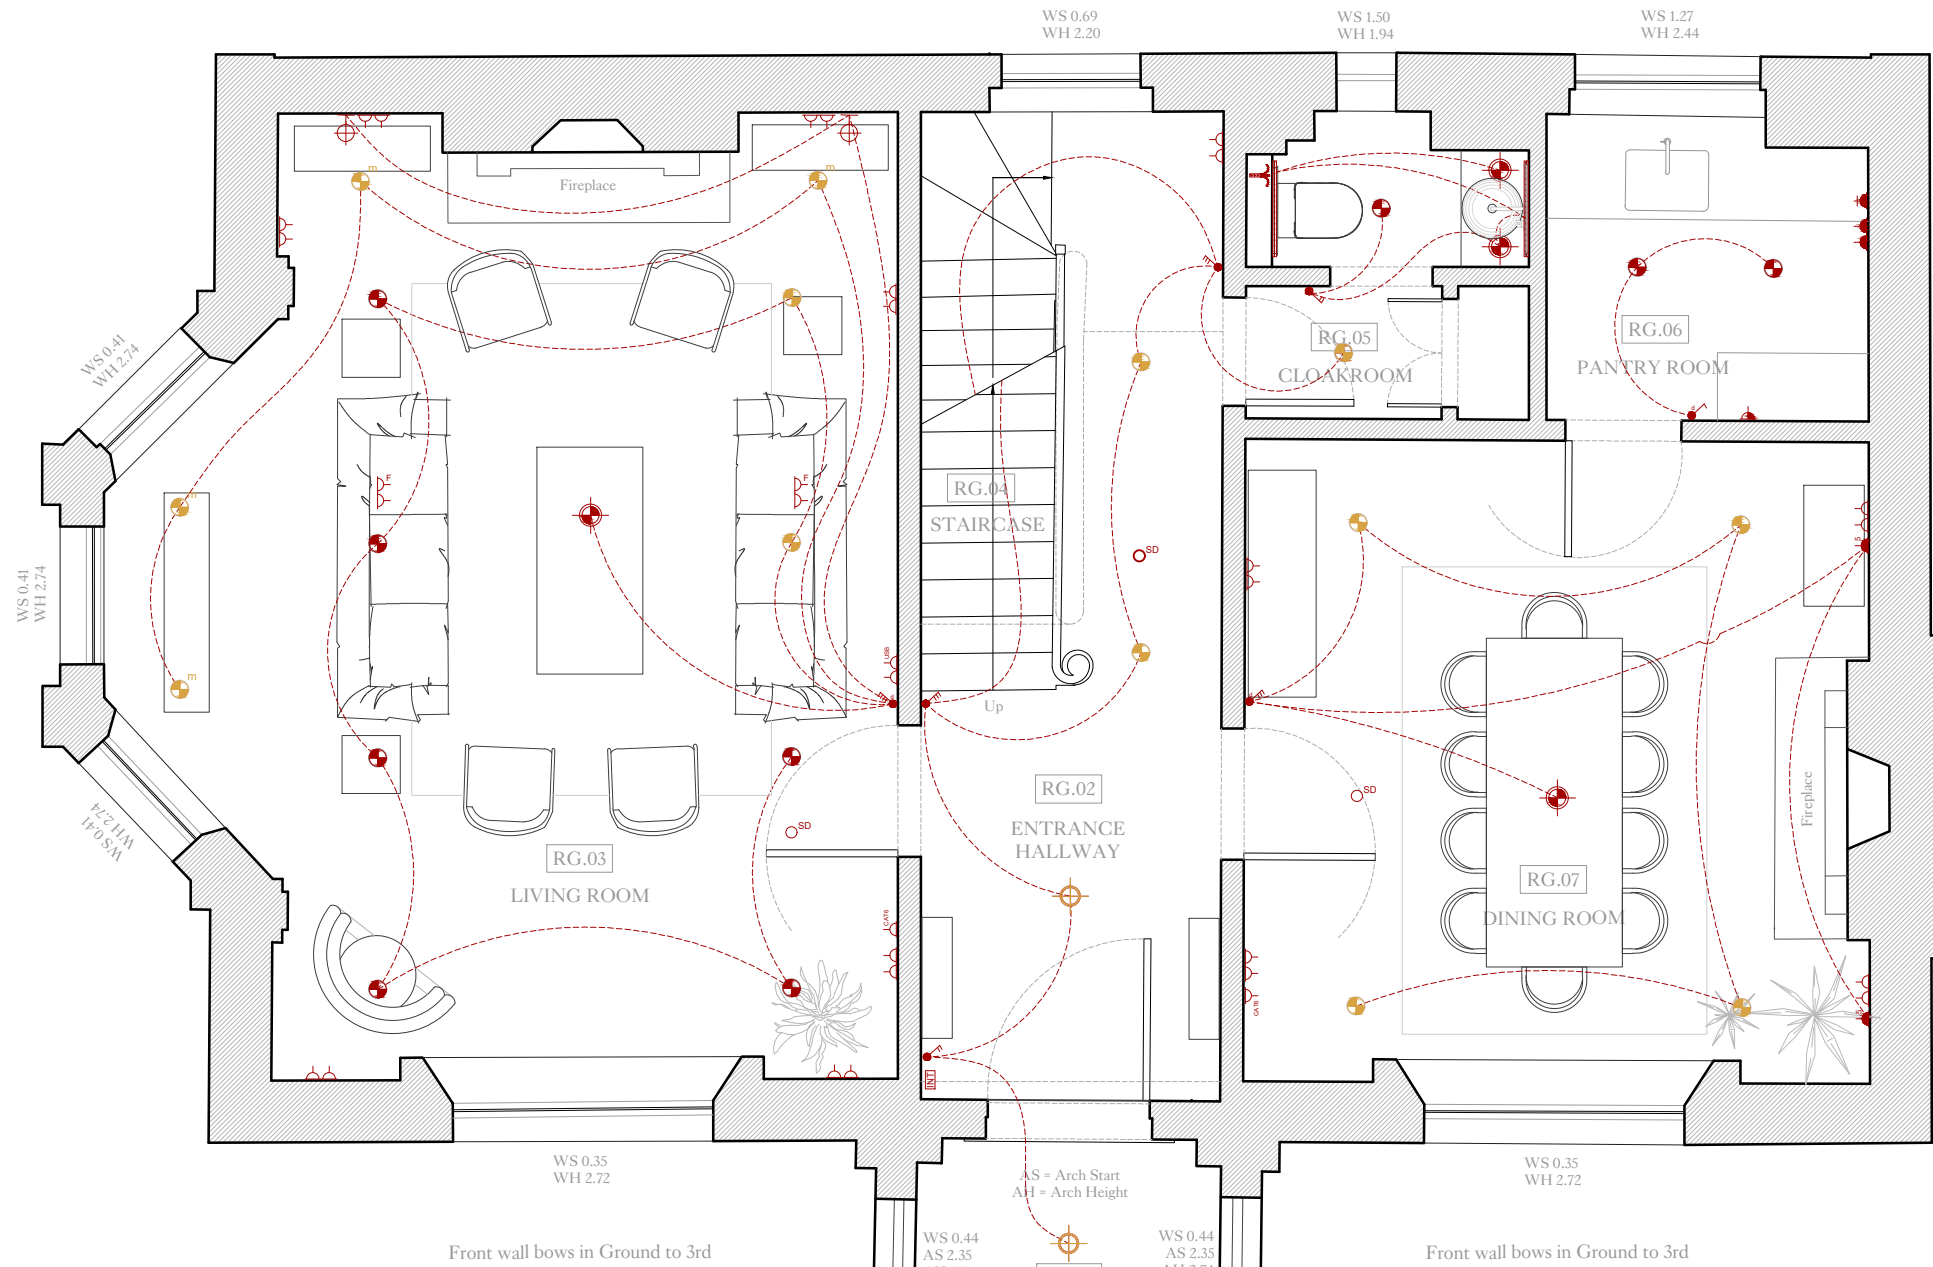

Front wall bows in Ground to 3rd

Front wall bows in Ground to 3rd

COLOUR LEGEND

- NEW POSITION/ NEW FITTING
- EXISTING POSITION/ NEW FITTING
- EXISTING TO BE MOVED or REMOVED

LEGEND - LIGHTING

LEGEND - ELECTRICAL

general notes

THIS DRAWING IS COPYRIGHT OF CLIFTON INTERIORS LTD. THIS DRAWING MUST BE READ IN CONJUNCTION WITH THE DESIGNER'S RISK ASSESSMENT, SPECIFICATION AND ALL OTHER RELEVANT DOCUMENTATION AND DRAWINGS. CLIFTON INTERIORS LTD ACCEPT NO LIABILITY FOR ANY EXPENSE, LOSS OR DAMAGE OF WHATSOEVER NATURE AND HOWEVER ARISING FROM ANY VARIATION MADE TO THIS DRAWING OR IN THE EXECUTION OF THE WORK TO WHICH IT RELATES WHICH HAS NOT BEEN REFERRED TO THEM AND THEIR APPROVAL OBTAINED.

DO NOT SCALE FROM THIS DRAWING OR THE COMPUTER DIGITAL DATA, ONLY FIGURED DIMENSIONS ARE TO BE USED.

IF IN DOUBT ASK.

purpose of issue

PLANNING

notes

* do not scale from this drawing.
* check all dimensions on site.

revisions

A - 11/10/2024

project name		drawing title	
5 PRINCE ALBERT ROAD		GROUND FLOOR - SMALL POWER PLAN	
proposed interior layout			
scale 1:50@A3	date 23/09/2024	project ref. 2401	drawing no. 151
drawn by AG	checked RW	revision A	

Clifton Interiors
Est. 1986

168 Regents Park Road
London NW1 8XN
020 7586 5533
www.cliftoninteriors.com