


© BOWKER SADLER PARTNERSHIP LIMITED
 ■ THIS DRAWING IS THE SUBJECT OF COPYRIGHT WHICH VESTS IN BOWKER SADLER PARTNERSHIP LIMITED. IT IS AN INFRINGEMENT OF COPYRIGHT TO REPRODUCE THIS DRAWING, BY WHATEVER MEANS, INCLUDING ELECTRONIC, WITHOUT THE EXPRESS WRITTEN CONSENT OF BOWKER SADLER PARTNERSHIP LIMITED WHICH RESERVES ALL ITS RIGHTS
 BOWKER SADLER PARTNERSHIP LIMITED ASSERTS ITS RIGHTS TO BE IDENTIFIED AS THE AUTHOR OF THIS DESIGN
 ■ REPORT ERRORS & OMISSIONS TO ARCHITECT.
 ■ CHECK ALL DIMENSIONS ON SITE.
 ■ DRAWING TO BE READ IN CONJUNCTION WITH THE HEALTH AND SAFETY PLAN AND ALL RELEVANT RISK ASSESSMENTS

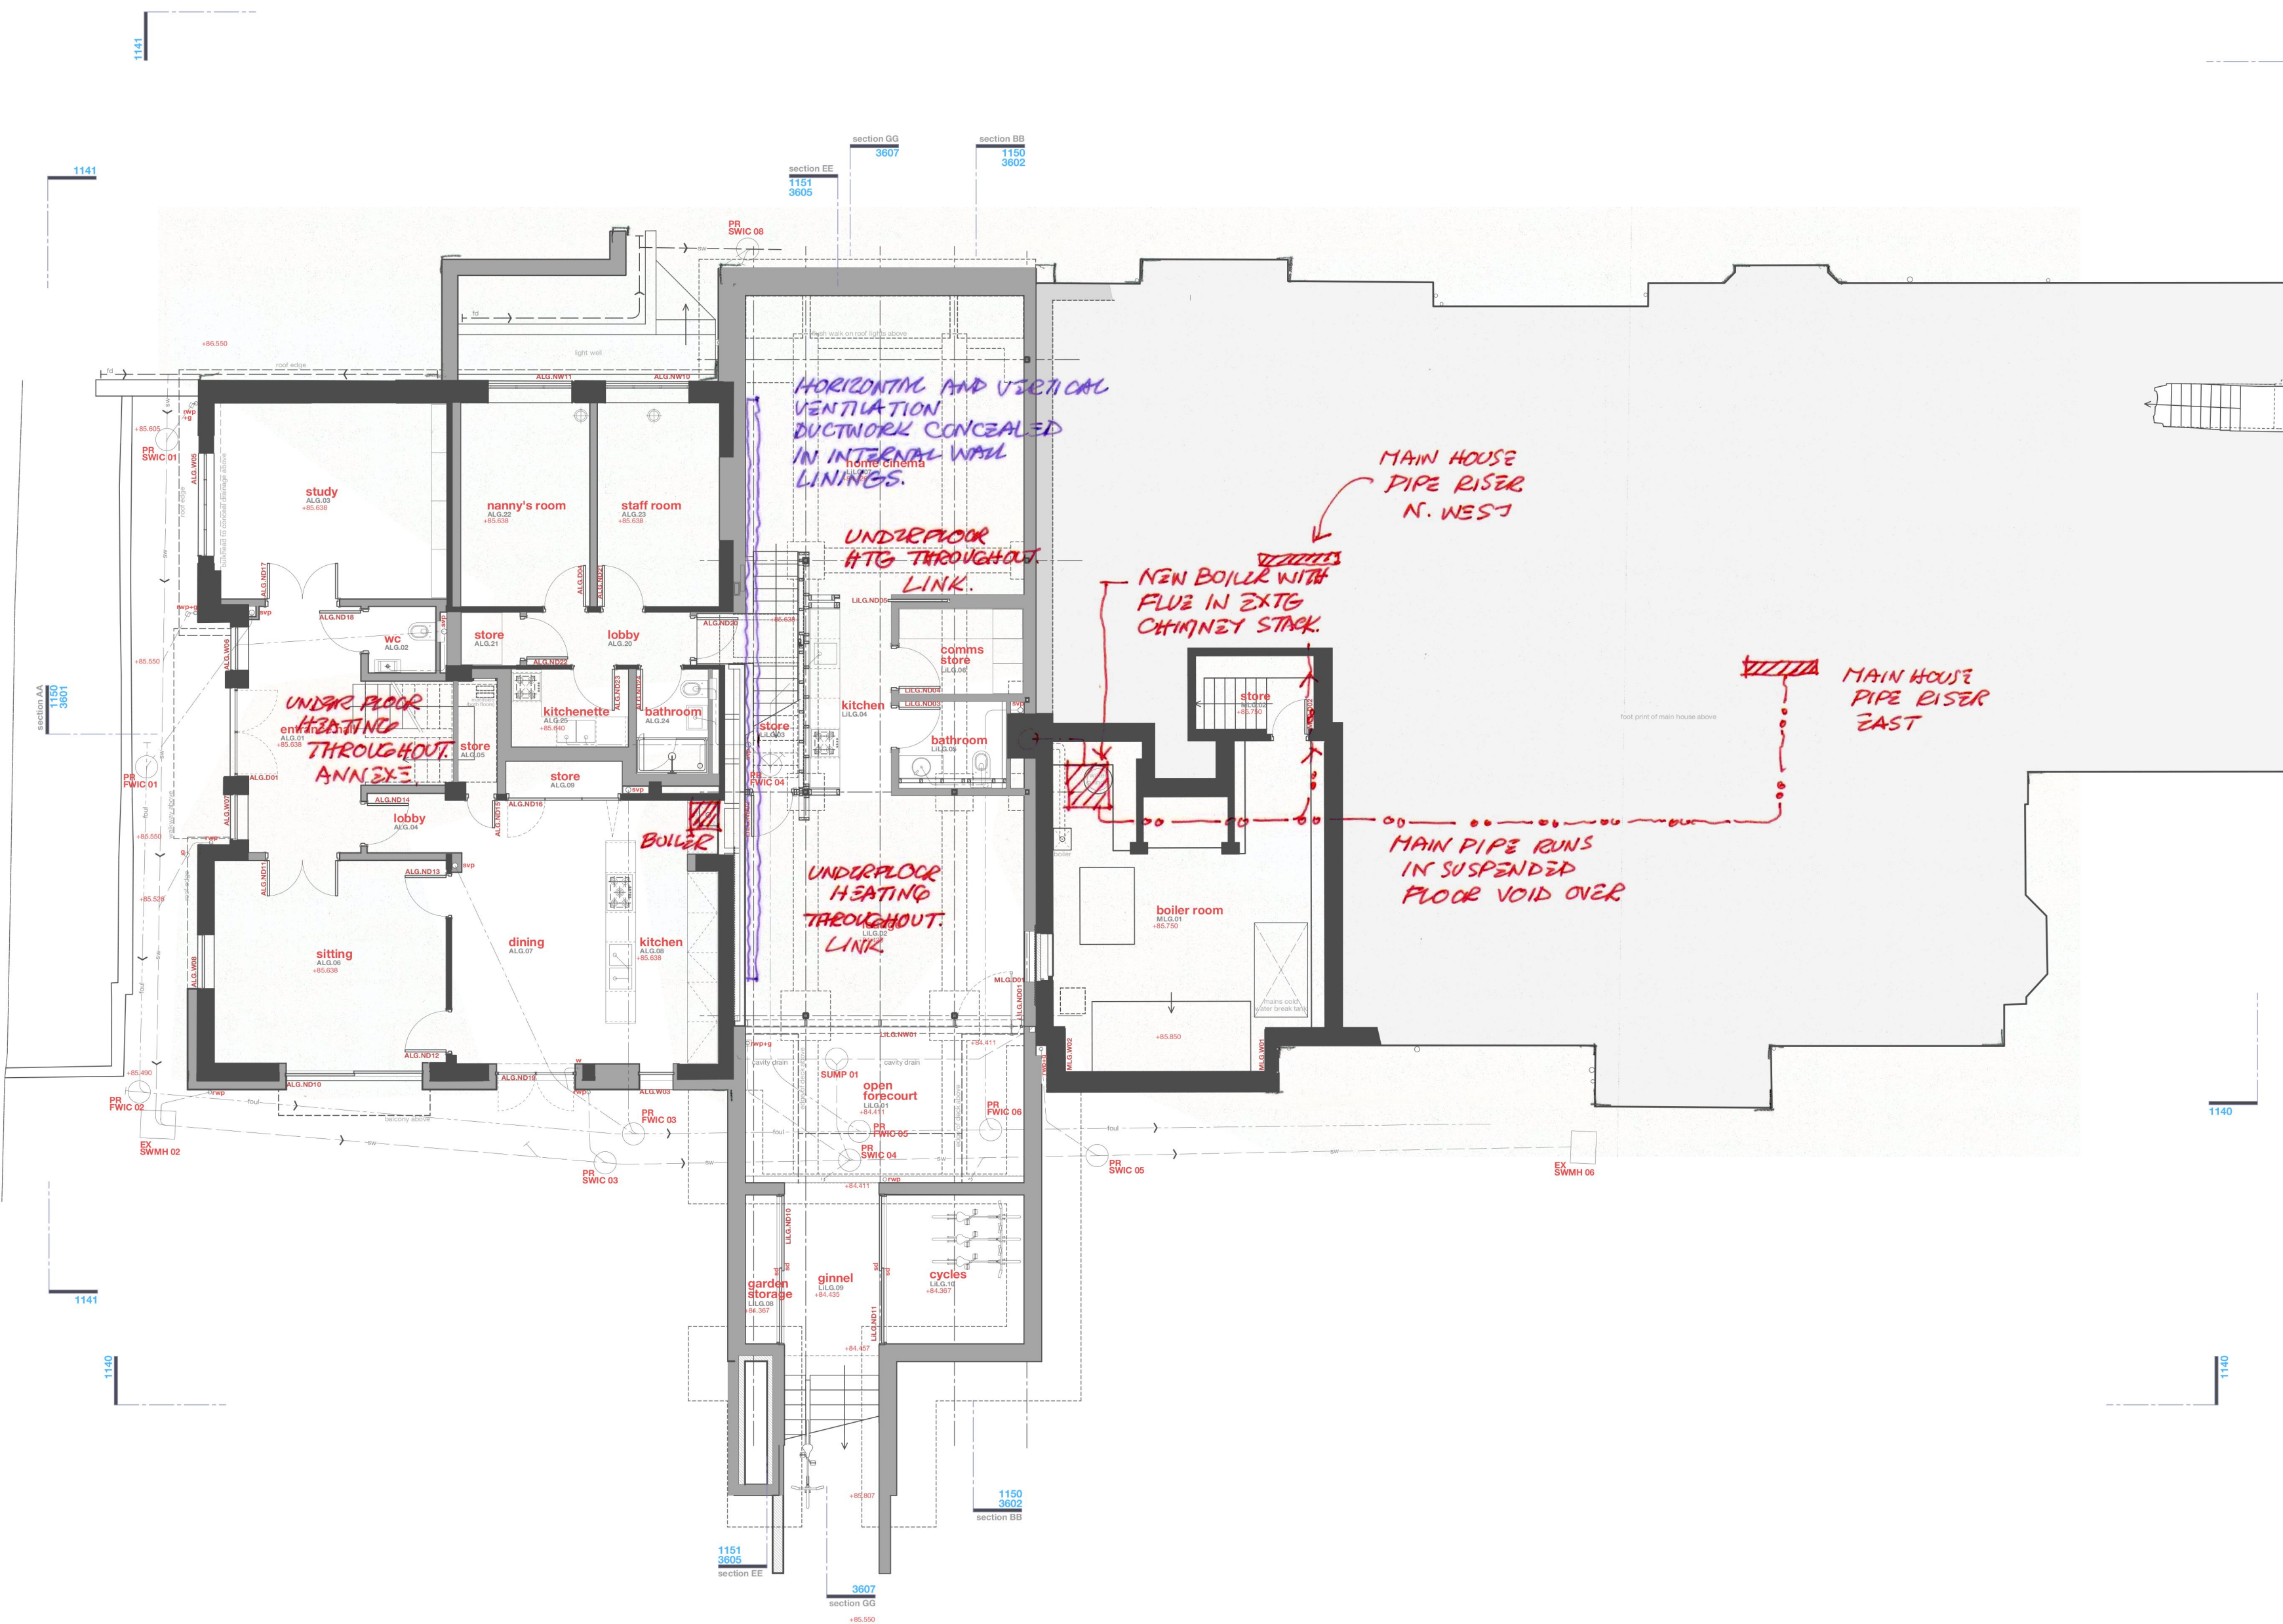

KEY TO SYMBOLS.

	NEW HEATING PLANT AND DUCTWORK
	MAIN PIPE RUNS IN VOIDS.
	VENTILATION DUCTWORK AND PLANT (IN NEW LINK ONLY)
	UFH UNDER FLOOR HEATING
	EUPH ELECTRIC UNDER FLOOR HEATING.

REV. DATE DRN. CHKD

PROJECT
The Hoo,
17 Lyndhurst Gardens,
Hampstead, London
 Returning A Grand Victorian House To Private Domestic Accommodation
 NW3 5NU

CLIENT
Mr and Mrs Yu
 REPRESENTED BY
JAGA Developments (London)

DRAWING
Indicative Services Distribution
Lower Ground Floor

SCALE	SHEET SIZE	DRAWN	CHECKED	DATE
1:100	@ A2	GMcG WDH		Sep 2020

BOWKER SADLER ARCHITECTURE
 A: Hatherlow House, Hatherlow, Romiley, Stockport SK6 3DY
 T: 0161 406 7333
 E: bsp@bowker-sadler.co.uk
 W: www.bowker-sadler.co.uk

JOB No	DRAWING No	REVISION
19013	4500	B
STATUS		
FOR PLANNING		