


© BOWKER SADLER PARTNERSHIP LIMITED
 ■ THIS DRAWING IS THE SUBJECT OF COPYRIGHT WHICH VESTS IN BOWKER SADLER PARTNERSHIP LIMITED. IT IS AN INFRINGEMENT OF COPYRIGHT TO REPRODUCE THIS DRAWING, BY WHATEVER MEANS, INCLUDING ELECTRONIC, WITHOUT THE EXPRESS WRITTEN CONSENT OF BOWKER SADLER PARTNERSHIP LIMITED WHICH RESERVES ALL ITS RIGHTS
 BOWKER SADLER PARTNERSHIP LIMITED ASSERTS ITS RIGHTS TO BE IDENTIFIED AS THE AUTHOR OF THIS DESIGN

■ REPORT ERRORS & OMISSIONS TO ARCHITECT.
 ■ CHECK ALL DIMENSIONS ON SITE.
 ■ DRAWING TO BE READ IN CONJUNCTION WITH THE HEALTH AND SAFETY PLAN AND ALL RELEVANT RISK ASSESSMENTS

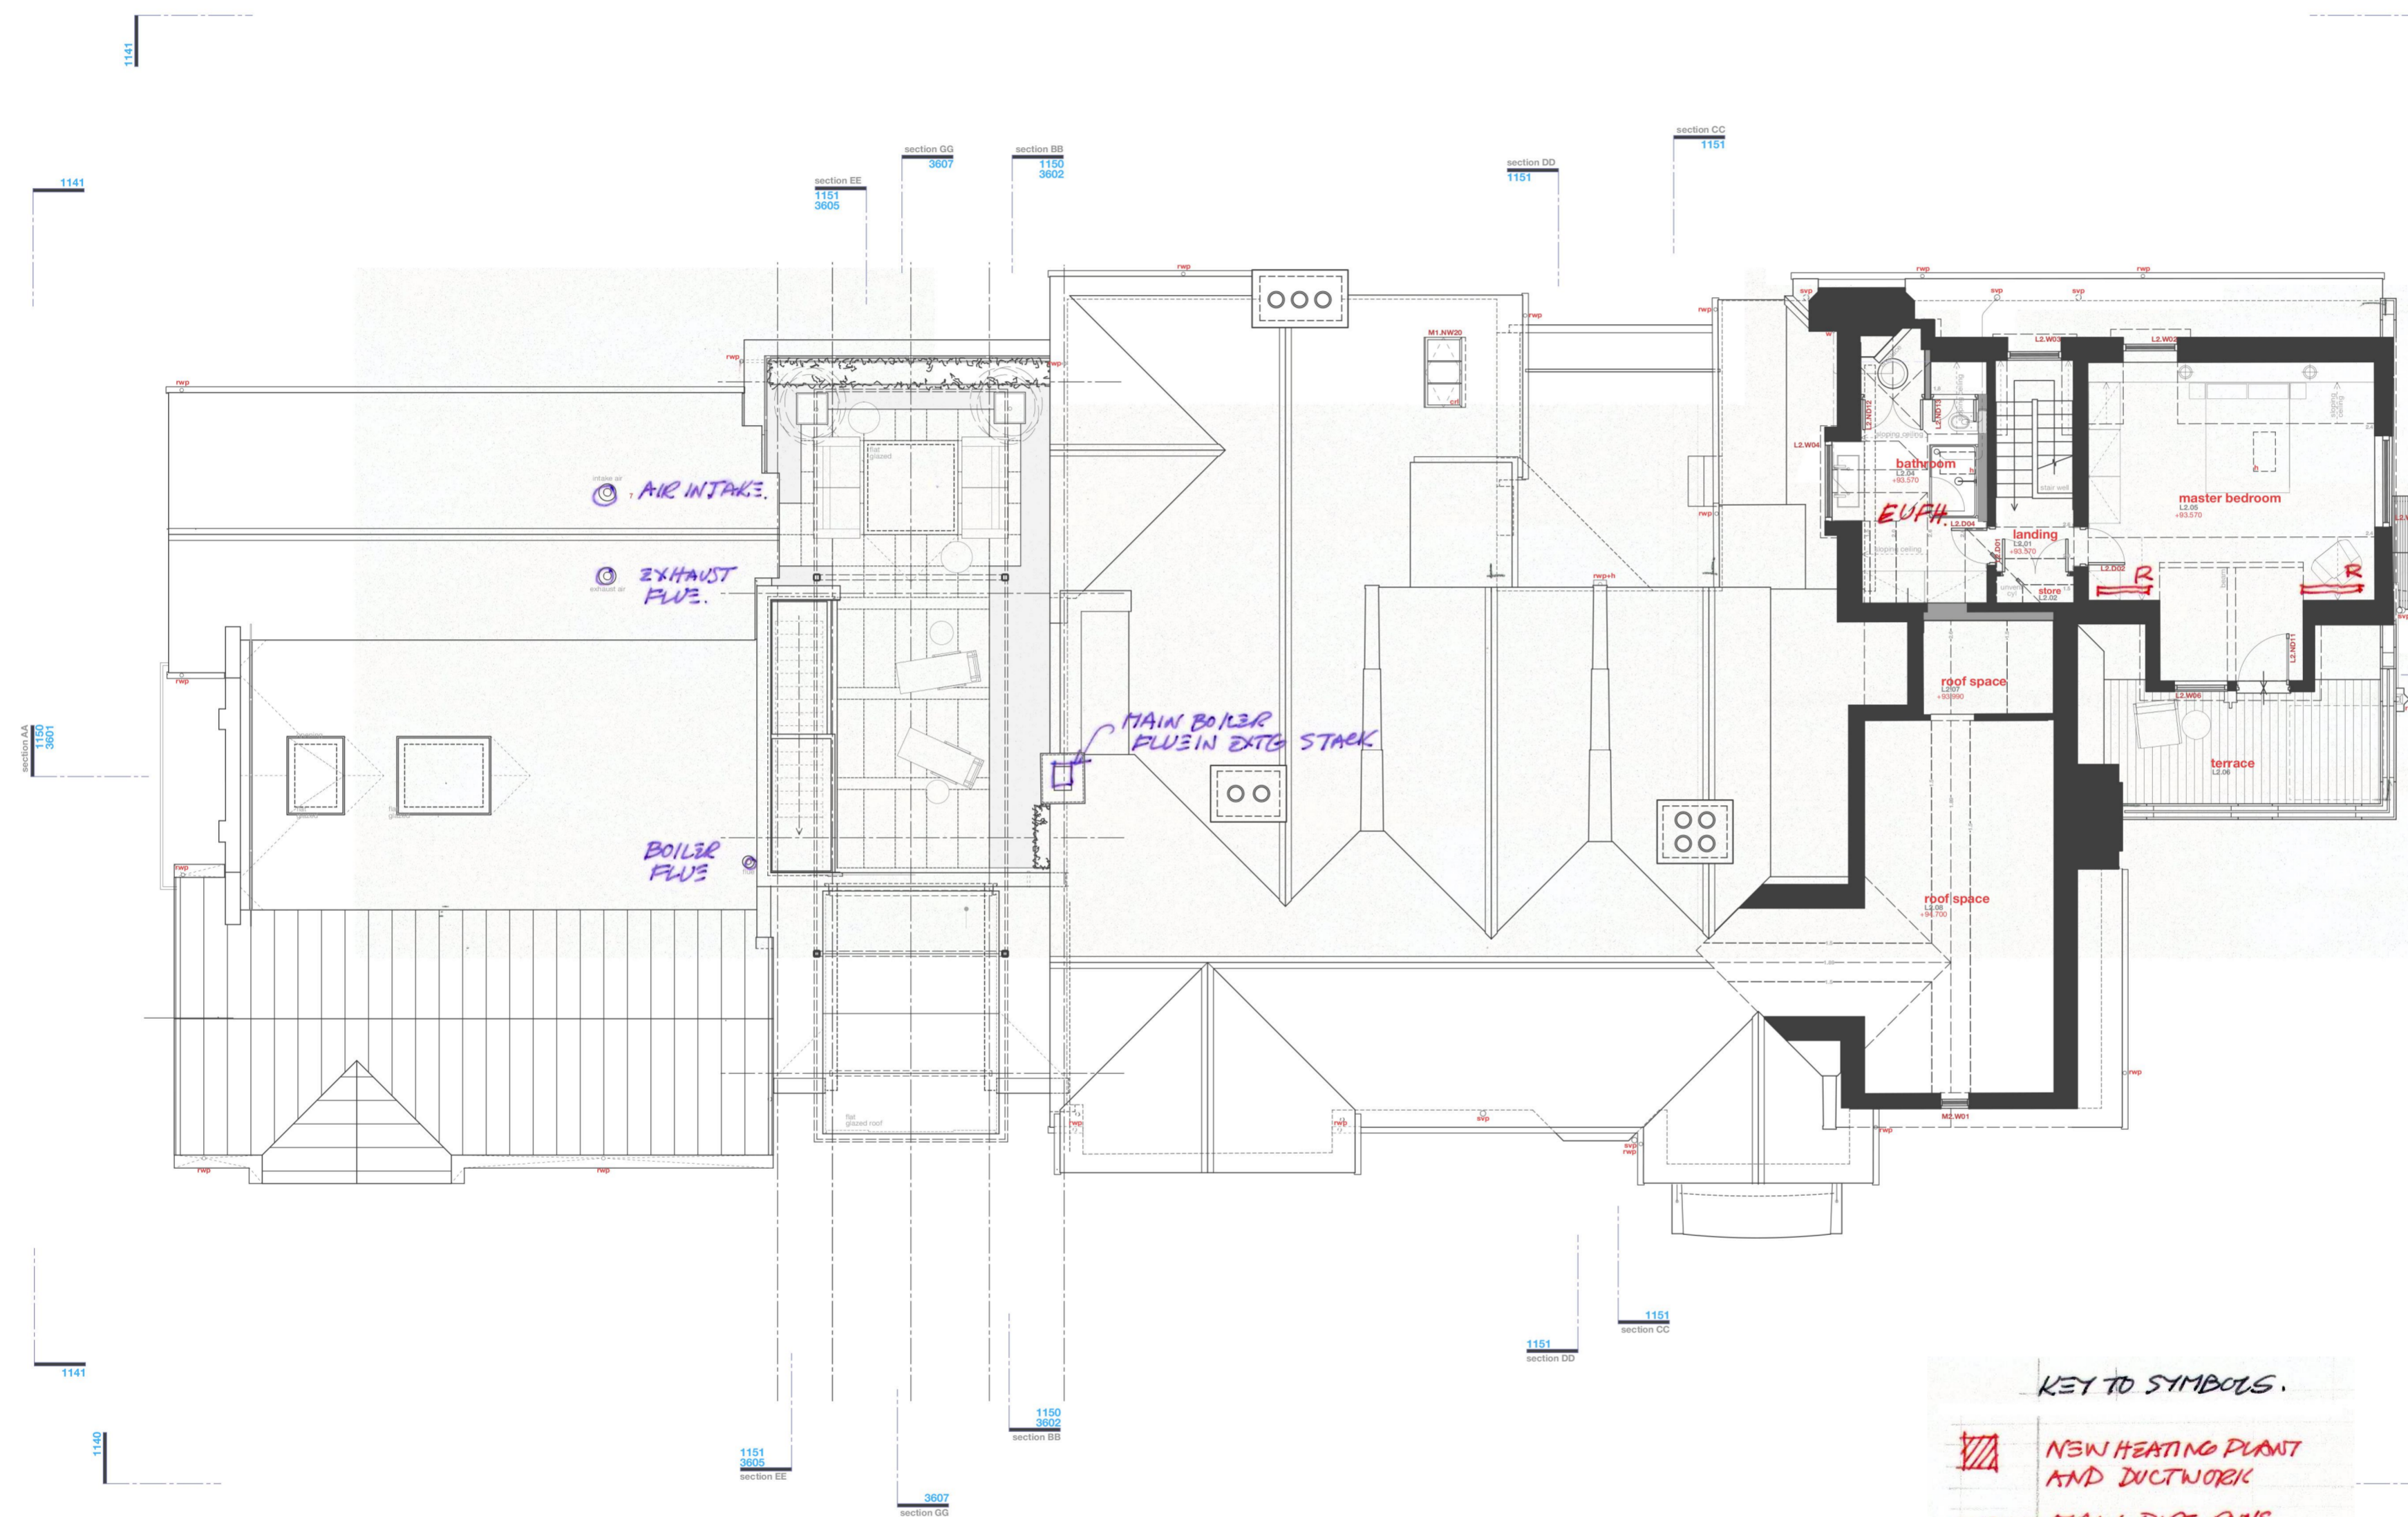

REV.	DATE	DRN.	CHKD.
------	------	------	-------

PROJECT
**The Hoo,
 17 Lyndhurst Gardens,
 Hampstead, London**
 Returning A Grand Victorian House To Private Domestic Accommodation
 NW3 5NU

CLIENT
Mr and Mrs Yu
 REPRESENTED BY
JAGA Developments (London)

DRAWING
**Indicative Services Distribution
 Second Floor**

SCALE	SHEET SIZE	DRAWN	CHECKED	DATE
1:100	@ A2	WDH		Sep 2020

KEY TO SYMBOLS.

NEW HEATING PLANT AND DUCTWORK

MAIN PIPE RUNS IN VOIDS.

VENTILATION DUCTWORK AND PLANT (IN NEW LINK ONLY).

UFH UNDER FLOOR HEATING

EUPH ELECTRIC UNDER FLOOR HEATING.

BOWKER SADLER ARCHITECTURE
 A: Hatherlow House, Hatherlow, Romiley, Stockport SK6 3DY
 T: 0161 406 7333
 E: bsp@bowker-sadler.co.uk
 W: www.bowker-sadler.co.uk

JOB No	DRAWING No	REVISION
19013	4503	B
STATUS FOR PLANNING		