


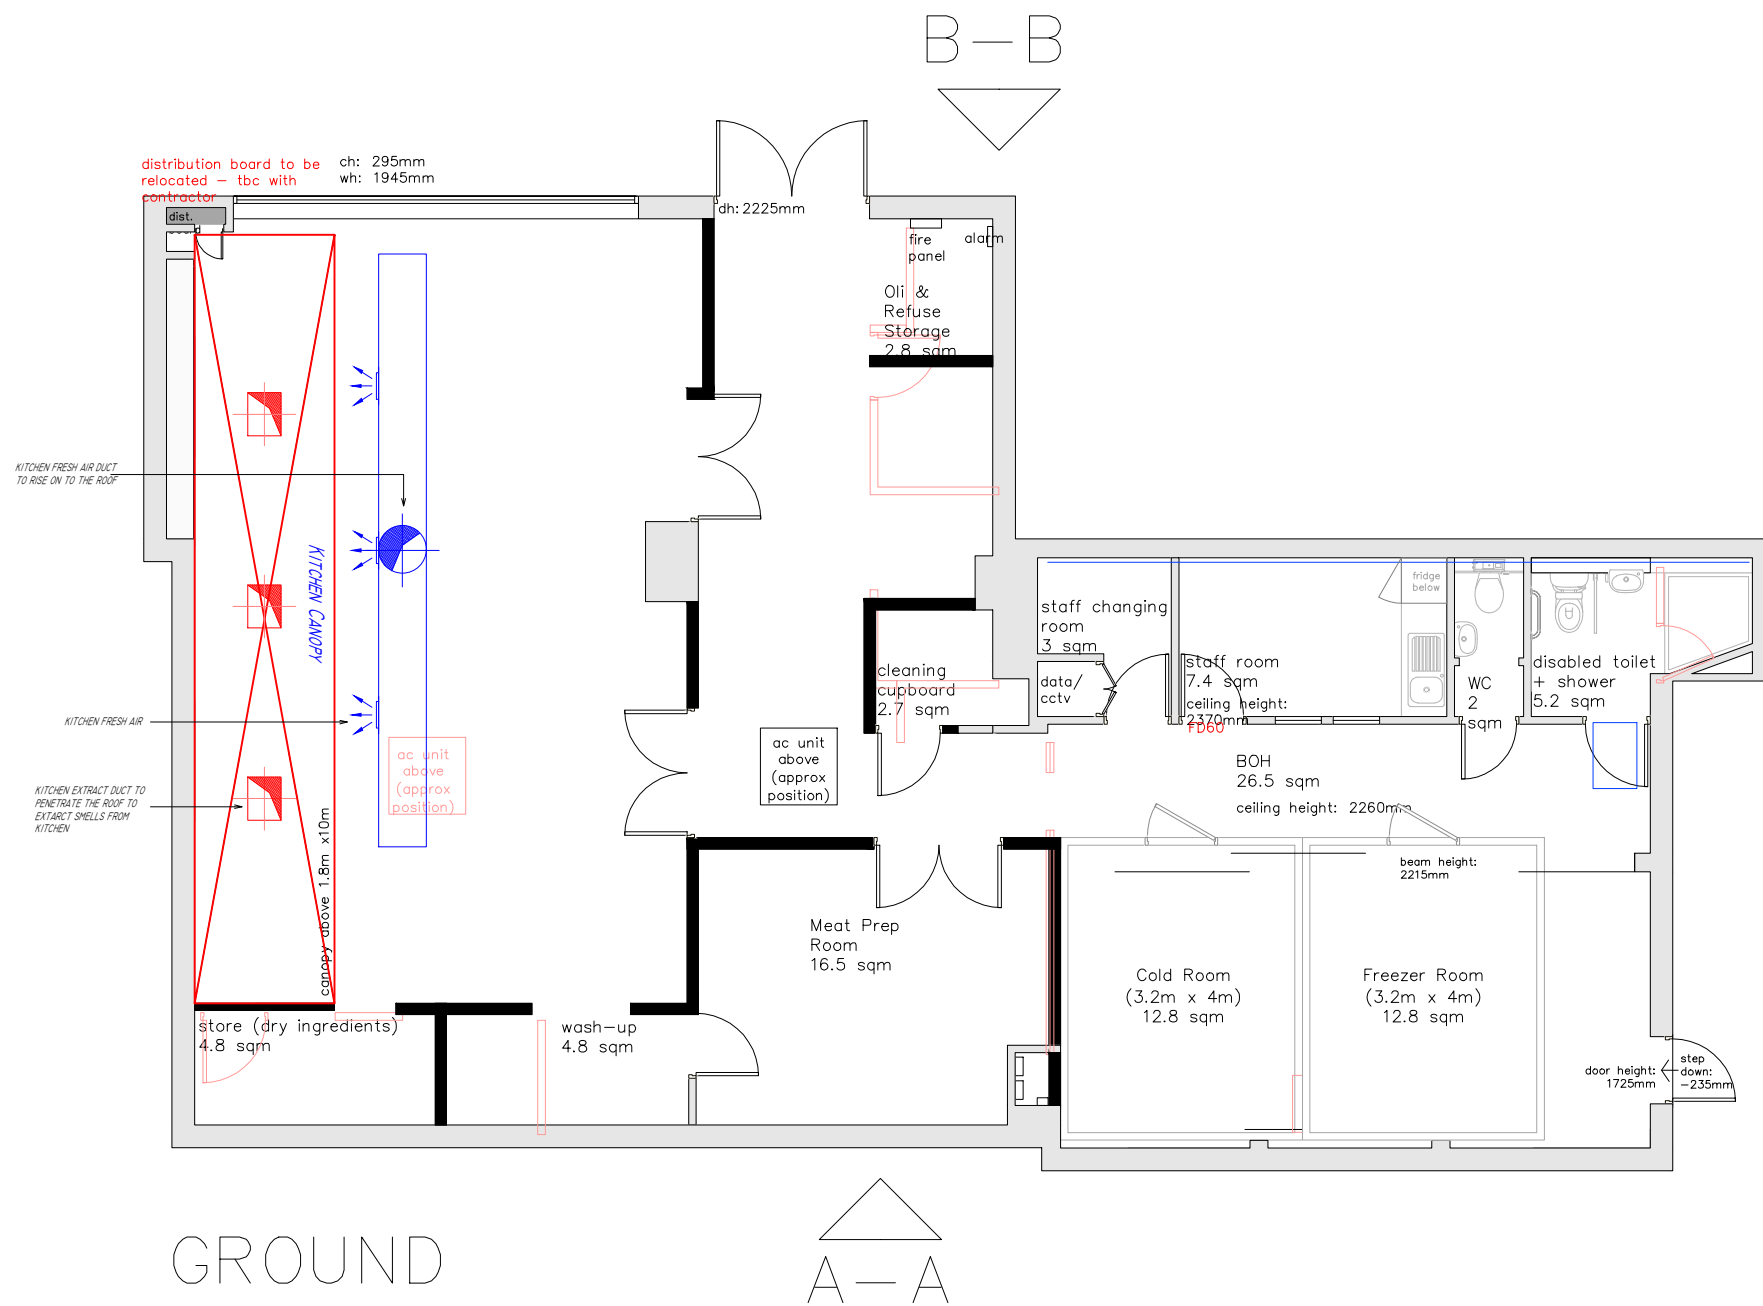

Note:

Project Title:
1A Hawley Rd, London -
Proposed HVAC Plan

Drawing Number:
1A Hawley Rd, London - 01 -
Proposed HVAC Plan

Scale:
1:100 @ A3

Date:
20/08//2024

**FAN
RESCUE**

Commercial kitchen and HVAC
System Specialists
Established 2005

Ability House, Unit 129,
121 Brooker Road,
Waltham Abbey EN9 1JH
Tel: +44 (0) 20 33082 936
www.fanrescue.co.uk

1:100

