


EXISTING

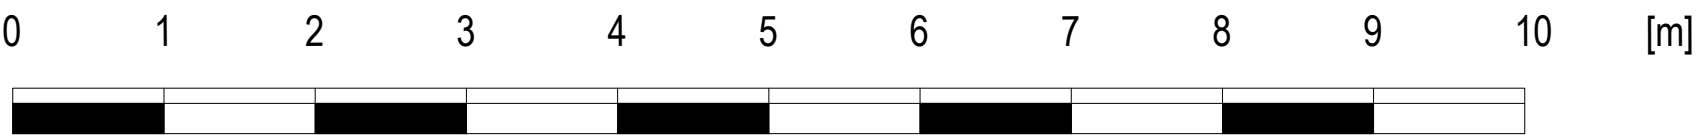

Drawn by:
A-A

Client:
LIA BROWN

Project:
30 MACKESON ROAD LONDON NW3 2LT

Drawing Title:
EXISTING PLANS

Date:
04.12.2024

Scale @A1:
1:50





No.:
PP-01

Rev:

Page:



PROPOSED

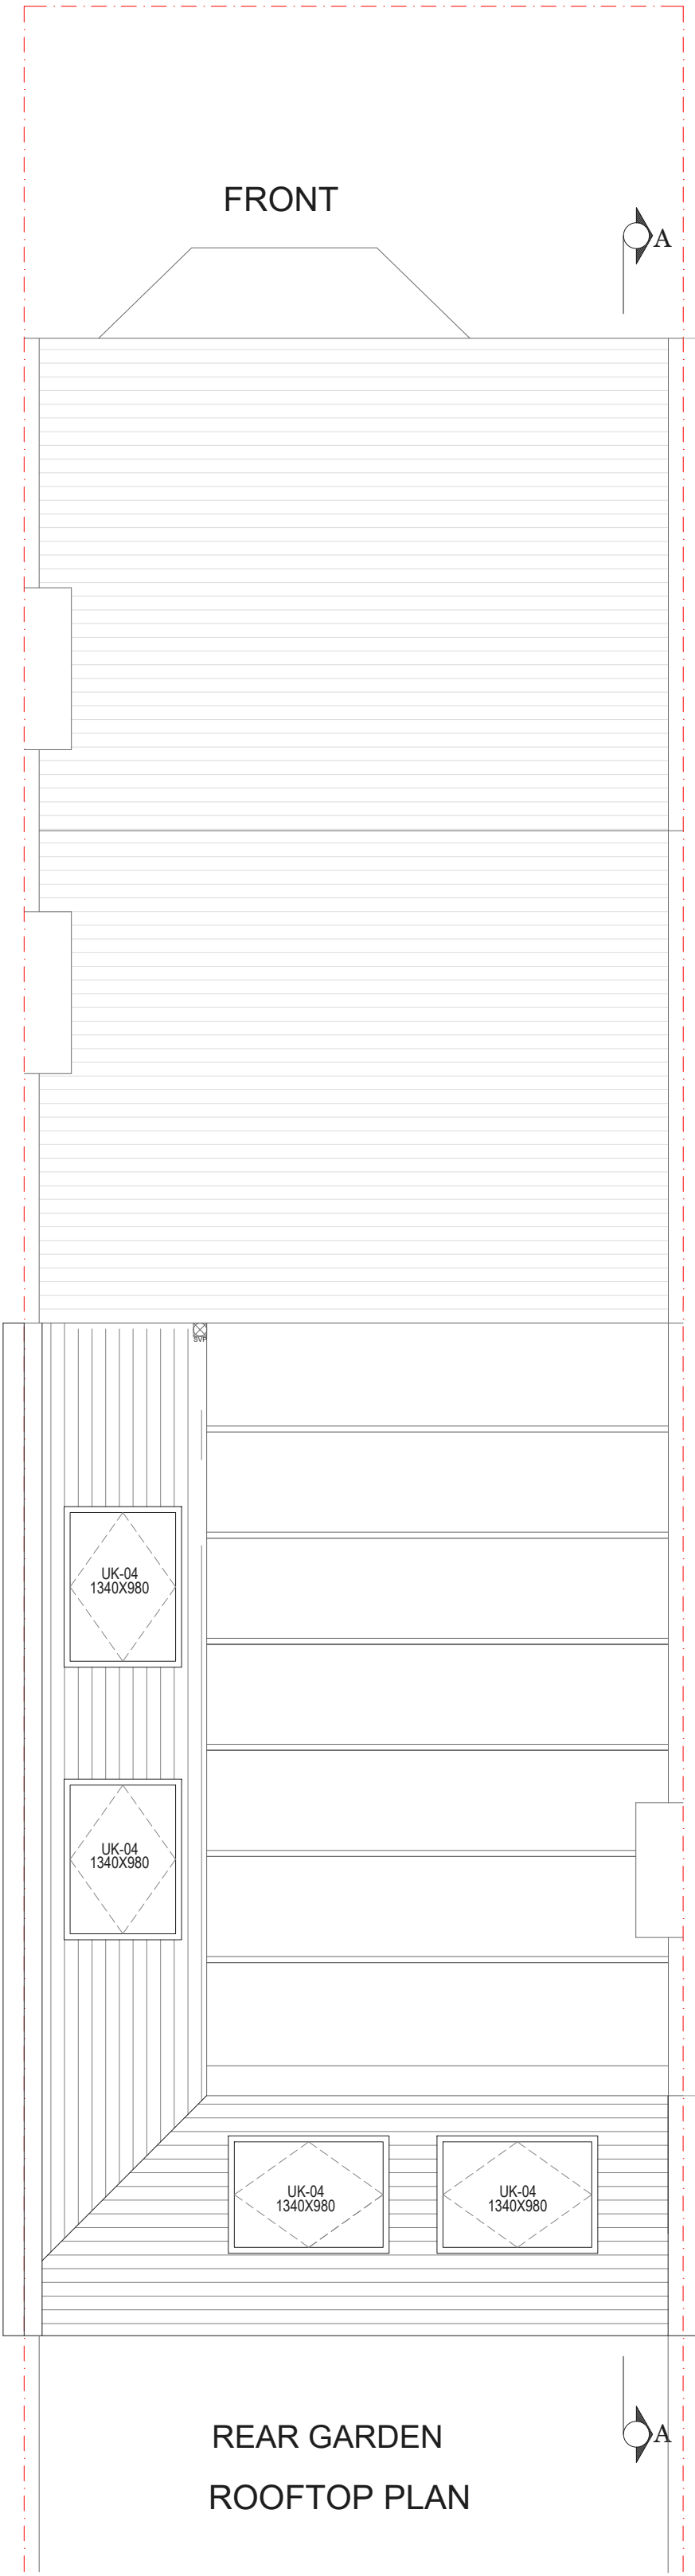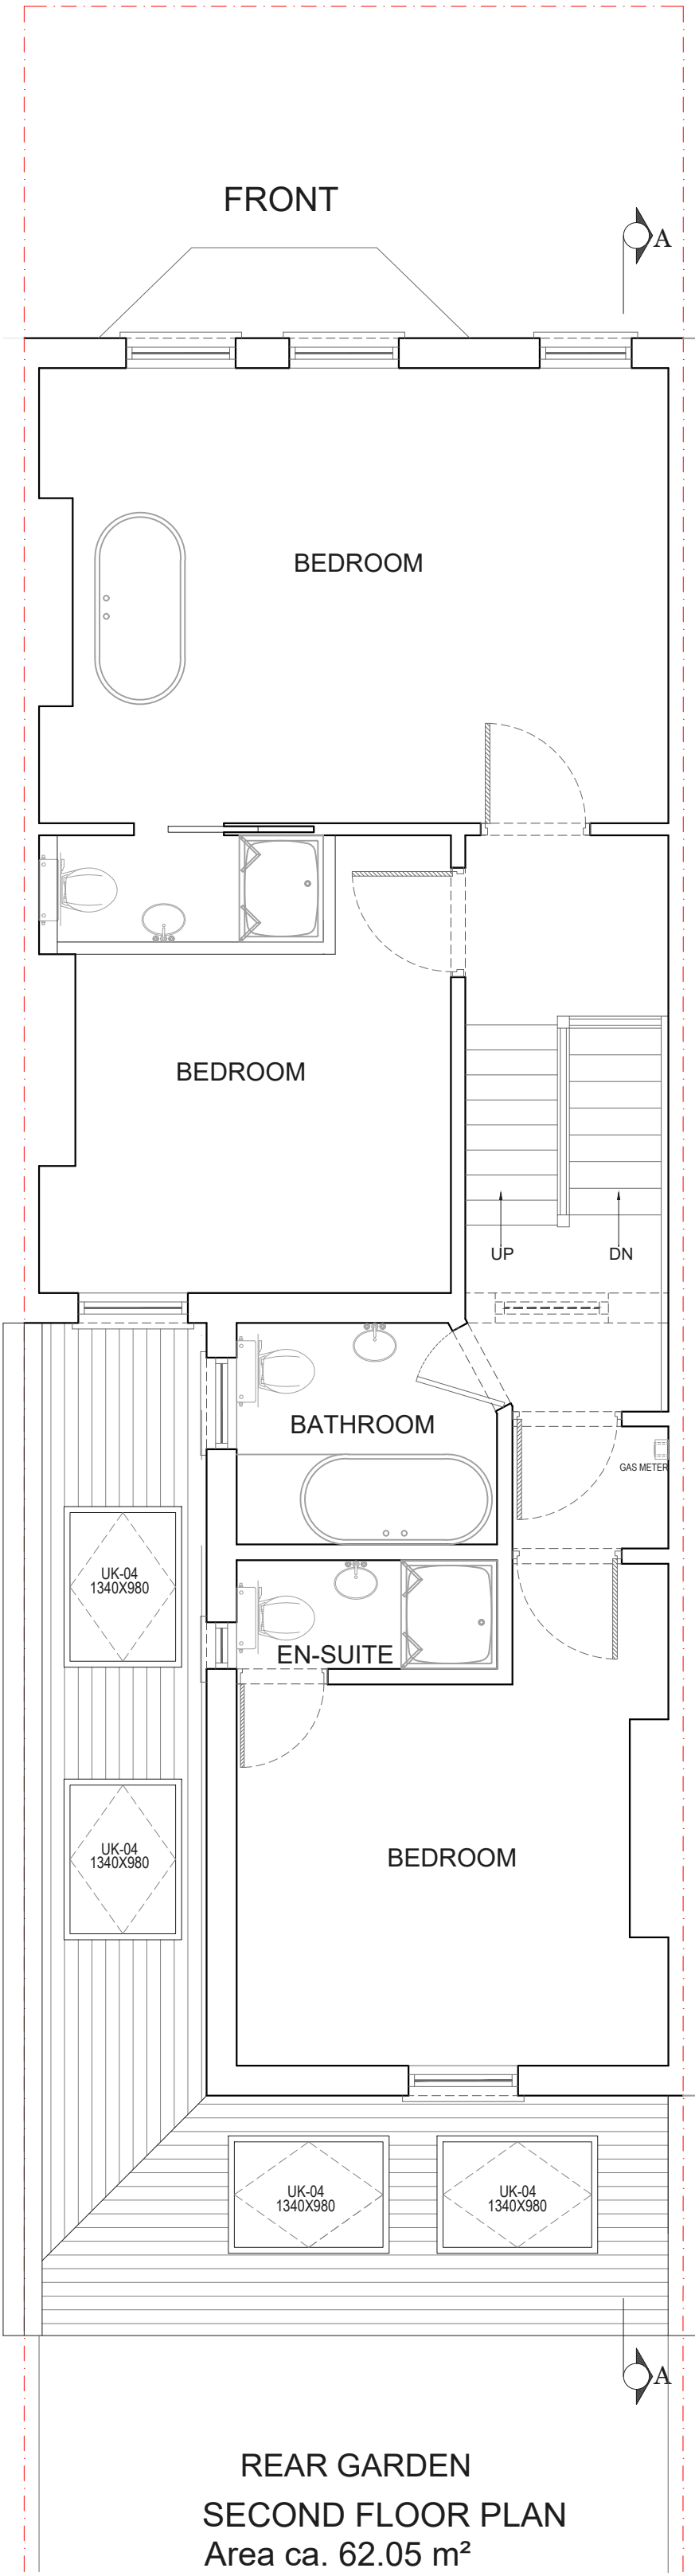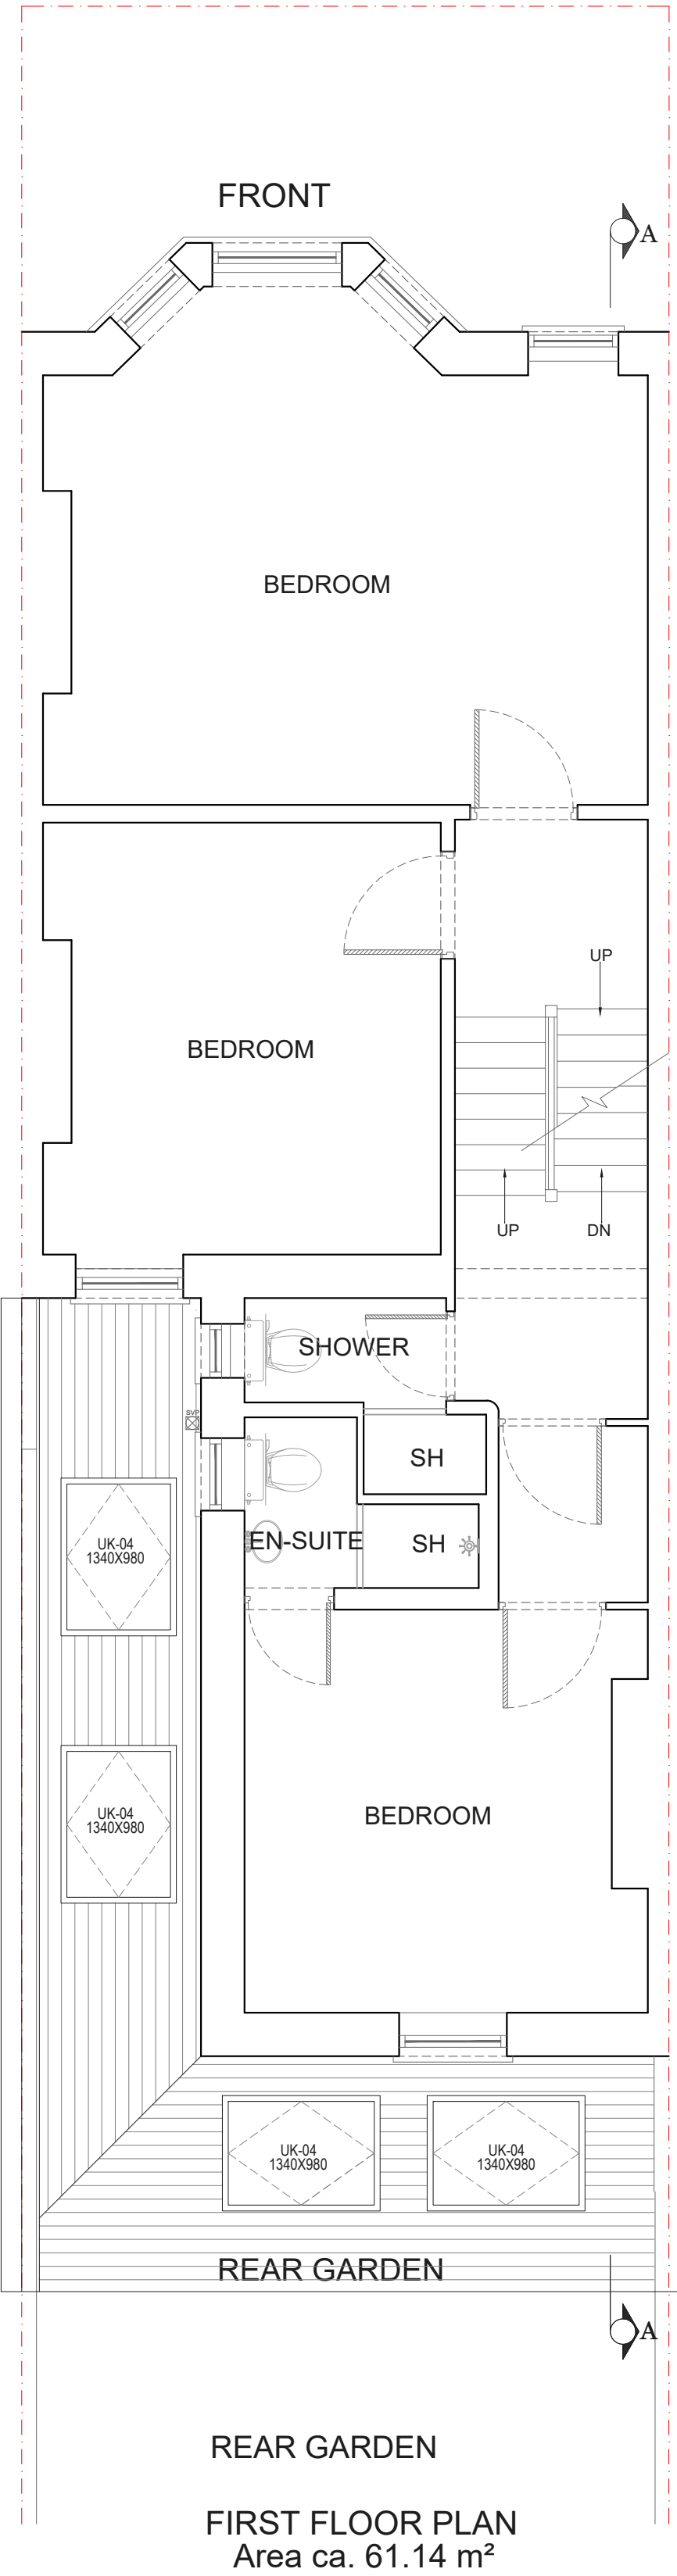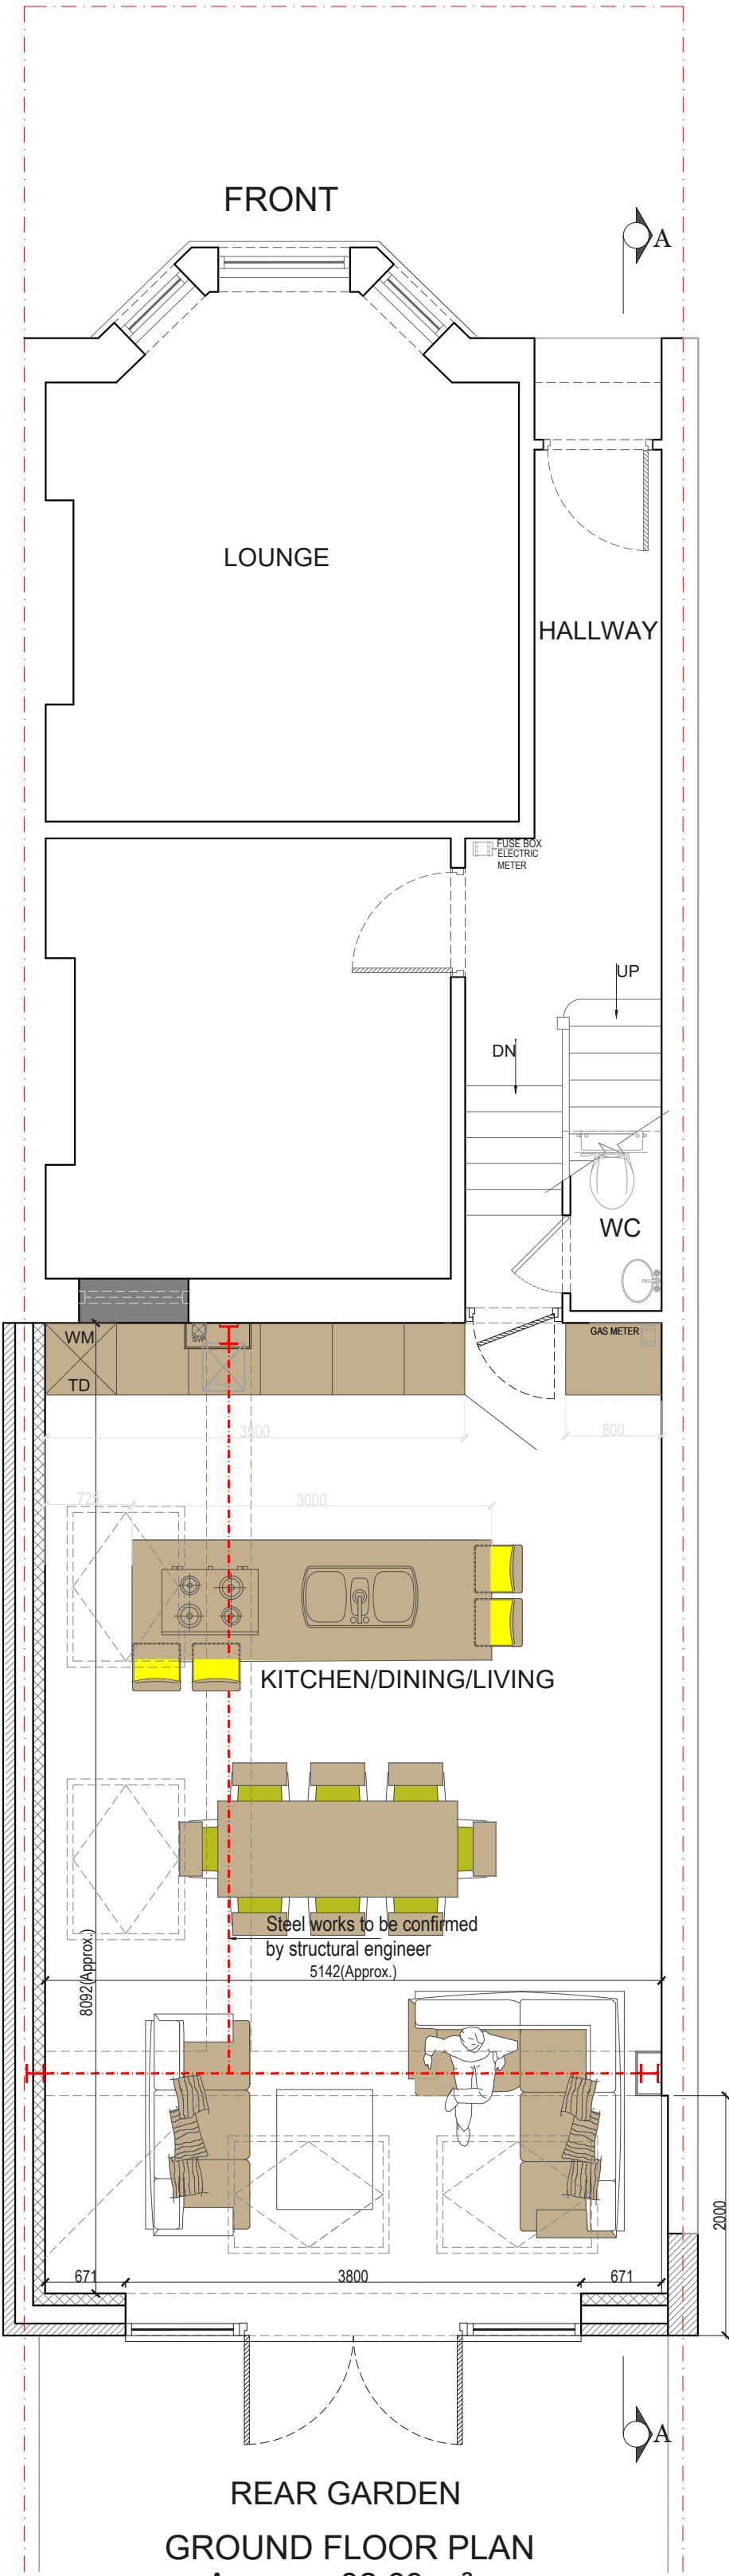


Symbol Key:

- Proposed wall
- Boundary line
- Details above
- Waste drainage layout
- Demolished
- Rainwater layout
- Fixtures and fittings

New rainwater waste to be taken to new or existing soak away minimum 5metres away from any foundation. Contractor to specify new location on site.

Timber/steel beam above sized and specified by Structural Engineer - fire proofed as per spec. and detail drawing

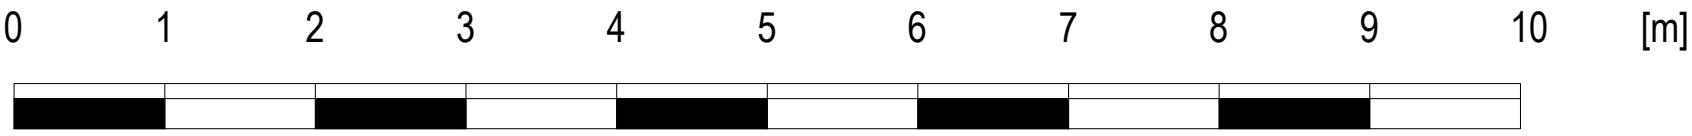

Drawn by:
A-A

Client:
LIA BROWN

Project:
30 MACKESON ROAD LONDON NW3 2LT

Drawing Title:
PROPOSED PLANS

Date:
04.12.2024

Scale @A1:
1:50

No.:
PP-02

Rev:

Page:



EXISTING




FRONT ELEVATION



SOUTH ELEVATION



REAR ELEVATION

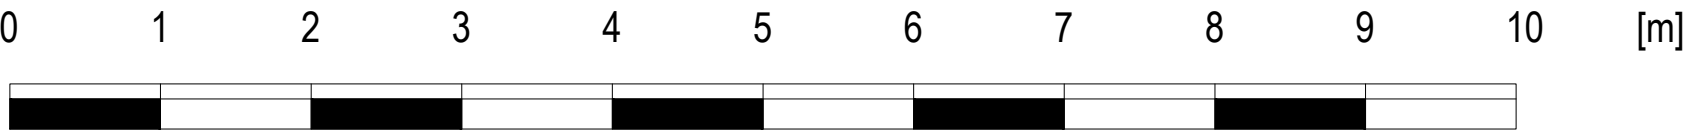

Drawn by:
A-A

Client:
LIA BROWN

Project:
30 MACKESON ROAD LONDON NW3 2LT

Drawing Title:
EXISTING ELEVATIONS

Date:
04.12.2024

Scale @A1:
1:50

No.:
PP-03

Rev:

Page:



PROPOSED

Proposed Materials:
Walls: Tiles to match existing
Flat roof: Ply membrane




FRONT ELEVATION



SOUTH ELEVATION



REAR ELEVATION

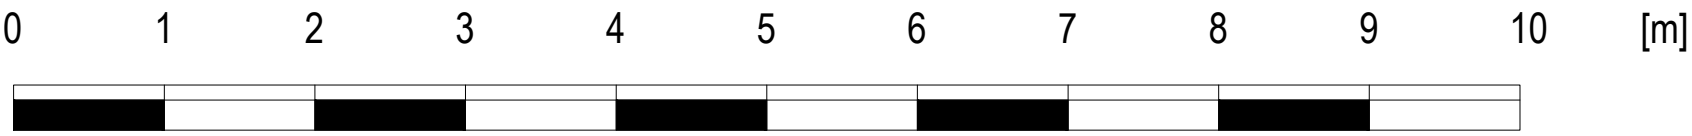

Drawn by:
A-A

Client:
LIA BROWN

Project:
30 MACKESON ROAD LONDON NW3 2LT

Drawing Title:
PROPOSED ELEVATIONS

Date:
04.12.2024

Scale @A1:
1:50




No.:
PP-04

Rev:

Page:



EXISTING & PROPOSED

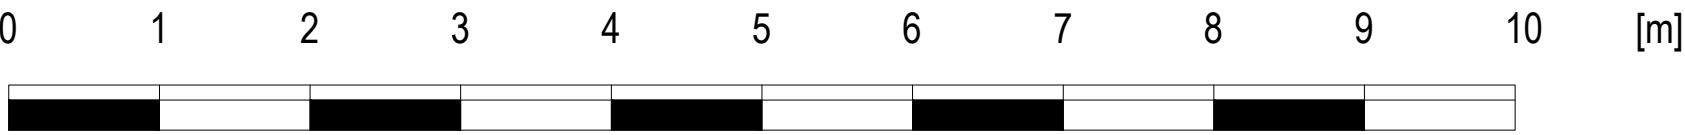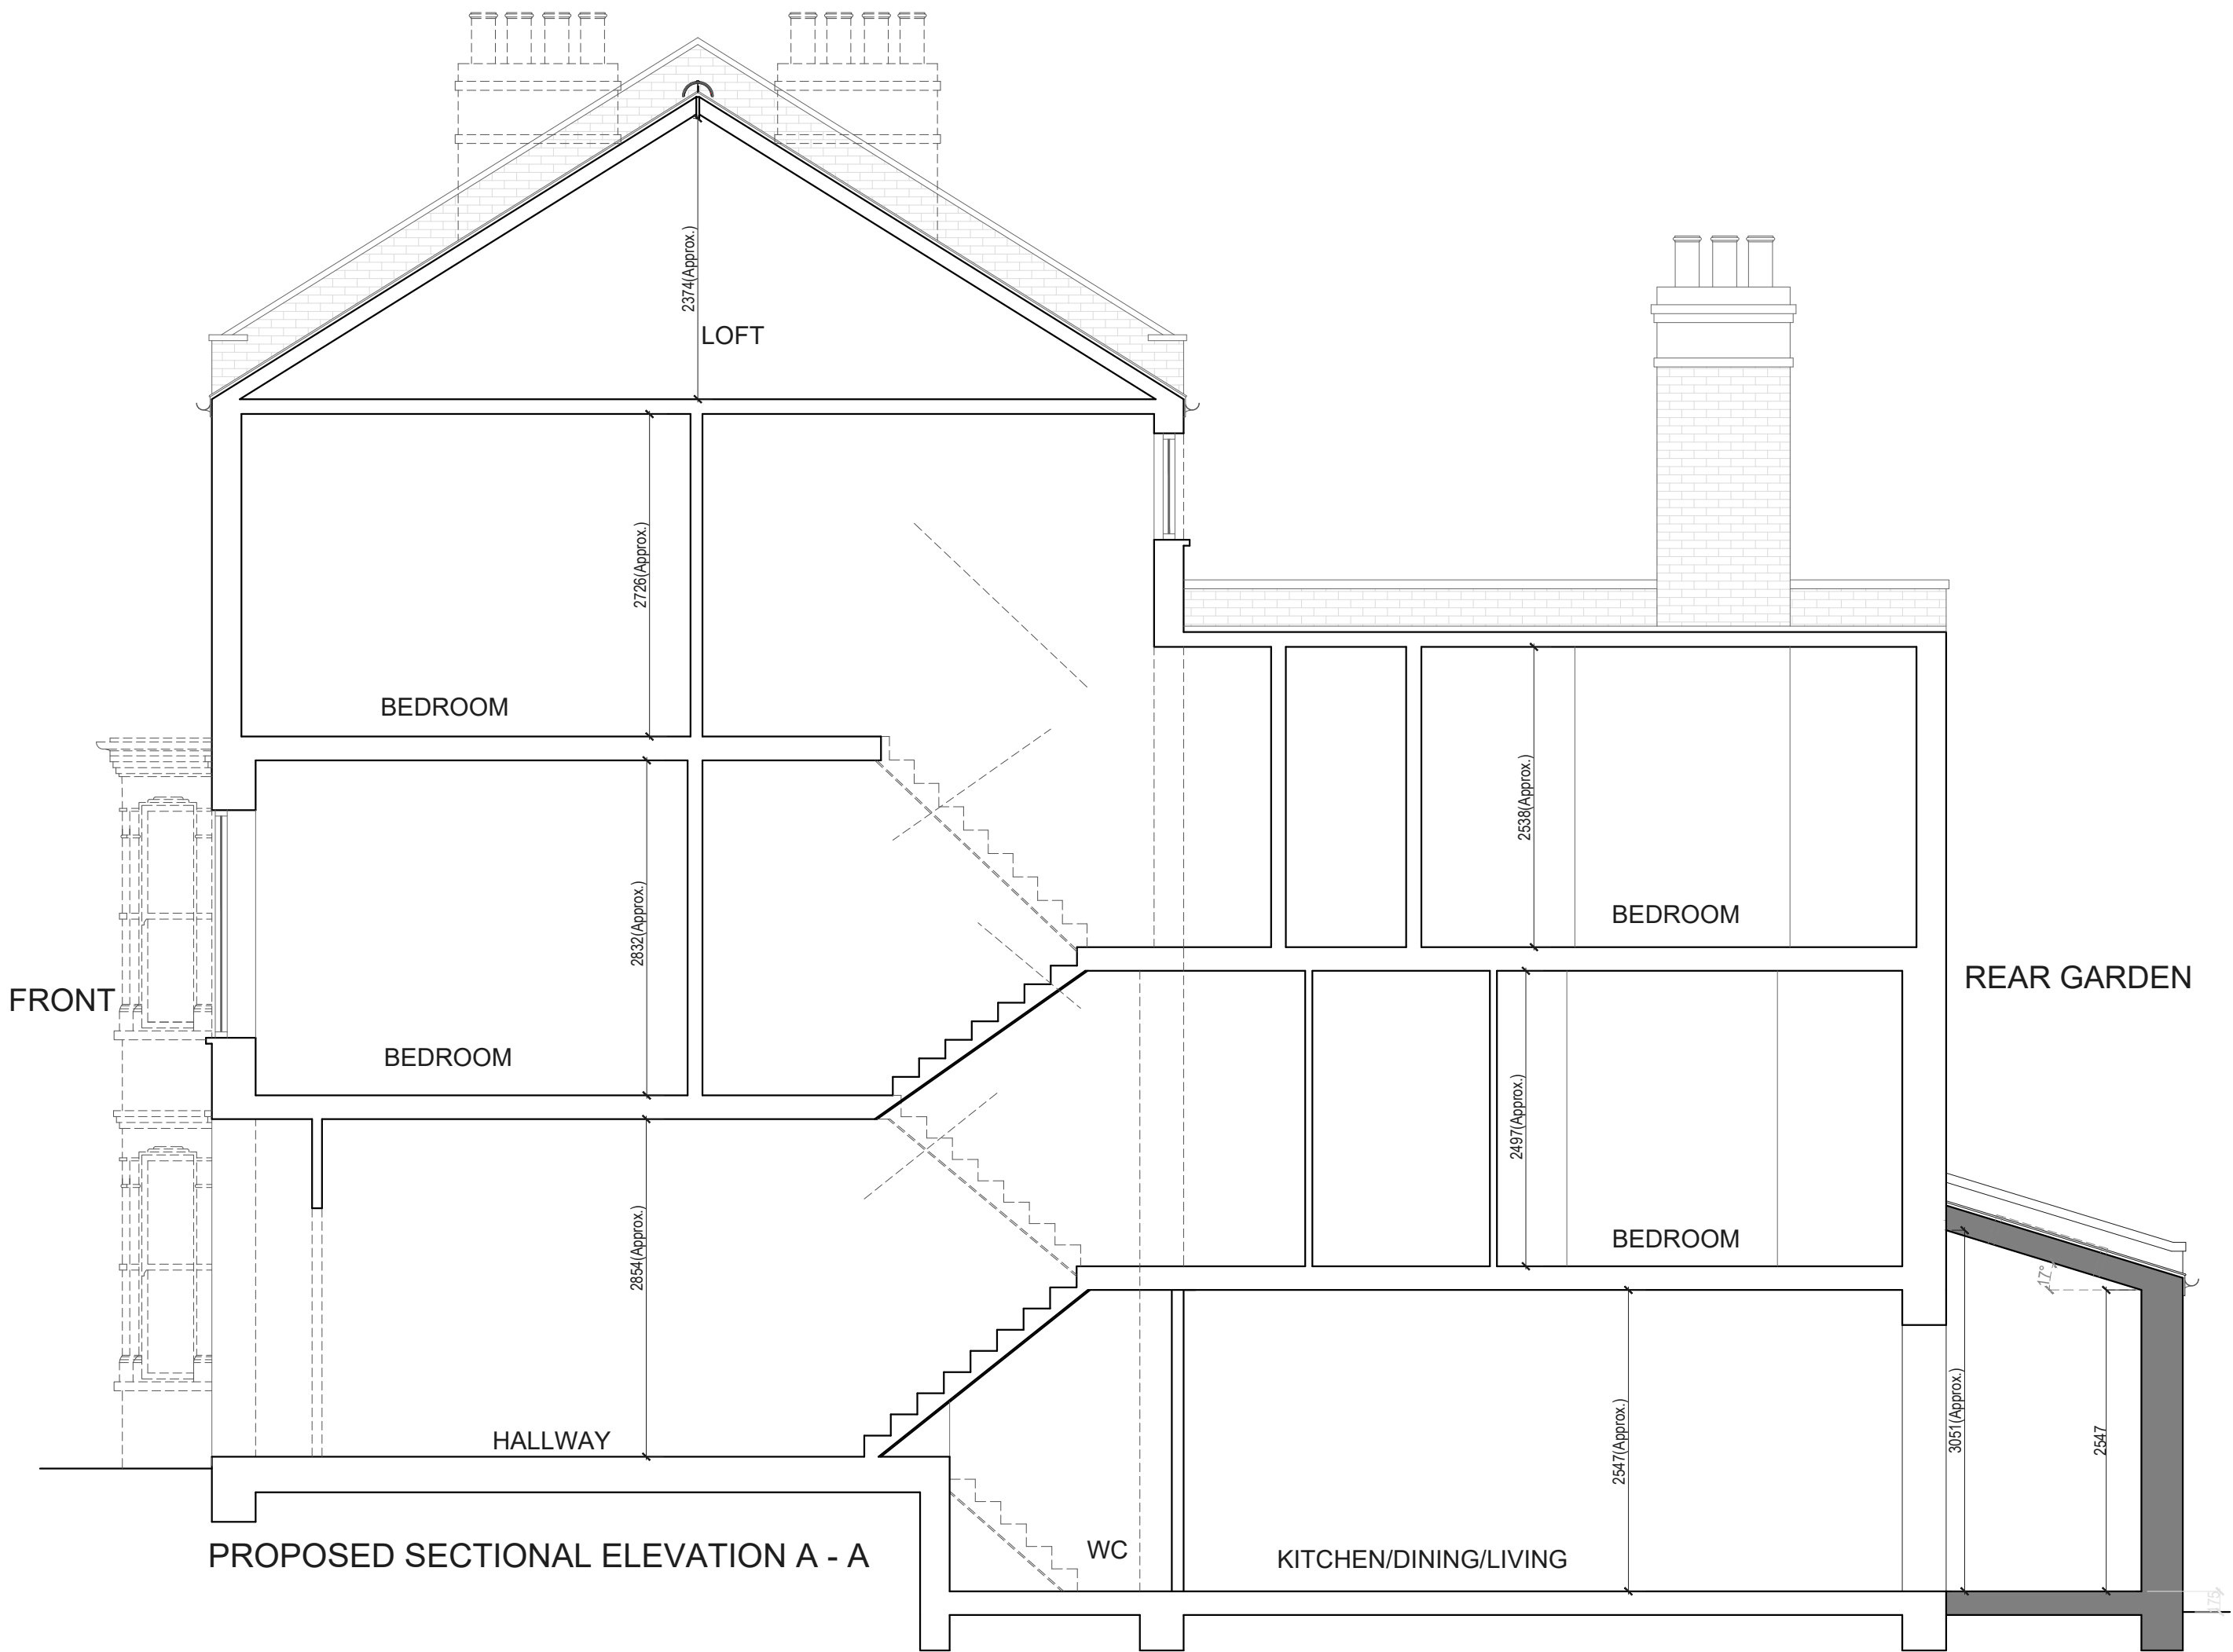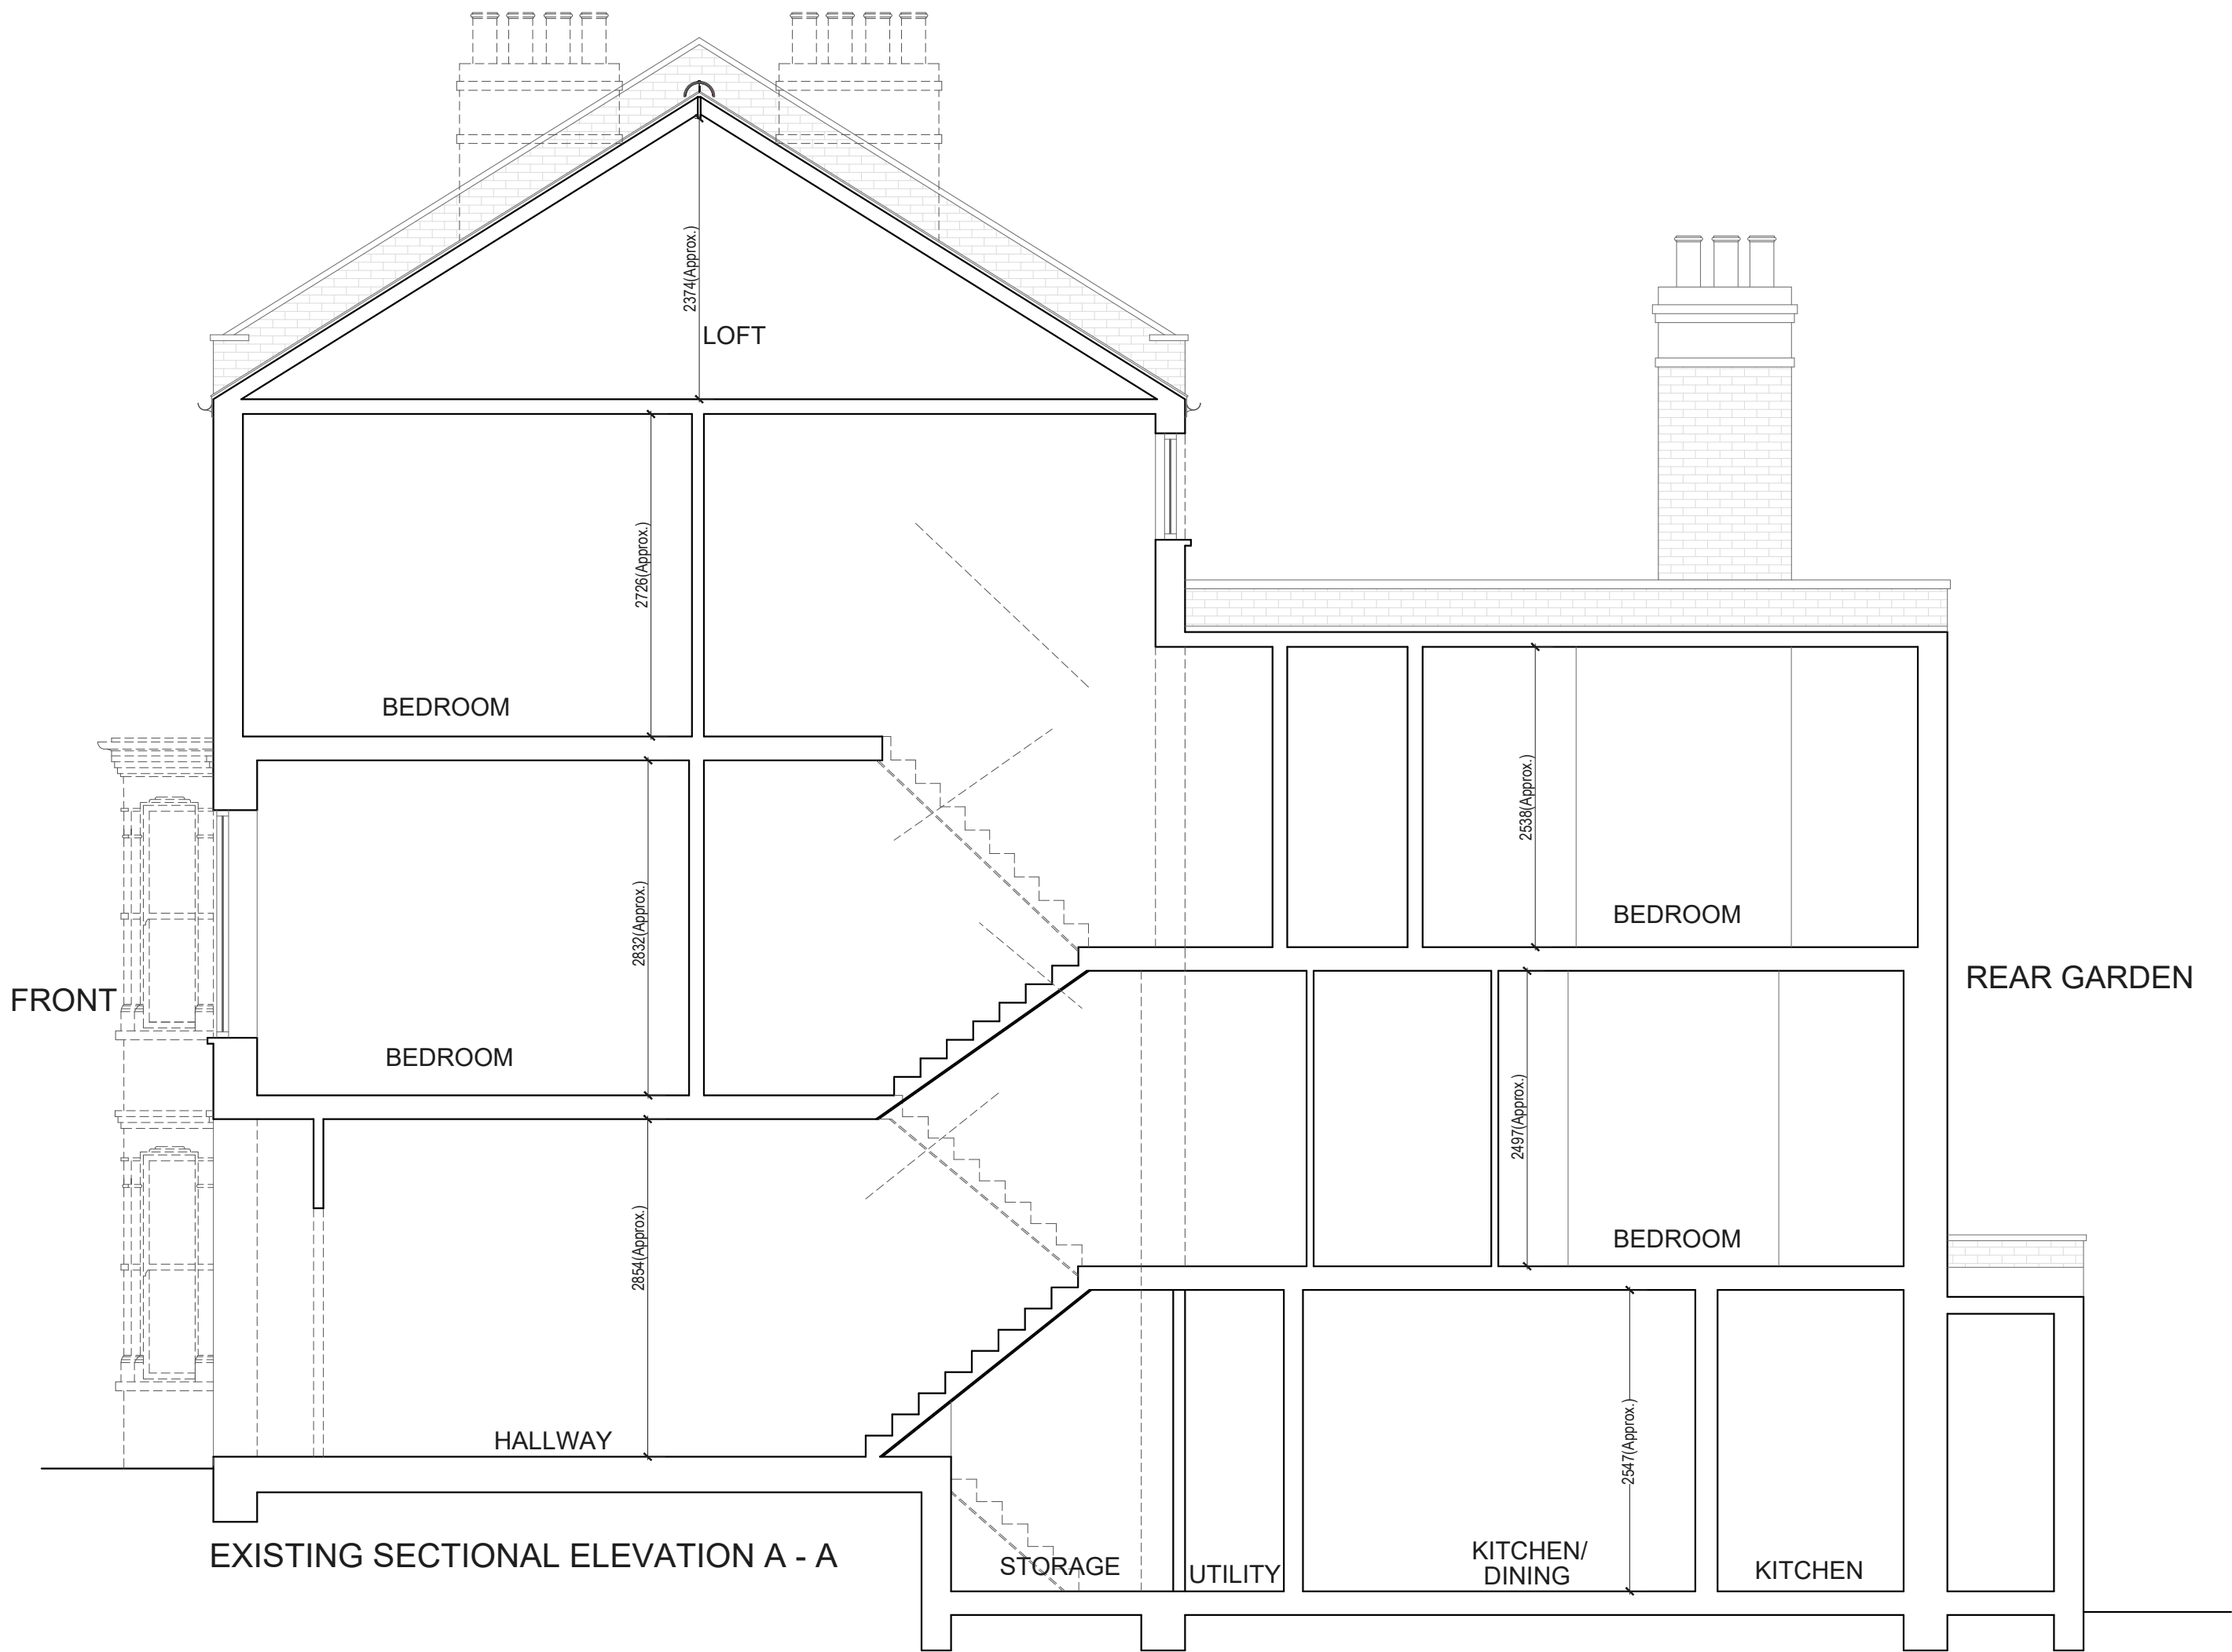

Drawn by:
A-A

Client:
LIA BROWN

Project:
30 MACKESON ROAD LONDON NW3 2LT

Drawing Title:
SECTION A-A

Date:
04.12.2024

Scale @A1:
1:50

No.:
PP-05




Rev:

Page:



EXISTING & PROPOSED

Proposed Materials:
Walls: Tiles to match existing
Flat roof: Ply membrane

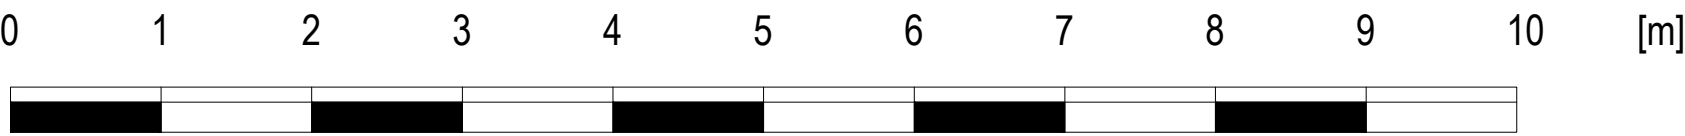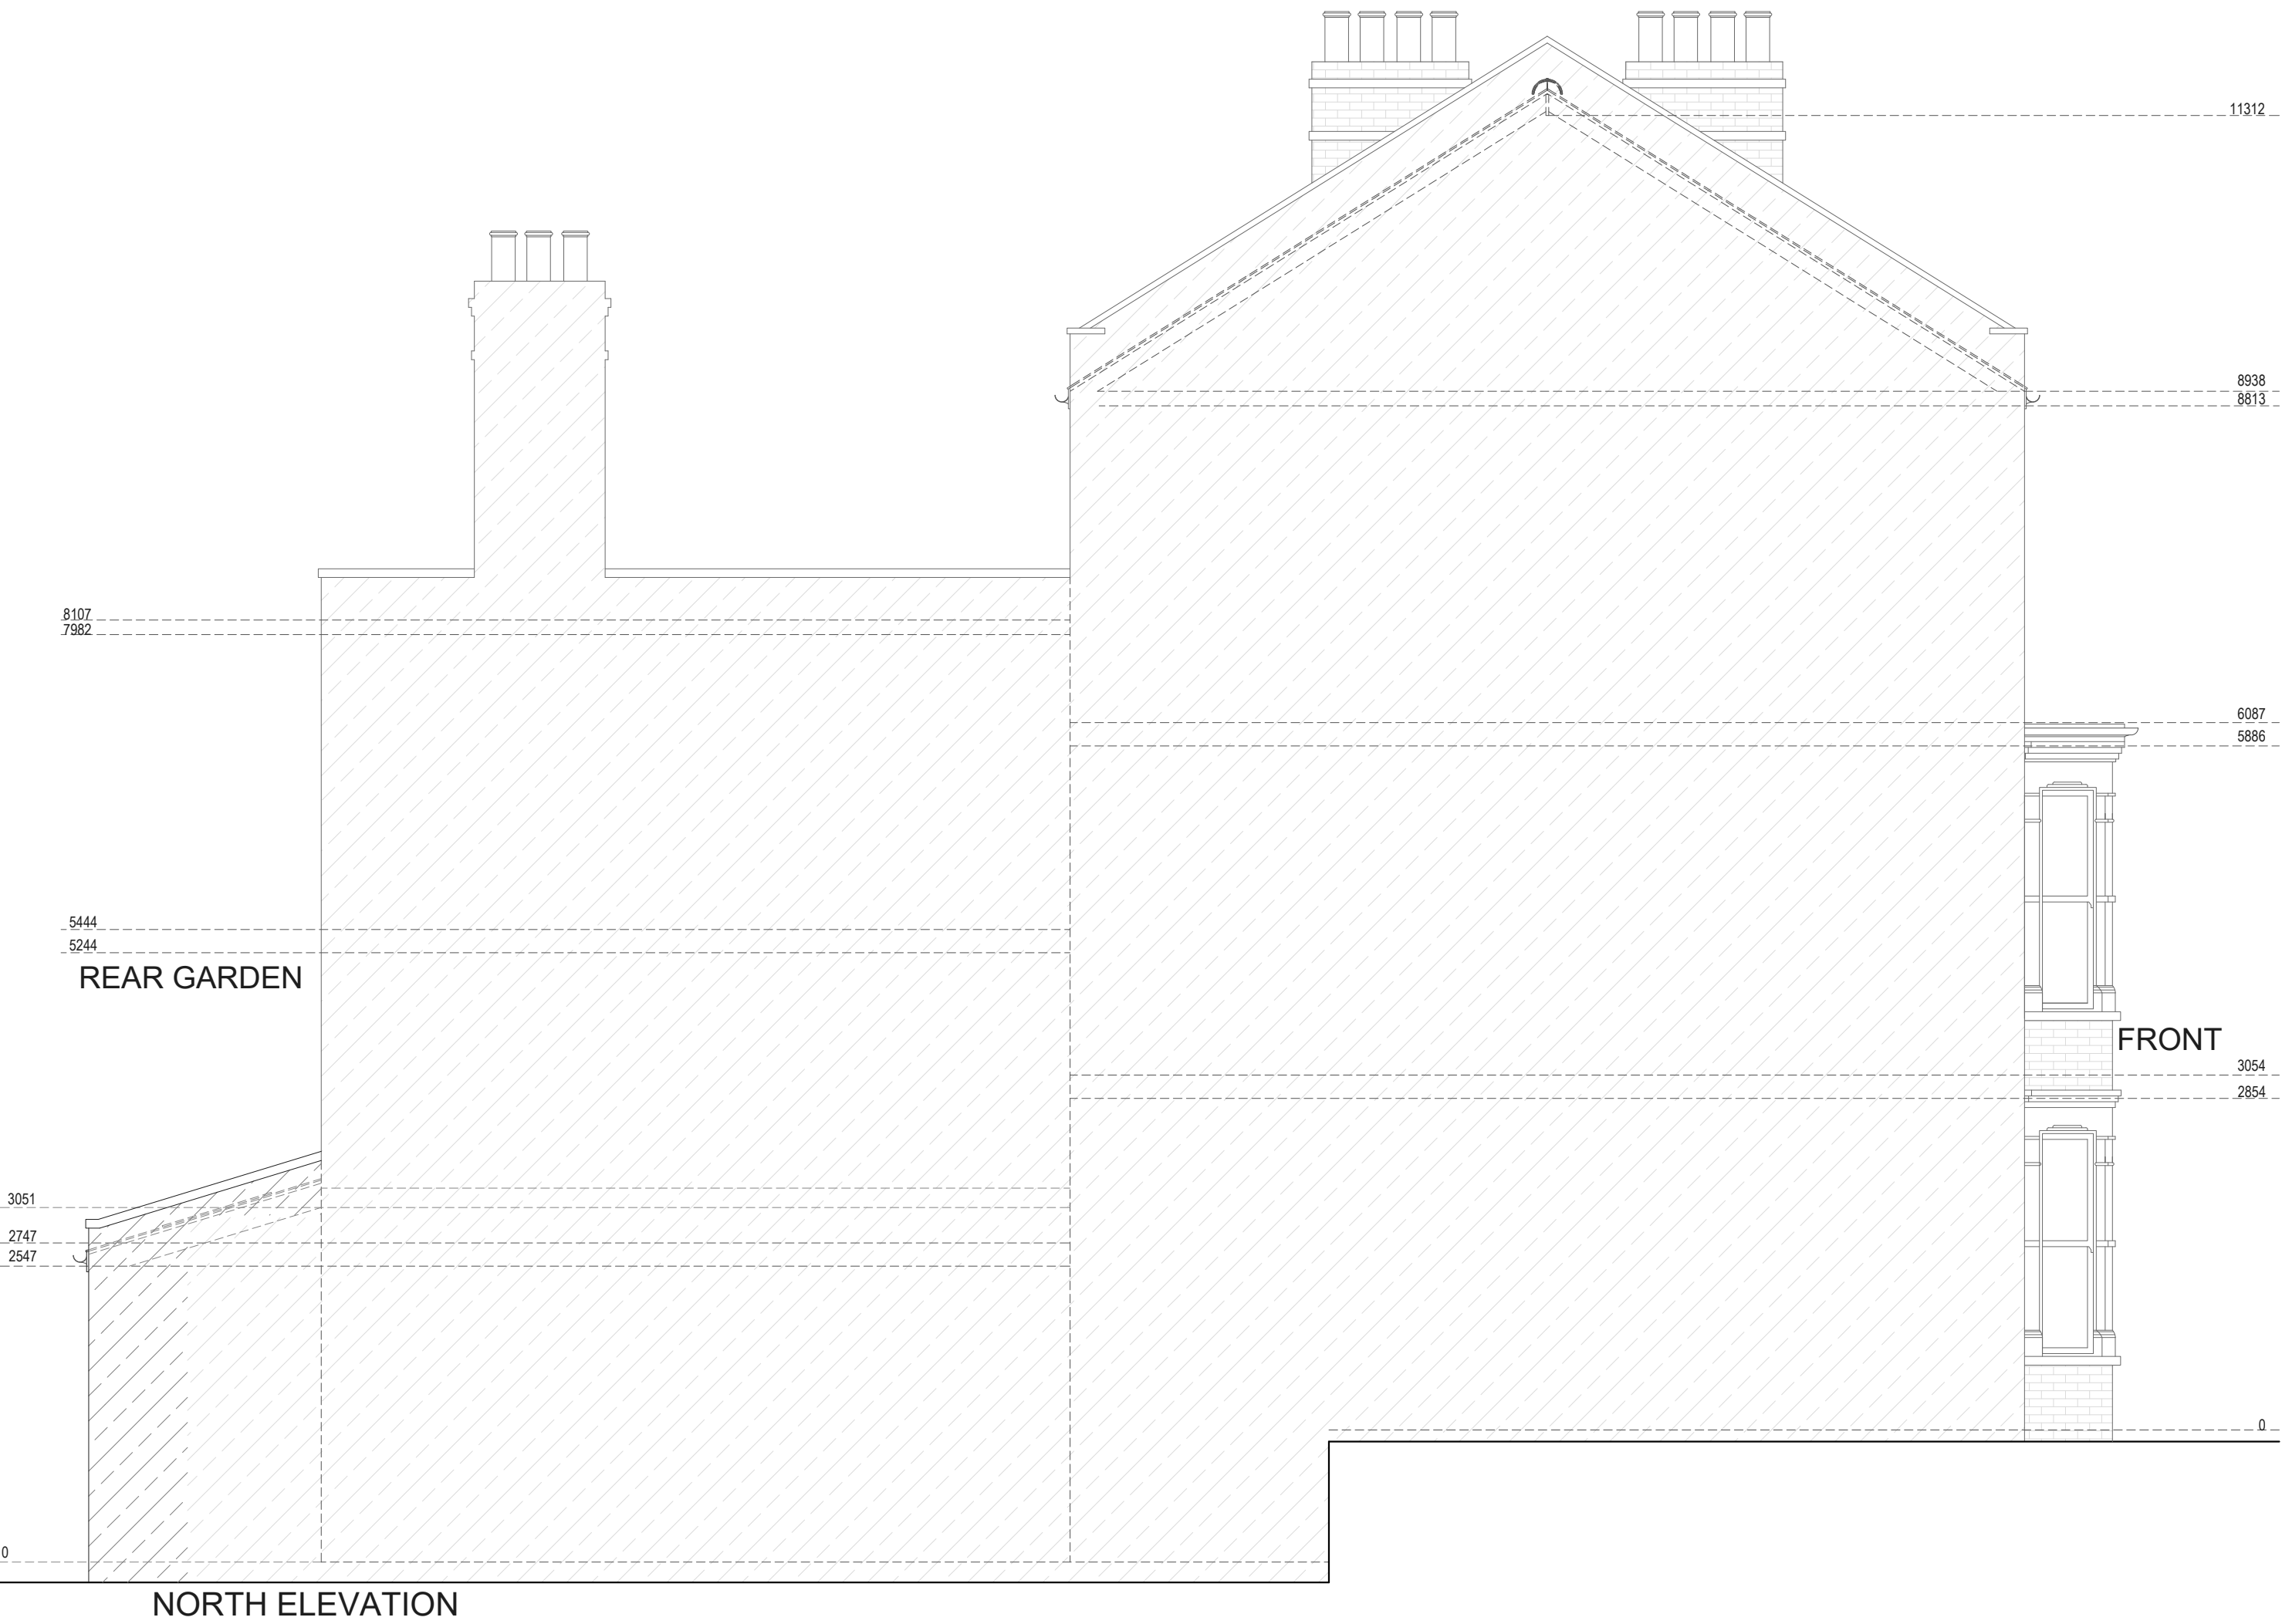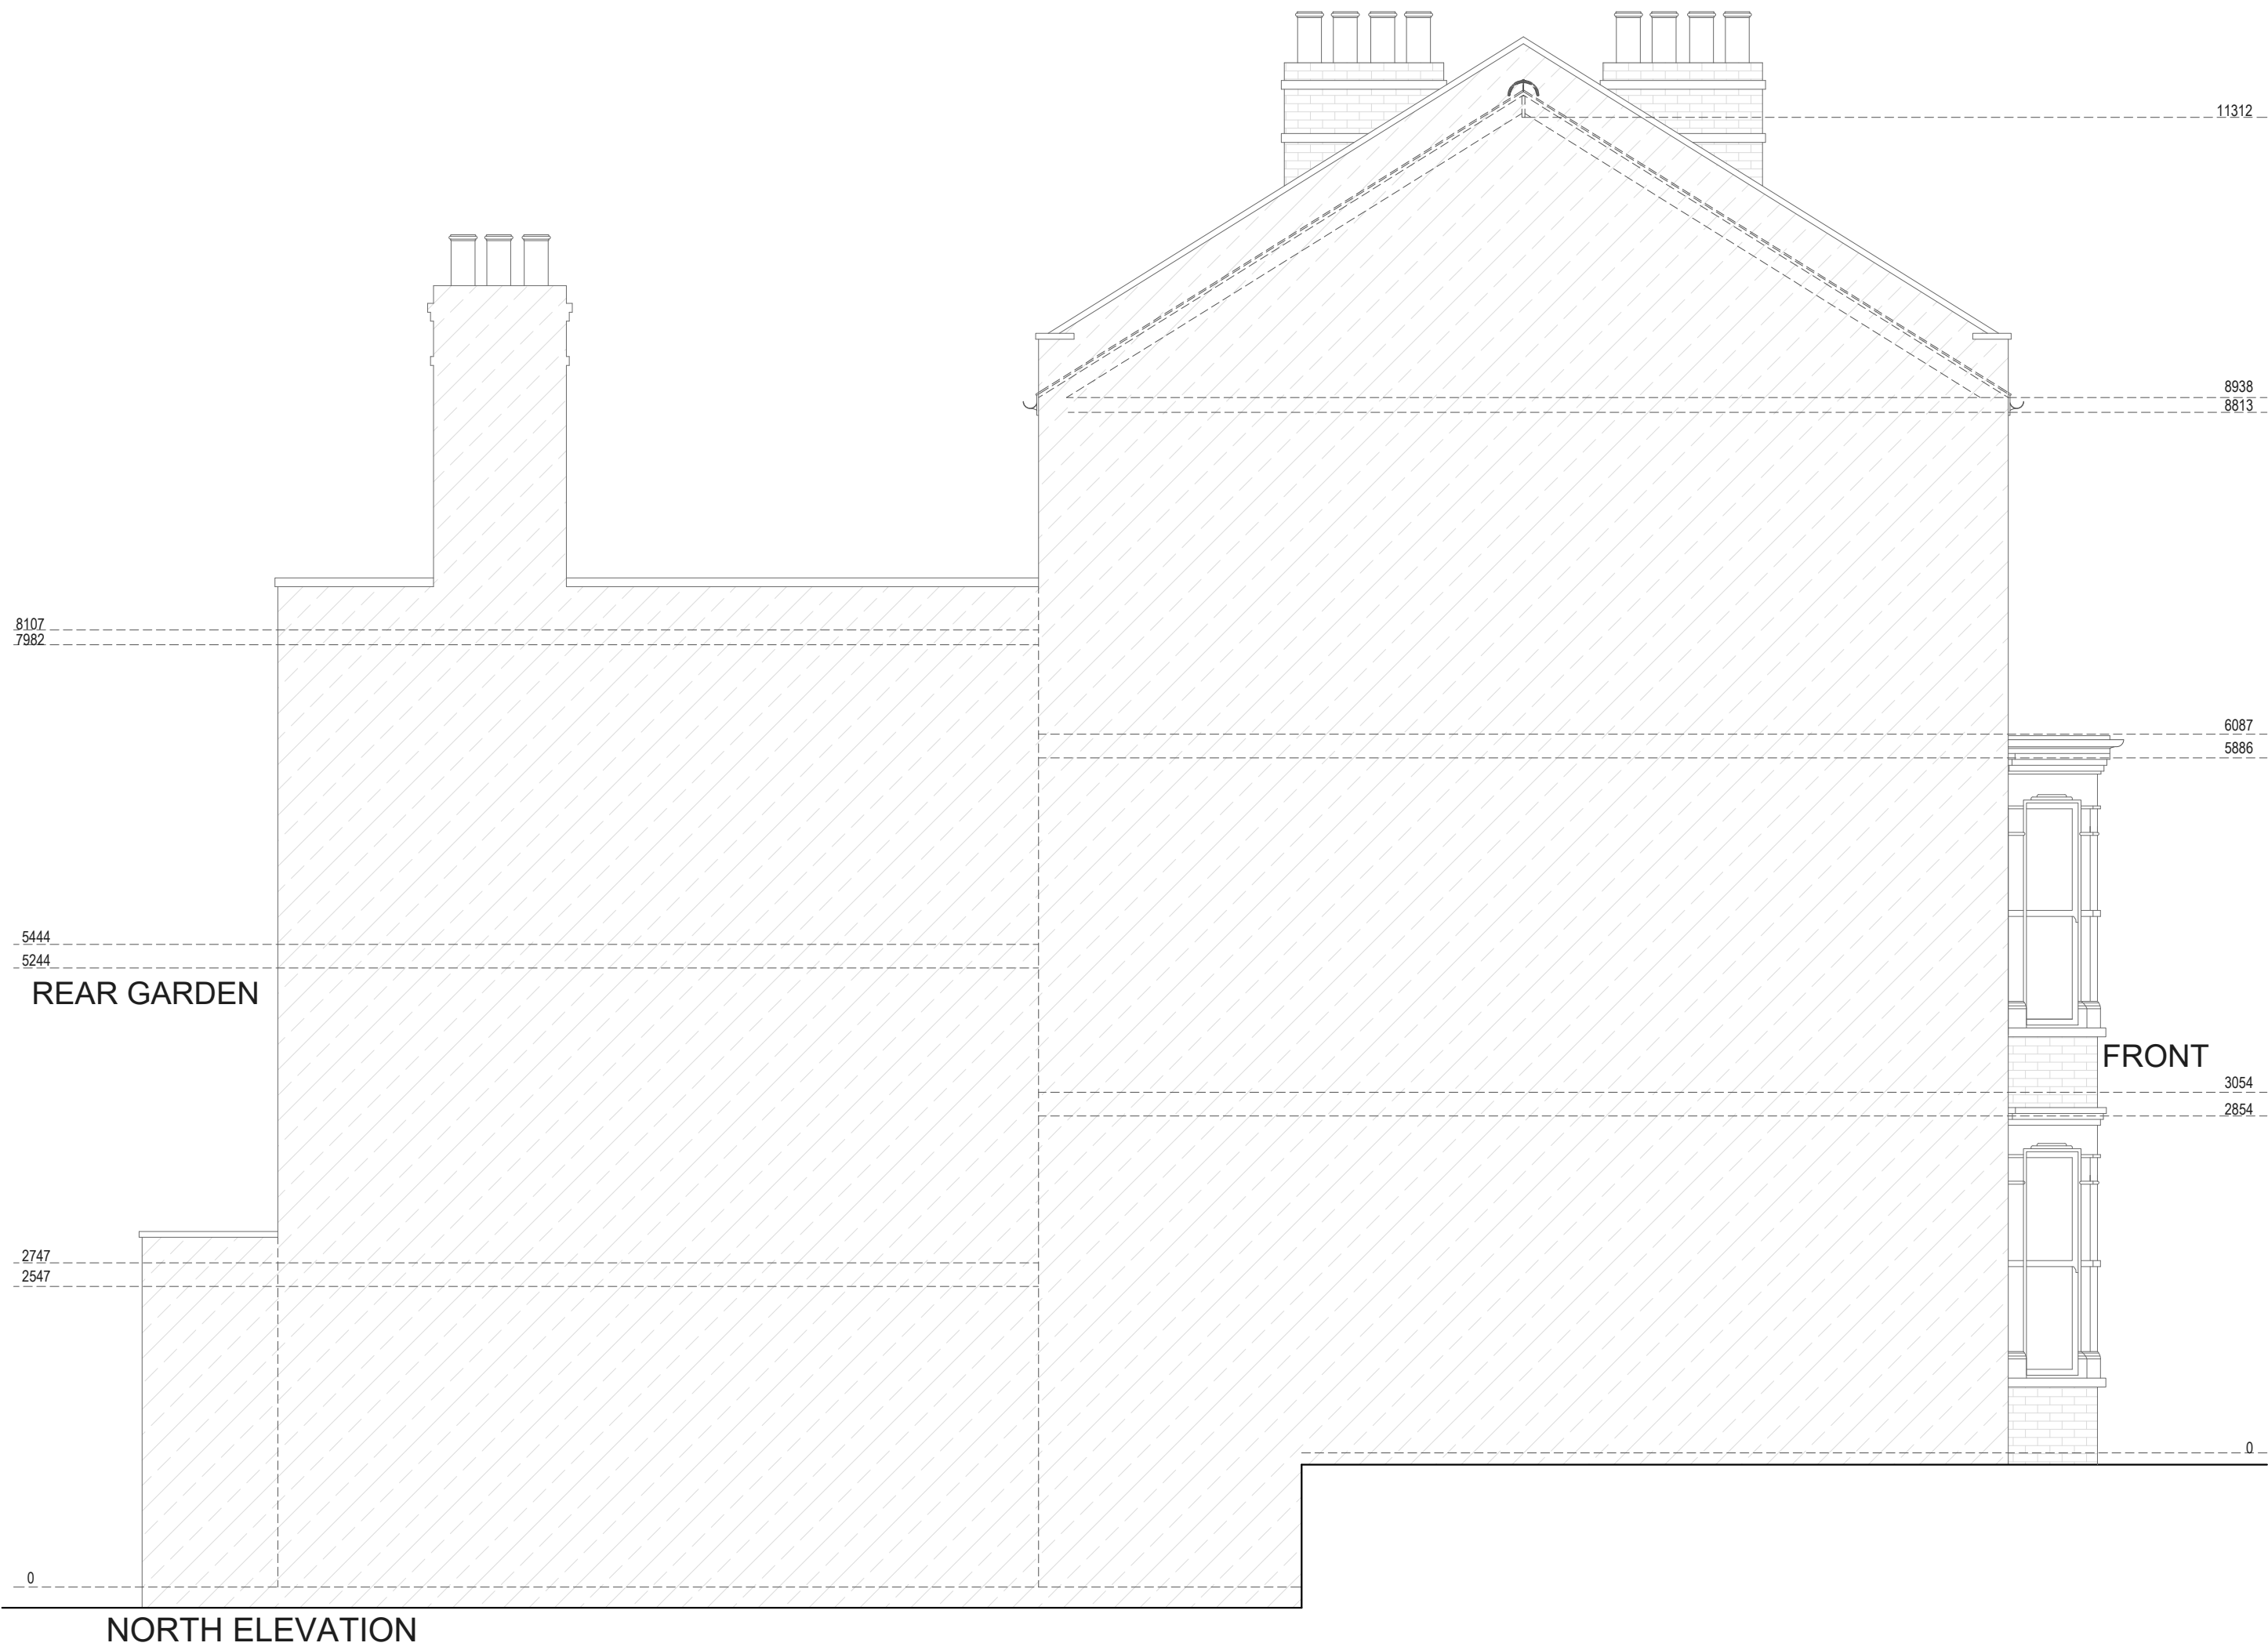

Drawn by:
A-A

Client:
LIA BROWN

Project:
30 MACKESON ROAD LONDON NW3 2LT

Drawing Title:
SIDE ELEVATIONS

Date:
04.12.2024

Scale @A1:
1:50


No.:
PP-06

Rev:


Page:



EXISTING &
PROPOSED

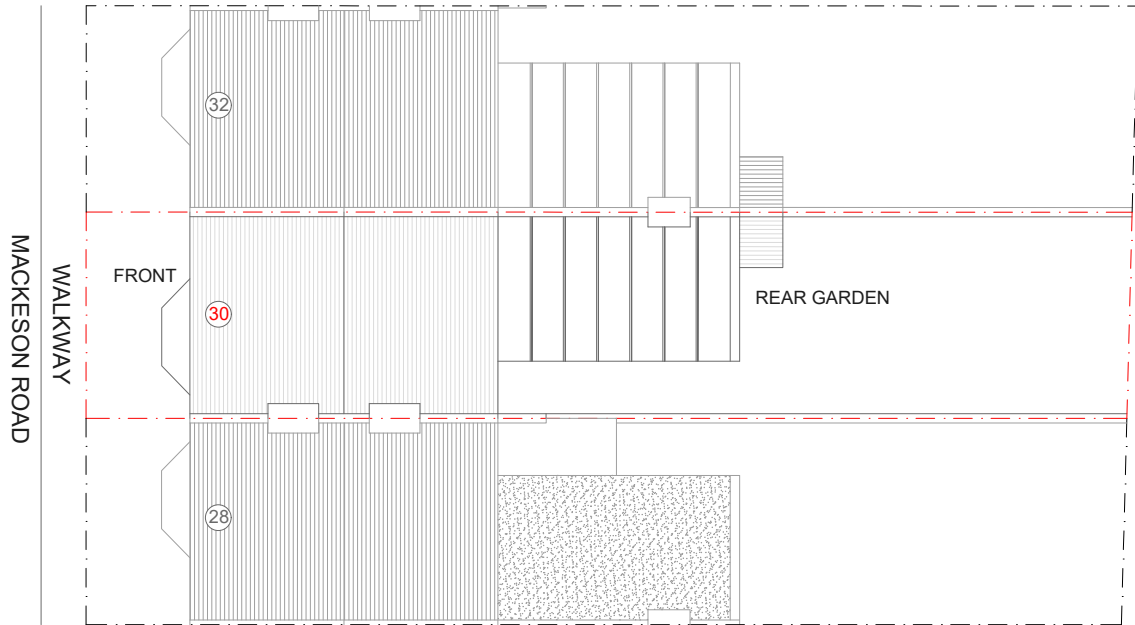

EXISTING SITE-BLOCK PLAN

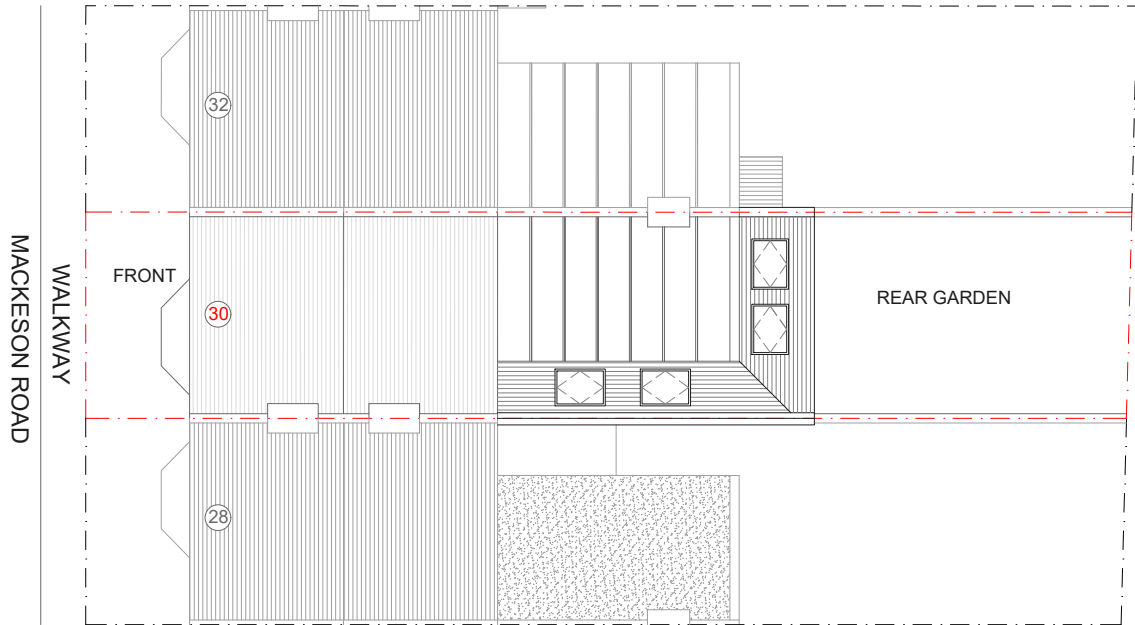

PROPOSED SITE-BLOCK PLAN



Drawn by:
A-A

Client:
LIA BROWN

Project:
30 MACKESON ROAD LONDON NW3 2LT

Drawing Title:
SITE PLAN

Date:
04.12.2024

Scale @A3:
1:200

No.:
PP-07
Rev:
Page:

