

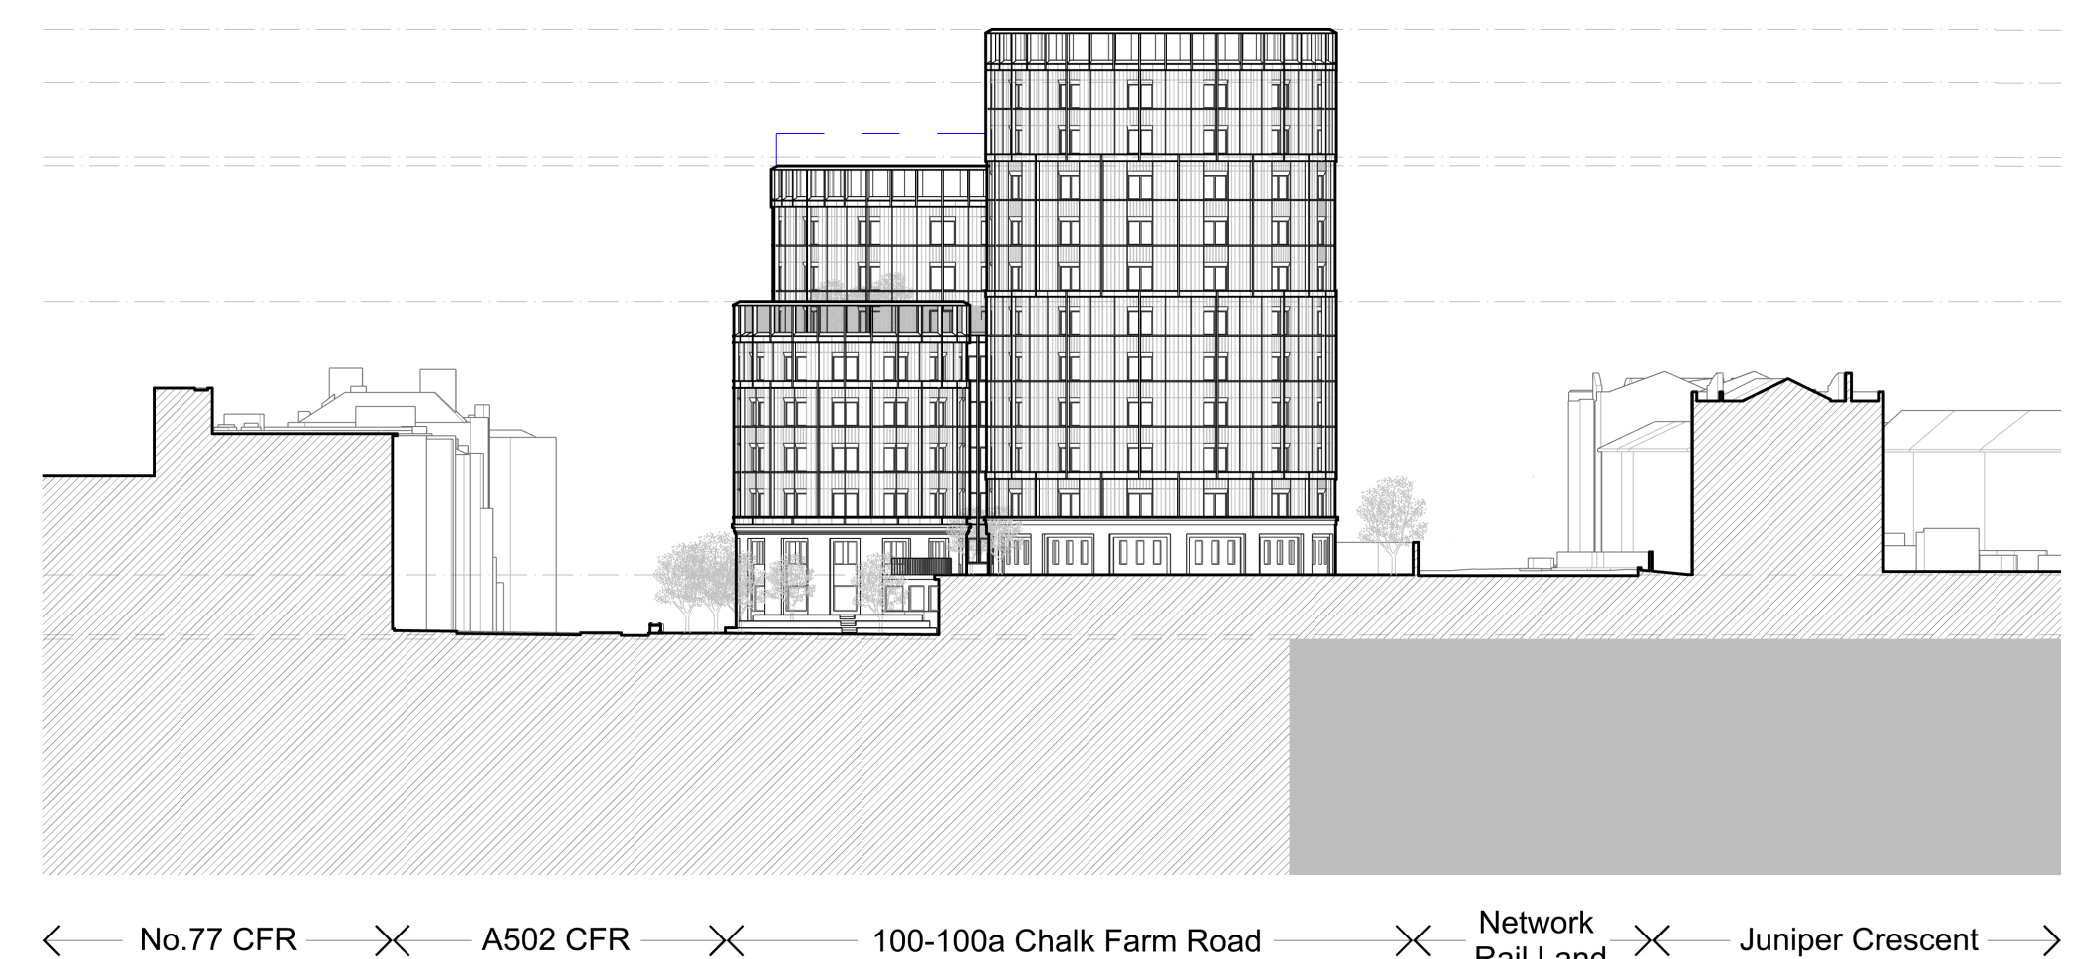
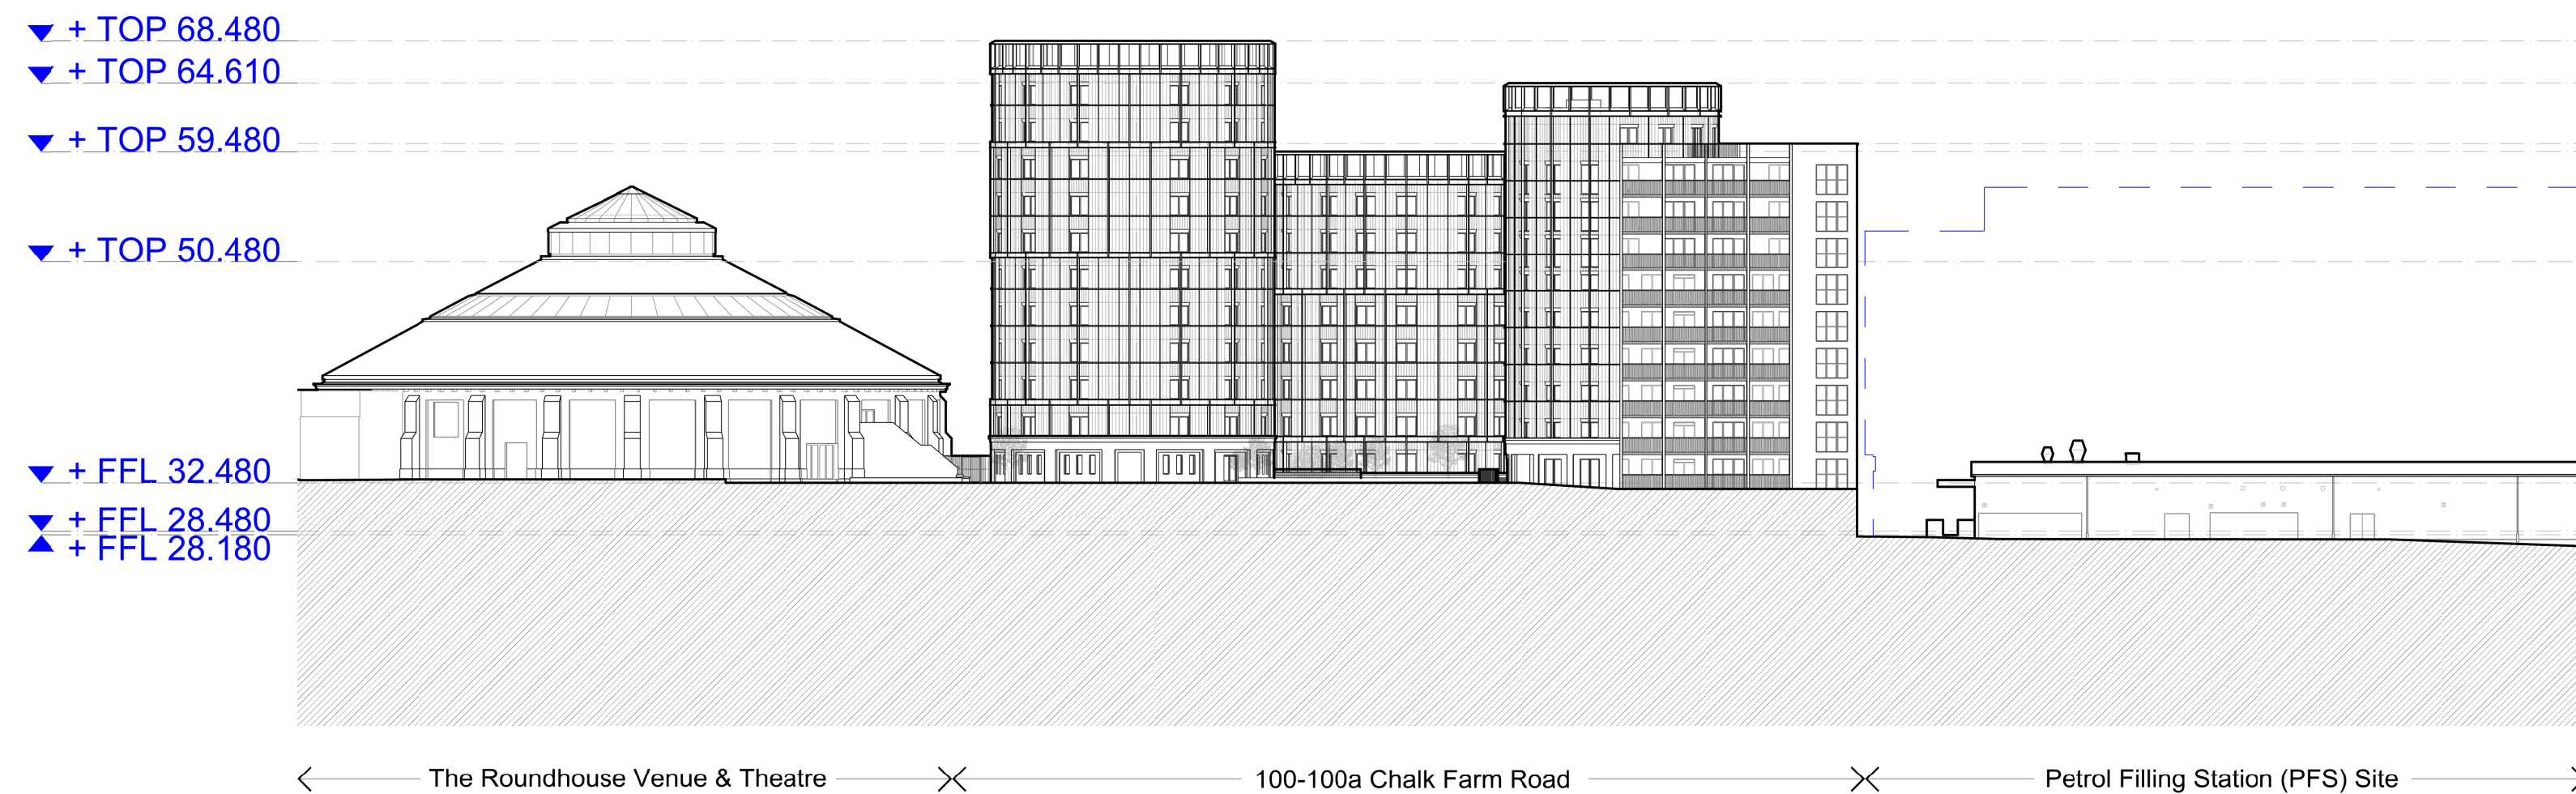


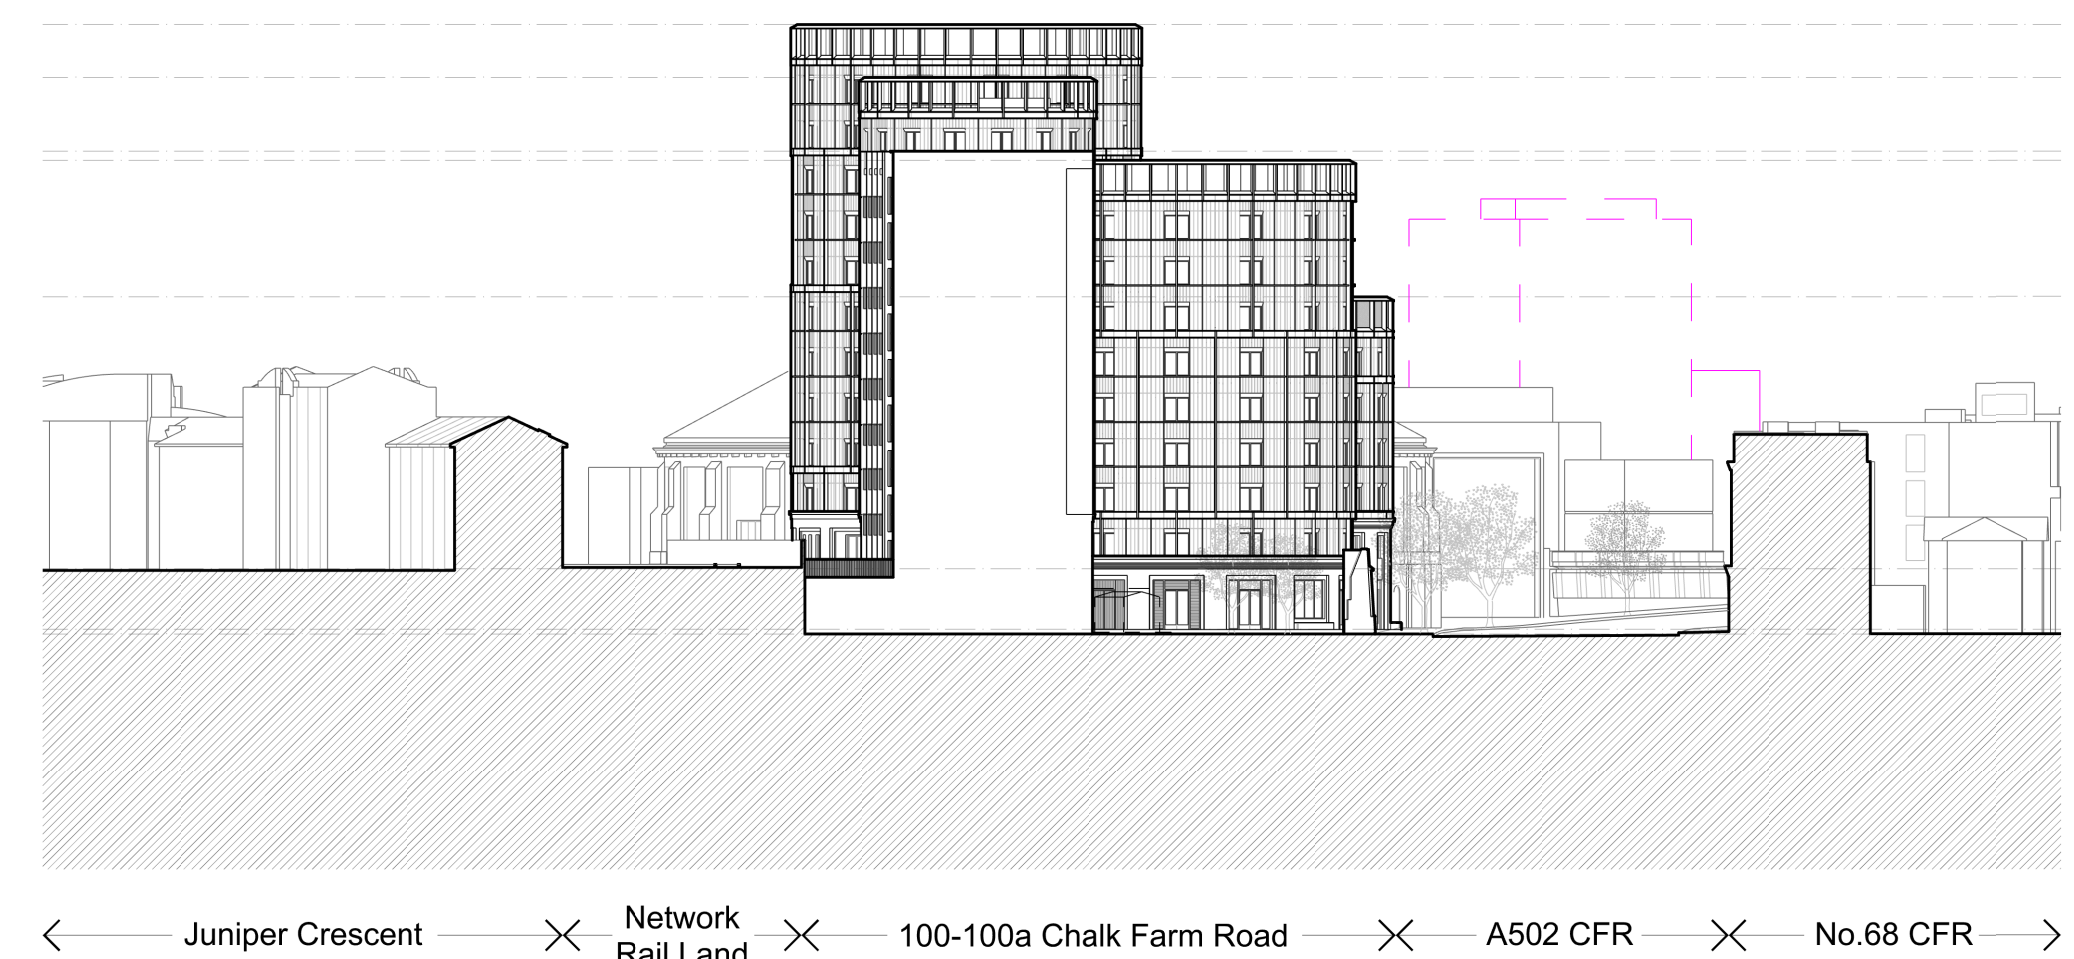

Context Elevations

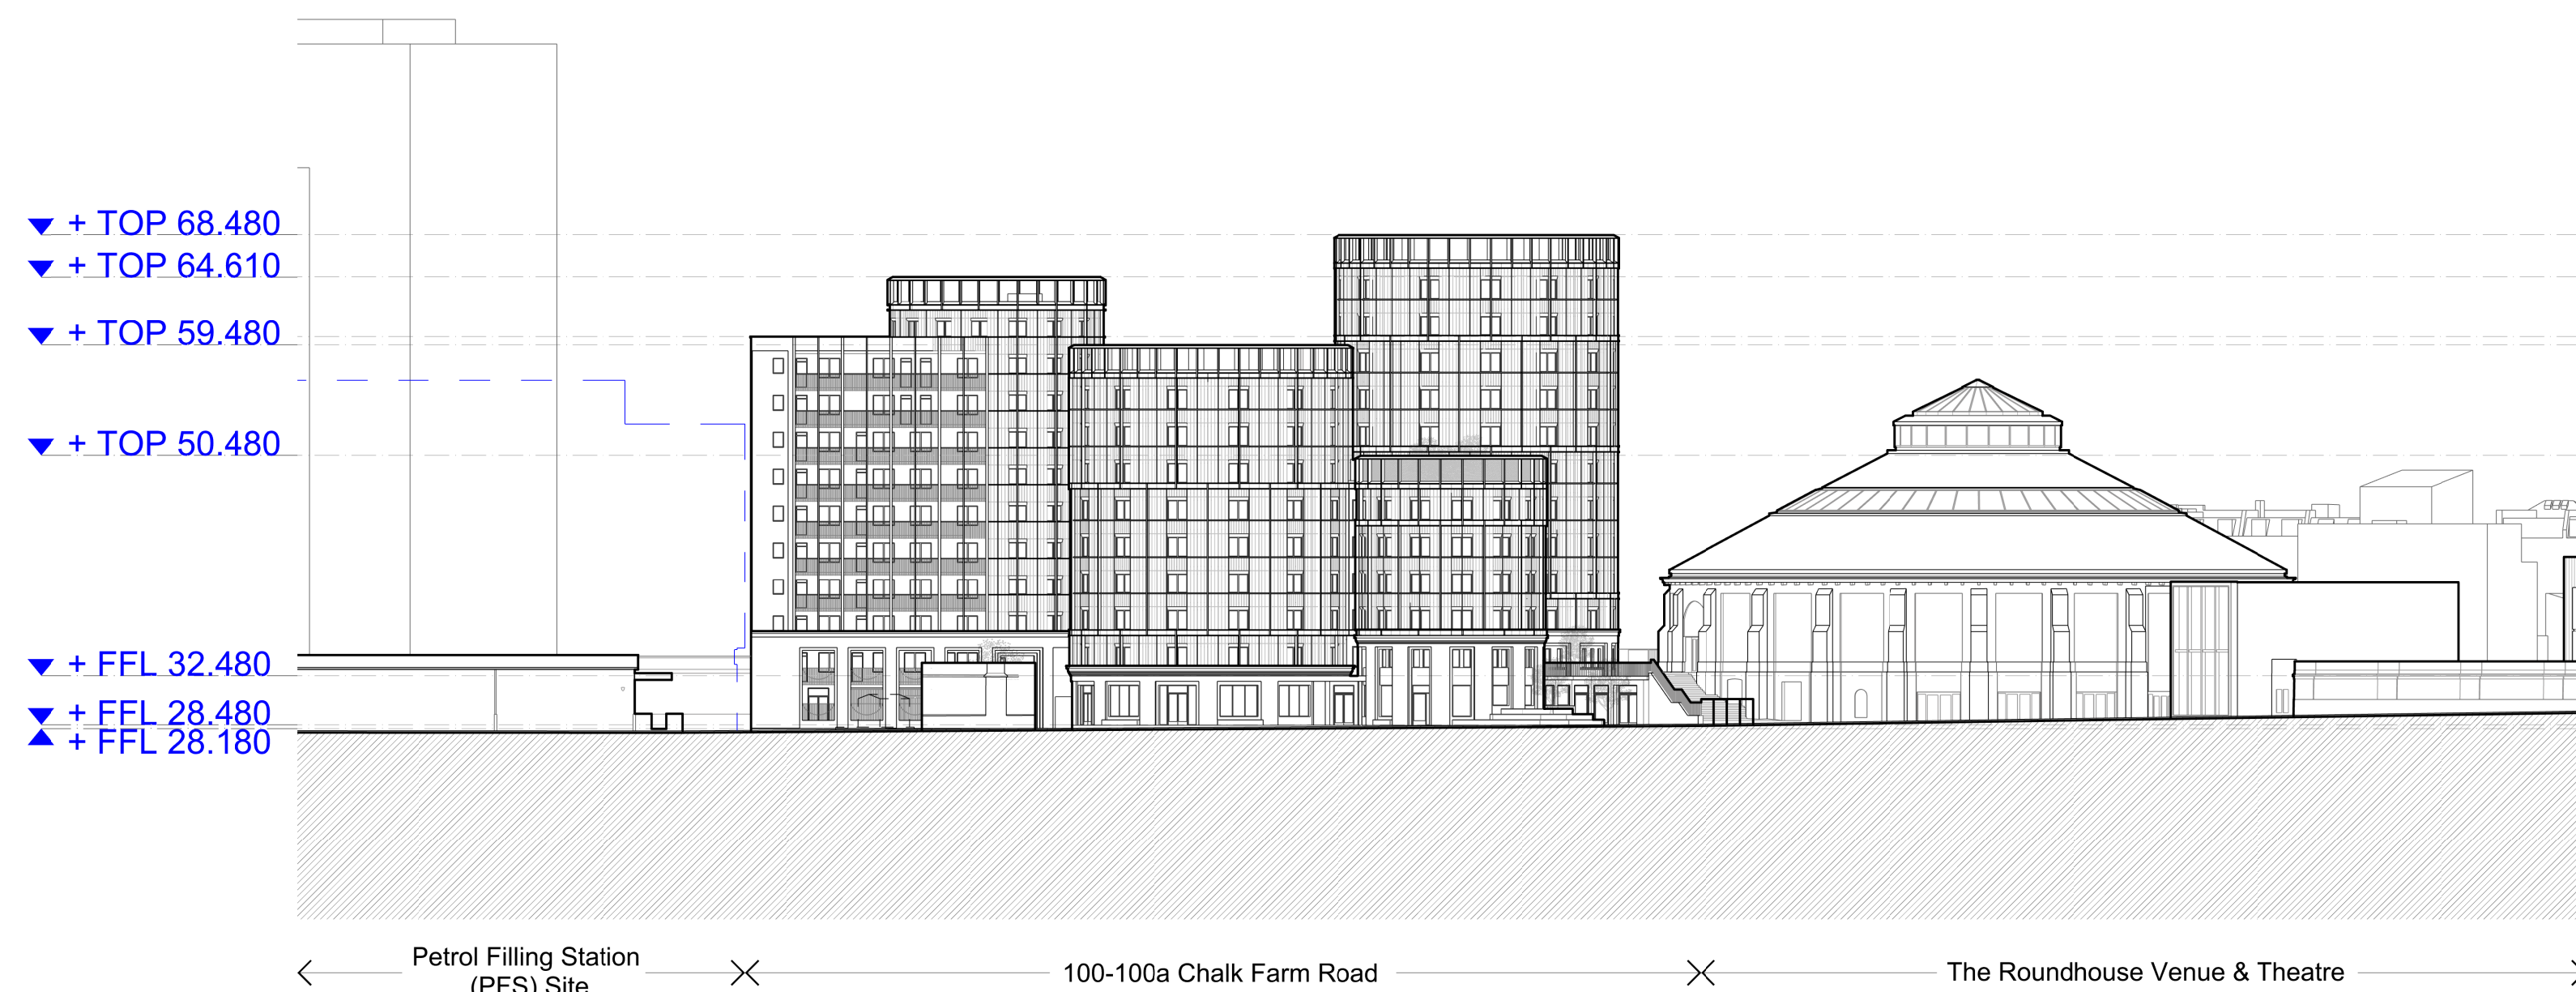


ICES

Key Plan

Elevation Marker

Application Boundary

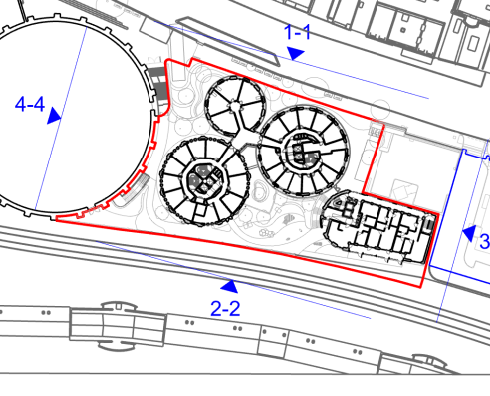

Drawing Key

Petrol Filling Station Consented Scheme. Planning Ref: 2022/3646/P

Roundhouse Hotel Consented Scheme. Planning Ref: 2021/0877/P

C 10/07/24 Planning

B 28/05/24 Planning

A 31/01/24 Planning

PLANNING


rev	date	check	comments																
DSDHA 357 Kennington Lane London SE11 5QY T 020 7703 3555 F 020 7703 3890 E info@dshda.co.uk W www.dshda.co.uk																			
project																			
100 Chalk Farm Road																			
drawing title																			
Context Elevations																			
<table><tr><th>drawn</th><th>size</th><th>date</th><th>scale</th></tr><tr><td>Fl</td><td>A1</td><td>10/07/24</td><td>1:500</td></tr><tr><td colspan="3">drawing number</td><td>revision</td></tr><tr><td colspan="3">356_P30.104</td><td>C</td></tr></table>				drawn	size	date	scale	Fl	A1	10/07/24	1:500	drawing number			revision	356_P30.104			C
drawn	size	date	scale																
Fl	A1	10/07/24	1:500																
drawing number			revision																
356_P30.104			C																
REPORT DISCREPANCIES DO NOT SCALE FROM THIS DRAWING COPYRIGHT DSDHA		USE LATEST REVISION CHECK DIMENSIONS ON SITE																	

▼ + TOP 68.480

▼ + TOP 59.480

▼ + TOP 50.480

▼ + FFL 28.480

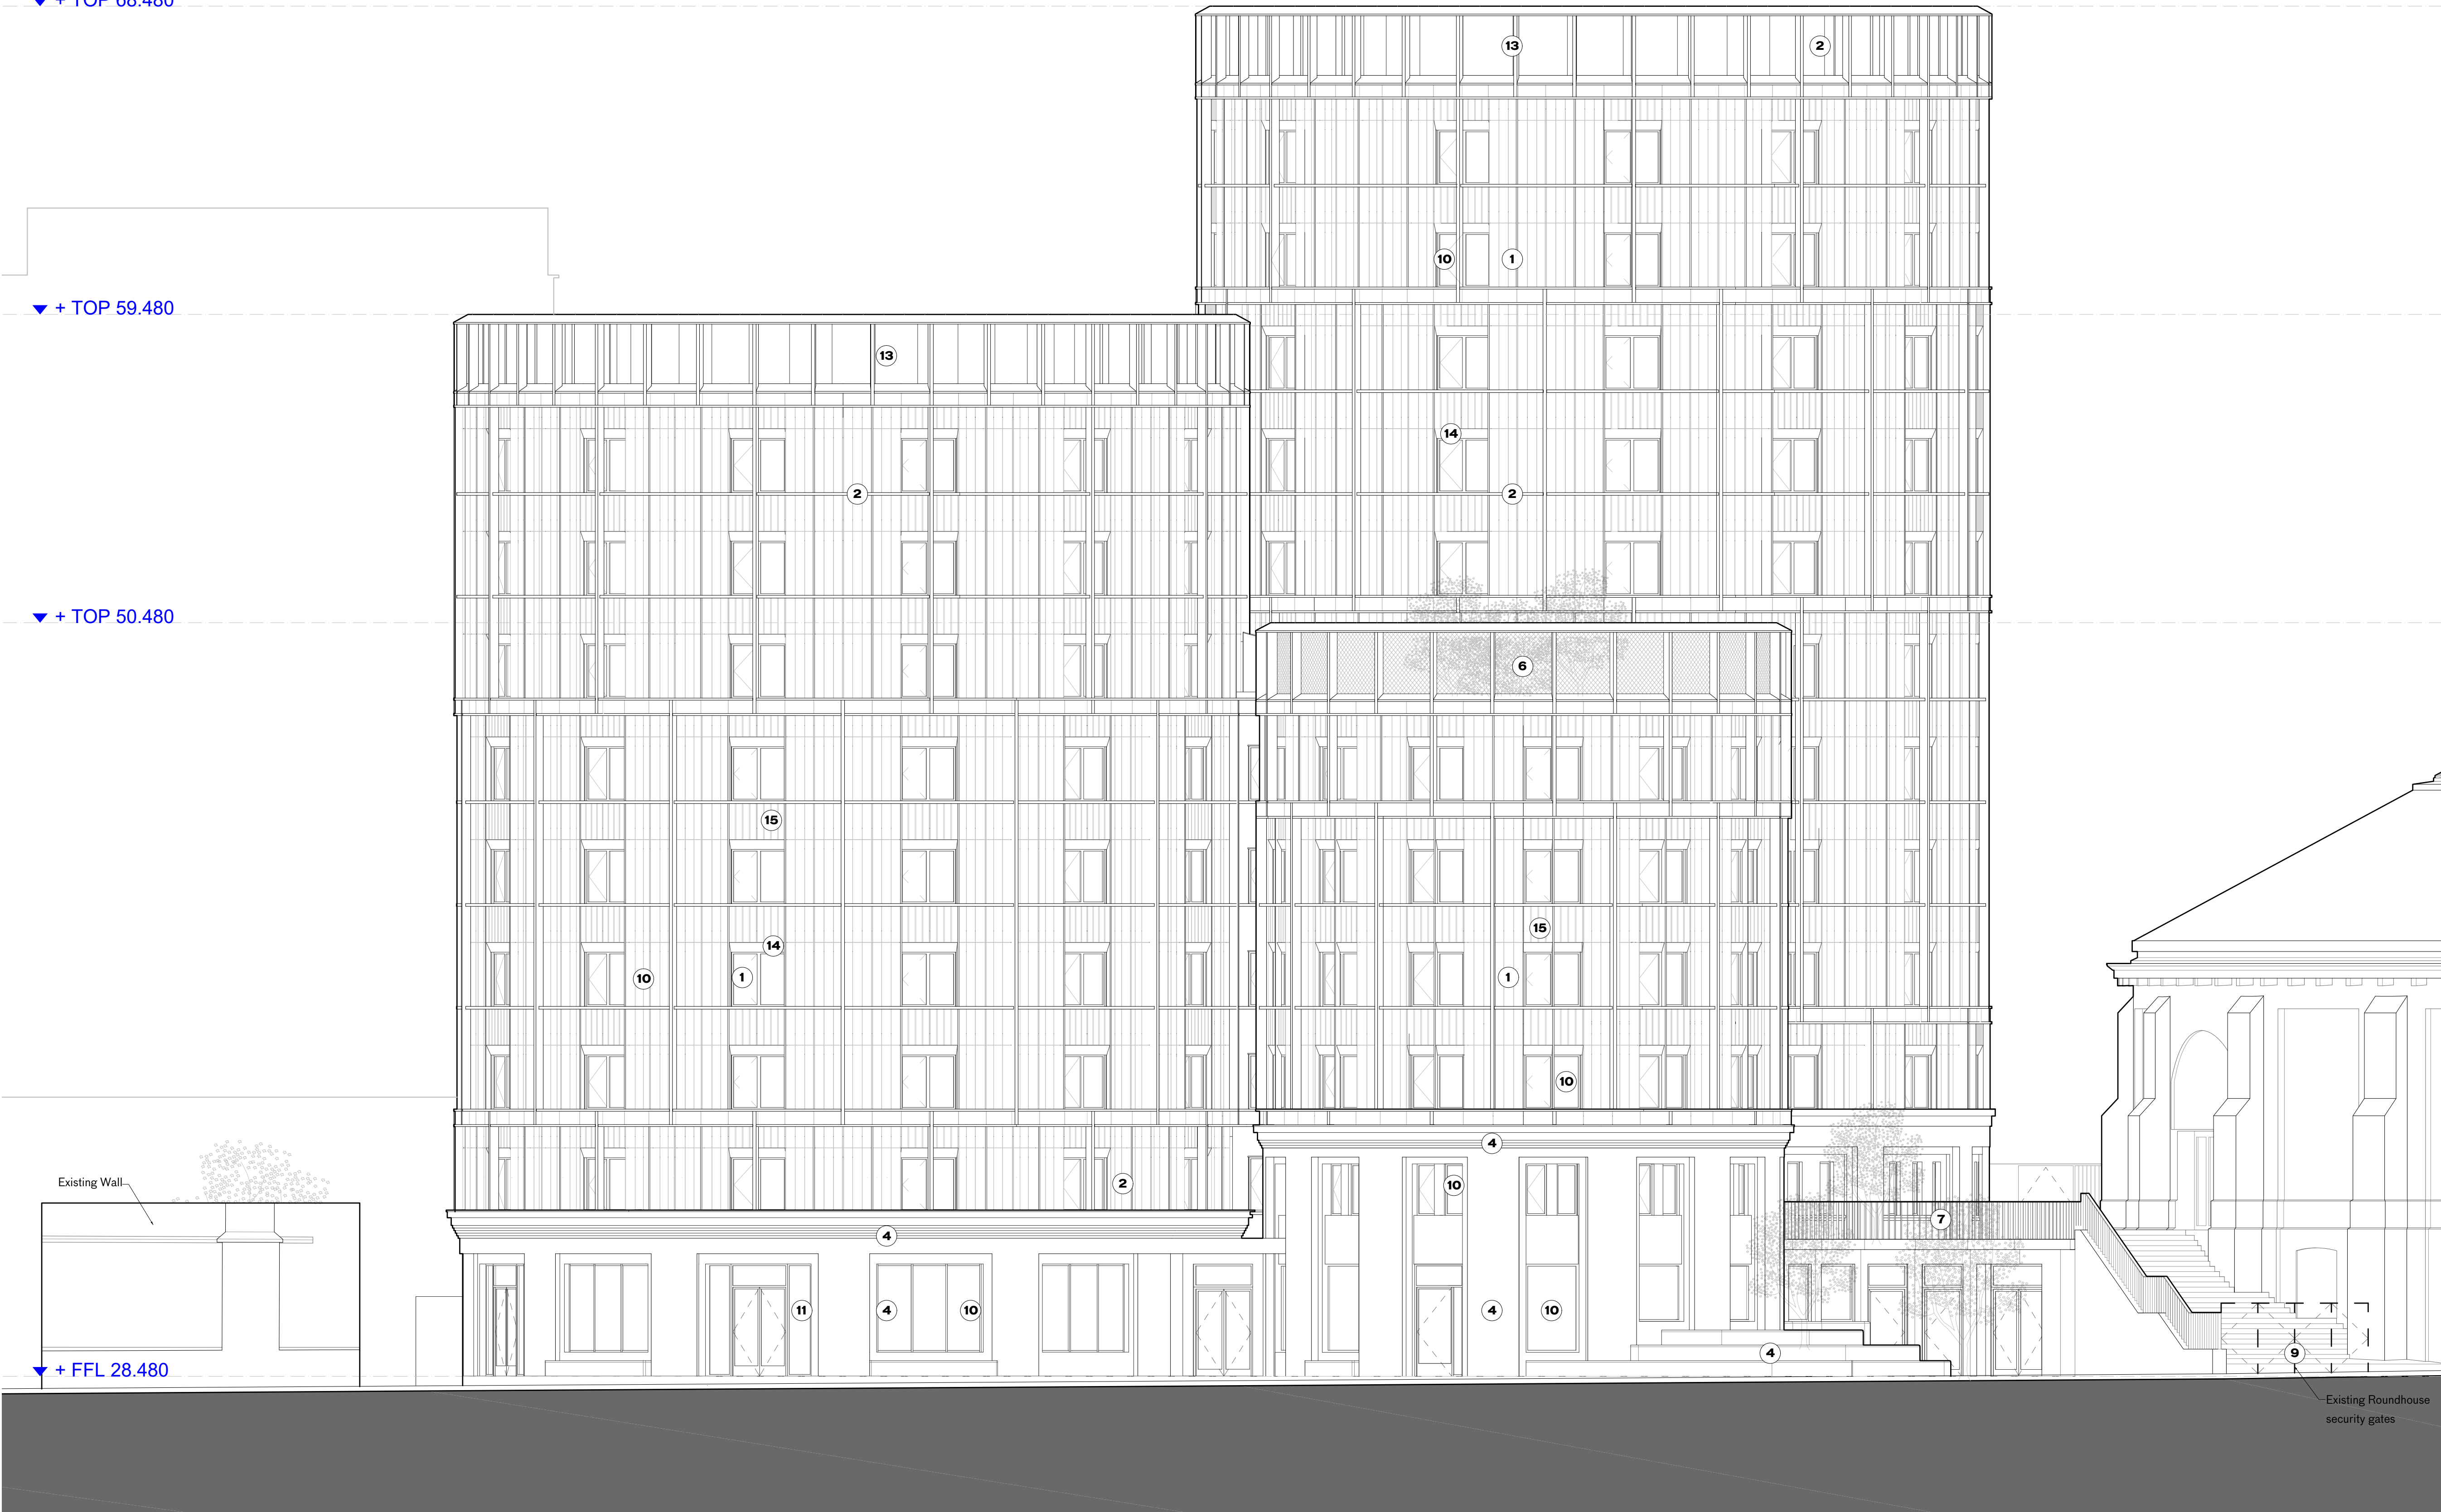


← Petrol Filling Station (PFS) Site →

100-100a Chalk Farm Road

→ The Roundhouse Venue & Theatre


PBSA Building North Elevation 1-1

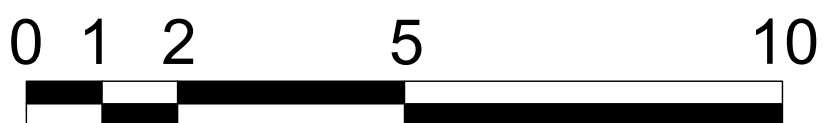

NOTES

Key Plan

▼ Elevation Marker
— Application Boundary

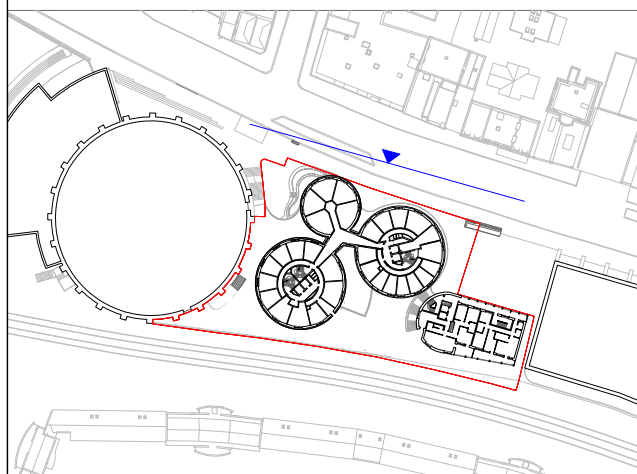

Drawing Key

Material Key

- 1 - Terracotta Cladding - Type 1
- 2 - Aluminium Profile
- 3 - Aluminium Cladding
- 4 - Brick
- 5 - Glazed Brick
- 6 - Metal Mesh
- 7 - Metal Balustrade
- 8 - Metal Fence
- 9 - Metal Gate
- 10 - Aluminium Framed Window
- 11 - Aluminium Framed Door
- 12 - Aluminium Louvers
- 13 - Plant Enclosure
- 14 - Metal Perforated Cladding
- 15 - Terracotta Cladding - Type 2

C 28/05/24 Planning
B 25/04/24 Revised window header and plinth
A 31/01/24 Planning submission

PLANNING

rev date check comments
DSDHA
357 Kennington Lane London SE11 5QY
T 020 7703 3555
F 020 7703 3890
E info@dshdha.co.uk
W www.dshdha.co.uk
project

100 Chalk Farm Road

drawing title

PBSA Building North Elevation

drawn	size	date	scale
FI	A1	28/05/24	1:100
drawing number			revision
356_P30.120			C


REPORT DISCREPANCIES
DO NOT SCALE FROM THIS DRAWING
COPYRIGHT DSDHA

USE LATEST REVISION
CHECK DIMENSIONS ON SITE



← The Roundhouse Venue & Theatre 100-100a Chalk Farm Road →

PBSA Building South Elevation 2-2

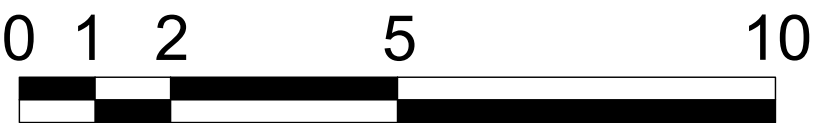

NOTES

Key Plan

Elevation Marker

Application Boundary

Drawing Key

Proposed Affordable Housing Building Outline

Material Key

1 - Terracotta Cladding - Type 1

2 - Aluminium Profile

3 - Aluminium Cladding

4 - Brick

5 - Glazed Brick

6 - Metal Mesh

7 - Metal Balustrade

8 - Metal Fence

9 - Metal Gate

10 - Aluminium Framed Window

11 - Aluminium Framed Door

12 - Aluminium Louvers

13 - Plant Enclosure

14 - Metal Perforated Cladding

15 - Terracotta Cladding - Type 2

C 28/05/24 Planning

B 25/04/24 Revised window header and plinth

A 31/01/24 Planning

PLANNING

rev	date	check	comments
DSDHA			
357 Kennington Lane London SE11 5QY			
T 020 7703 3555			
F 020 7703 3890			
E info@dsdha.co.uk			
W www.dsdha.co.uk			

project

100 Chalk Farm Road

drawing title

PBSA Building South Elevation


drawn	size	date	scale
FI	A1	28/05/24	1:100
drawing number			revision
356_P30.121			C

REPORT DISCREPANCIES
DO NOT SCALE FROM THIS DRAWING
COPYRIGHT DSDHA

USE LATEST REVISION
CHECK DIMENSIONS ON SITE



PBSA Building East Elevation 3-3

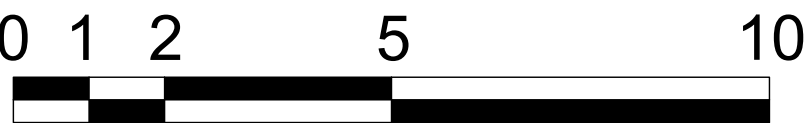

NOTES

Key Plan

Elevation Marker

Application Boundary

Drawing Key

Roundhouse Hotel Consented Scheme, Planning Ref. 2021/0877/P

Material Key

1

Terracotta Cladding - Type 1

2

Aluminium Profile

3

Aluminium Cladding

4

Brick

5

White Brick

6

Metal Mesh

7

Metal Balustrade

8

Metal Fence

9

Metal Gate

10

Aluminium Framed Window

11

Aluminium Framed Door

12

Aluminium Louvers

13

Plant Enclosure

14

Metal Perforated Cladding

15

Terracotta Cladding - Type 2

C 28/05/24 Planning

B 25/04/24 Revised window header and plinth

A 31/01/24 Planning

PLANNING

rev	date	check	comments
DSDHA			
357 Kennington Lane London SE11 5QY			
T 020 7703 3555			
F 020 7703 3890			
E info@dsha.co.uk			
W www.dsha.co.uk			
project			

100 Chalk Farm Road

drawing title

PBSA Building East Elevation

drawn	size	date	scale
FI	A1	31/01/24	1:100
drawing number			revision
356_P30.122			C

REPORT DISCREPANCIES
DO NOT SCALE FROM THIS DRAWING
COPYRIGHT DSDHA

USE LATEST REVISION
CHECK DIMENSIONS ON SITE



PBSA Building West Elevation 4-4

NOTES

Key Plan

Elevation Marker

Application Boundary

Drawing Key

Petrol Filling Station Consented Scheme, Planning Ref: 2022/3646/P

Material Key

1 - Terracotta Cladding - Type 1

2 - Aluminium Profile

3 - Aluminium Cladding

4 - Brick

5 - White Brick

6 - Metal Mesh

7 - Metal Balustrade

8 - Metal Fence

9 - Metal Gate

10 - Aluminium Framed Window

11 - Aluminium Framed Door

12 - Aluminium Louvers

13 - Plant Enclosure

14 - Metal Perforated Cladding

15 - Terracotta Cladding - Type 2

C 28/05/24 Planning

B 25/04/24 Revised window header and plinth

A 31/01/24 Planning

PLANNING

rev	date	check	comments
DSDHA 357 Kennington Lane London SE11 5QY T 020 7703 3555 F 020 7703 3890 E info@dsdha.co.uk W www.dsdha.co.uk			

project

100 Chalk Farm Road


drawing title

PBSA Building West Elevation

drawn	size	date	scale
FI	A1	25/04/24	1:100
drawing number			revision
356_P30.123			C

REPORT DISCREPANCIES
DO NOT SCALE FROM THIS DRAWING
COPYRIGHT DSDHA

USE LATEST REVISION
CHECK DIMENSIONS ON SITE

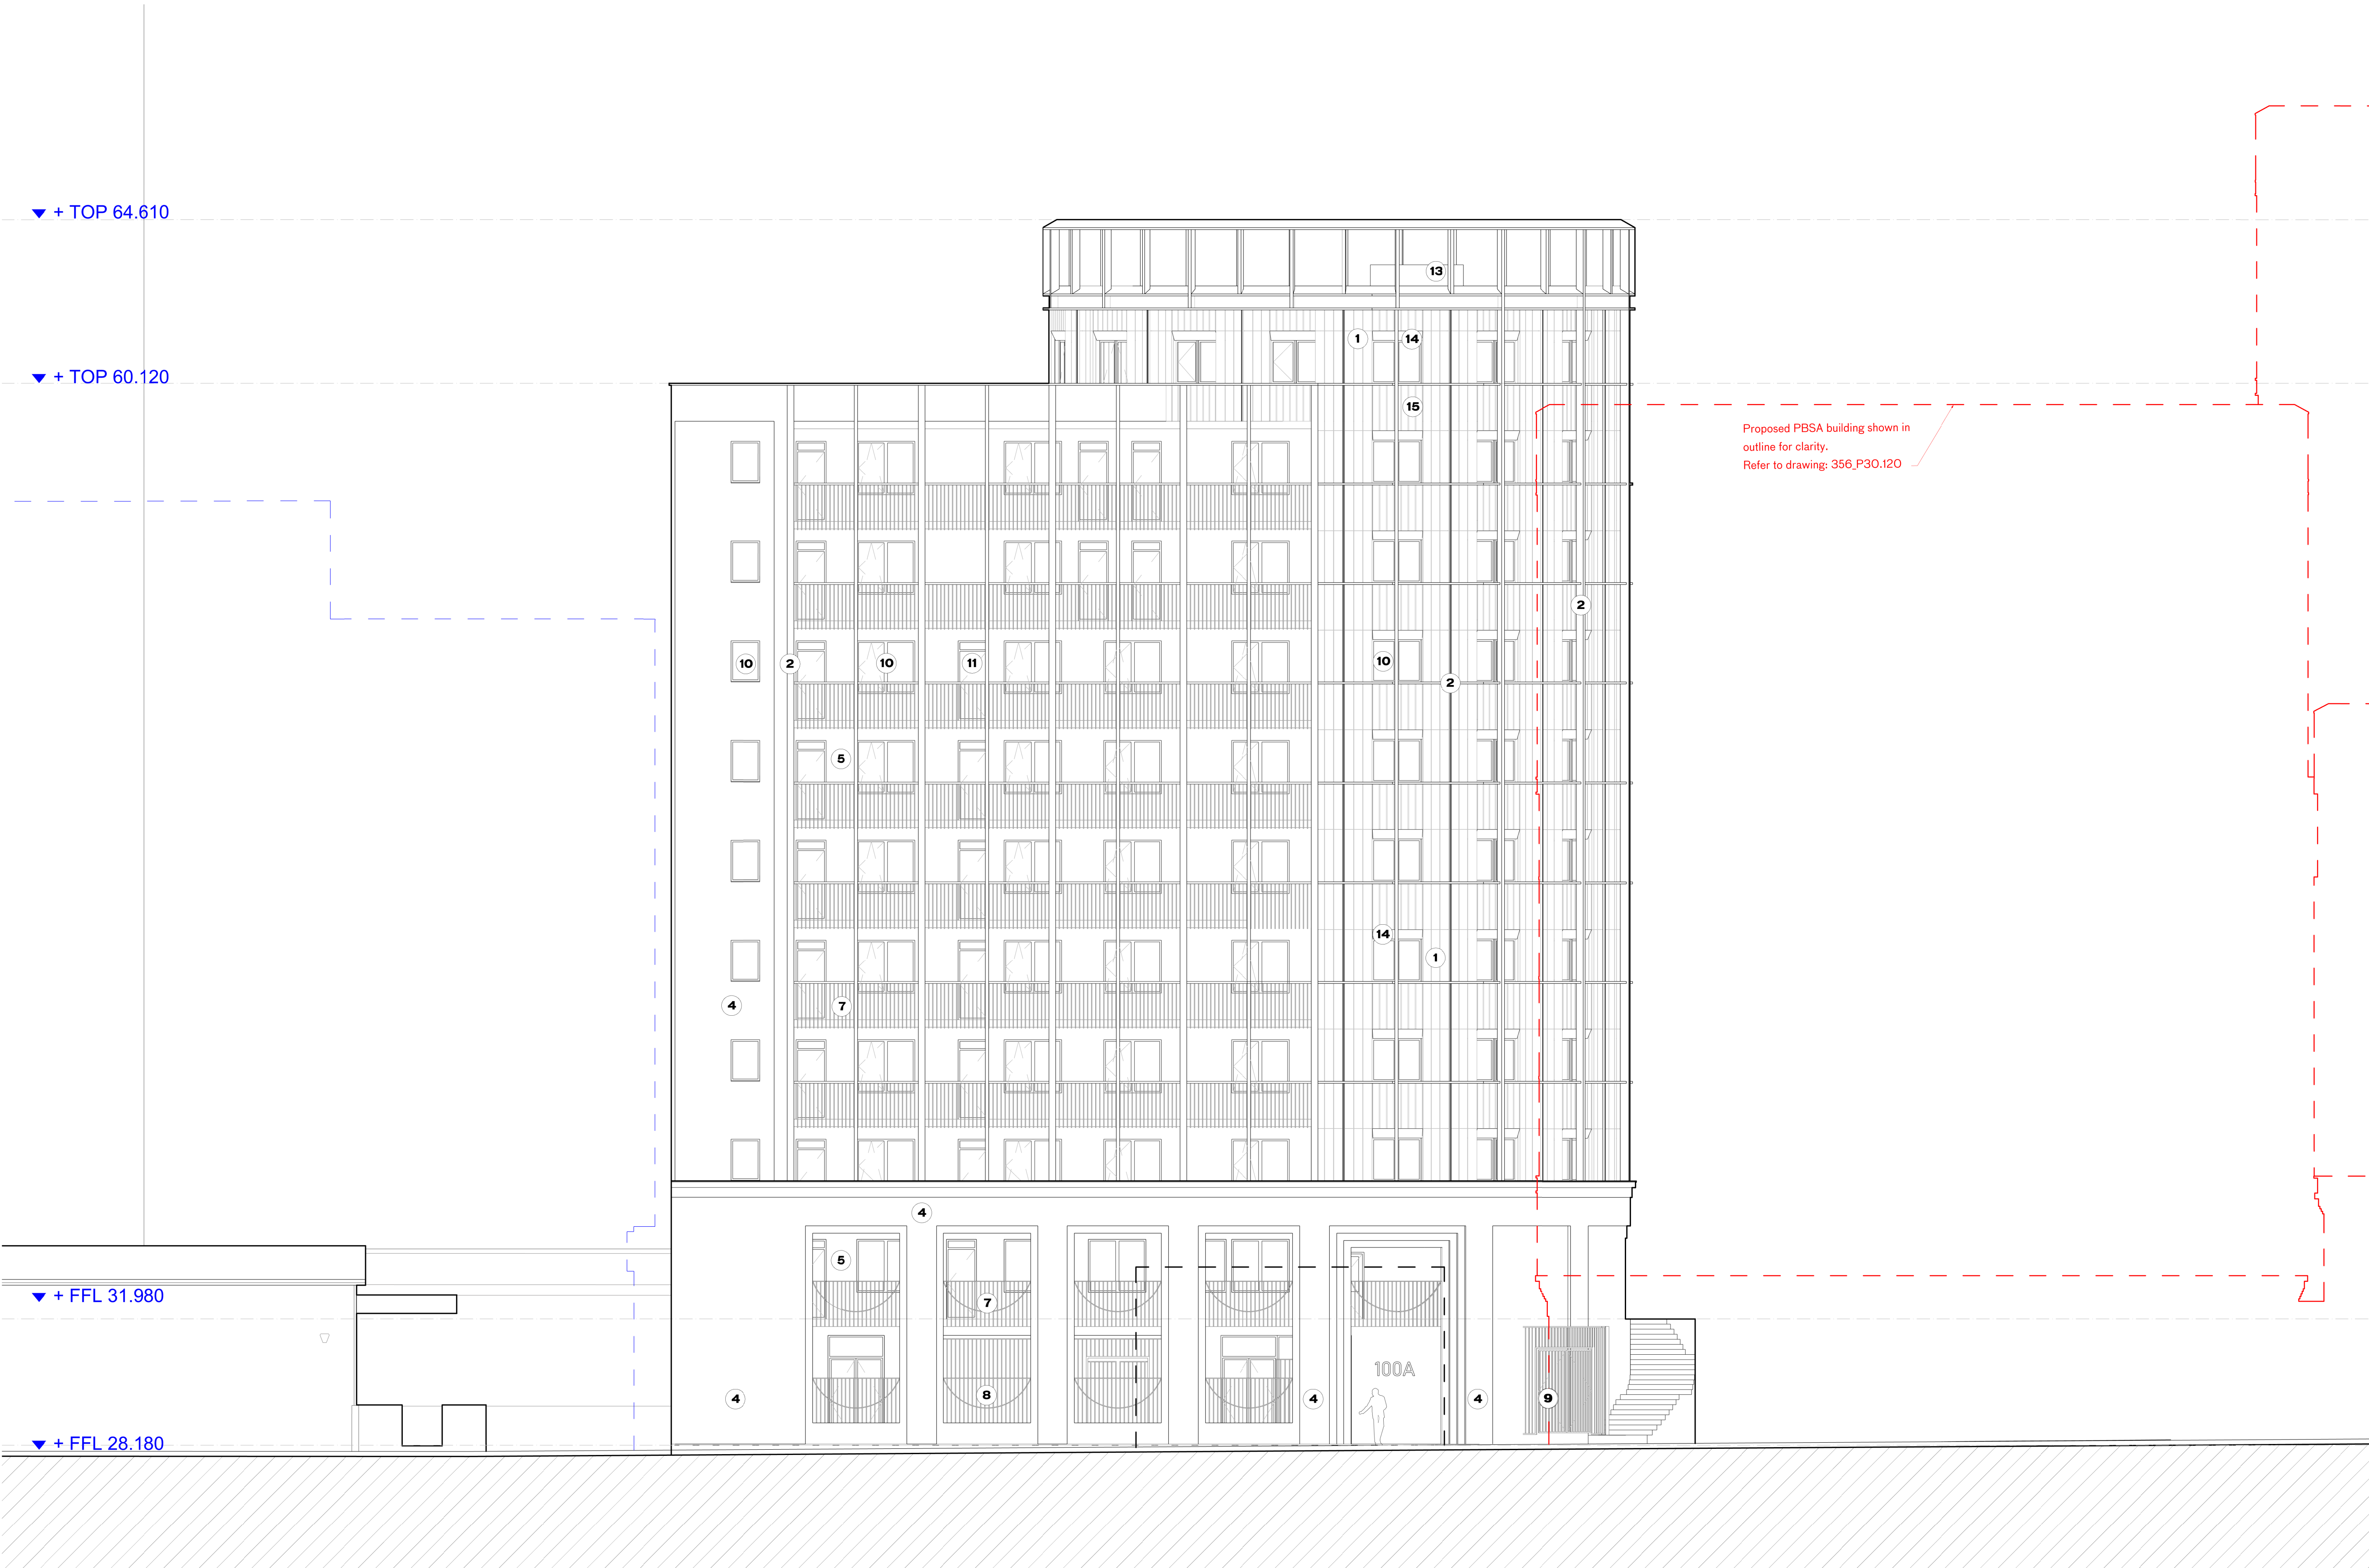

Affordable Housing North Elevation 5-5

NOTES

Key Plan

Elevation Marker

Application Boundary

Drawing Key

Petrol Filling Station Consented Scheme, Planning Ref: 2022/3646/P

Proposed PBSA Building Outline

Material Key

1 - Terracotta Cladding - Type 1

2 - Aluminium Profile

3 - Aluminium Cladding

4 - Brick

5 - White Brick

6 - Metal Mesh

7 - Metal Balustrade

8 - Metal Fence

9 - Metal Gate

10 - Aluminium Framed Window

11 - Aluminium Framed Door

12 - Aluminium Louvers

13 - Plant Enclosure

14 - Metal Perforated Cladding

15 - Terracotta Cladding - Type 2

E 10/07/24 Planning _ Revised AH Corner


C 28/05/24 Planning

B 25/04/24 Revised facade and openings

A 31/01/24 Planning

PLANNING

rev	date	check	comments
DSDHA 357 Kennington Lane London SE11 5QY T 020 7703 3555 F 020 7703 3890 E info@dsdha.co.uk W www.dsdha.co.uk			
project			
100 Chalk Farm Road			
drawing title			
Affordable Housing North Elevation			
drawn	size	date	scale
FI	A1	10/07/2024	1:100
drawing number			revision
356_P30.130			E
REPORT DISCREPANCIES DO NOT SCALE FROM THIS DRAWING COPYRIGHT DSDHA		USE LATEST REVISION CHECK DIMENSIONS ON SITE	

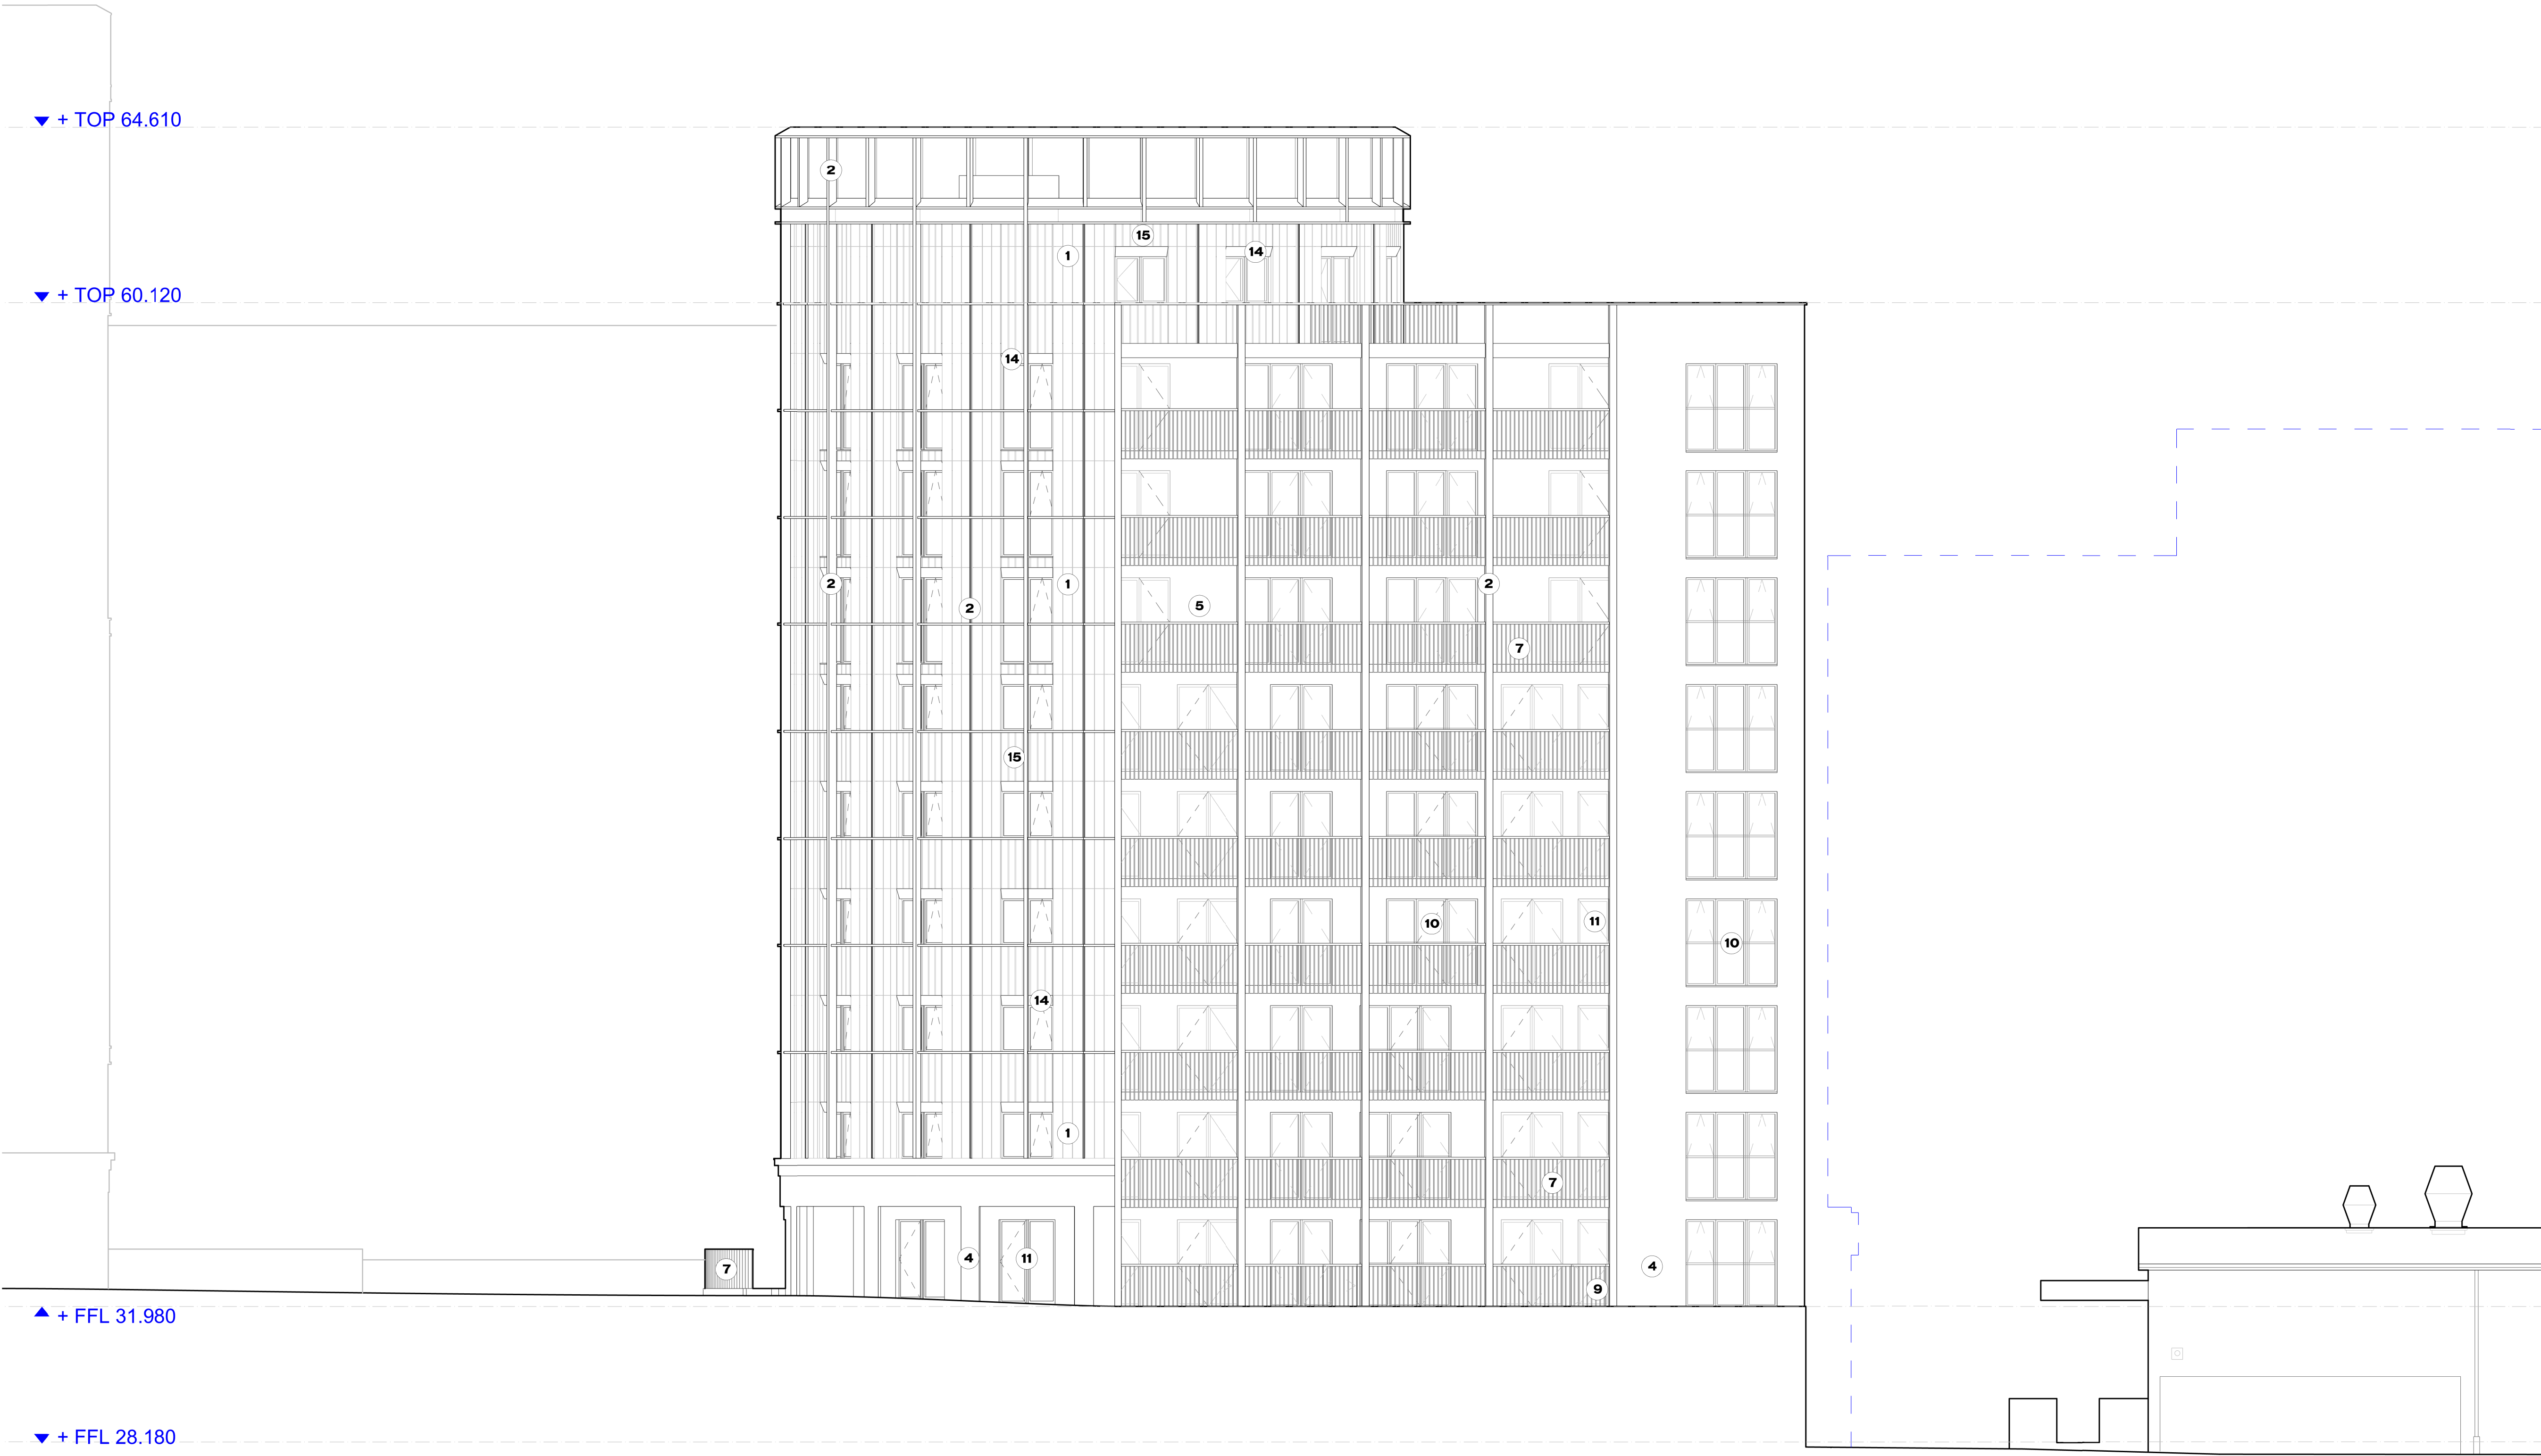

Affordable Housing South Elevation 6-6

NOTES

Key Plan

Elevation Marker

Application Boundary

Drawing Key

Petrol Filling Station Consented Scheme, Planning Ref: 2022/3646/P

Material Key

1 - Terracotta Cladding - Type 1

2 - Aluminium Profile

3 - Aluminium Cladding

4 - Brick

5 - White Brick

6 - Metal Mesh

7 - Metal Balustrade

8 - Metal Fence

9 - Metal Gate

10 - Aluminium Framed Window

11 - Aluminium Framed Door

12 - Aluminium Louvers

13 - Plant Enclosure

14 - Metal Perforated Cladding

15 - Terracotta Cladding - Type 2

E 10/07/24 Planning _ Revised AH Corner

D 18/06/24 Planning _ Revised AH Layouts

C 28/05/24 Planning

B 25/04/24 Revised facade and openings

A 31/01/24 Planning

PLANNING

rev	date	check	comments
DSDHA			
357 Kennington Lane London SE11 5QY			
T 020 7703 3555			
F 020 7703 3890			
E info@dshda.co.uk			
W www.dshda.co.uk			
project			

100 Chalk Farm Road


drawing title

Affordable Housing South Elevation


drawn	size	date	scale
FI	A1	10/07/2024	1:100
drawing number			revision
356_P30.131			E

REPORT DISCREPANCIES
DO NOT SCALE FROM THIS DRAWING
COPYRIGHT DSDHA

USE LATEST REVISION
CHECK DIMENSIONS ON SITE

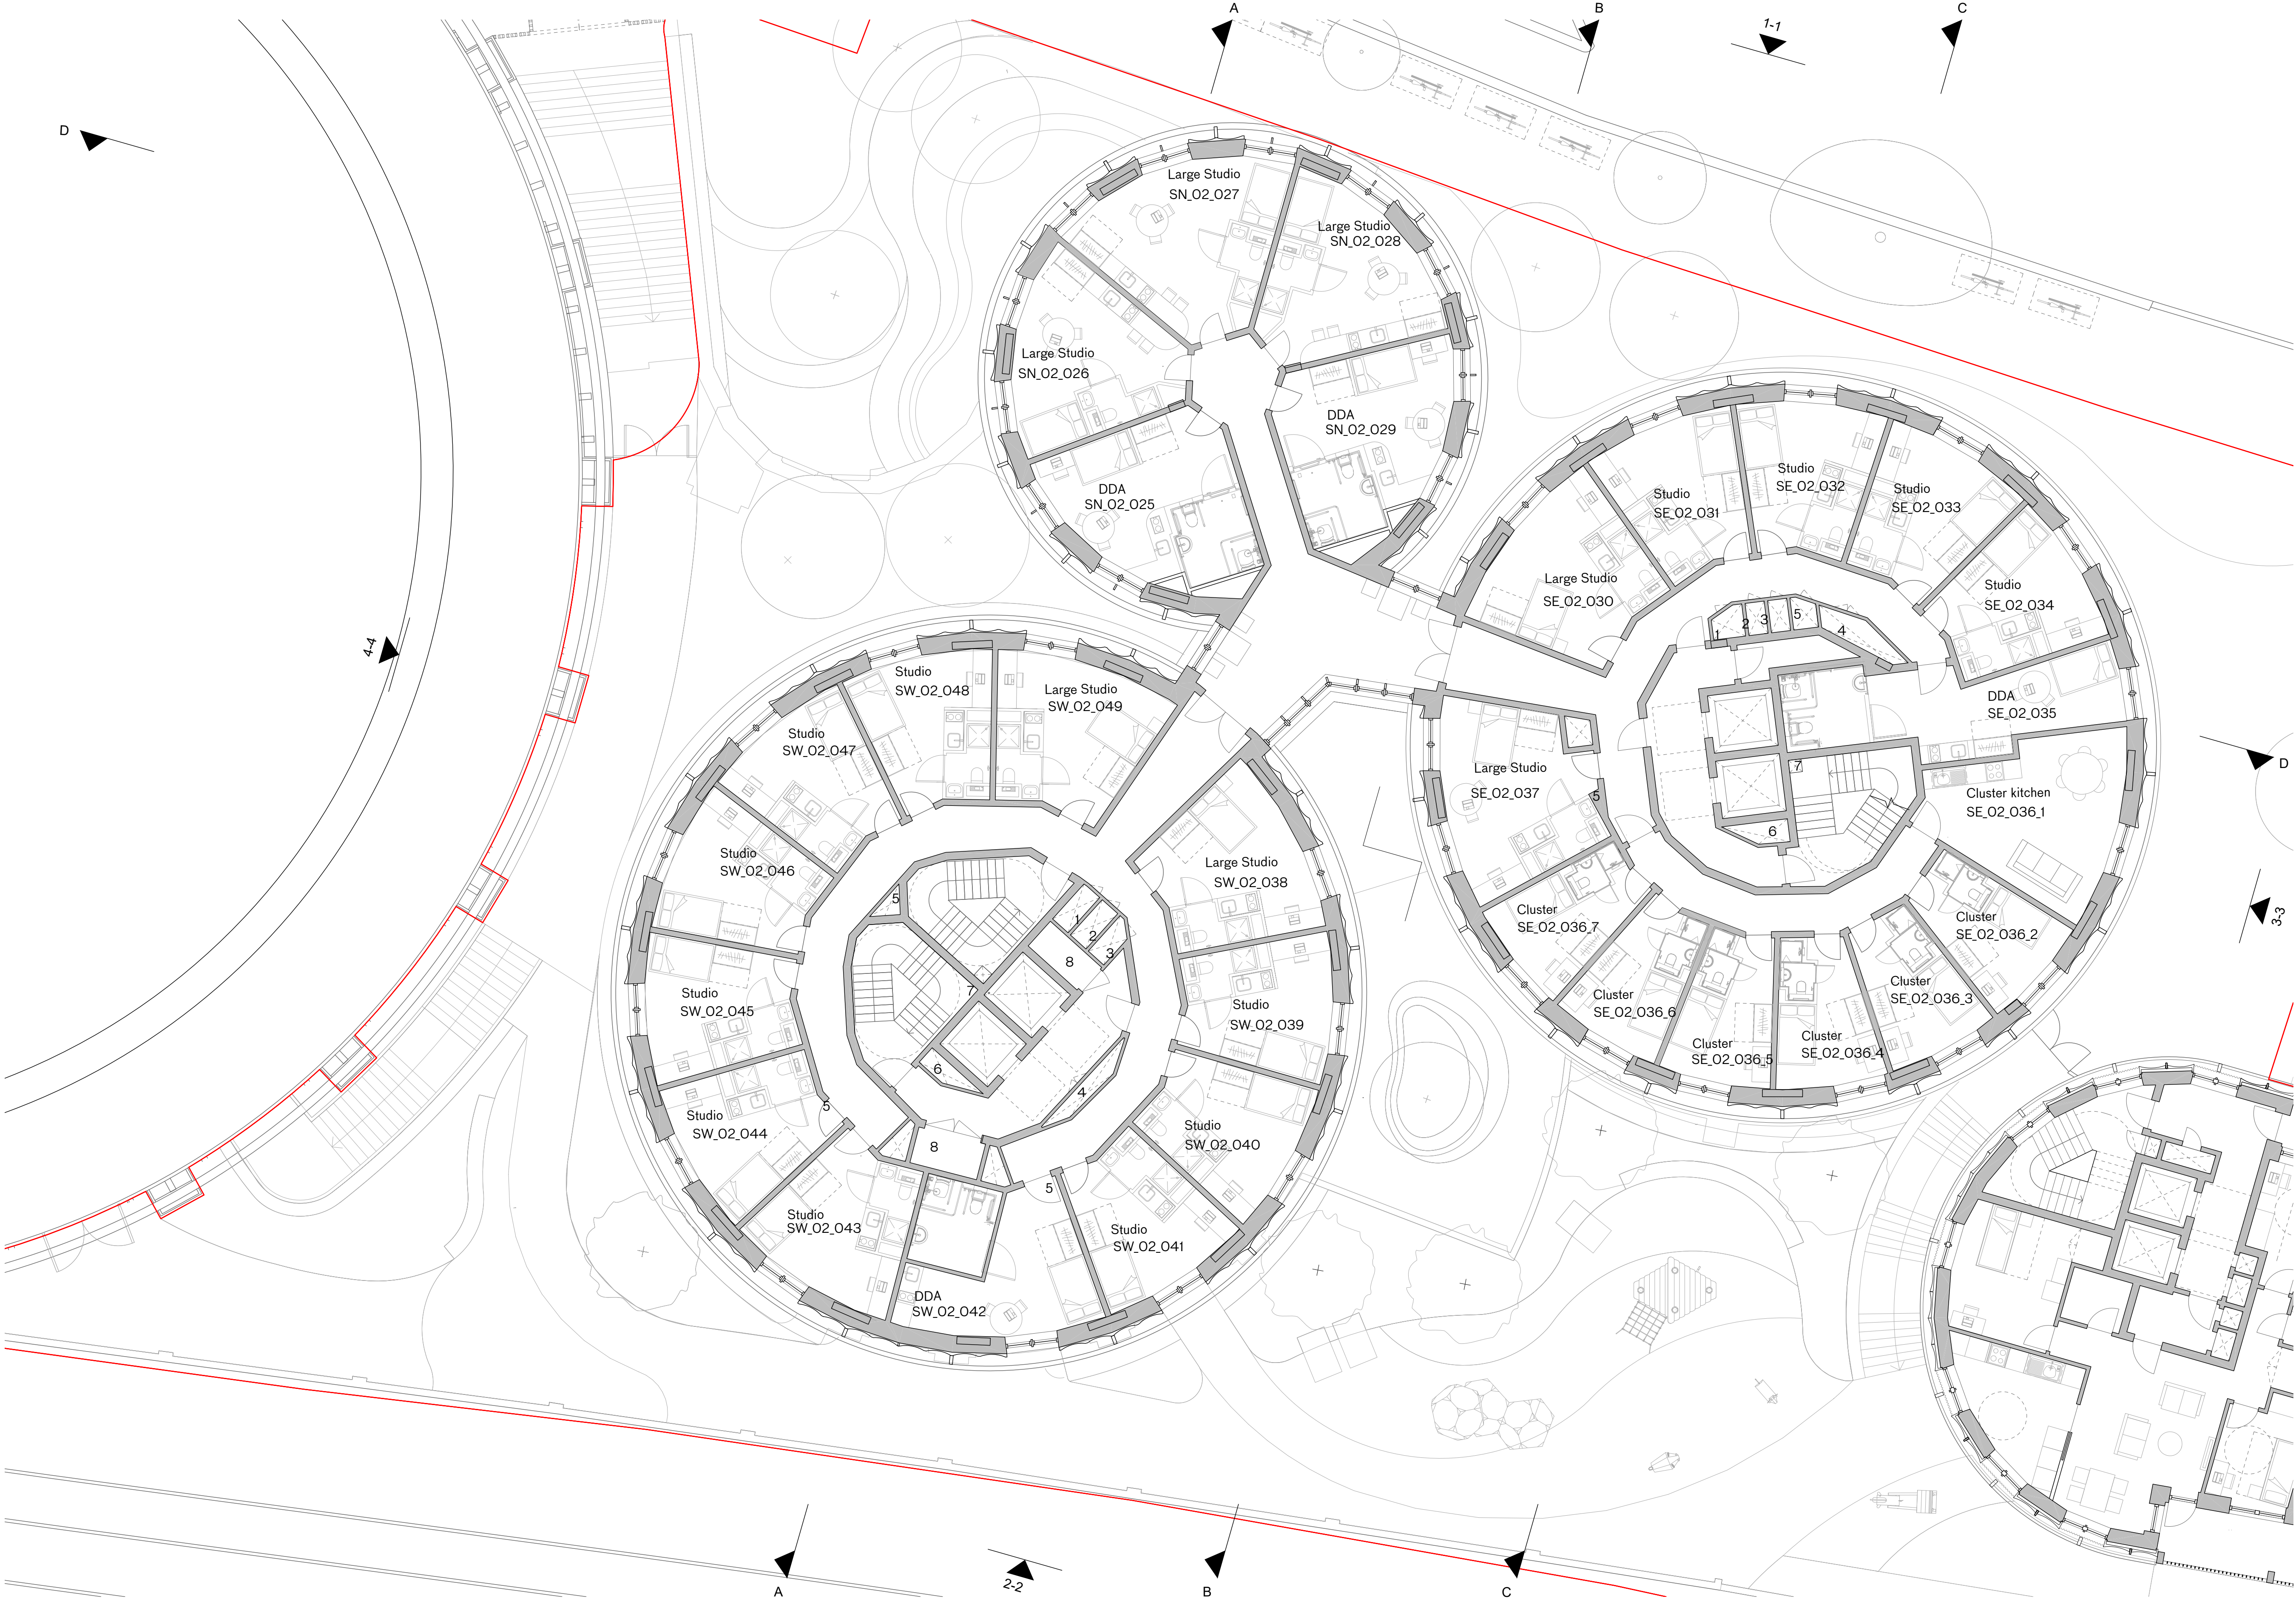

PBSA Level 2 - 4 Floor Plan

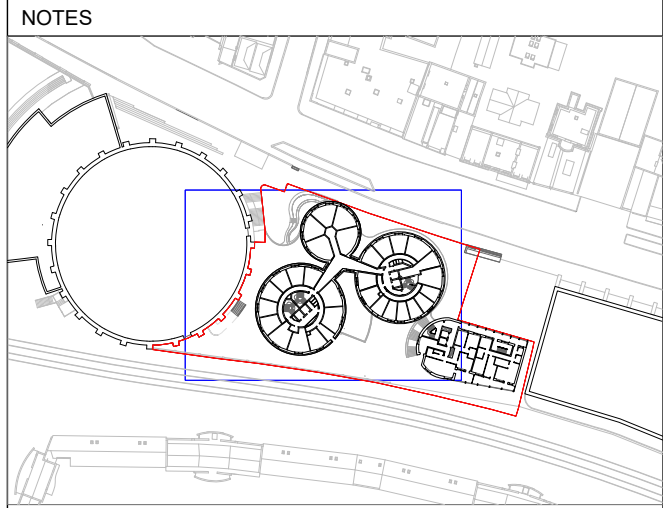

- Key to Risers
- 1 Heating Riser
 - 2 Water Riser
 - 3 Comms Riser
 - 4 Electrical Riser
 - 5 Smoke Outlet
 - 6 Smoke Inlet
 - 7 Dry Riser
 - 8 MVHR Cupboard
 - 9 Mechanical Ventilation
- Site Boundary
- Petrol Filling Station Consented Scheme. Planning Ref: 2022/3646/P

C -28/05/24 Planning
B -17/05/24 Revised PBSA Layouts
A - 31/01/24 Planning

PLANNING


rev	date	check	comments
DSDHA 357 Kennington Lane London SE11 5QY T 020 7703 3555 F 020 7703 3890 E info@dsdha.co.uk W www.dsdha.co.uk			
project			
100 Chalk Farm Road			
drawing title			
PBSA Level 2 - 4 Floor Plan			
drawn	size	date	scale
FI	A1	28/05/24	1 : 100
drawing number			revision
356_P20.132			C
REPORT DISCREPANCIES DO NOT SCALE FROM THIS DRAWING COPYRIGHT DSDHA		USE LATEST REVISION CHECK DIMENSIONS ON SITE	

▼ + TOP 64.610

▼ + TOP 60.120

▼ + FFL 31.980

▲ + FFL 28.180

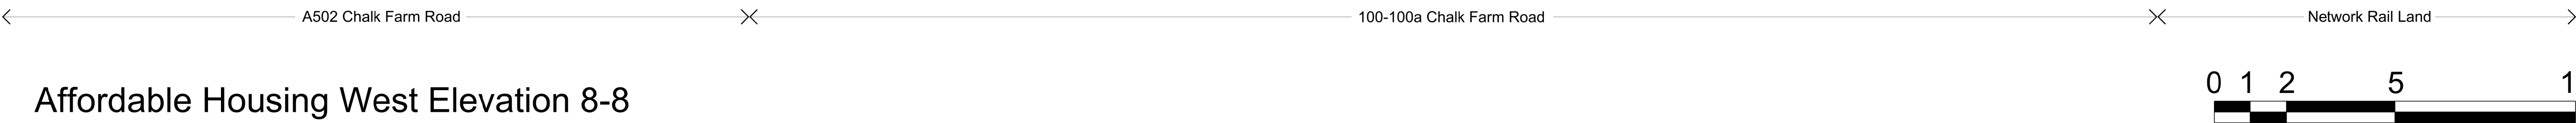


Affordable Housing West Elevation 8-8

NOTES

Key Plan

▼ Elevation Marker
Application Boundary

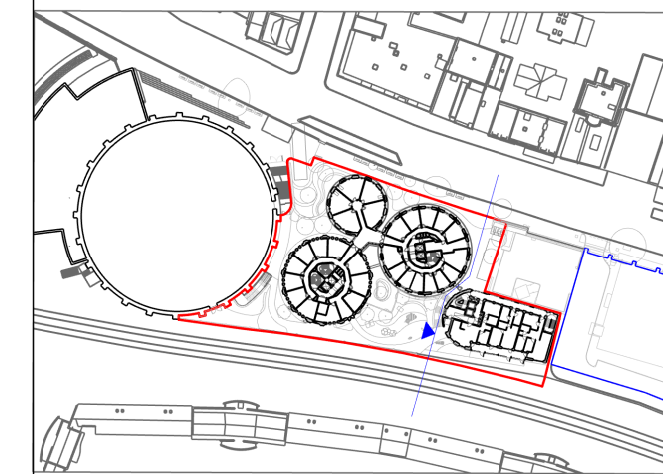

Drawing Key

Petrol Filling Station Consented Scheme, Planning Ref: 2022/3646/P

Material Key

- 1 - Terracotta Cladding - Type 1
- 2 - Aluminium Profile
- 3 - Aluminium Cladding
- 4 - Brick
- 5 - White Brick
- 6 - Metal Mesh
- 7 - Metal Balustrade
- 8 - Metal Fence
- 9 - Metal Gate
- 10 - Aluminium Framed Window
- 11 - Aluminium Framed Door
- 12 - Aluminium Louvers
- 13 - Plant Enclosure
- 14 - Metal Perforated Cladding
- 15 - Terracotta Cladding - Type 2

E 10/07/24 Planning _ Revised AH Corner
C 28/05/24 Planning
B 25/04/24 Revised facade and openings
A 31/01/24 Planning

PLANNING

rev	date	check	comments
-----	------	-------	----------

DSDHA			
357 Kennington Lane London SE11 5QY			
T 020 7703 3555			
F 020 7703 3890			
E info@dsdha.co.uk			
W www.dsdha.co.uk			

project

100 Chalk Farm Road

drawing title

Affordable Housing West Elevation

drawn	size	date	scale
FI	A1	10/07/2024	1:100

drawing number	revision
356_P30.133	E

REPORT DISCREPANCIES DO NOT SCALE FROM THIS DRAWING COPYRIGHT DSDHA	USE LATEST REVISION CHECK DIMENSIONS ON SITE
---	---