
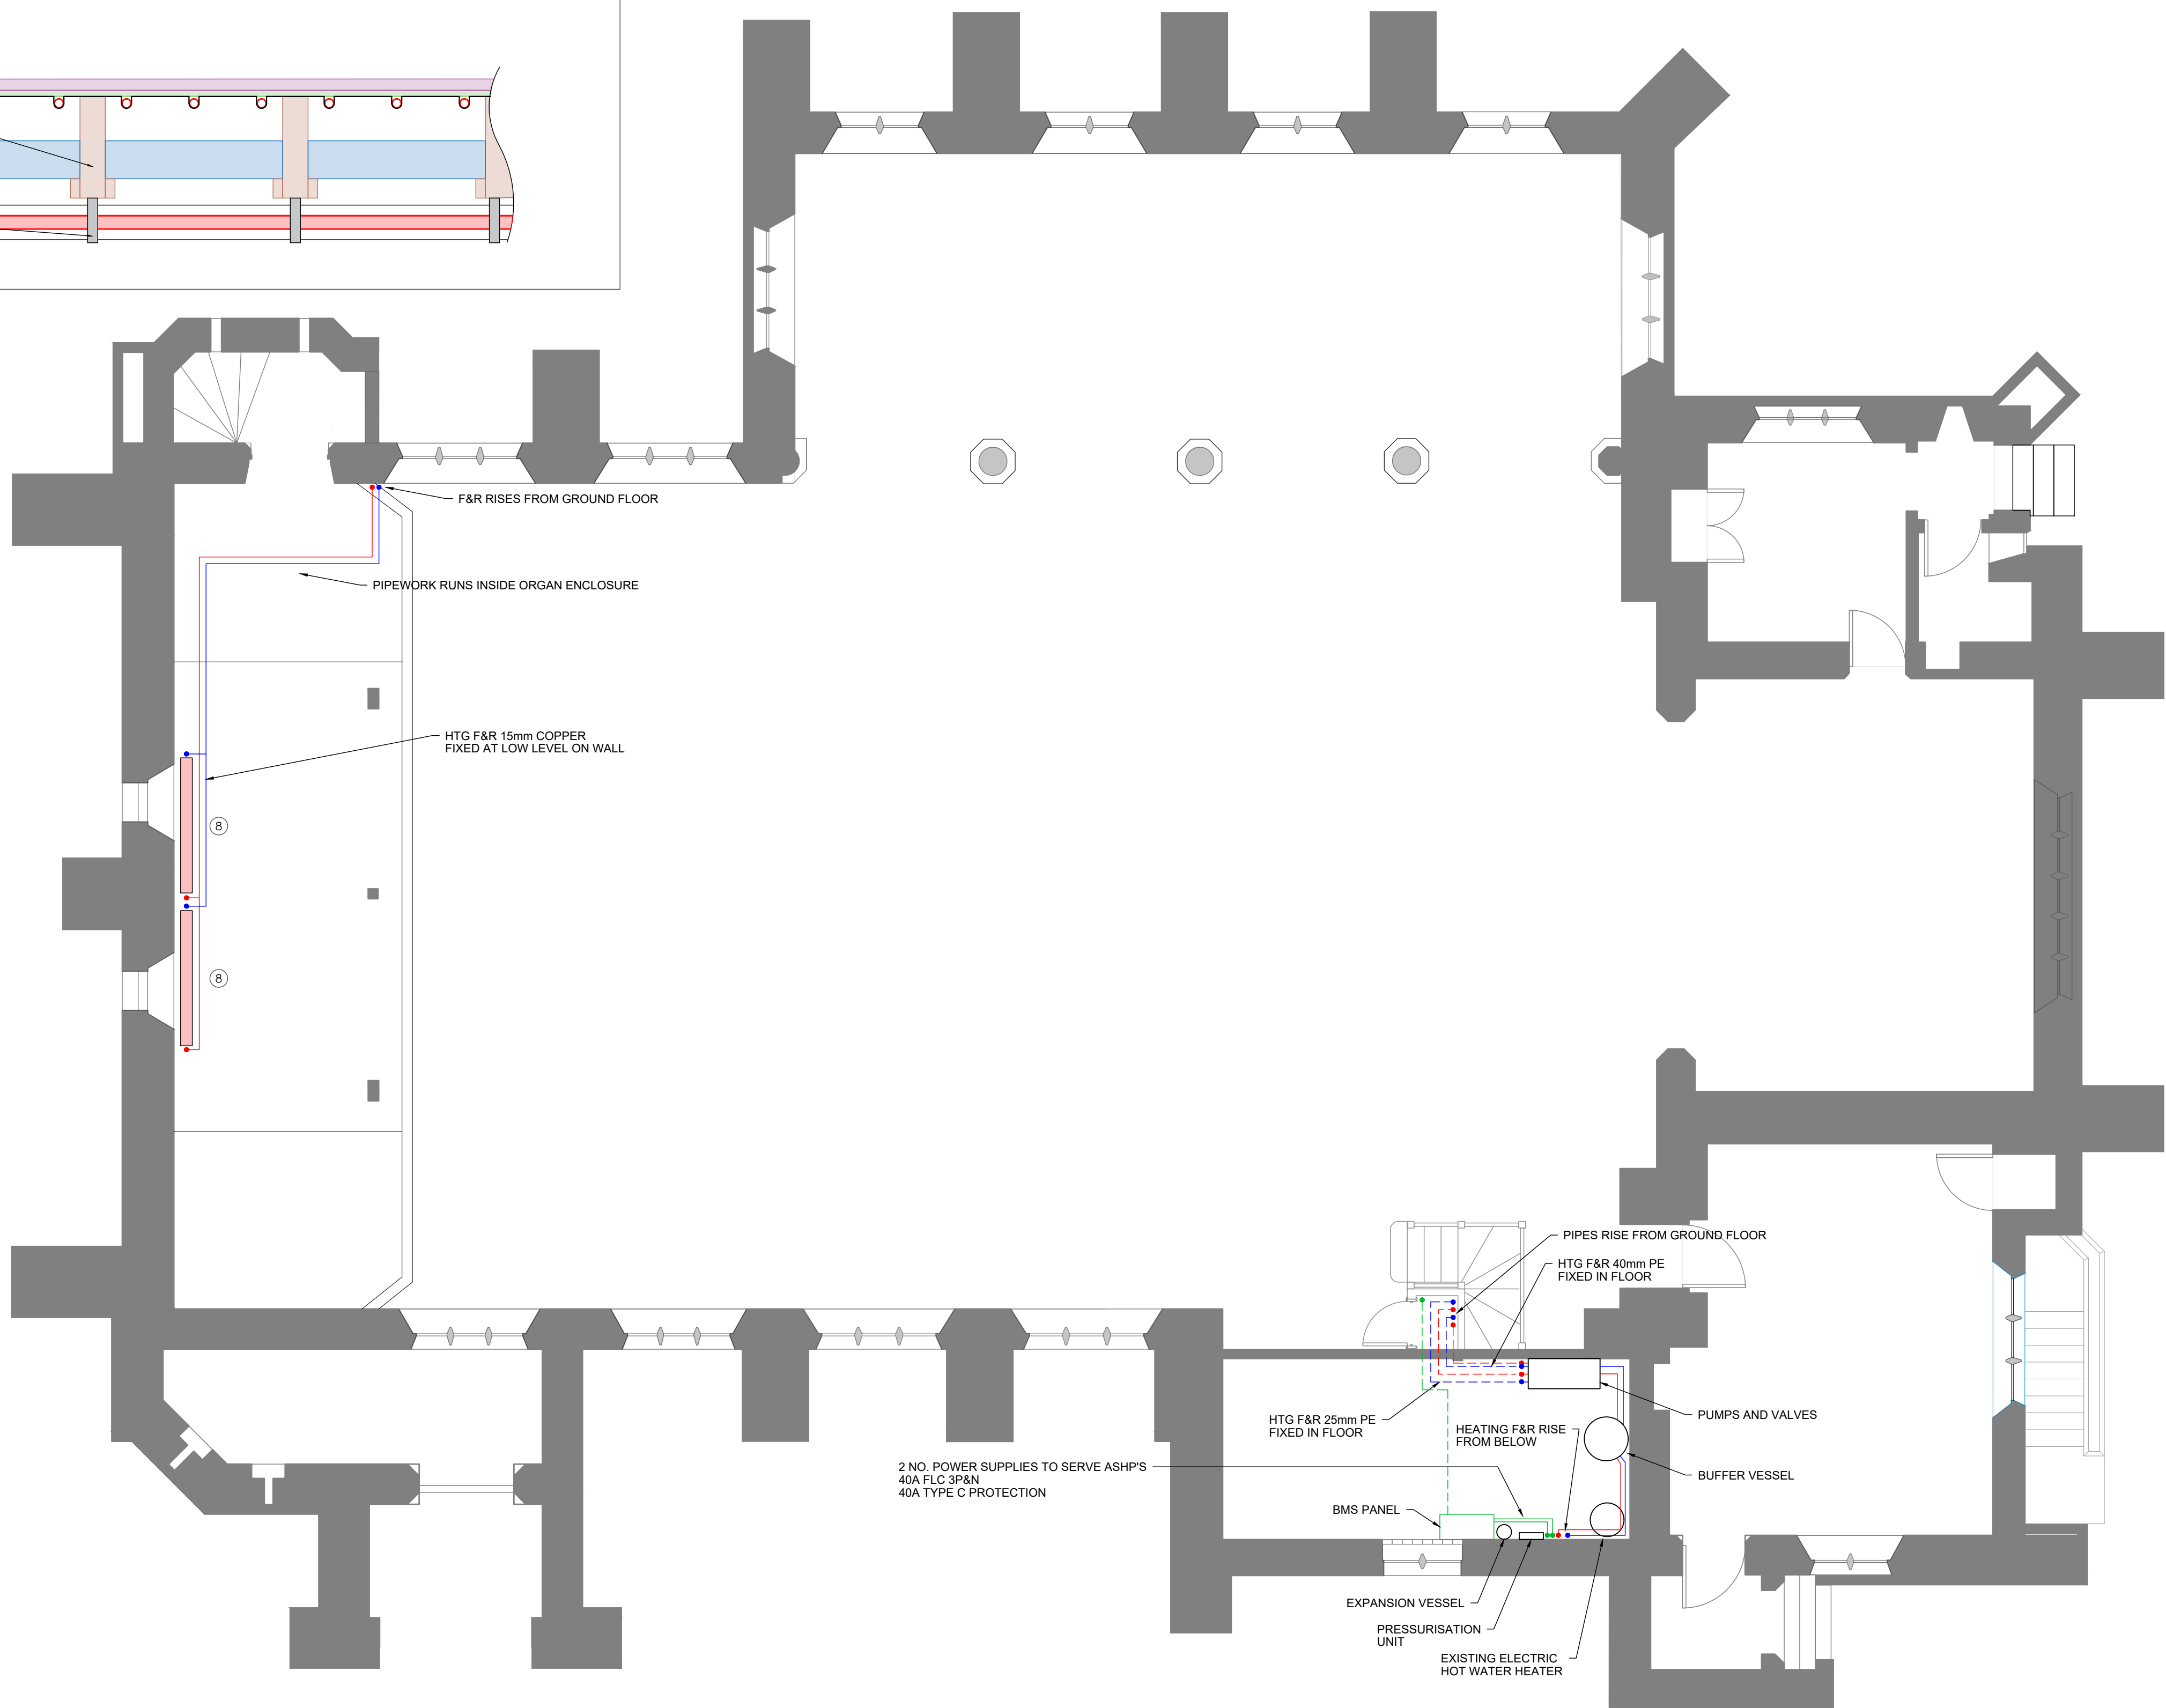
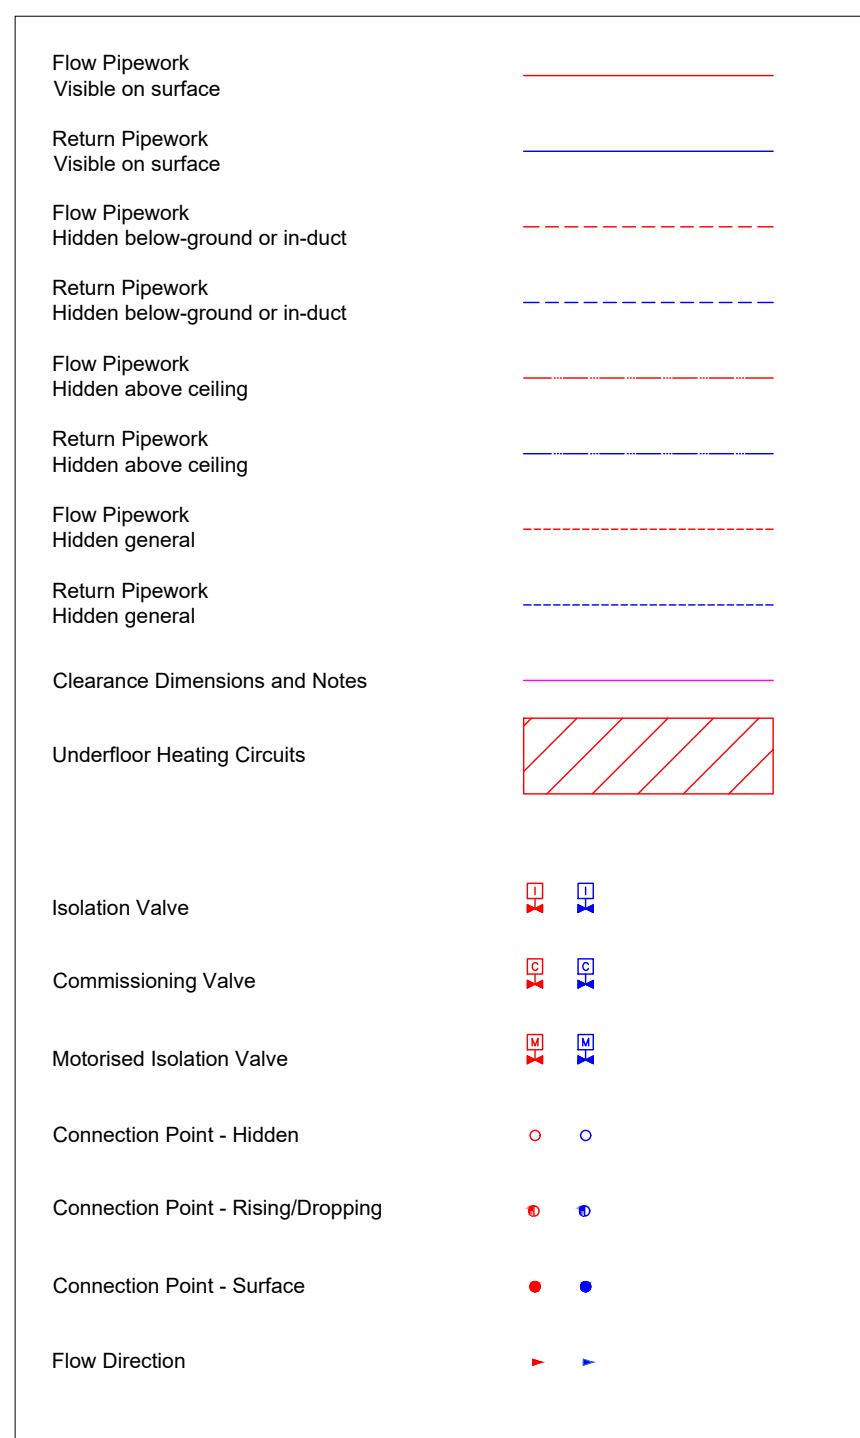


Underfloor Heating Schedule							
Type	Manufacturer	Model	Flow/Return Temperatures (°C)	Heat Output (W/m²)	Area (m²)	Heat Output for Area (W)	Mounting/Installation Type
1	Rehau	Diffusion Plate 3-Channel System	55 / 45	60	30	1800	Diffusion Plate
2	Rehau	Diffusion Plate 3-Channel System	55 / 45	60	17	1020	Diffusion Plate
3	Rehau	Diffusion Plate 3-Channel System	55 / 45	60	16	960	Diffusion Plate
4	Rehau	Diffusion Plate 3-Channel System	55 / 45	60	93	5580	Diffusion Plate
5	Rehau	Diffusion Plate 3-Channel System	55 / 45	60	29	1740	Diffusion Plate
		Total			185	11,100	

Radiator Schedule									
Type	Manufacturer	Model	Flow/Return Temperatures (°C)	Heat Output (W)	Size W x H x D (mm)	Quantity	Colour	Total Output (W)	Mounting/fin
1	MHS	IONIC 6 COLUMN 23 SECTIONS	55 / 45	1710	1400 x 760 x 221	4	ANTHRACITE	6843	FLOOR STANDING
2	MHS	IONIC 6 COLUMN 34 SECTIONS	55 / 45	2328	1600 x 660 x 221	2	SPECIFIED RAL	4657	WALL MOUNTED
3	MHS	IONIC 6 COLUMN 34 SECTIONS	55 / 45	1710	1400 x 760 x 221	2	ANTHRACITE	3420	FLOOR STANDING
4	MHS	IONIC 6 COLUMN 34 SECTIONS	55 / 45	2644	2040 x 760 x 221	1	SPECIFIED RAL	2108	FLOOR STANDING
5	MHS	MONOPLAN HORIZONTAL TYPE DK	55 / 45	1686	1600 x 720 x 95	2	SPECIFIED RAL	3372	WALL MOUNTED
6	MHS	MONOPLAN HORIZONTAL TYPE DK	55 / 45	2108	2000 x 720 x 95	1	SPECIFIED RAL	2108	WALL MOUNTED
7	MHS	MATRIX VERTICAL TYPE V	55 / 45	375	630 x 1200 x 32	7	SPECIFIED RAL	2625	WALL MOUNTED
8	MHS	MATRIX CONNECTOR TYPE CP21 3 PANEL	55 / 45	1490	2000 x 210 x 181	2	SPECIFIED RAL	2980	FLOOR STANDING
9	MHS	MONOPLAN HORIZONTAL TYPE DK	55 / 45	1751	2200 x 540 x 95	1	SPECIFIED RAL	1751	WALL MOUNTED
10	MHS	IONIC 6 COLUMN 23 SECTIONS	55 / 45	1710	1400 x 760 x 221	2	ANTHRACITE	3420	FLOOR STANDING
11	MHS	MONOPLAN HORIZONTAL TYPE DK	55 / 45	1273	1600 x 540 x 95	1	SPECIFIED RAL	1273	WALL MOUNTED

[illegible]

NOTES

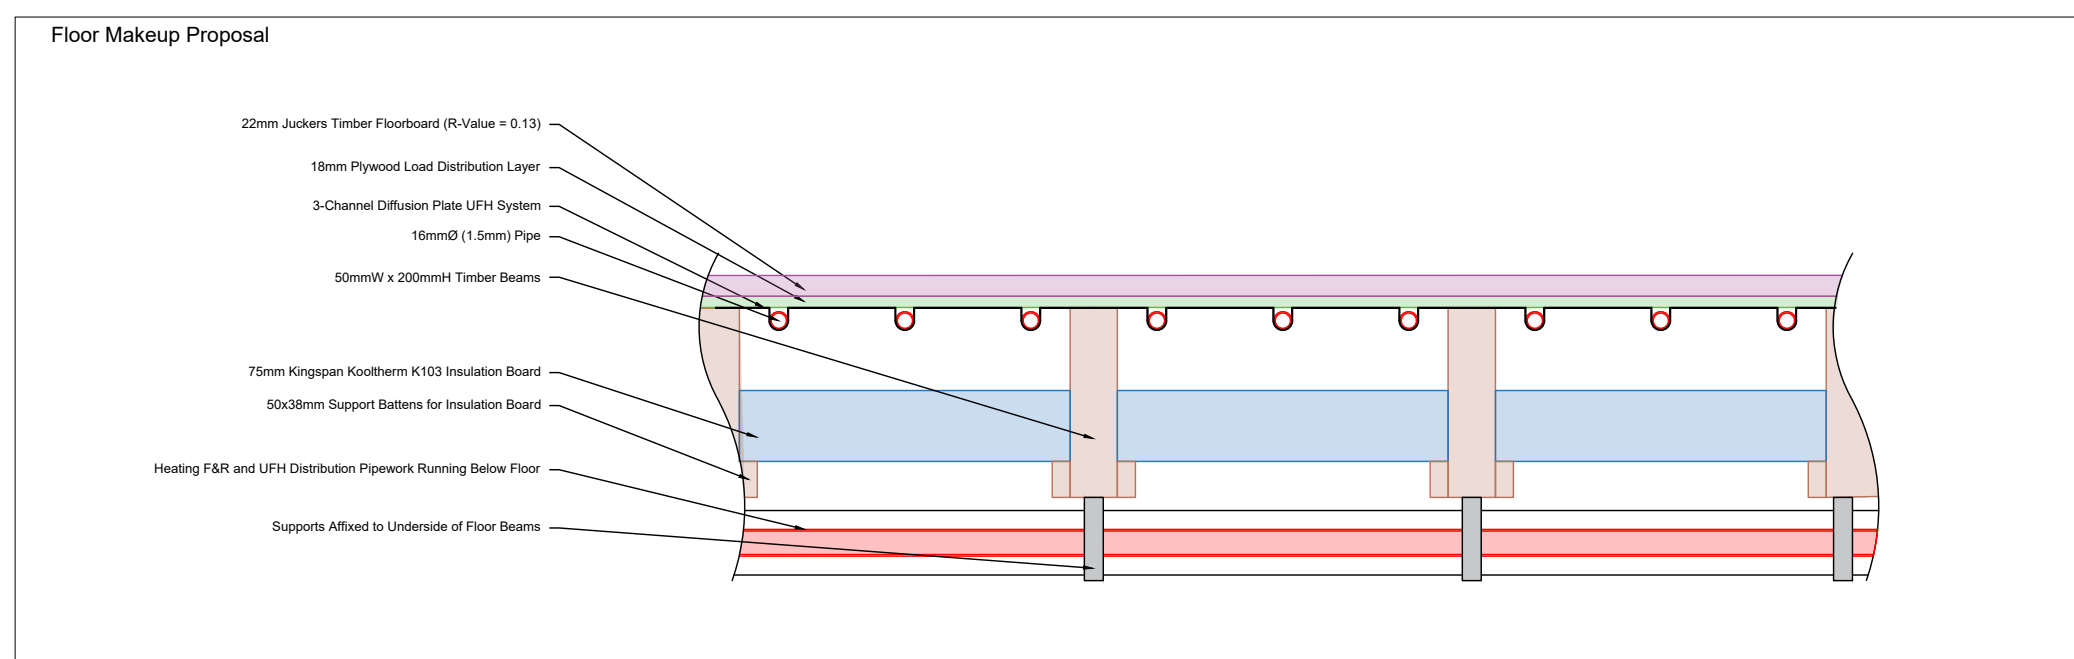

Chris Reading
associates limited

MECHANICAL AND ELECTRICAL
BUILDING SERVICES ENGINEERS

8A Parr Street, Poole, BH14 0JY
Telephone: 07966799740
E-mail: office@consultcraltd.co.uk
Website: www.consultcraltd.co.uk

Registered in England and Wales
Registration Number: 12240384

Architect

Ryan Bunce & Co

Project Title

Rosslyn Hill Chapel, Hampstead - Heating Project

Drawing Title

Heating Drawing
Upper Floor

SCALE	DATE	DRAWN BY	PROJECT NO.	DWG. NO.	REV.
1:60 @ A1	AUG 2024	MJB	2401	4	A