
 


- PROPOSED VMo2 GRP SHROUD TO BE INSTALLED
- PROPOSED VMo2 7.5m HIGH BESPOKE FLI MONOPOLE C/W NEW SLIMLINE HEADFRAME TO BE INSTALLED TO PROPOSED STEELWORK
- PROPOSED VMo2 GRILLAGE TO BE INSTALLED ON ROOFTOP SUPPORTED BY 4No. PLINTHS
- PROPOSED VMo2 3No. ANTENNAS AT 26.8m TO BE INSTALLED TO PROPOSED HEADFRAME
- PROPOSED VMo2 3No. ANTENNAS AT 28.115m TO BE INSTALLED ONTO PROPOSED HEADFRAME
- PROPOSED VMo2 12No. RRUS TO BE INSTALLED ON RAILS FIXED TO PROPOSED GANTRY POLES
- PROPOSED VMo2 1No. OUTDOOR PERCY PSU INSTALLED ON PROPOSED GRILLAGE PLATFORM
- PROPOSED VMo2 2No. FLAT PACK FRAME TO BE INSTALLED ON PROPOSED STEELWORK
- PROPOSED VMo2 1No. HANDRAIL TO BE INSTALLED ON GRILLAGE

NOTE:
SHROUD SHOWN INDICATIVELY

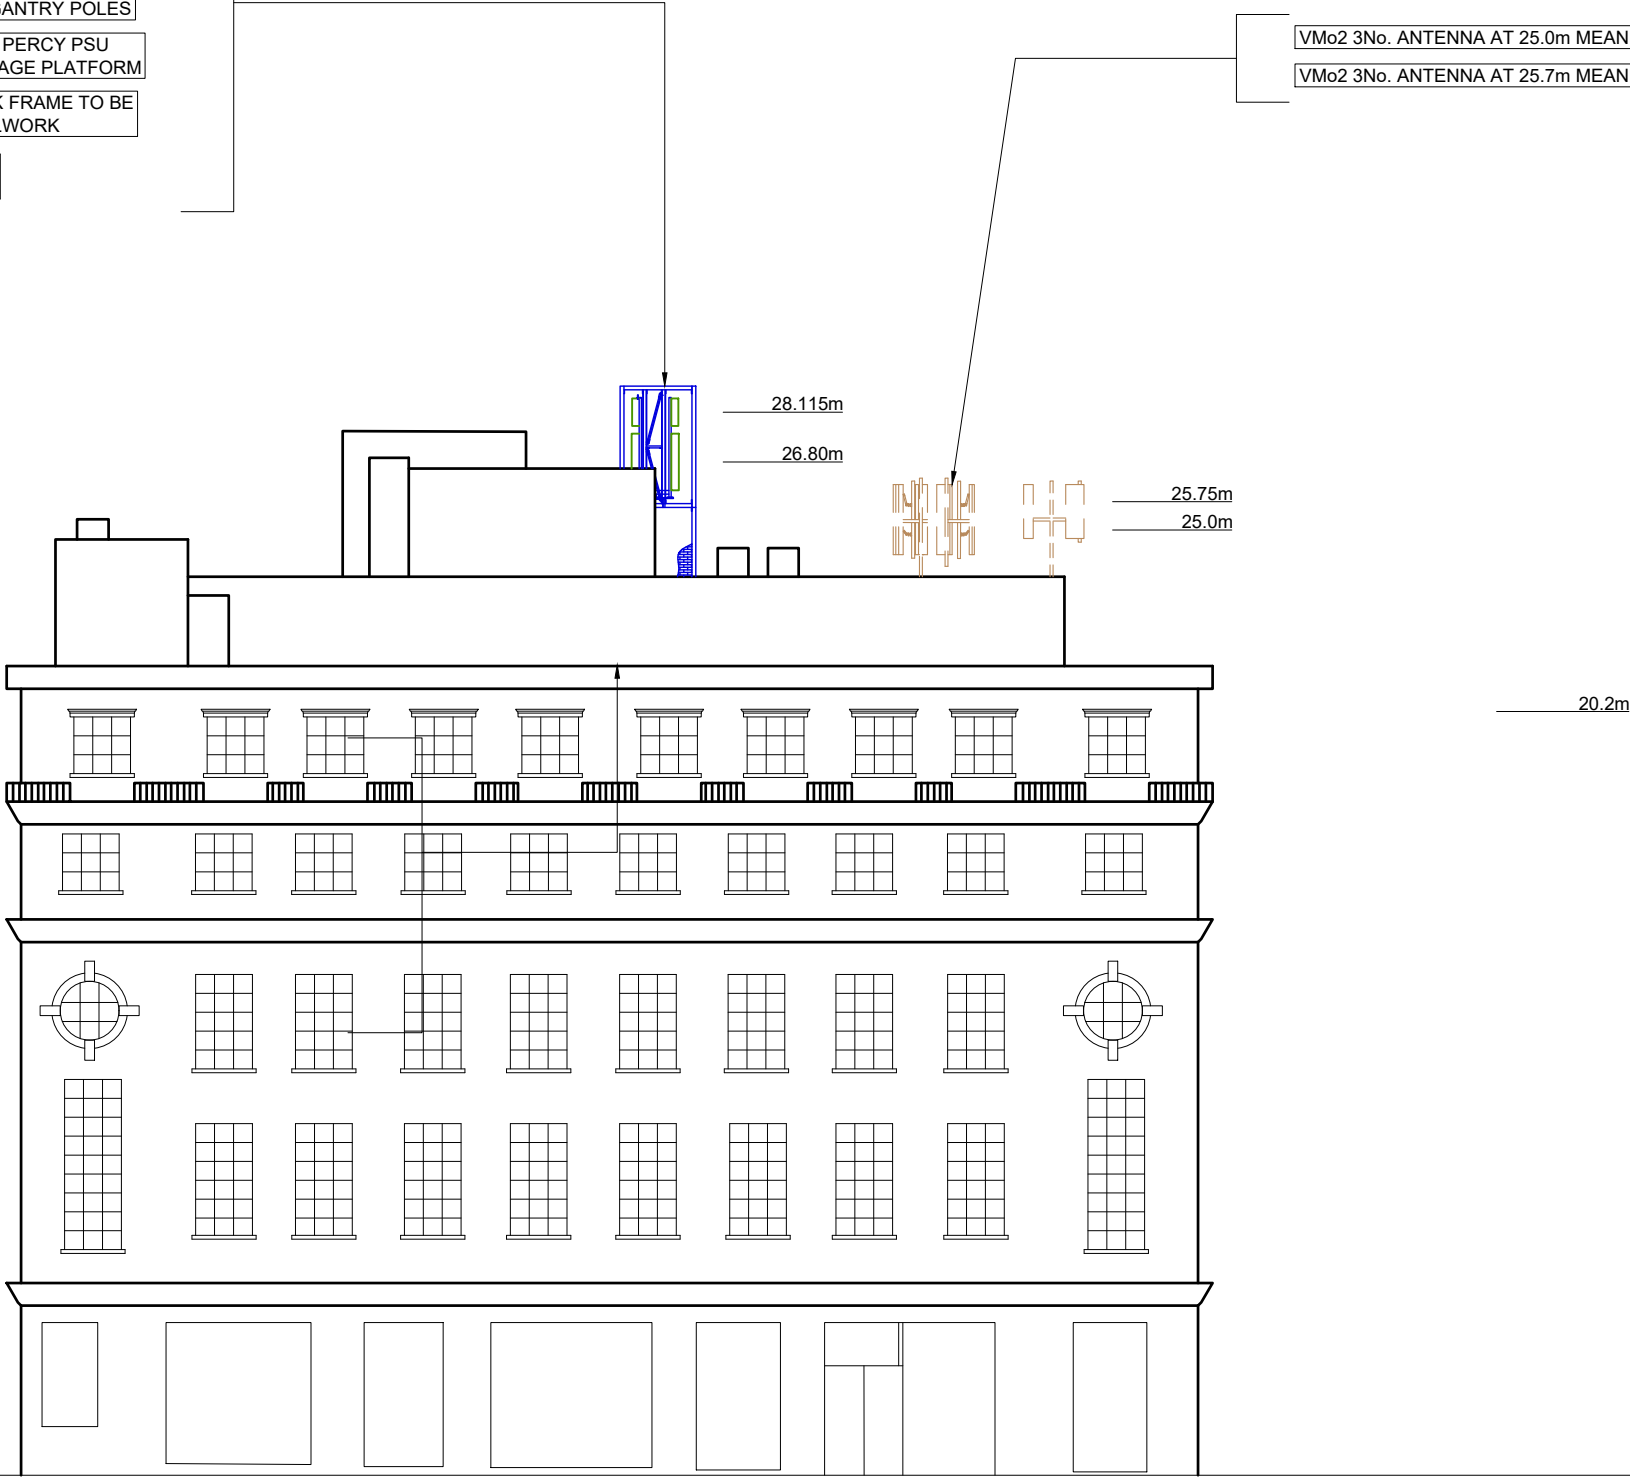


NORTH EAST ELEVATION
SCALE 1:200



FEINT DETAILS INDICATE LOCATIONS
RESERVED FOR OTHER PROPOSALS
WHICH MAY BE THE SUBJECT OF
SEPARATE APPLICATIONS

©2020 Cellnex
All rights reserved. No part of this publication may be reproduced, stored in a retrieval system or transmitted in any form or by any means (Electronic, Mechanical, Photocopying, Recording or otherwise), without the prior written consent of the Company.

NOTES

PROJECT No.		COM-0007834			
CSID		13622022			
VFID		N/A			
CSR		2442			
CELL No.		244202			
BT SKYLINE No.					
NW0031					
26	COM-0007834 MAJOR AMEND	24/05/24	HFC	HFC	
25	COM-0007834 LEASE AMEND	01/12/23	HFC	HFC	
24	COM-0007834 LEASE AMEND	13/07/23	HFC	HFC	
23	COM-0007834 MAJOR AMEND	15/05/23	HFC	HFC	
22	COM-0007834 MAJOR AMEND	22/04/22	HFC	HFC	
ISS	REVISION	DATE	DRN	APP	
<div> CELLNEX UK R+, 4TH FLOOR, 2 BLA GRAVE STREET, READING, RG1 1AZ Tel. 020 4526 8553</div>					
SITE No 166657					
EUSTON TE					
EUSTON ROAD					
CAMDEN					
GREATER LONDON 3					
NW1 2BH					
NGR		TQ 29740 82540			
OS GRID		529740 182540			
TITLE					
NE ELEVATION ENHANCED					
PROPOSED					
VM02 LTD					
SCALE		1:200			
DRAWN		HF	27/02/13		
APPROVED		HFC	24/05/24		
DRG No.		Sheet 4 of 8			Rev
166657-03-150-MD026					26