

**GENERAL NOTES**

ALL INTERIOR DIMENSIONS INCLUDING CEILING HEIGHTS ARE TAKEN TO AND FROM FINISHED SURFACES UNLESS OTHERWISE STATED. ALL LEVELS AND DIMENSIONS MUST BE CHECKED ON SITE. ANY DISCREPANCIES WITH THE INFORMATION DEPICTED IN THIS DRAWING MUST BE REPORTED IN WRITING. RESPONSIBILITY CANNOT BE ACCEPTED FOR ALTERATIONS MADE TO THIS DRAWING WITHOUT PRIOR PERMISSION.  
THIS DRAWING MUST NOT BE PHOTOCOPIED, SCALED OR REPRODUCED OTHERWISE. SCALE ACCURACY CANNOT BE GUARANTEED. THIS DRAWING SHOULD NOT BE USED IN ANY CIRCUMSTANCES FOR ANY STRUCTURAL CALCULATION OR BUILDING CONSTRUCTION / DEMOLITION WORK.

**SURVEY GRID**

PLEASE NOTE THAT GRID SHOWN ON THIS DRAWING IS AS FOLLOWS

- ARBITRARY
- ARBITRARY BUT APPROXIMATELY RELATED TO GRID NORTH
- BEST FIT TO ORDNANCE SURVEY DIGITAL DATA
- ORDNANCE SURVEY NATIONAL GRID USING GPS

**LEVELS AND HEIGHTS**


- AS ARCH SPRINGER HEIGHT
- AH ARCH HEAD HEIGHT
- B BEAM SOFFIT HEIGHT
- C CEILING SOFFIT HEIGHT
- D DOOR HEAD HEIGHT
- FL FLOOR LEVEL
- P PLINTH HEIGHT
- S SOFFIT HEIGHT
- T TRUNKING HEIGHT
- WS WINDOW SILL HEIGHT
- WH WINDOW HEAD HEIGHT

PLEASE NOTE: ALL HEIGHTS TAKEN FROM FLOORLANDING UNLESS OTHERWISE STATED.


DATUM: ARBITRARY

DESCRIPTION: N/A


N/A

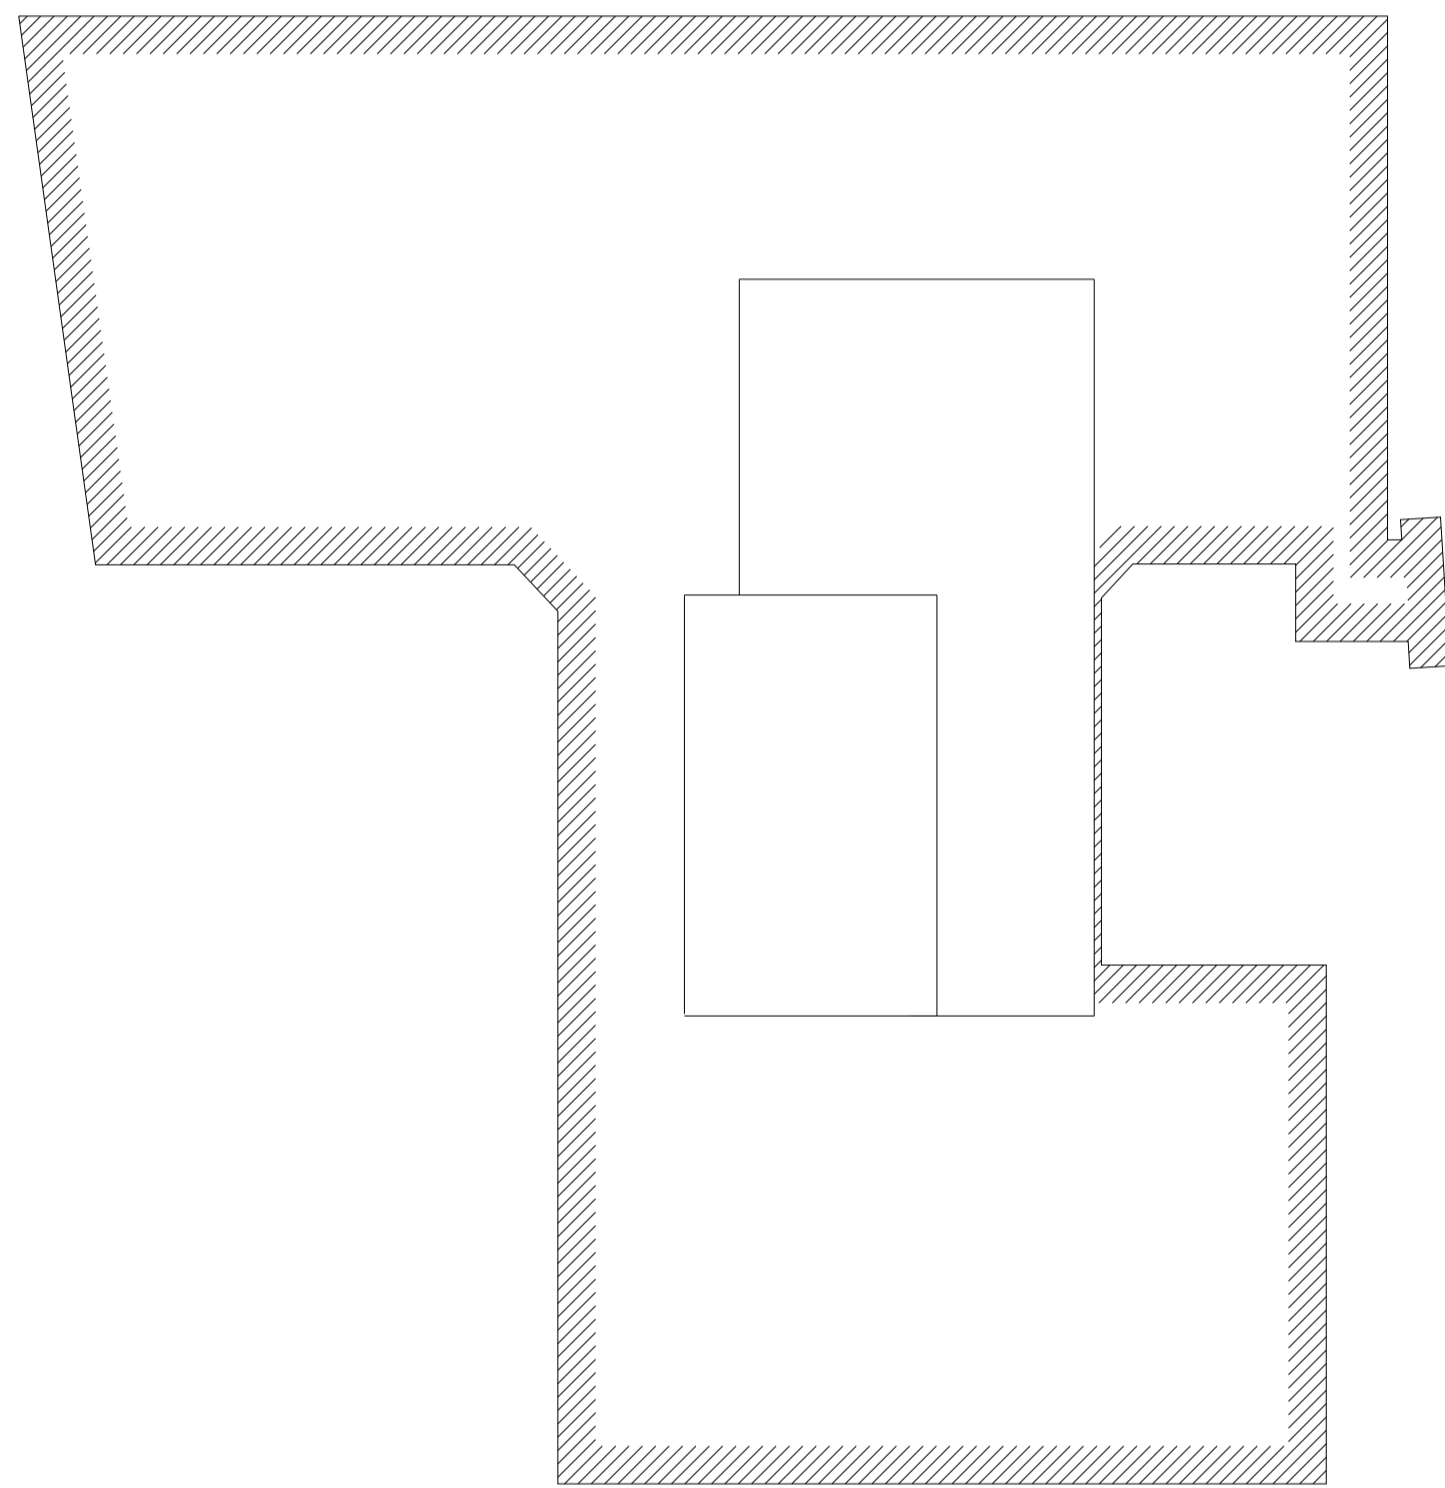

EXISTING ROOF PLAN

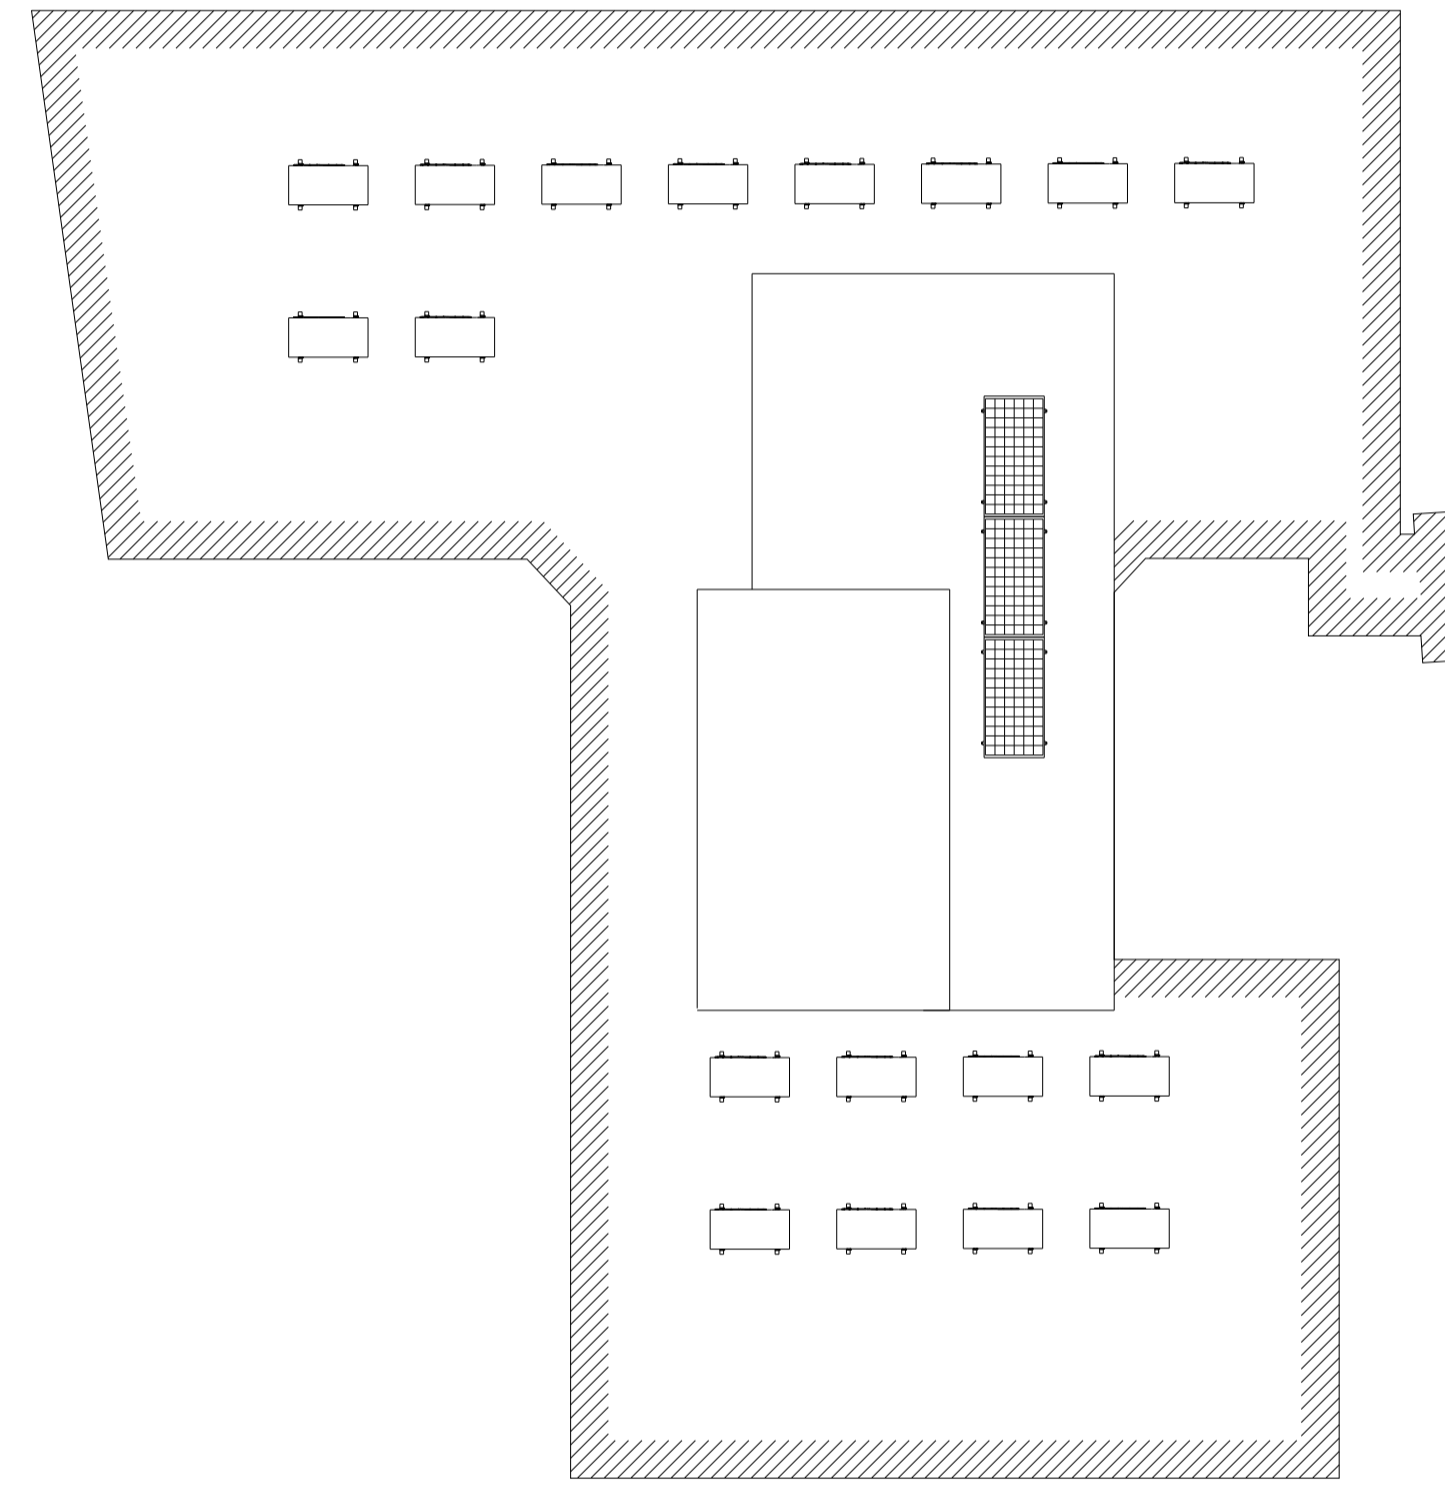


PROPOSED ROOF PLAN

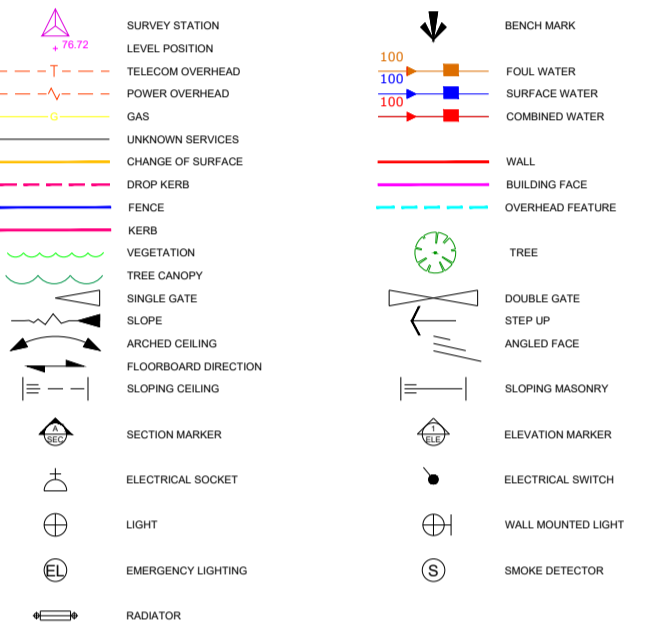

**ABBREVIATIONS (Where Applicable)**

AB	AIR BRICK	OH	OVERHEAD
ACU	AIR CONDITIONING UNIT	PLT	PAVEMENT LIGHT
BOL	BOLLARD	R	RADIATOR
BRW	BRICK WALL	RG	ROAD GULLY
BT	BRITISH TELECOM	RH	RADIATOR HOUSING
CATV	CABLE TELEVISION COVER	RNB	ROAD NAME BOARD
CE	CLEANING EYE	RS	ROAD SIGN
CL	COVER LEVEL	RW	REATINING WALL
CPS	CONC. PAVING SLABS	RWP	RAINWATER PIPE
DP	DOWN PIPE	SC	STOP COCK
ECP	ELECTRIC CABLE PIT	SG	SECONDARY GLAZING
EP	ELECTRICITY POLE	SV	STOP VALVE
FH	FIRE HYDRANT	T	TRUNKING
G	GULLY	TIC	TELECOM INSPECTION COVER
GSC	GAS STOP COCK	TDO	TRAP DOOR OVER
GV	GAS VALVE	TLT	TRAFFIC LIGHT
HWC	HOT WATER CYLINDER	TP	TELEGRAPH POLE
HTR	HEATED TOWEL RAIL	TPS	TACTILE PAVING SLABS
IC	INSPECTION COVER	UTL	UNABLE TO LIFT
LP	LAMP POST	V	VENT
MH	MANHOLE	VP	VENT PIPE
MKR	MARKER	W	WINDOW
NB	NOTICE BOARD	WM	WATER METER
NFI	NO FURTHER INFORMATION	WP	WASTE PIPE

**LOCATION PLAN**

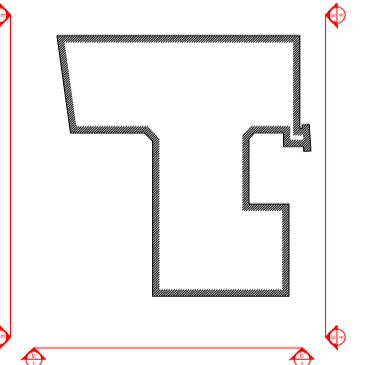


**PROJECT TITLE**

**CHESTER COURT  
LISSENDEN GARDENS  
LONDON, NW5 1LY**

**DRAWING TITLE**

**EXISTING AND PROPOSED  
ROOF PLAN**

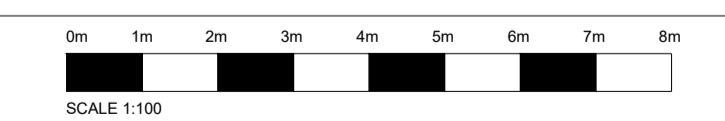

SCALE	SIZE	DRAWING
1:100	A1	79819
DRAWN	CHECKED	DATE
DO	HR	OCT 2024