


SUBJECT
TO
SURVEY


FOR DESIGN INTENT ONLY.

Ground Level

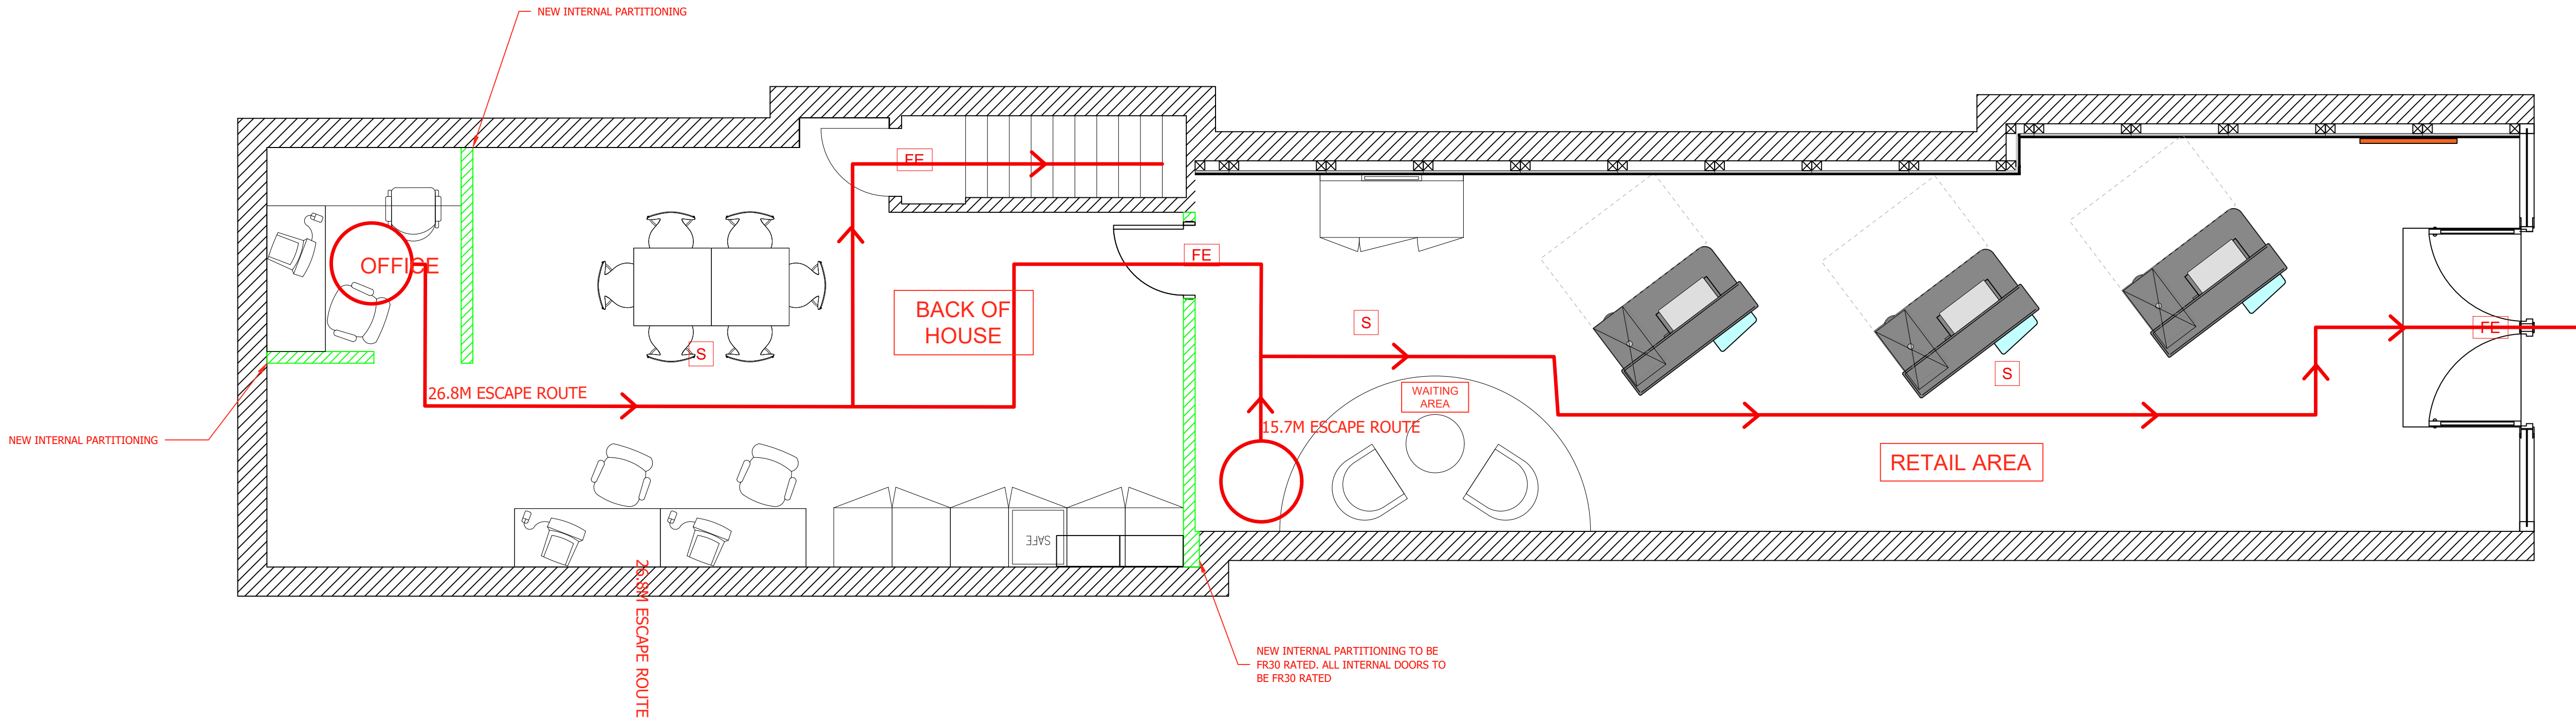



BASEMENT HAS NOT BEEN SURVEYED.
WHERE SUITABLE, AREAS SUCH AS THE KITCHEN WILL REMAIN
IN THE SAME LOCATION WITH THE SAME LAYOUT AS CURRENT.
BUT, WILL BE REFURBISHED AND MADE GOOD AS REQUIRED.

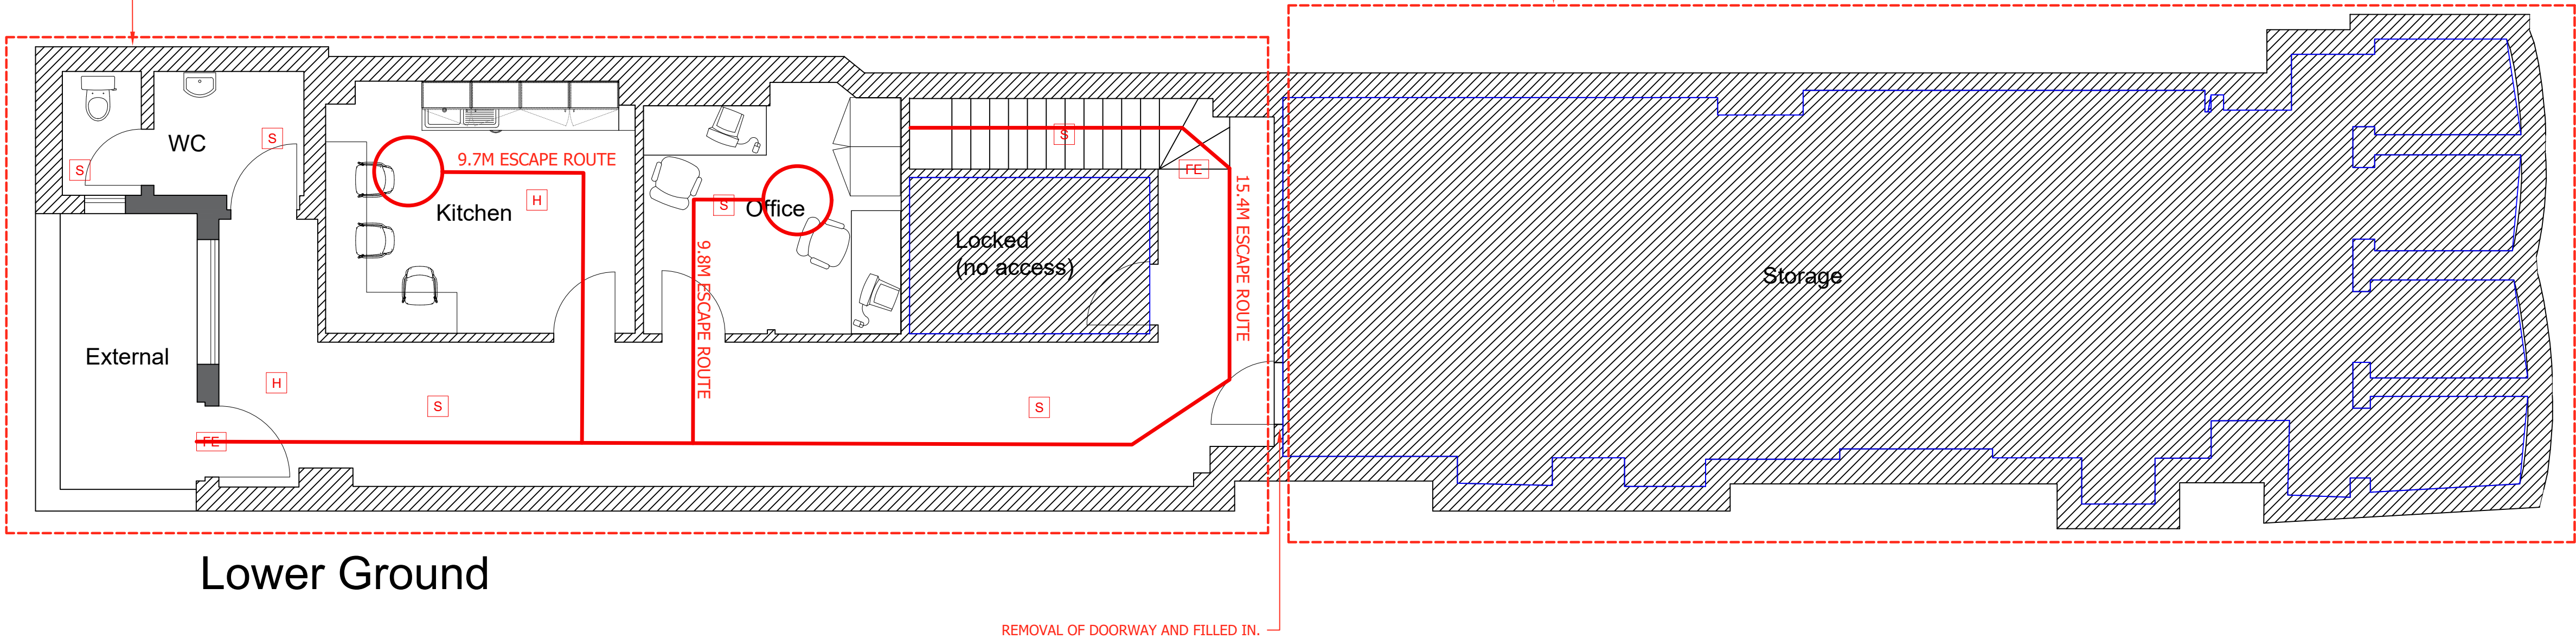THIS STORAGE AREA IS EXCESS SPACE
AND IS NOT REQUIRED OPERATIONALLY.



FIRE KEY	
KEY	DESCRIPTION
FAIP	FIRE ALARM PANEL
H	HEAT DETECTOR HEAD
S	SMOKE DETECTOR HEAD
FE	ILLUMINATED RUNNING MAN
	INTERNAL SOUNDER
SAB	EXTERNAL SOUNDER
©	SPRINKLER HEAD
FIRE ALARM SYSTEM TO BE COMPLIANT WITH BS 5839-1:2017. ALARM SOUNDERS TO PROVIDE A MINIMUM OF 65DB IN ALL AREAS. FIRE SAFETY / EXIT SIGNAGE TO COMPLY WITH BS EN ISO 7010, BS5499-4 2013, BS5266-1:2016	

	123A BOROUGH HIGH STREET LONDON SE1 1NP WWW.STAMPDESIGN.CO.UK	TITLE	FIRE STRATEGY		ISSUE RECORD		(ADD EXTRA NOTES HERE)	FOR DESIGN INTENT ONLY. BUILDER AND / OR SUB-CONTRACTORS SHALL VERIFY ALL PROJECT DIMENSIONS BEFORE COMMENCING ON-SITE OR OFF-SITE FABRICATIONS FIGURED DIMENSIONS SHALL TAKE PRECEDENCE OVER SCALED DIMENSIONS. THIS DRAWING IS COPYRIGHT AND CANNOT BE REPRODUCED IN WHOLE OR IN PART OR BY ANY MEDIUM WITHOUT THE WRITTEN PERMISSION OF STAMP DESIGN. NO WARRANTY IS OFFERED OR IMPLIED ON THE CONTENT OF THESE DRAWINGS. CLIENT AND CONTRACTOR SHOULD SATISFY THEMSELVES THAT THE DESIGN INTENT AS INDICATED IS SUITABLE IN TERMS OF FUNCTION AND FEASIBILITY. GUIDANCE SHOULD BE SOUGHT FROM THE LANDLORDS RETAINED ARCHITECT, STRUCTURAL ENGINEERS AND PROJECT TEAM AS TO THE FEASIBILITY OF DESIGN INTENT CONTAINED HEREIN. THE LANDLORDS AGENTS WILL BE RESPONSIBLE IN ALL CASES FOR ENSURING ADEQUATE PROVISION OF DESIGN INFORMATION, AND SIGN OFF OF DESIGN INTENT HEREIN. NO STRUCTURAL DESIGN HAS TAKEN PLACE. SHOULD STRUCTURAL DESIGN BE REQUIRED, THIS MUST BE COMMISSIONED AND SIGNED OFF BY AN INDEPENDENT STRUCTURAL ENGINEER IN ALL CASES. NO GUIDANCE OR WARRANTY AS TO THE STRUCTURAL SUITABILITY OF ANY WORK CONTAINED HEREIN IS OFFERED OR IMPLIED. IF IN DOUBT, ASK!
		SCALE	1:40 @ A1		A	FIRST ISSUE		
	88 SOUTHAMPTON ROW LONDON WC1B 4BB	DRAWN BY	DRAWING NO.					
		LB	STA.SIXT.SOUTHAMPTONROW.FS00					