

REPLACEMENT WINDOW HIGHLIGHTED IN YELLOW




This drawing is copyright & the property of Chris Potter Associates Ltd & must not be copied in whole or in part without their written permission. Copyright is reserved. ©

This drawing must not be scaled. The Contractor is to report all dimensional discrepancies & errors to the Contract Administrator prior to construction commencing.

This drawing is to be read in conjunction with all specifications/ schedule of works and all other associated documents. All works described and / or reasonably inferable from the same are deemed included in the contract sum.


BUILDING OUTLINE

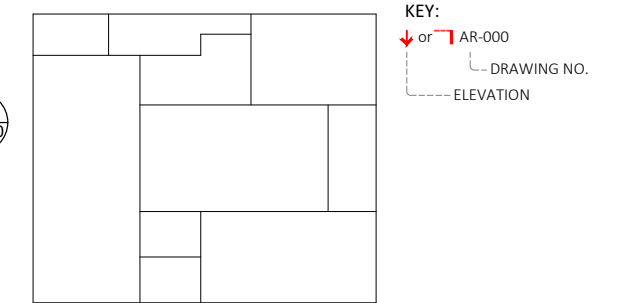

NOTES:

- FOR WALL INSULATION PLAN AND DETAILS, PLEASE DRAWING REF. NO. 0616-CP02 AND 0616-CP03 AND APPENDIX 10.
 ■ WOODFIBRE INSULATION WITH LIME PLASTER TO CURVED RECESSED ARCHES.
 ■ METAL STUD INSULATED WALL LINING.
- EXISTING PIPE RUNS & CONDUIT OMITTED FOR CLARITY.
- FOR SECONDARY GLAZING DETAILS AND SPECIFICATION, PLEASE REFER TO SELECTAGLAZ REPORT NO. KB/E/73081/R0/A AND APPENDIX 8.
 ■ SECONDARY GLAZING HORIZONTAL SLIDING (SERIES 10 SLIMLINE).
- FOR HEATING & VENTILATION LAYOUTS AND SPECIFICATION, PLEASE REFER TO FLOH DRAWINGS AND APPENDIX 11

-	issue for planning	22.11.2023
Revisions/	Comments	Dates
Status		
○ Feasibility	○ Tender	○ For Client Approval
● Planning	○ Construction	
○ Building Regulations	○ As Built	○ Preliminary
Client	Camden Council	Date Nov 23
		Drawn IC
Project Title	Highgate Library Chester Road, London N19 5DH	Approved BB
		Scale 1:100 @A3
Drawing Title	Proposed Upper Library Plan / First Floor Roof	Job No. 0955
		Dwg No. AR-102

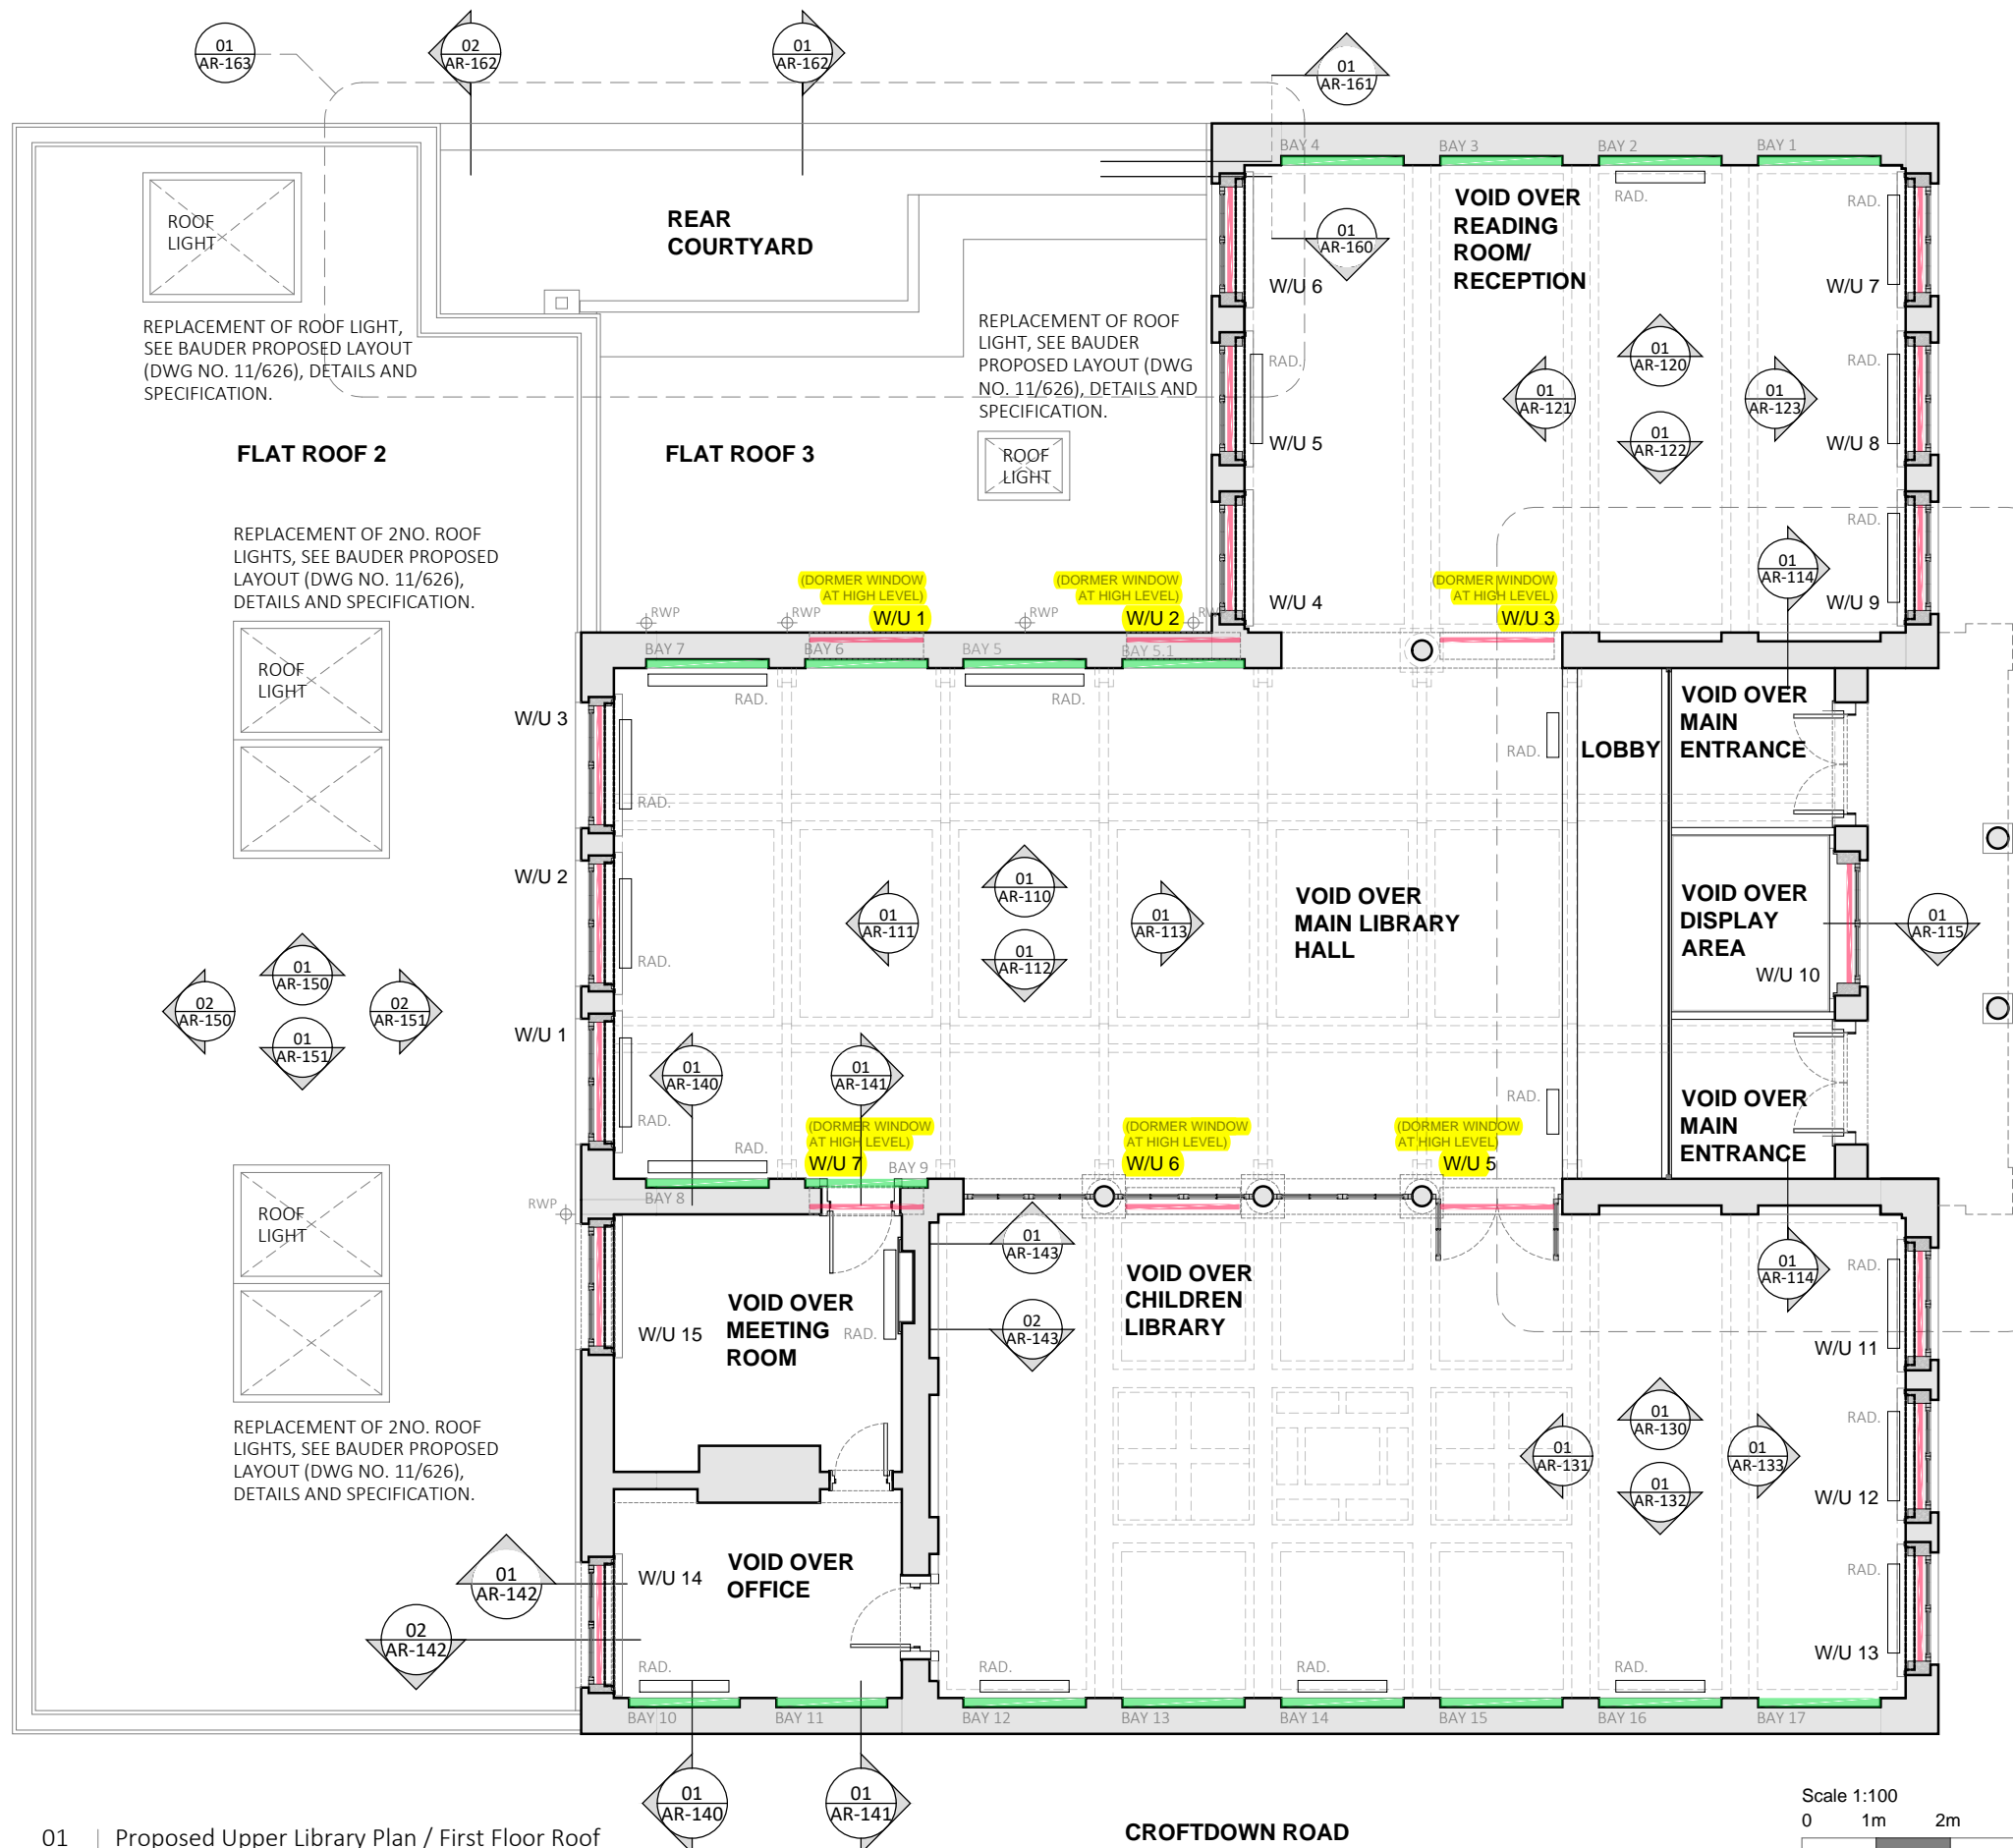

BROOKFIELD PRIMARY SCHOOL

CHESTER ROAD

CROFTDOWN ROAD

