

Notes:

Drawings are based on survey data and may not accurately represent what is physically present.



Do not scale from this drawing. All dimensions are to be verified on site before proceeding with the work.

All dimensions are in millimetres unless noted otherwise.

Purcell shall be notified in writing of any discrepancies.

Key Plan
not to scale

Addition of proposed dumbwaiter in room 3.16 from 2nd to 3rd floor refer to drawings:
242931-PUR-01-XX-DR-A-6411
242931-PUR-02-02-DR-A-9203
242931-PUR-02-03-DR-A-9204

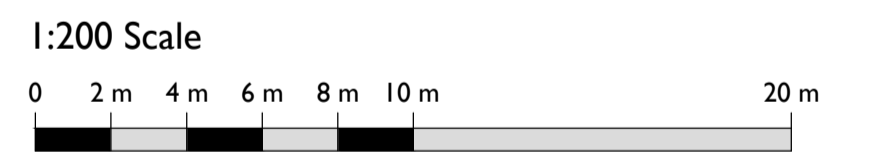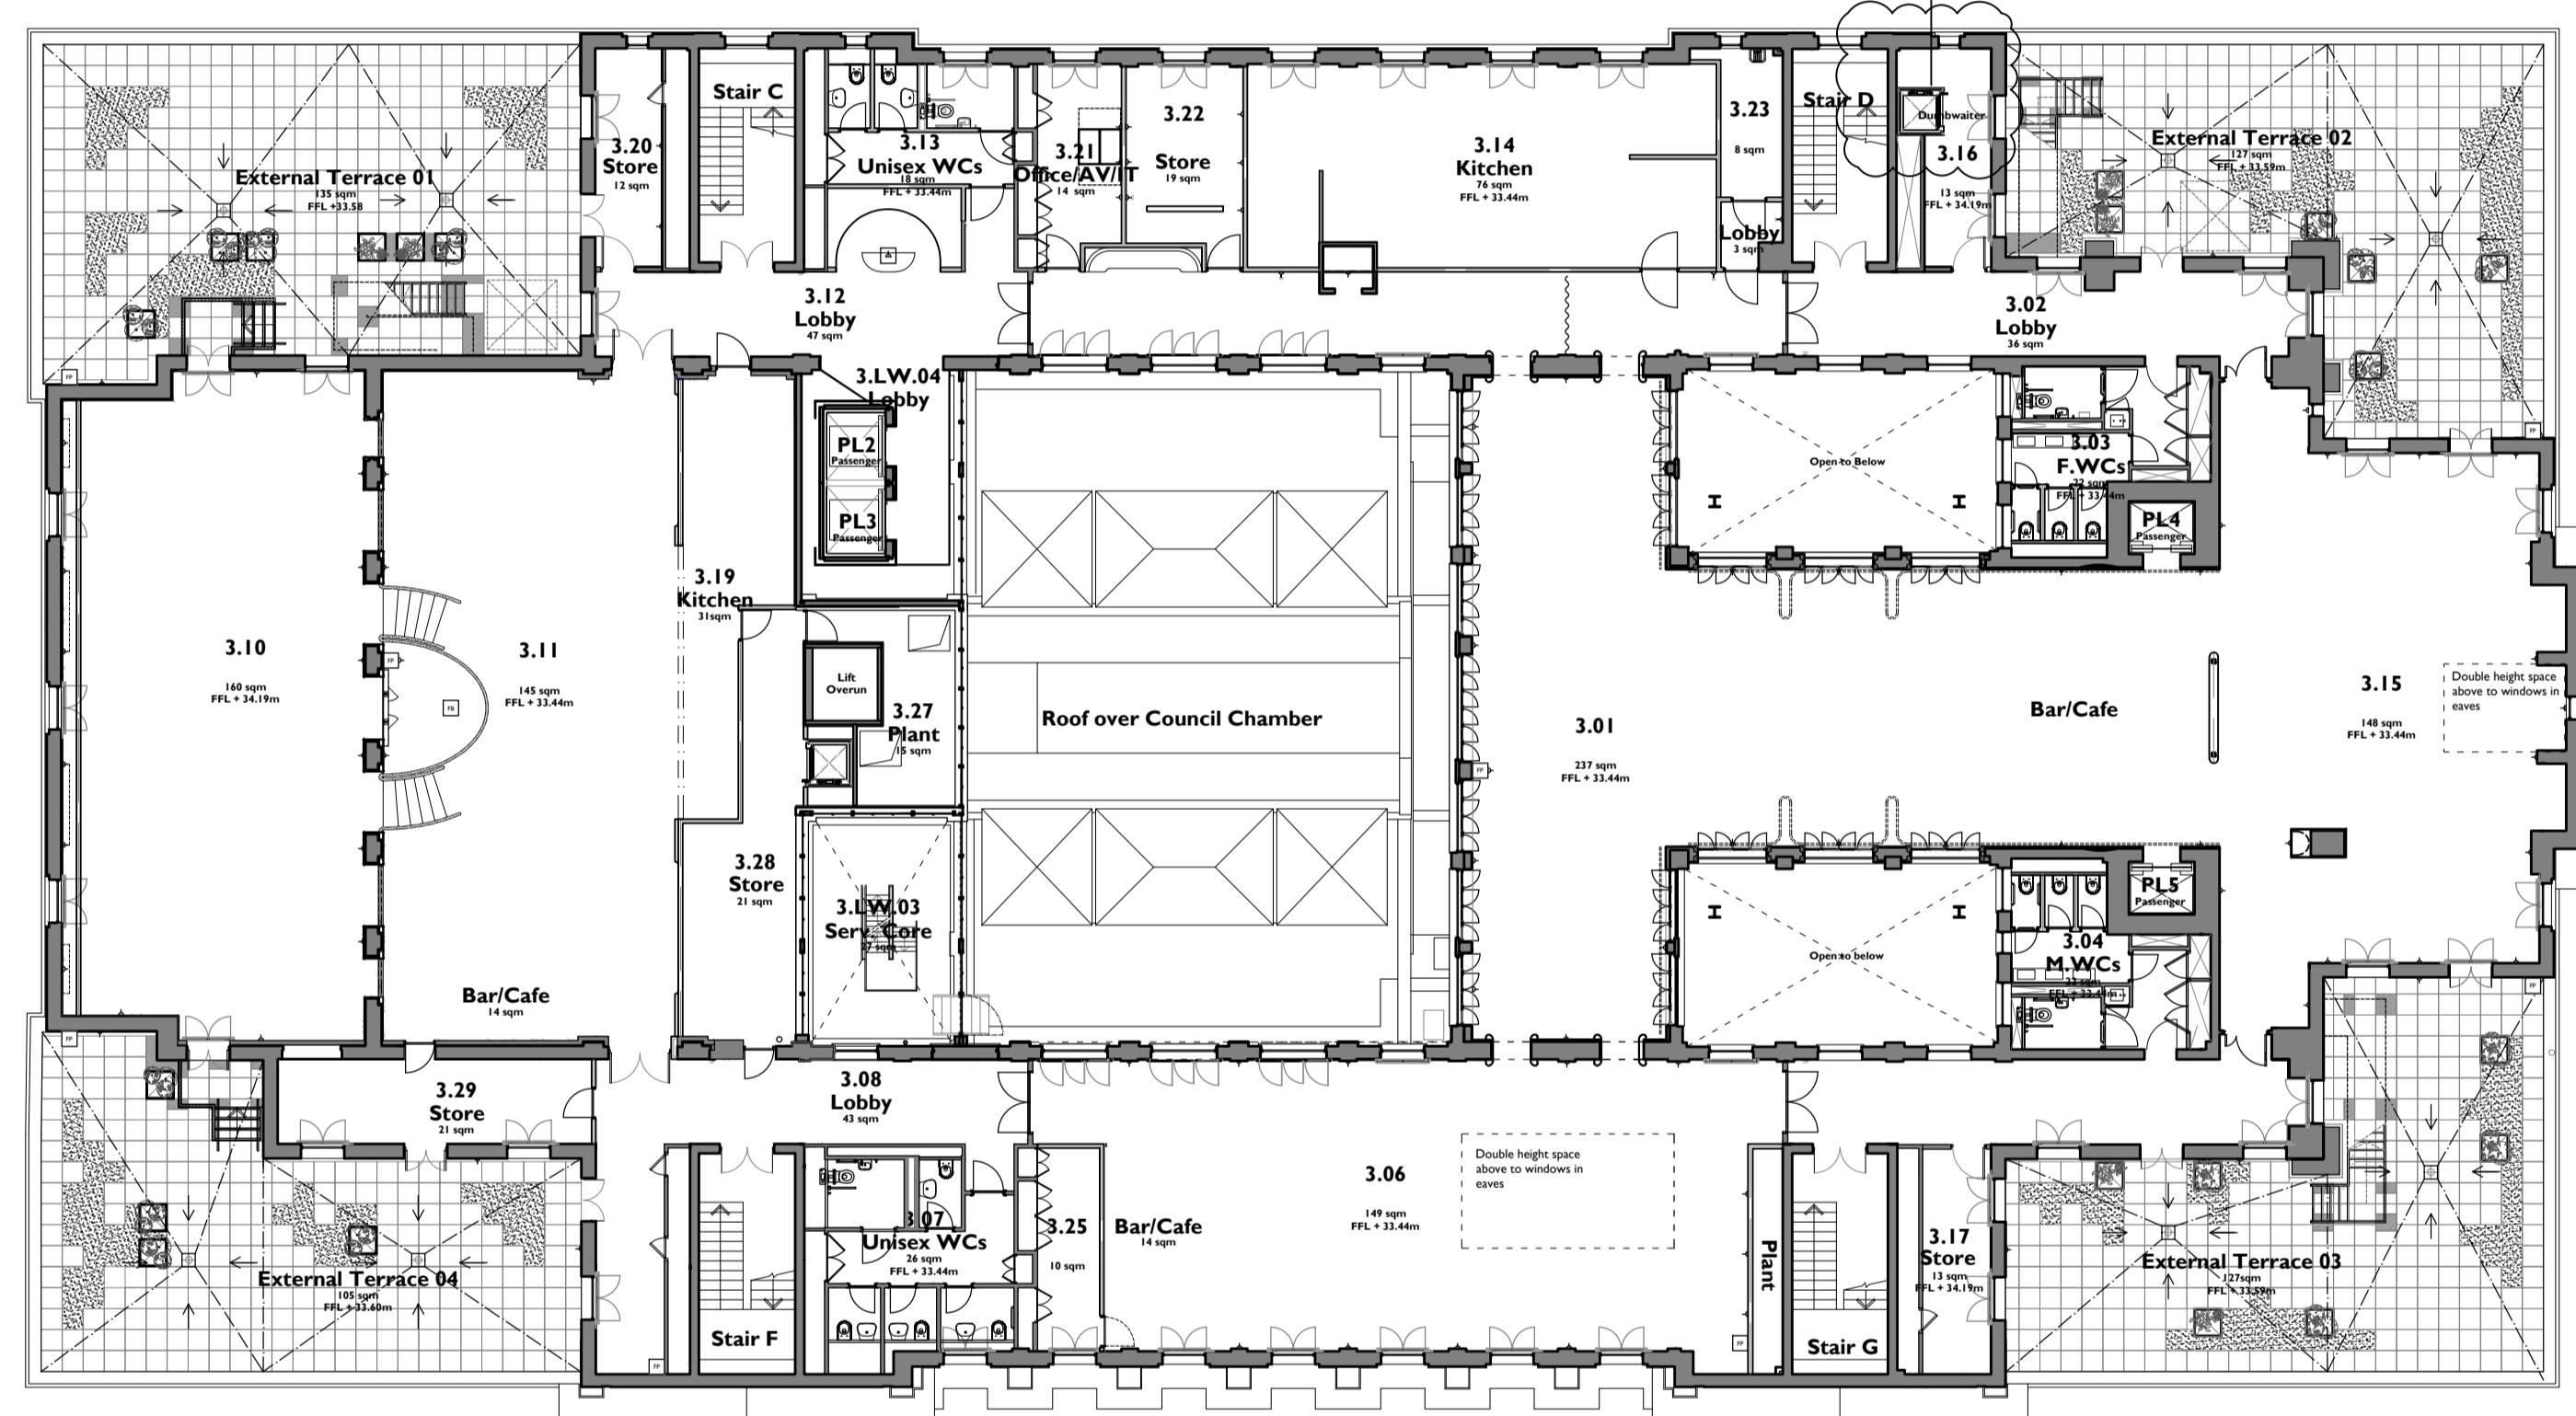


P01	20.12.24	DZ	OB	For LBC
REV	DATE	BY	CHK	DESCRIPTION

CLIENT
Il Bottaccio

PROJECT
Camden Town Hall Tenant Fitout

JOB NUMBER
242931

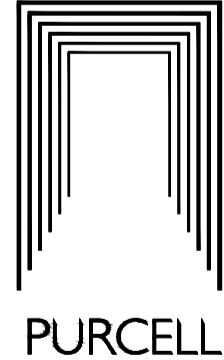

TITLE
PROPOSED THIRD FLOOR PLAN

SIZE SCALE
A1L 1:200

REV SUITABILITY/REASON FOR ISSUE
P01 S4 - For Review and Authorisation

DRAWING NUMBER
242931-PUR-01-03-DR-A-9204

PURCELL® IS THE REGISTERED TRADE NAME FOR PURCELL ARCHITECTURE LTD AND ALL SUBSIDIARY COMPANIES AND IS REGISTERED IN THE UNITED KINGDOM, EUROPEAN UNION, HONG KONG, CHINA AND AUSTRALIA. © PURCELL 2024. www.purcell.com