


- LEGEND - LIGHTING**
- NON-DIRECTIONAL RECESSED DOWNLIGHT
  - NON-DIRECTIONAL RECESSED DOWNLIGHT - IP RATED
  - DIRECTIONAL RECESSED DOWNLIGHT
  - DIRECTIONAL RECESSED DOWNLIGHT - IP RATED
  - RECESSED MINI DOWNLIGHT
  - PENDANT LIGHT
  - CHANDELIER
  - SURFACE MOUNTED NON-DIRECTIONAL DOWNLIGHT
  - SURFACE MOUNTED DIRECTIONAL DOWNLIGHT
  - WALL LIGHT
  - READING WALL LIGHT
  - FREESTANDING FLOOR LIGHT
  - FREESTANDING TABLE LIGHT
  - RECESSED FLOOR SPOT LIGHT
  - RECESSED FLOOR SPOT LIGHT IP RATED
  - RECESSED WALL LIGHT
  - RECESSED WALL LIGHT HLVL
  - CONTROL KEYPAD
  - LIGHT SWITCH
  - DIM LIGHT SWITCH 1 POLE
  - DIM LIGHT SWITCH 2 POLE
  - DIM LIGHT SWITCH 3 POLE
  - DIM LIGHT SWITCH 4 POLE
  - SENSOR ACTIVATED LIGHT
  - INTERCOM
  - LED LINEAR LIGHT
  - LINEAR TRACK LIGHT
  - TRACK SPOT LIGHT
  - LOW VOLTAGE MAGNETIC TRACK SYSTEM

- LEGEND - ELECTRICAL**
- DOUBLE SWITCHED SOCKET HLVL
  - SINGLE SWITCHED SOCKET HLVL
  - DOUBLE SWITCHED SOCKET
  - SINGLE SWITCHED SOCKET
  - FUSED SPUR SWITCH
  - FAN ISOLATOR SWITCH
  - 5 AMP WALL SOCKET
  - 5 AMP FLOOR SOCKET
  - EXTERNAL POWER SOCKET
  - SHAVER SOCKET
  - EXTRACTOR FAN
  - PASSIVE INFRARED SENSOR
  - SMOKE DETECTOR
  - HEATH DETECTOR
  - TELEPHONE POINT
  - CAT 6 SINGLE DATA POINT
  - CAT 6 DOUBLE DATA POINT
  - TELEVISION POINT
  - ALARM ENTRY PANEL
  - ALARM PIR
  - ELECTRIC RADIATOR
  - USB (A and/or C) DOUBLE SOCKET
  - THERMOSTAT

**COLOUR LEGEND**

- NEW POSITION/ NEW FITTING
- EXISTING POSITION/ NEW FITTING

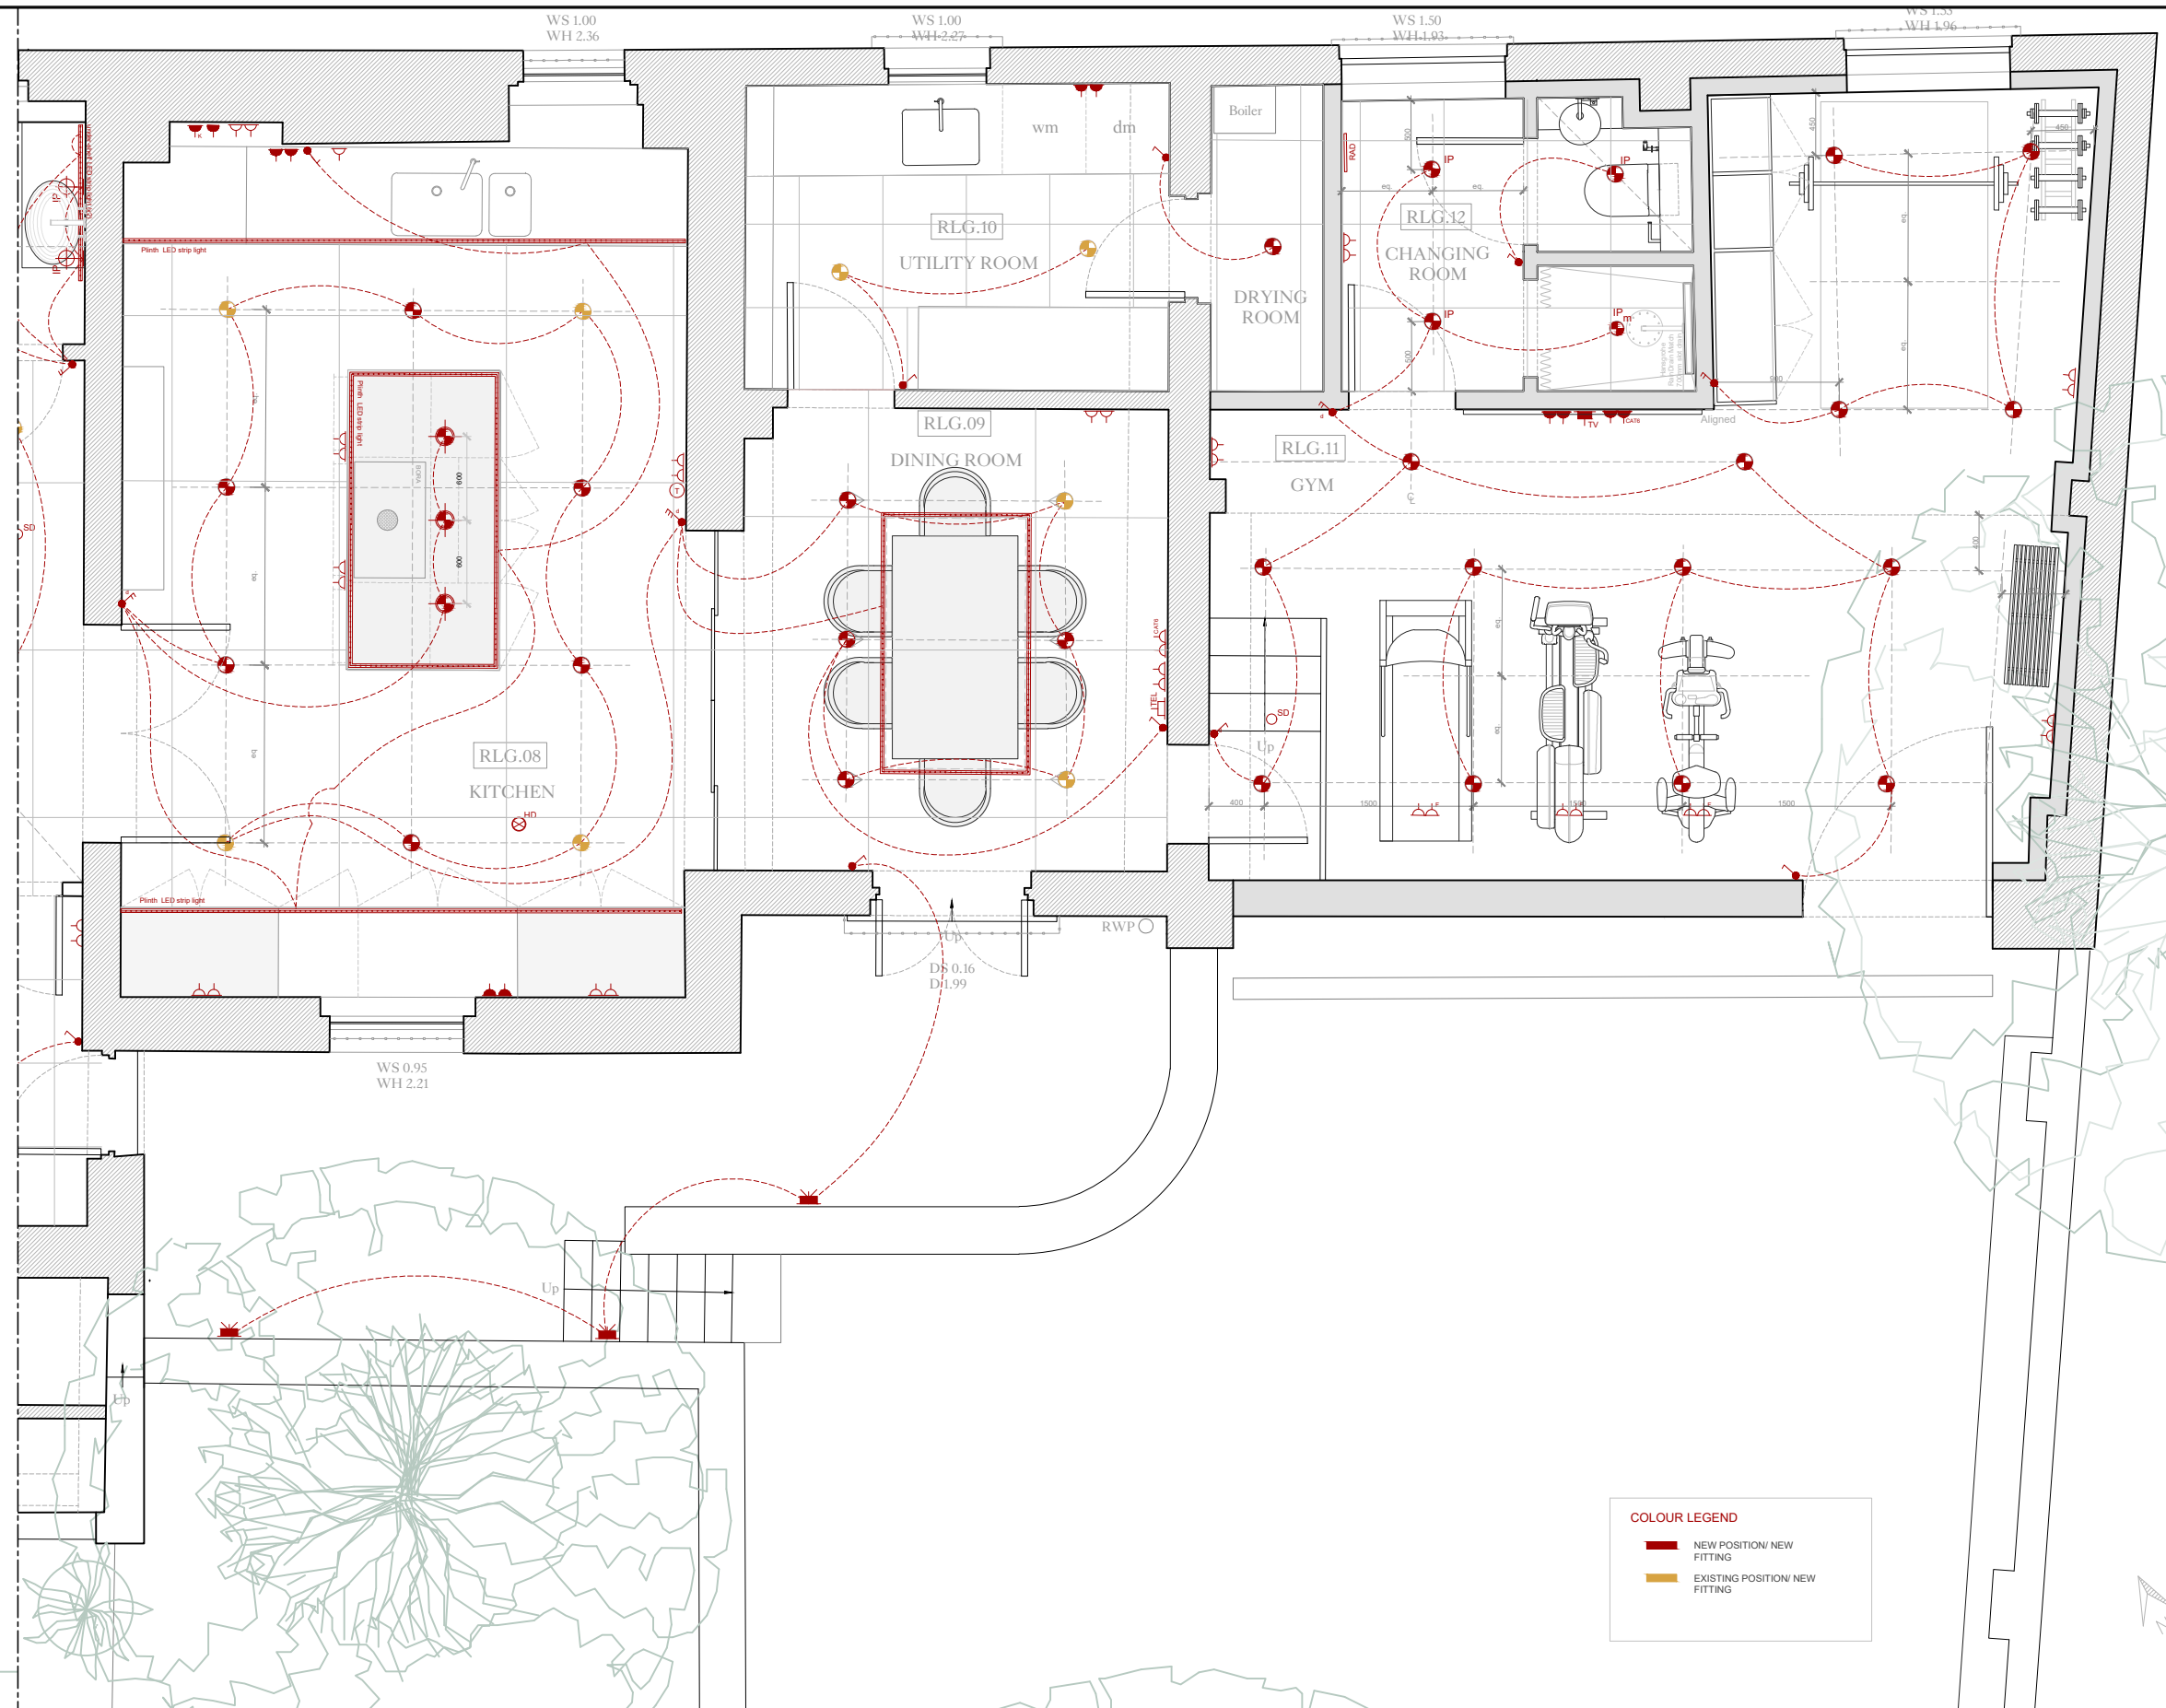

**general notes**

THIS DRAWING IS COPYRIGHT OF CLIFTON INTERIORS LTD. THIS DRAWING MUST BE READ IN CONJUNCTION WITH THE DESIGNER'S RISK ASSESSMENT, SPECIFICATION AND ALL OTHER RELEVANT DOCUMENTATION AND DRAWINGS. CLIFTON INTERIORS LTD ACCEPT NO LIABILITY FOR ANY EXPENSE, LOSS OR DAMAGE OF WHATSOEVER NATURE AND HOWEVER ARISING FROM ANY VARIATION MADE TO THIS DRAWING OR IN THE EXECUTION OF THE WORK TO WHICH IT RELATES WHICH HAS NOT BEEN REFERRED TO THEM AND THEIR APPROVAL OBTAINED.

DO NOT SCALE FROM THIS DRAWING OR THE COMPUTER DIGITAL DATA, ONLY FIGURED DIMENSIONS ARE TO BE USED.

IF IN DOUBT ASK.

**purpose of issue**

PLANNING

**notes**

- \* do not scale from this drawing.
- \* check all dimensions on site.

**revisions**

1 - 24/01/2025	
----------------	--

<b>project name</b> 5 PRINCE ALBERT ROAD		<b>drawing title</b> LOWER GROUND FLOOR - SMALL POWER PLAN GYM	
<b>scale</b> 1:50@A3	<b>date</b> 24/01/2025	<b>project ref.</b> 2401	<b>drawing no.</b> 150.2
<b>drawn by</b> CI	<b>checked</b> CI	<b>revision</b> 1	

Clifton Interiors

Est. 1986

168 Regents Park Road  
London NW1 8XN  
020 7586 5533  
www.cliftoninteriors.com