


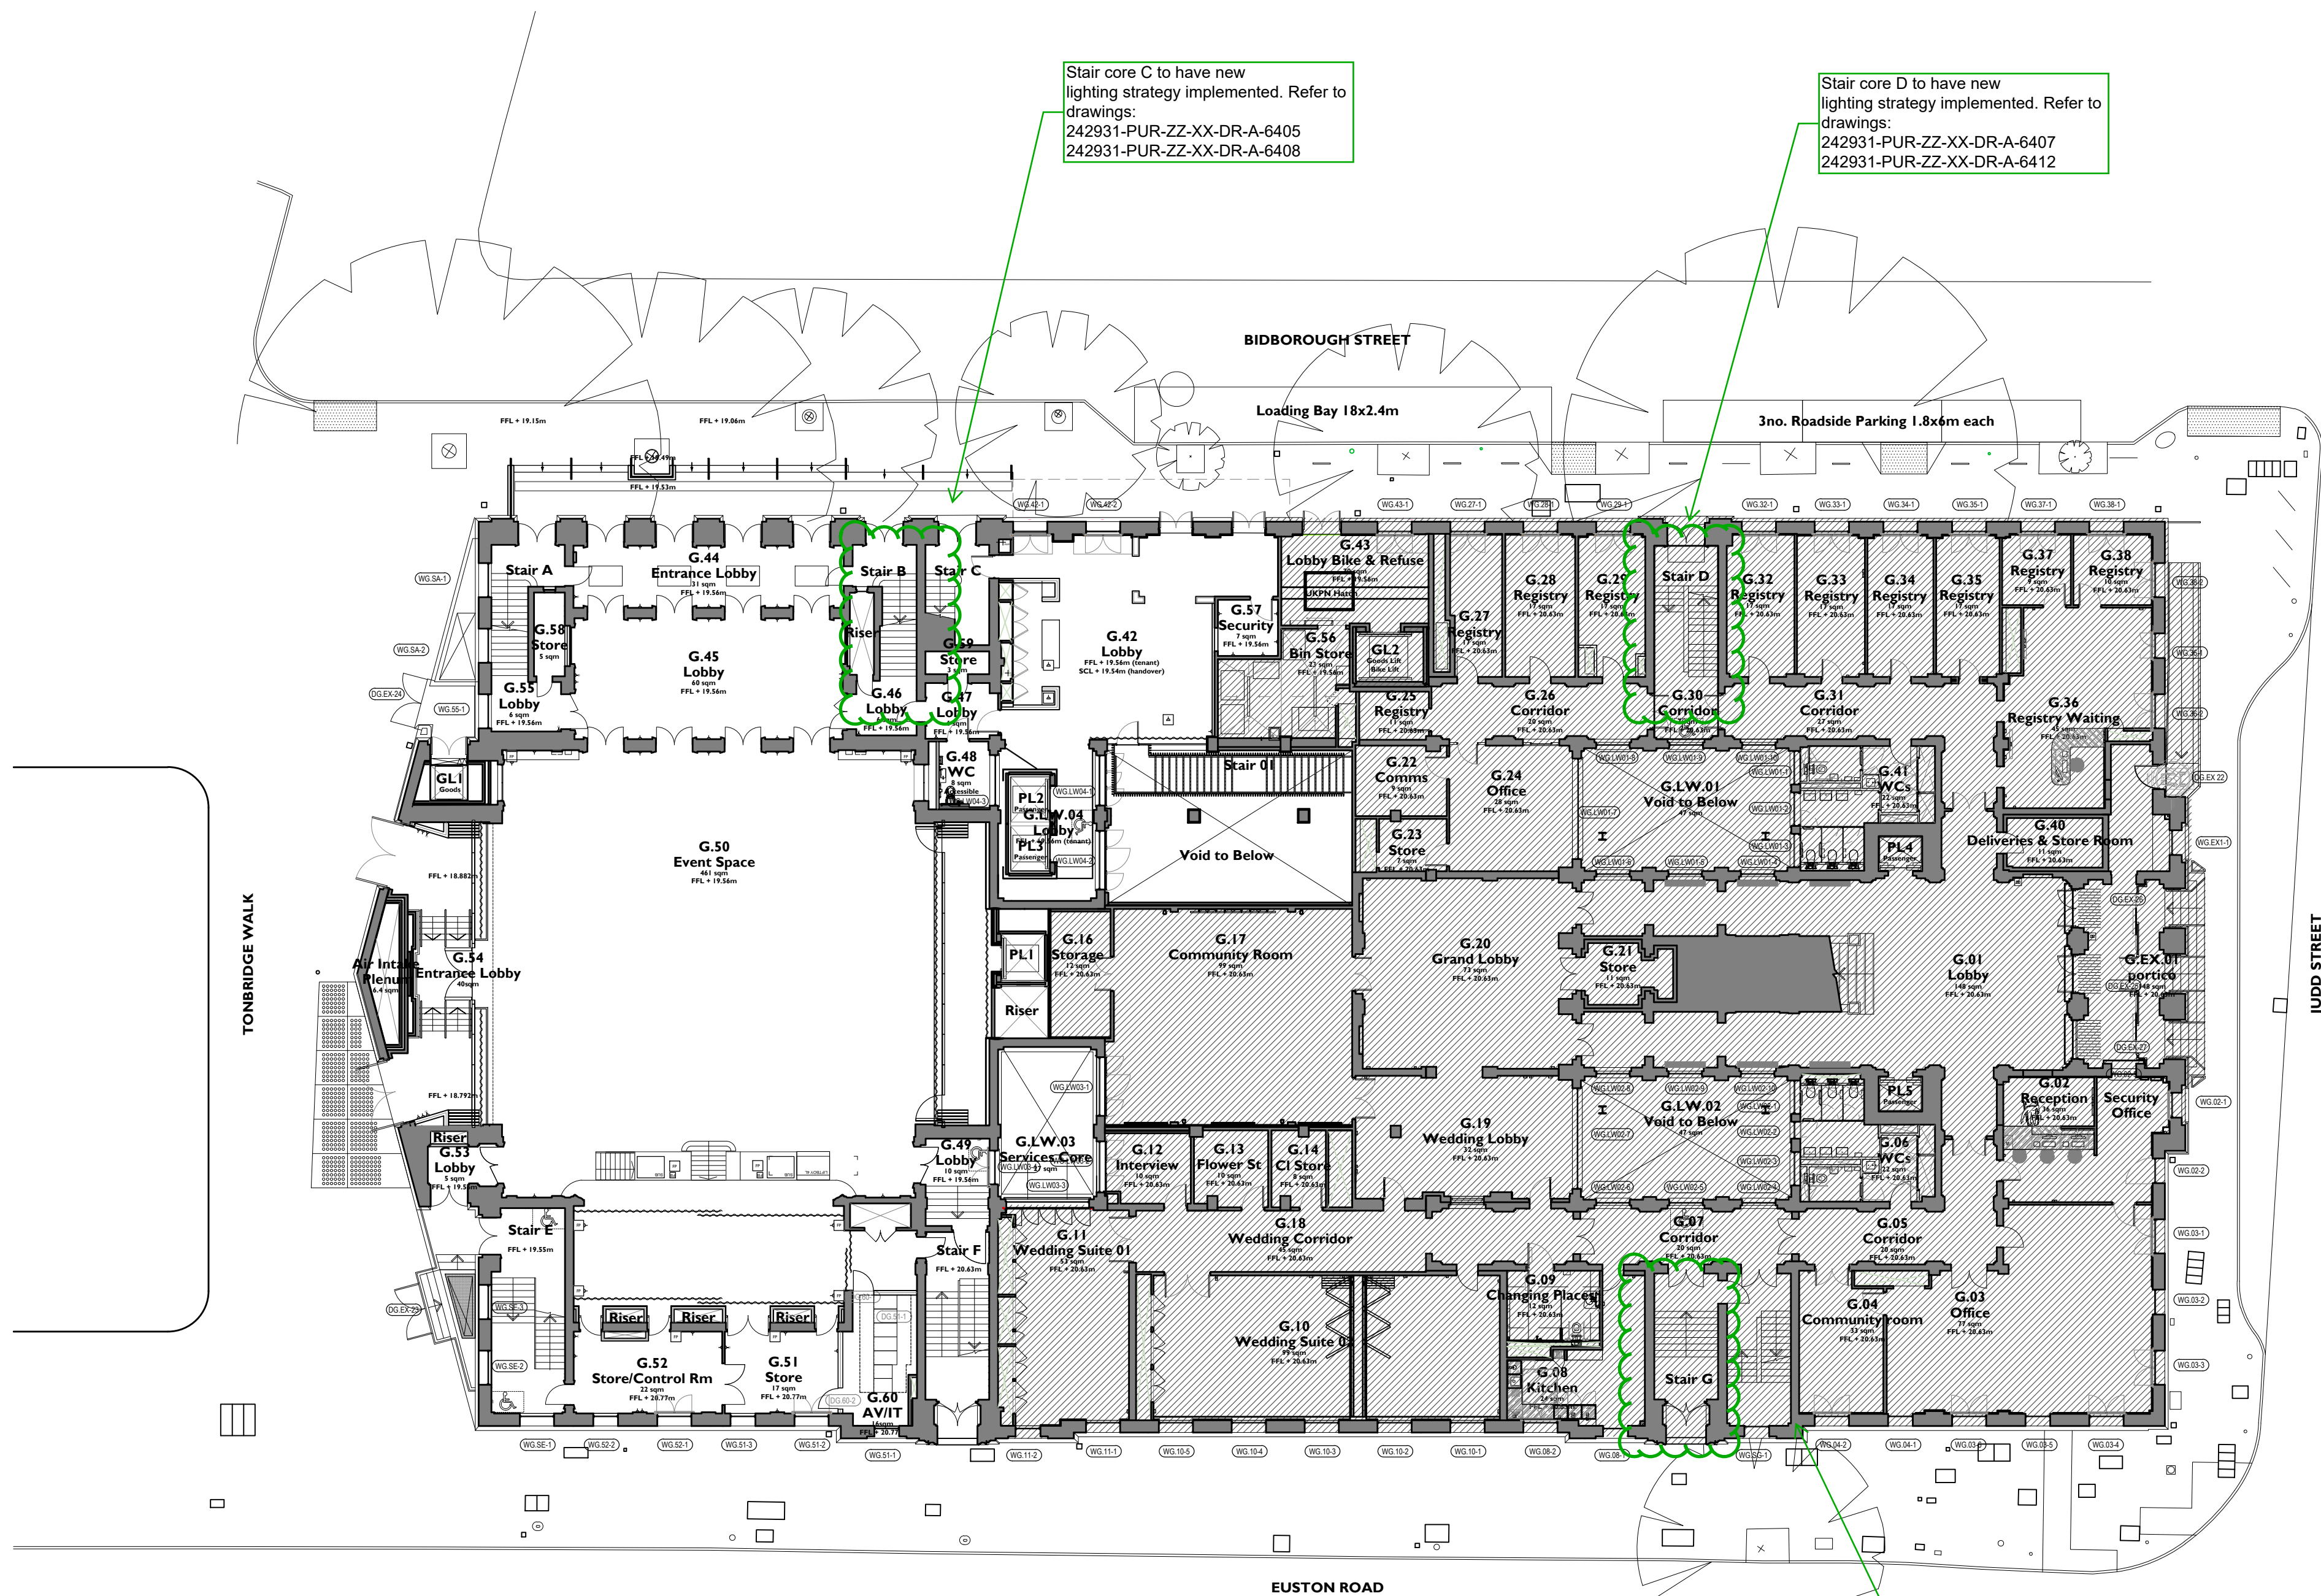

Stair core C to have new lighting strategy implemented. Refer to drawings:
242931-PUR-ZZ-XX-DR-A-6405
242931-PUR-ZZ-XX-DR-A-6408

Stair core D to have new lighting strategy implemented. Refer to drawings:
242931-PUR-ZZ-XX-DR-A-6407
242931-PUR-ZZ-XX-DR-A-6412

Stair core G to have new lighting strategy implemented. Refer to drawings:
242931-PUR-ZZ-XX-DR-A-6406
242931-PUR-ZZ-XX-DR-A-6409

Notes:

Drawings are based on survey data and may not accurately represent what is physically present.

Do not scale from this drawing. All dimensions are to be verified on site before proceeding with the work.

All dimensions are in millimetres unless noted otherwise.

Purcell shall be notified in writing of any discrepancies.

Key Plan

not to scale

1:200 Scale



REV	DATE	BY	CHK	DESCRIPTION
P01	20.12.24	DZ	OB	For LBC

CLIENT

Il Bottaccio

PROJECT

Camden Town Hall Tenant Fitout

JOB NUMBER

242931

TITLE

PROPOSED GROUND FLOOR PLAN

SIZE

A1L

SCALE

1:200

REV

P01

SUITABILITY/REASON FOR ISSUE

S4 - For Review and Authorisation

DRAWING NUMBER

242931-PUR-01-GF-DR-A-9201

