


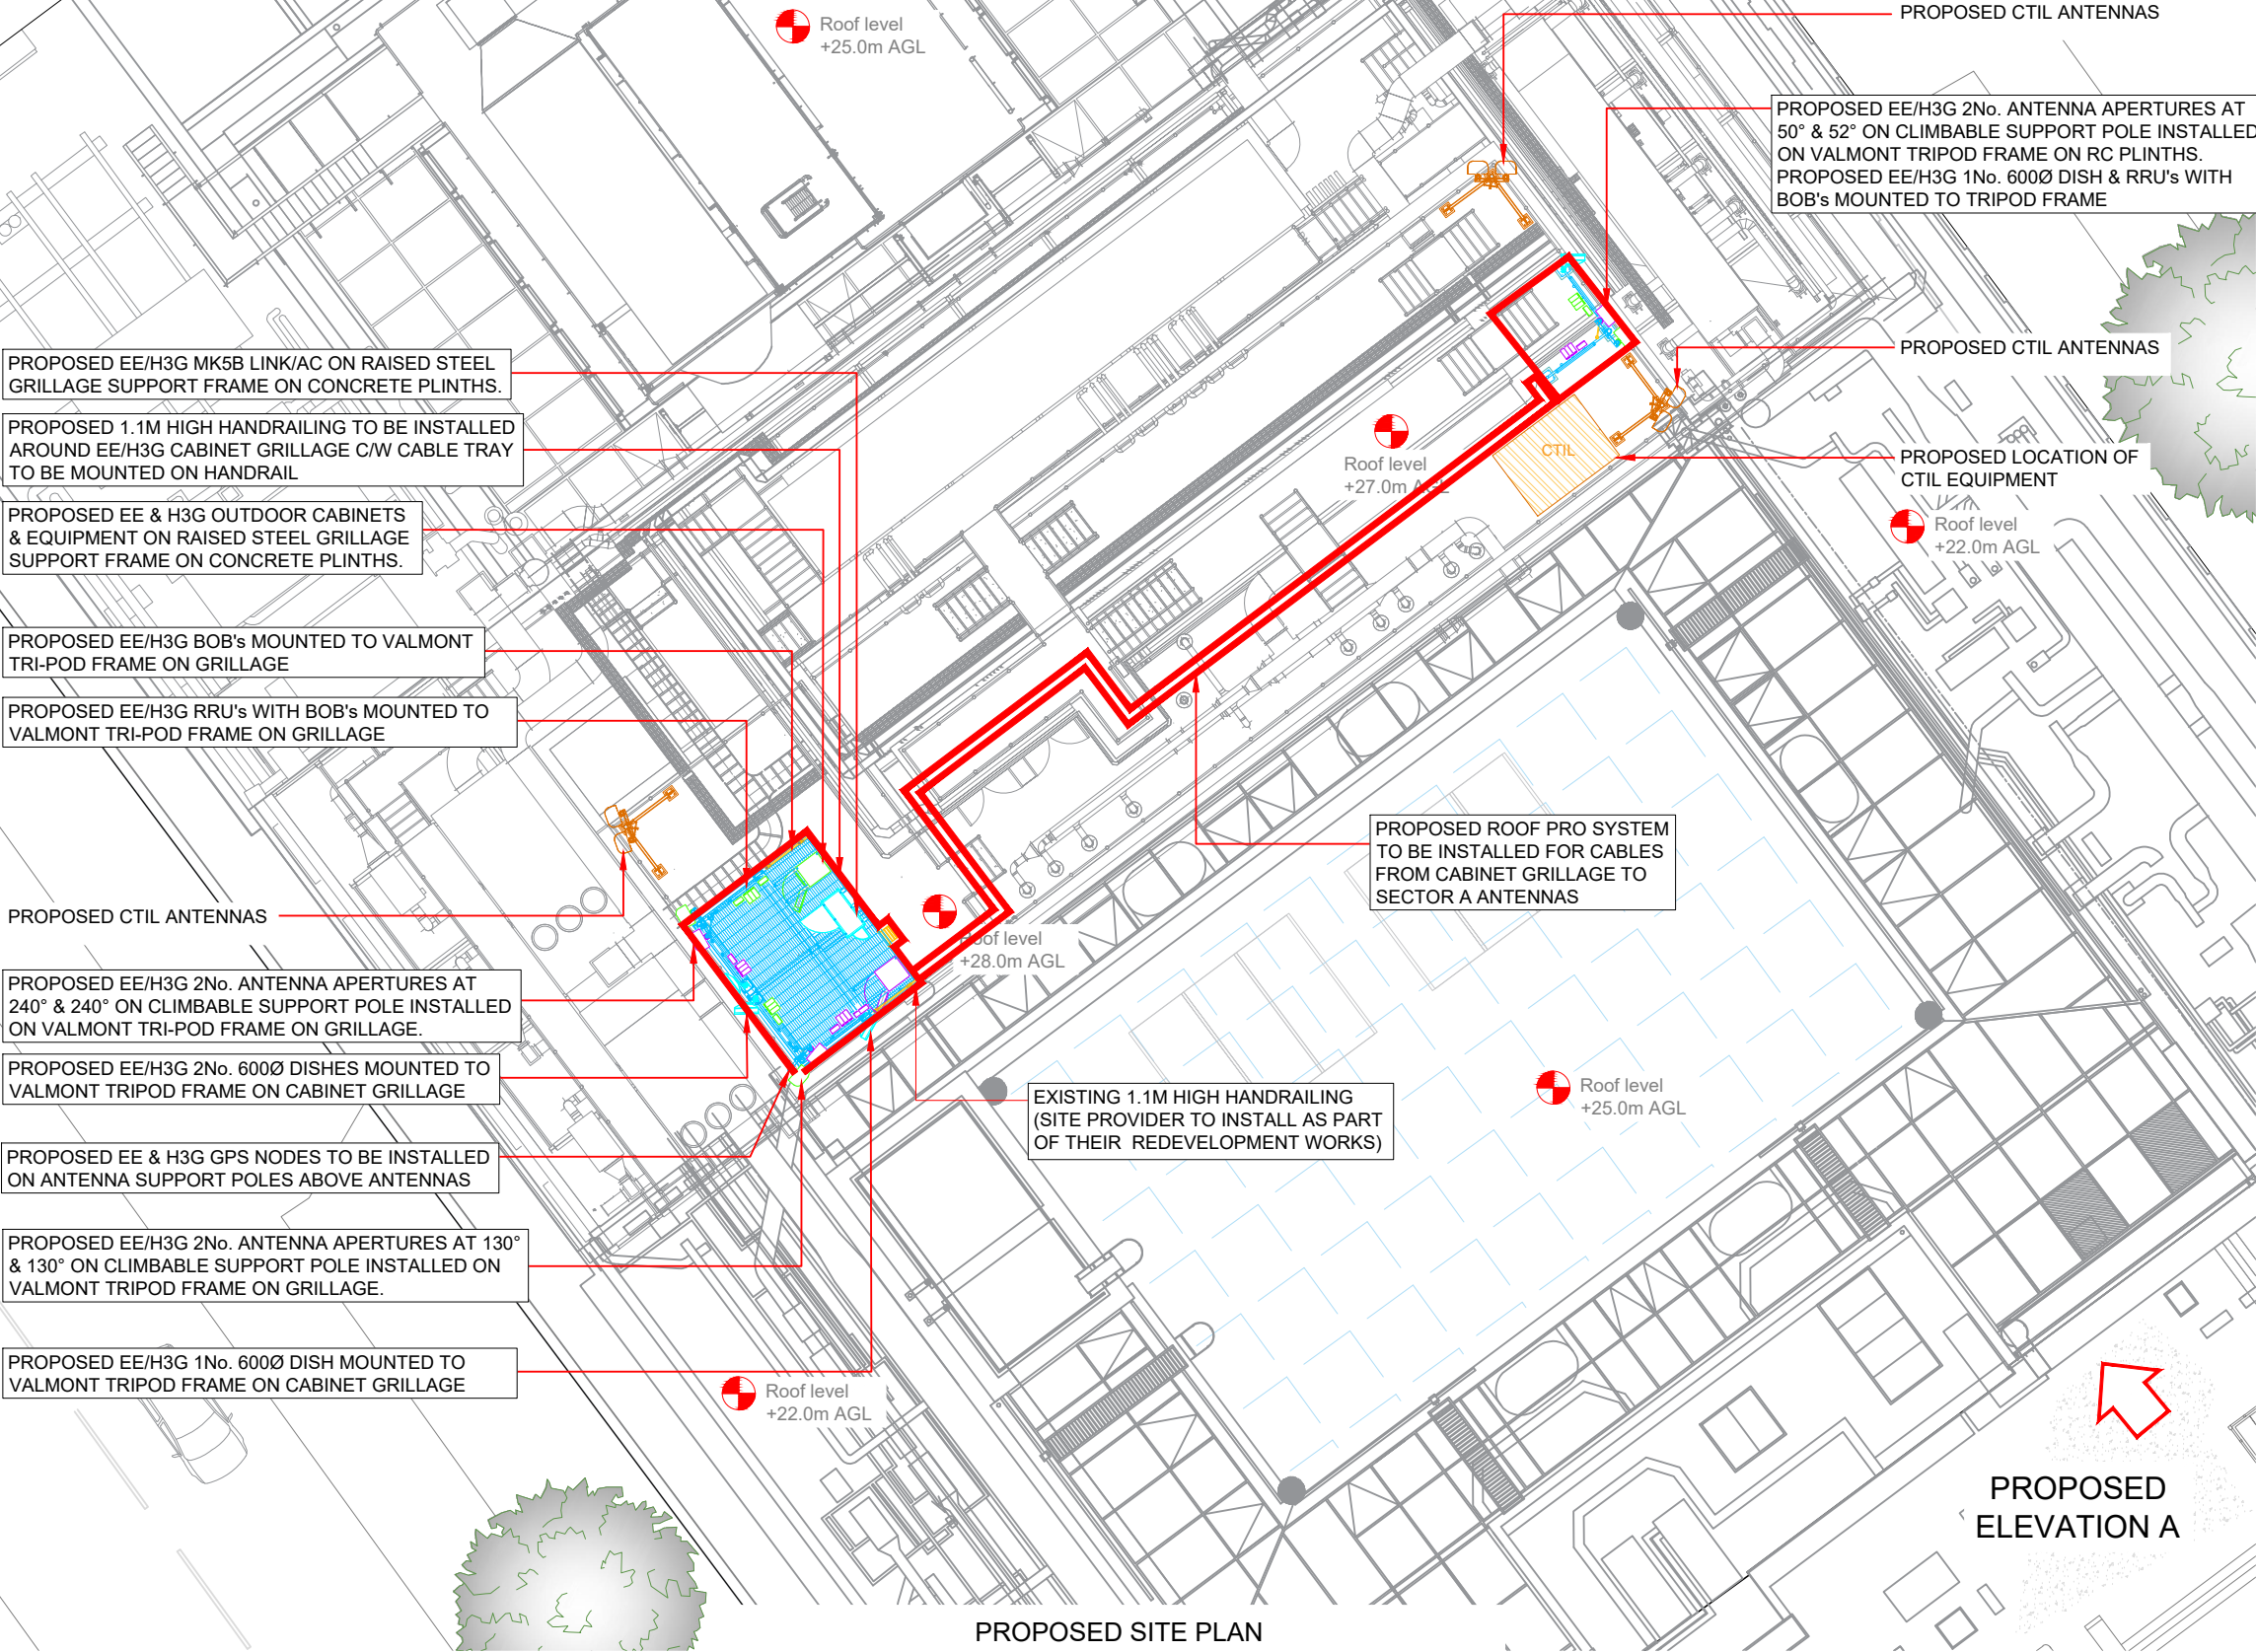

PROPOSED SITE PLAN



NOTE: S1A CONFIG IS PROPOSED ON THIS SITE TO REPLICATE EXISTING AAUS AND TECHS THAT ARE PRESENT ON THIS SITE ALREADY

Master:	MBNL / EE / H3G:	Project:	Purpose of Issue:	Issue:
M015	MBNL	L&S	General Arrangement	H
Date:	20/09/2024	Revision / Upgrade Description:		
Drawn:	I.Starkey	NGR updated for new Link AC location following TX Rejection comments		
Checked:	C.Barge			
Approved:	C.Barge			
Master:	MBNL / EE / H3G:	Project:	Purpose of Issue:	Issue:
M014	MBNL	L&S	General Arrangement	G
Date:	09/09/2024	Revision / Upgrade Description:		
Drawn:	I.Starkey	General Arrangement		
Checked:	C.Barge			
Approved:	C.Barge			
Master:	MBNL / EE / H3G:	Project:	Purpose of Issue:	Issue:
M013	MBNL	L&S	General Arrangement	F
Date:	15/03/2024	Revision / Upgrade Description:		
Drawn:	I.Starkey	BT Rejection comments addressed.		
Checked:	C.Barge	Existing antenna schedule added		
Approved:	C.Barge			
Master:	MBNL / EE / H3G:	Project:	Purpose of Issue:	Issue:
M012	MBNL	L&S	General Arrangement	E
Date:	15/03/2024	Revision / Upgrade Description:		
Drawn:	I.Starkey	General Arrangement		
Checked:	C.Barge			
Approved:	C.Barge			



Hutchison 3G UK Limited
Green Park
450 Longwater Avenue,
Reading
RG30 3UR
Tel: 01628 765 000
H3G Base Station Information line:
0845 6043000
Available 8am-6pm Monday to Friday



Hartfield Business Park
Hartfield
Hertfordshire
AL10 9BW
Tel: 01707 315000
Fax: 01707 319001



Mobile Broadband Network Limited
Sixth Floor, Thames Tower, Station Road, Reading, RG1 1LX



Unit 27F-G
Hartlebury Trading Estate
Crown Lane
Hartlebury
Worcestershire
DY10 4JD

Site Name:	HYG & TROPICAL MED		
Site ID:	1109521		
Address:	HYGIENE & TROPICAL MEDICINE 1 KEPPEL STREET LONDON WC1E 7HT		
Title:	200 PROPOSED SITE PLAN EQUIPMENT TO BE INSTALLED		
Project:	LIFT & SHIFT		
Purpose of Issue:	GENERAL ARRANGEMENT		
EE Cell ID:	27469	MBNL Cell ID:	CMN069
		3UK Cell ID:	WC0004
Master Drawing No:			Issue:
1109521_CMN069_27469_WC0004_M015			H