


I
2000
PROPOSED BASEMENT FLOOR LEVEL PLAN
1:200 @ A1

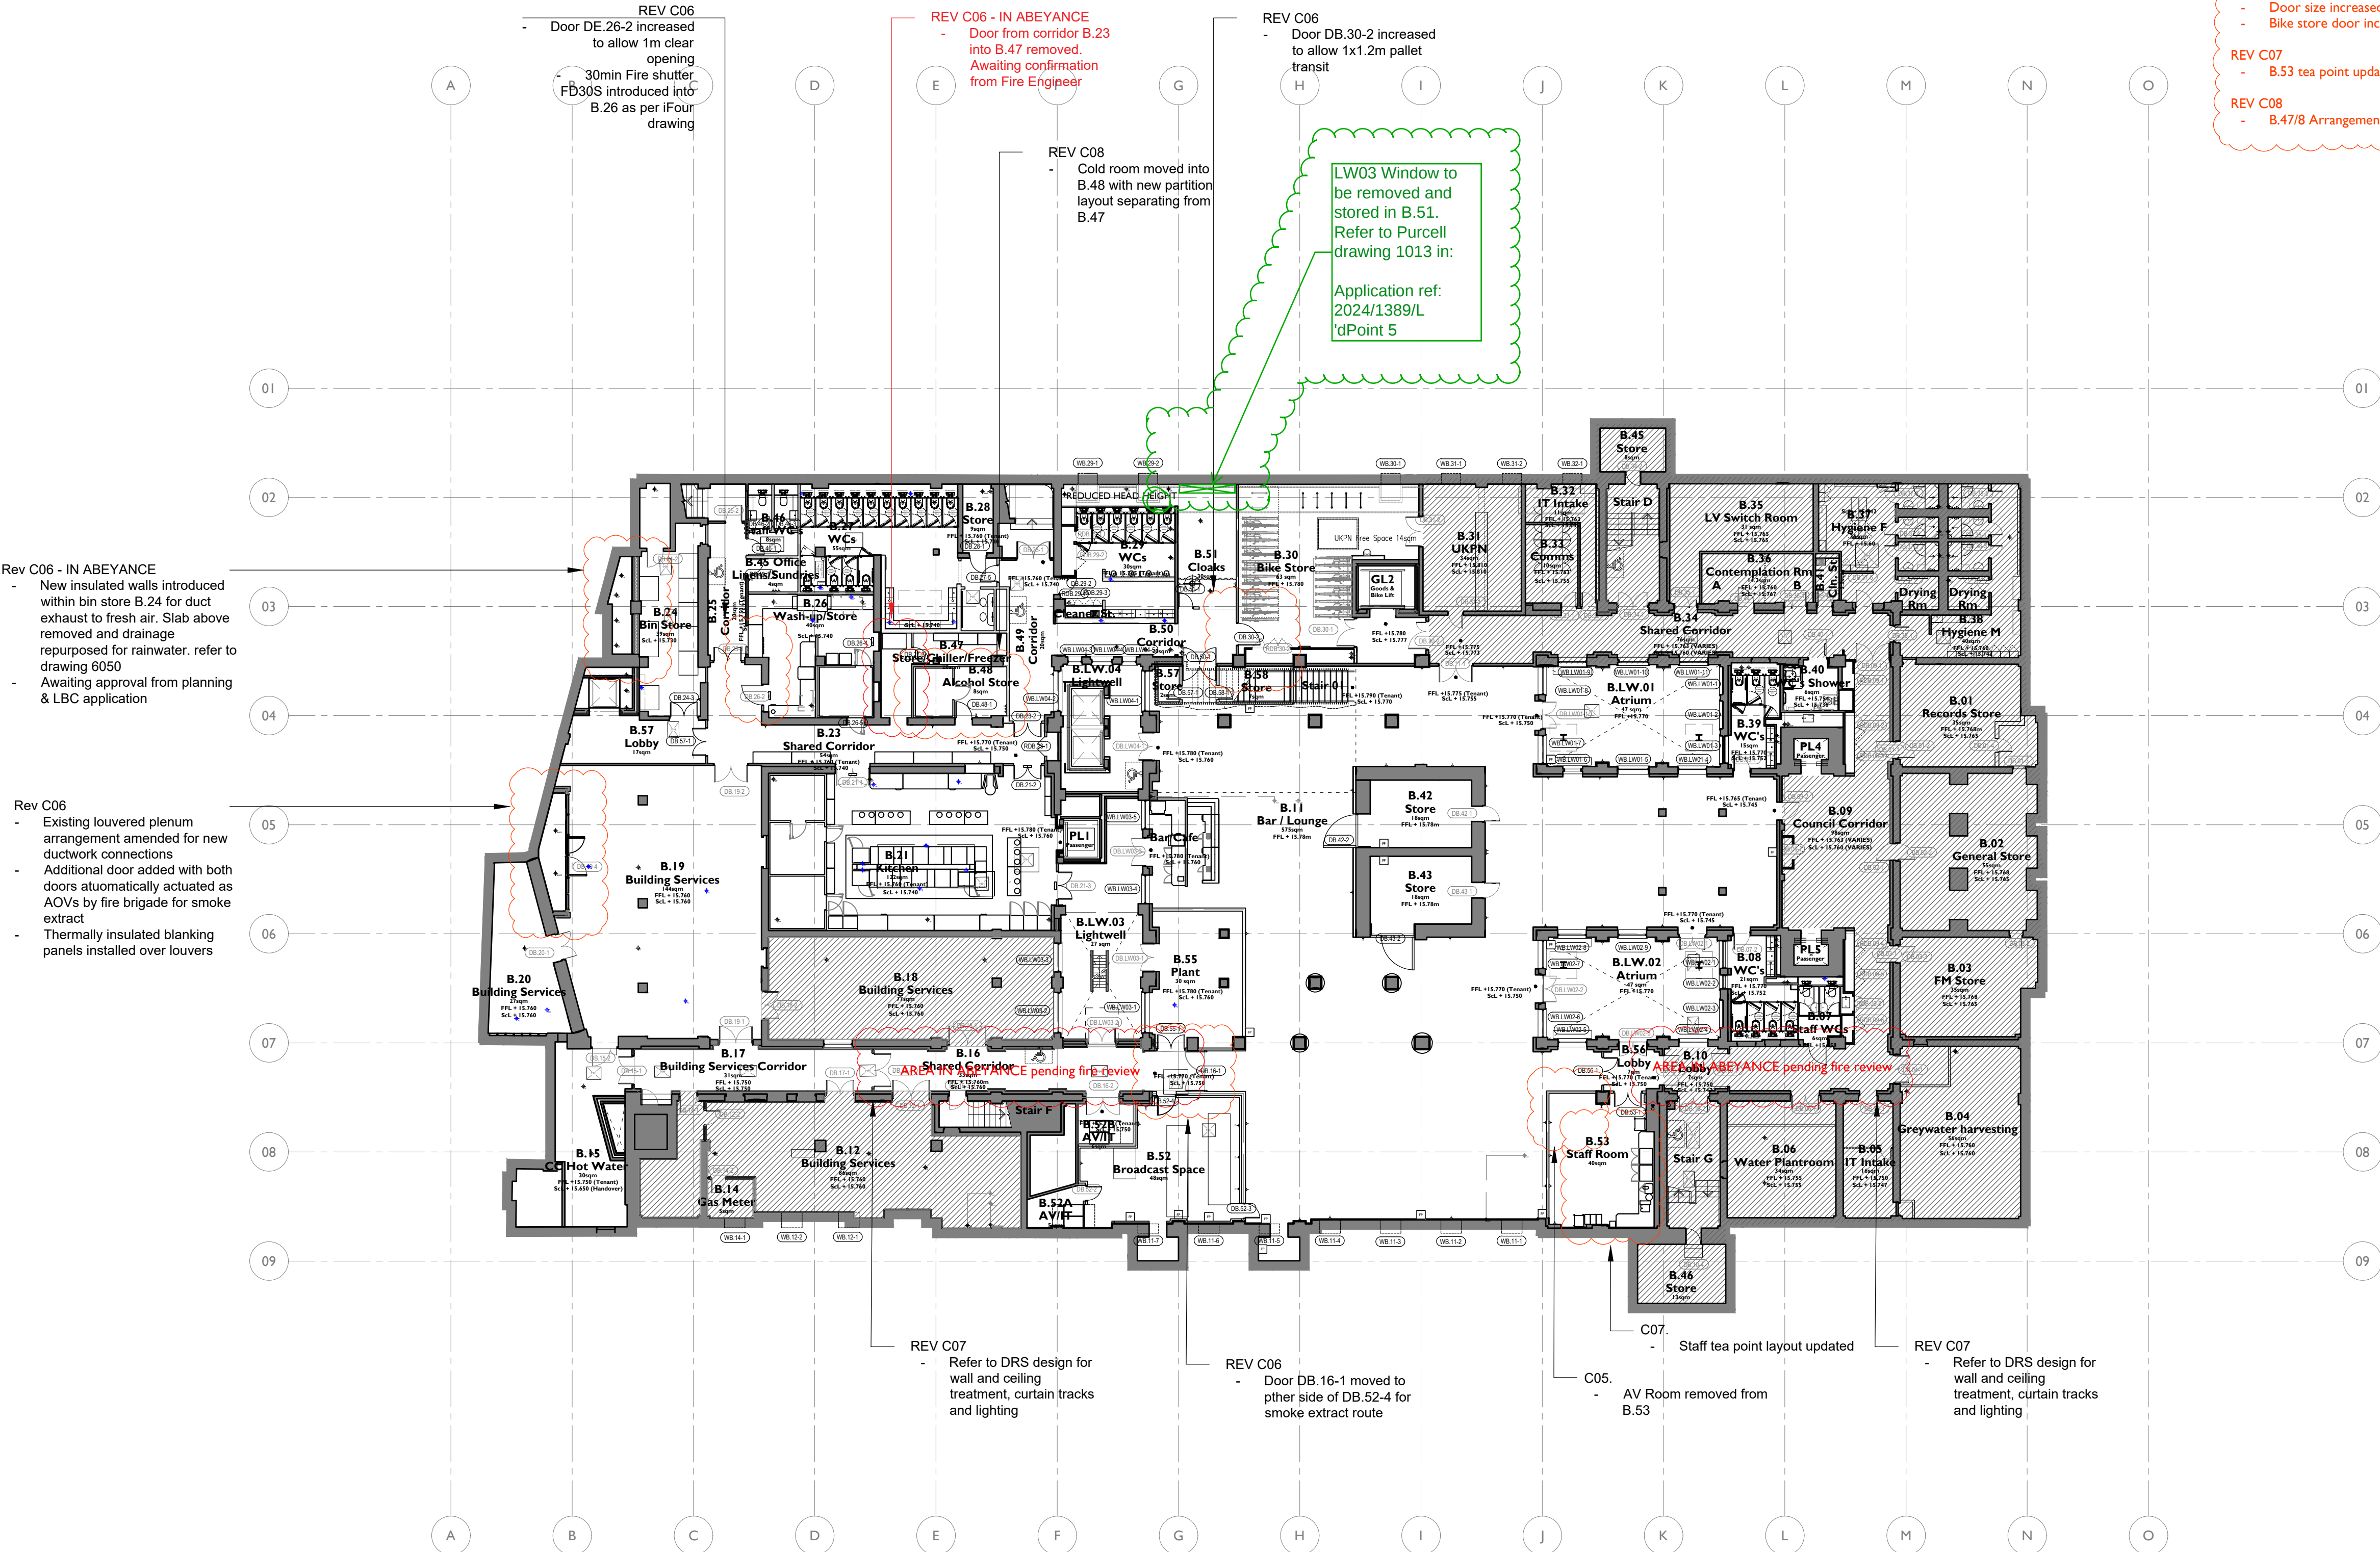

REV C03
Door DB.52-3 reintroduced for smoke ventilation

REV C04
- Tea point added to staff room B.53
- Racks moved from B.53 into B.52B with new lobby B.57 providing new entrance into B.52
- WVC cubicle & vanity updates

REV C05
- AV room to B.53 removed

REV C06
- Lobby B.58 to MCR space removed
- B.19 plenum adjusted for smoke extract
- B.24 bin store wall added for duct exhaust route to fresh air
- Door size increased and hatch introduced into B.26 wash up
- Bike store door increased for service route from GL2 lift

REV C07
- B.53 tea point updated

REV C08
- B.47/8 Arrangement updated with cold room now in B.48

Notes:

Drawings are based on survey data and may not accurately represent what is physically present.

Do not scale from this drawing. All dimensions are to be verified on site before proceeding with the work.

All dimensions are in millimetres unless noted otherwise.

Purcell shall be notified in writing of any discrepancies.

Key Plan

not to scale

Proposed Works Key

- Existing wall
- Demolition Element
- New stud wall
- Window Number
- Door Number
- Refuge Point
- Manhole Location

Drawings to be read in conjunction with PUR drawings and schedules:

- Fire strategy drawing series (50)00
- Wall type strategy plans (52)00
- Floor type strategy plans (53)00
- Ceiling type strategy plans (51)00
- Proposed 1:25 Elevations (40)00
- Proposed setting out plans (25)00

Proposed window schedule - 7100
Proposed door schedule - 7101
Proposed sanitary schedule - 7106
Proposed finishes schedule - 7107

Drawings also to be read in conjunction with DRS information:

Proposed General Arrangement - 100 series
Finishes schedule - 200147_CTH_DRSfinishes
Sanitaryware schedule - 200147_CTH_603_DRS
sanitaryware schedule



C08	22.10.24	OB	OB	Cold Room updates to B.47/8
C07	17.10.24	OB	OB	B.53 tea point layout updated
C06	15.10.24	OB	OB	S4 coordination and design changes
C05	23.09.24	OB	OB	B.53 AV room removed
C04	17.09.24	OB	OB	B.52 and B.53 updates + WC setting out
C03	09.08.24	TF	OB	Door DB.52-3 added for smoke vent
C02	14.06.24	TF	NS	STAGE 4 ISSUE
REV	DATE	BY	CHK	DESCRIPTION

CLIENT

Il Bottaccio

PROJECT

Camden Town Hall Tenant Fitout

JOB NUMBER

242931

TITLE

PROPOSED BASEMENT, GENERAL
ARRANGEMENT PLAN

SIZE SCALE

A1L As Indicated

REV SUITABILITY/REASON FOR ISSUE

C08 A4 - Technical Design Approved

DRAWING NUMBER

242931-PUR-01-B1-DR-A-2000

PURCELL® IS THE REGISTERED TRADE NAME FOR PURCELL ARCHITECTURE LTD AND ALL SUBSIDIARY COMPANIES AND IS REGISTERED IN THE UNITED KINGDOM, EUROPEAN UNION, HONG KONG, CHINA AND AUSTRALIA.
© PURCELL 2024. www.purcelluk.com

