

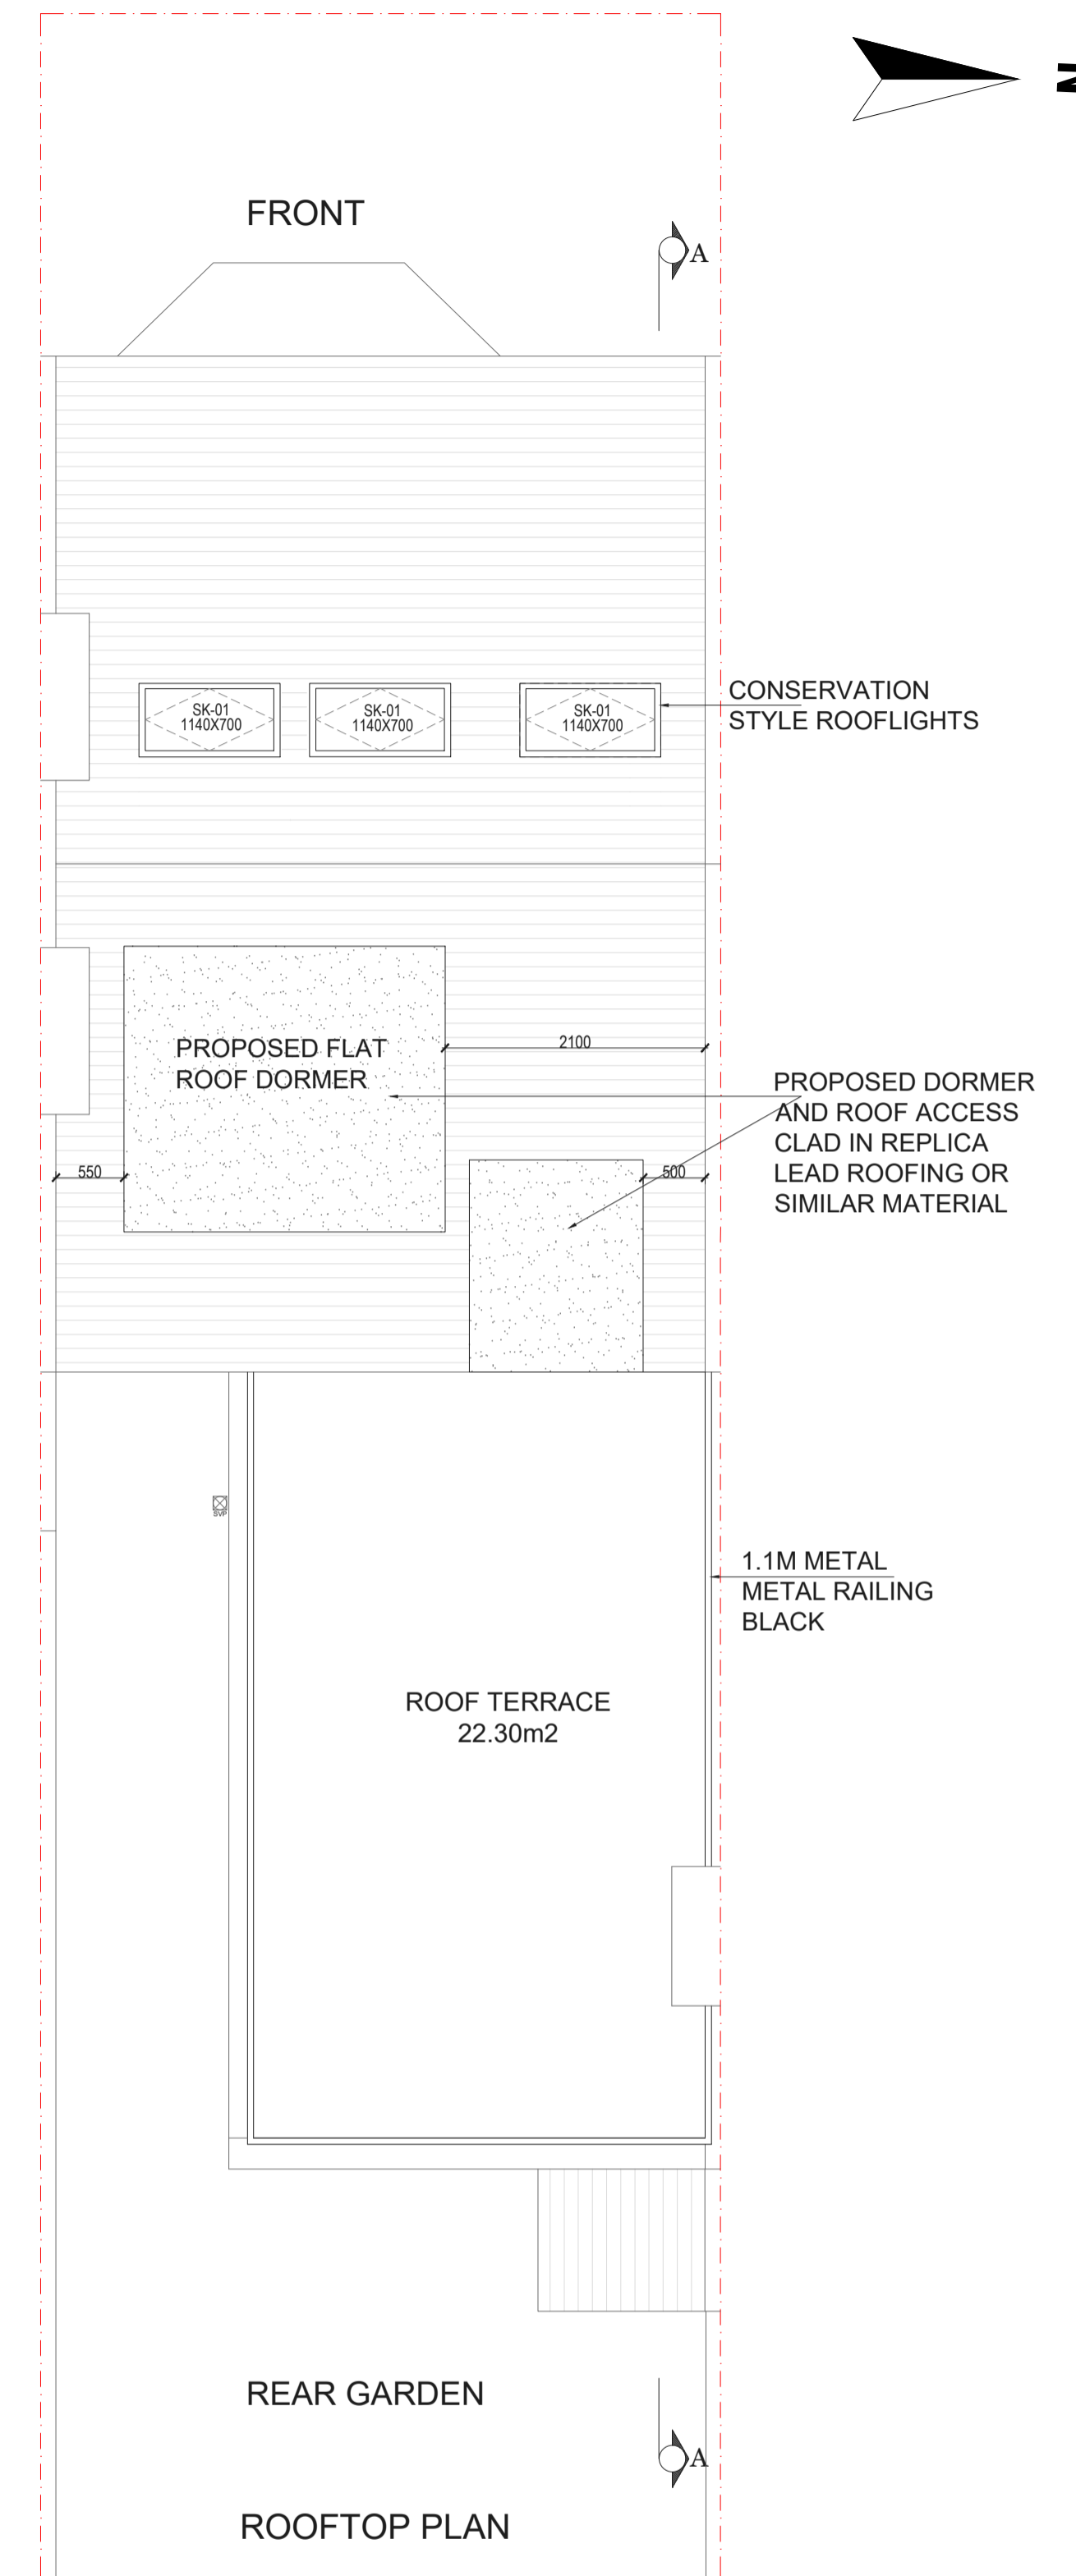
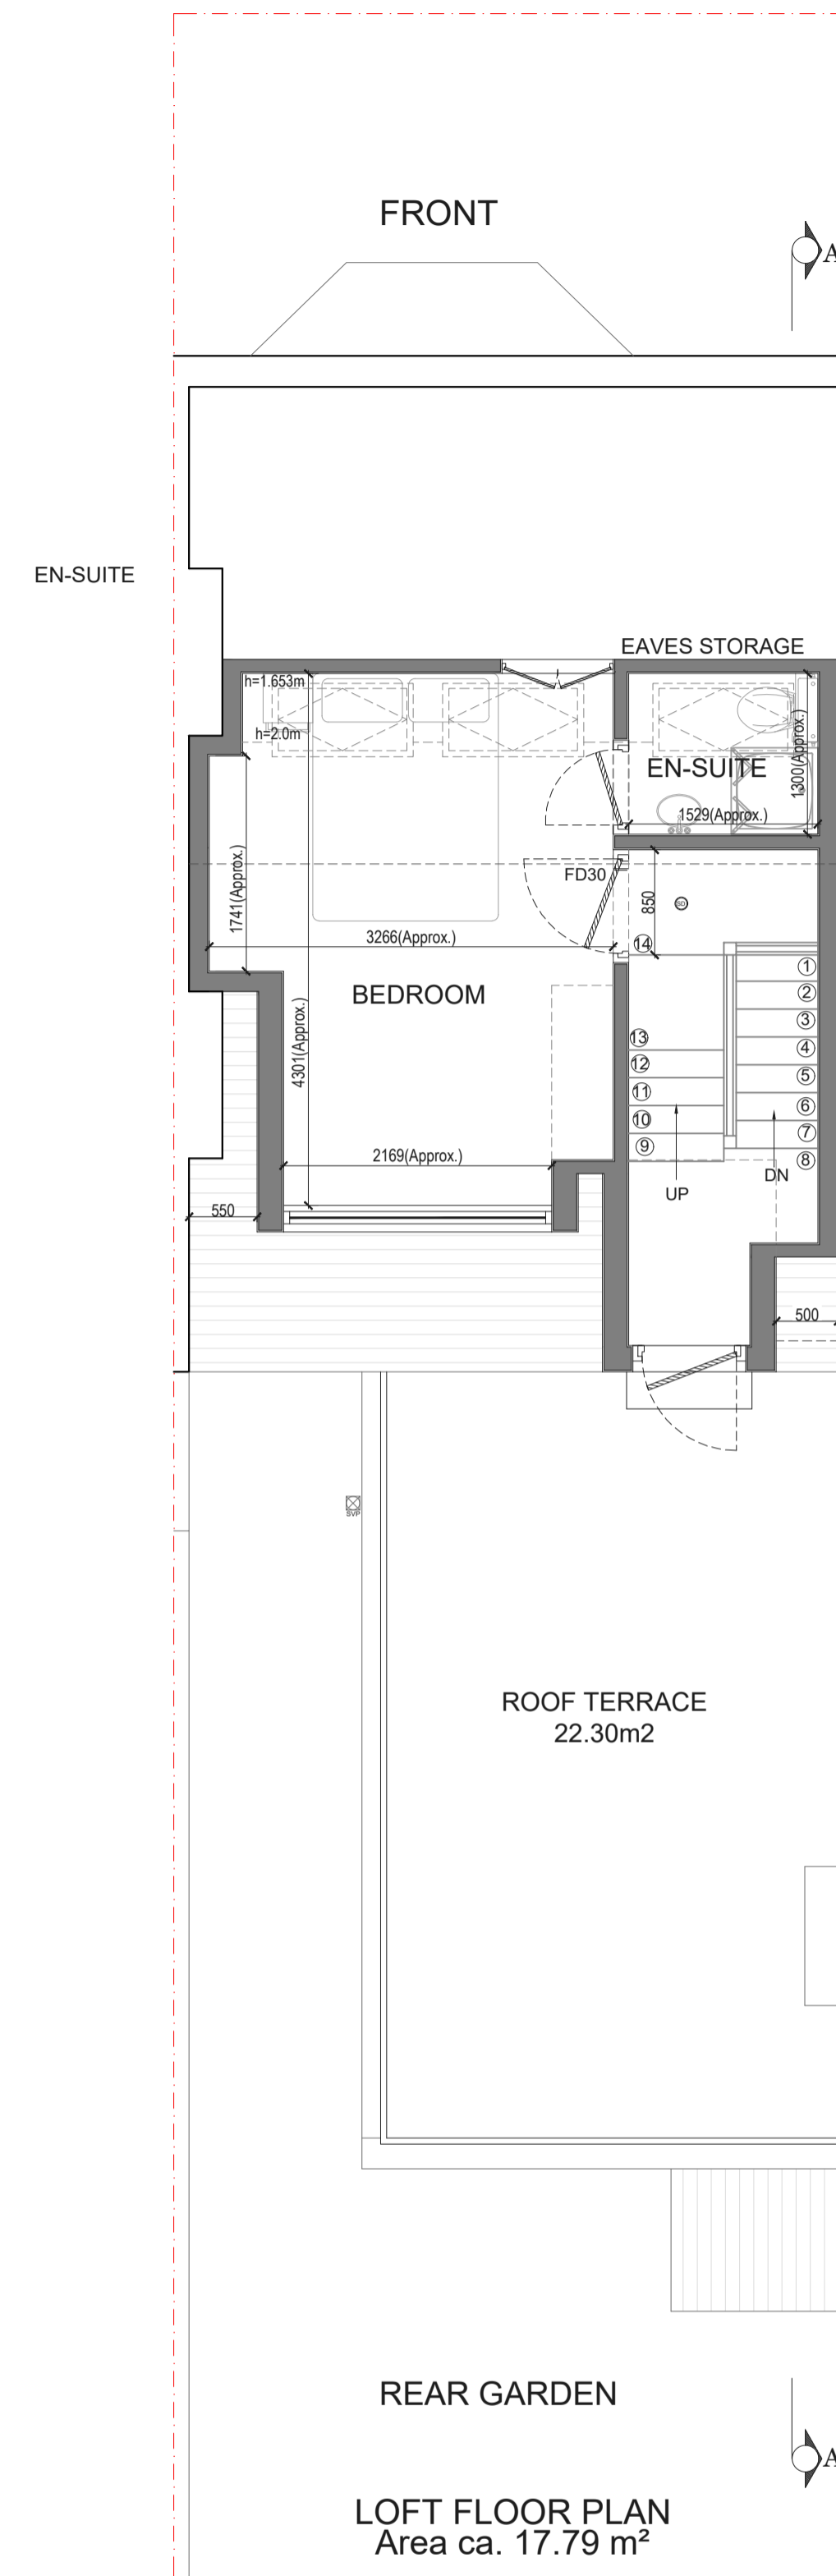
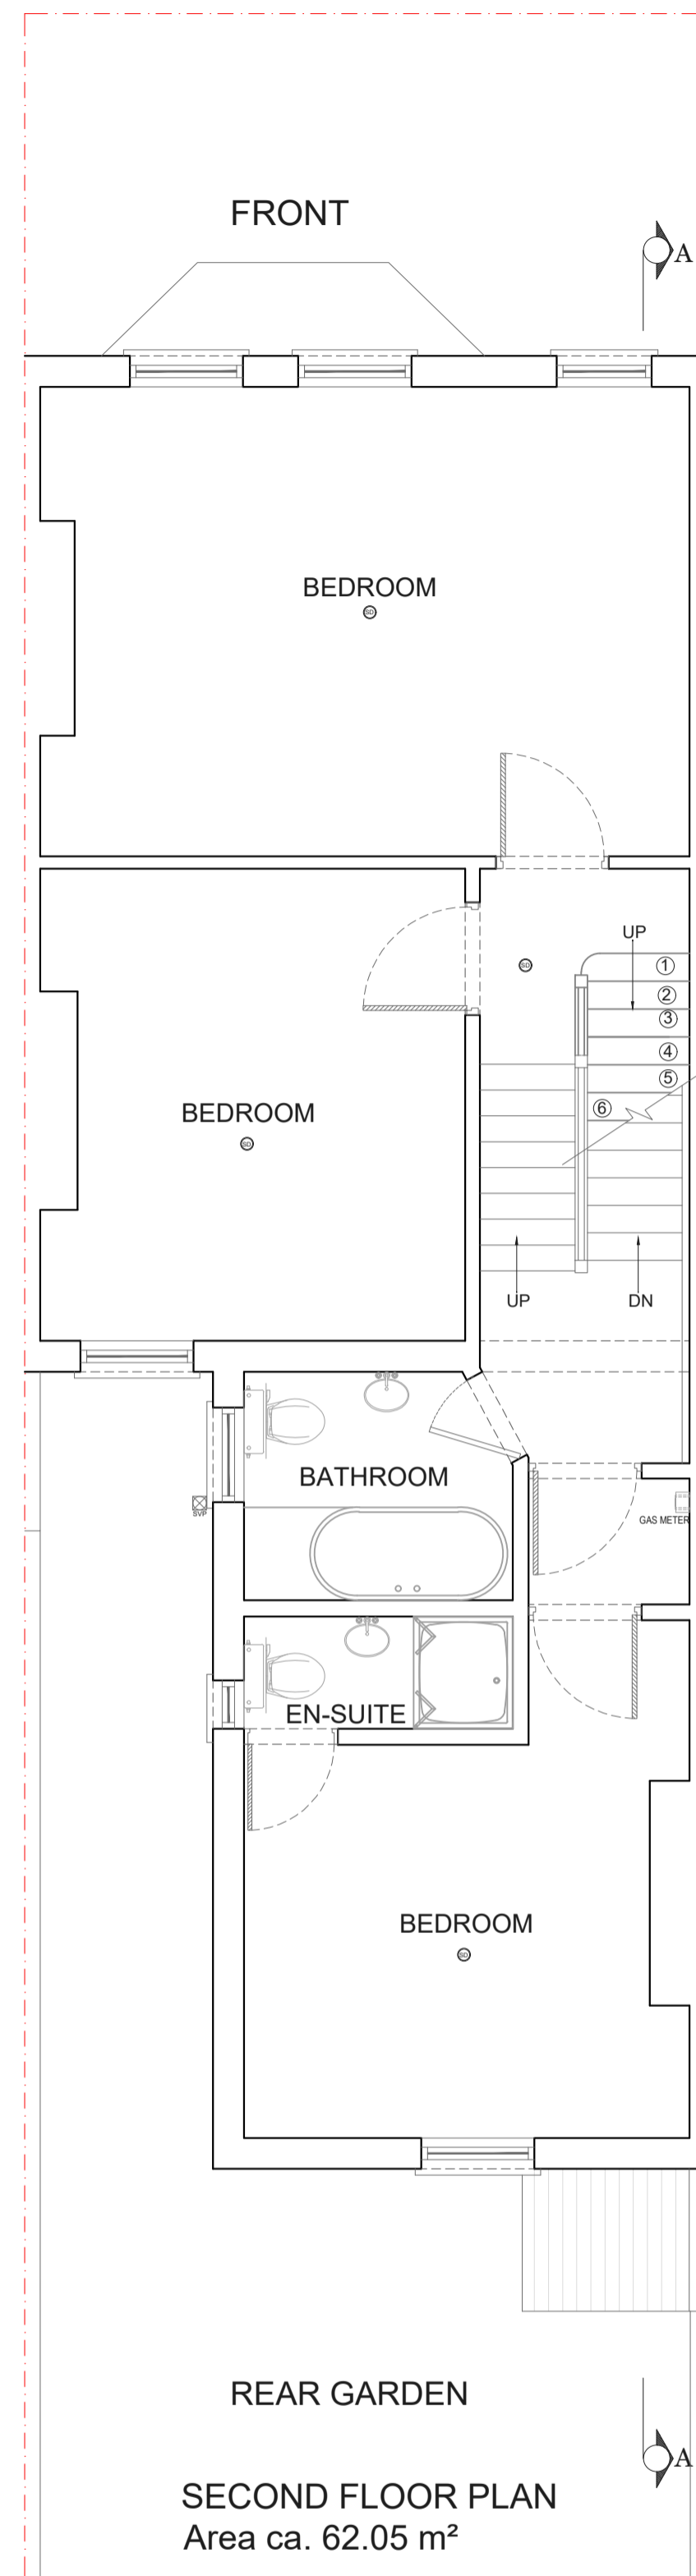
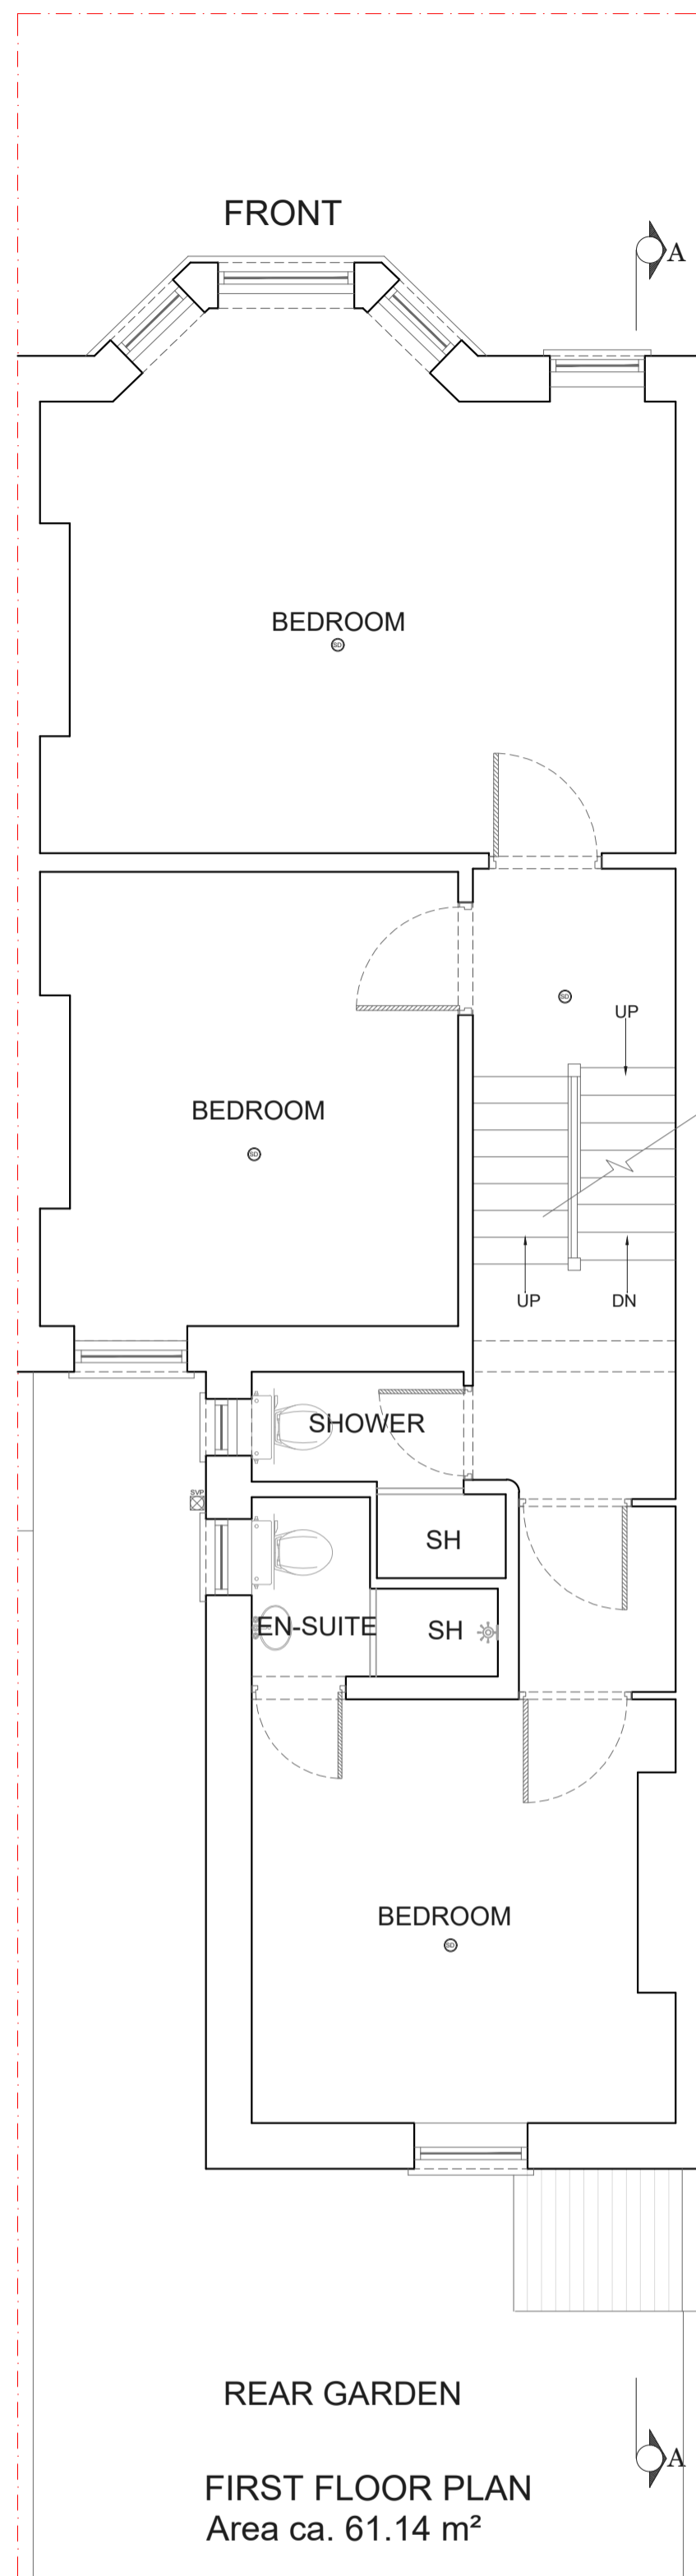
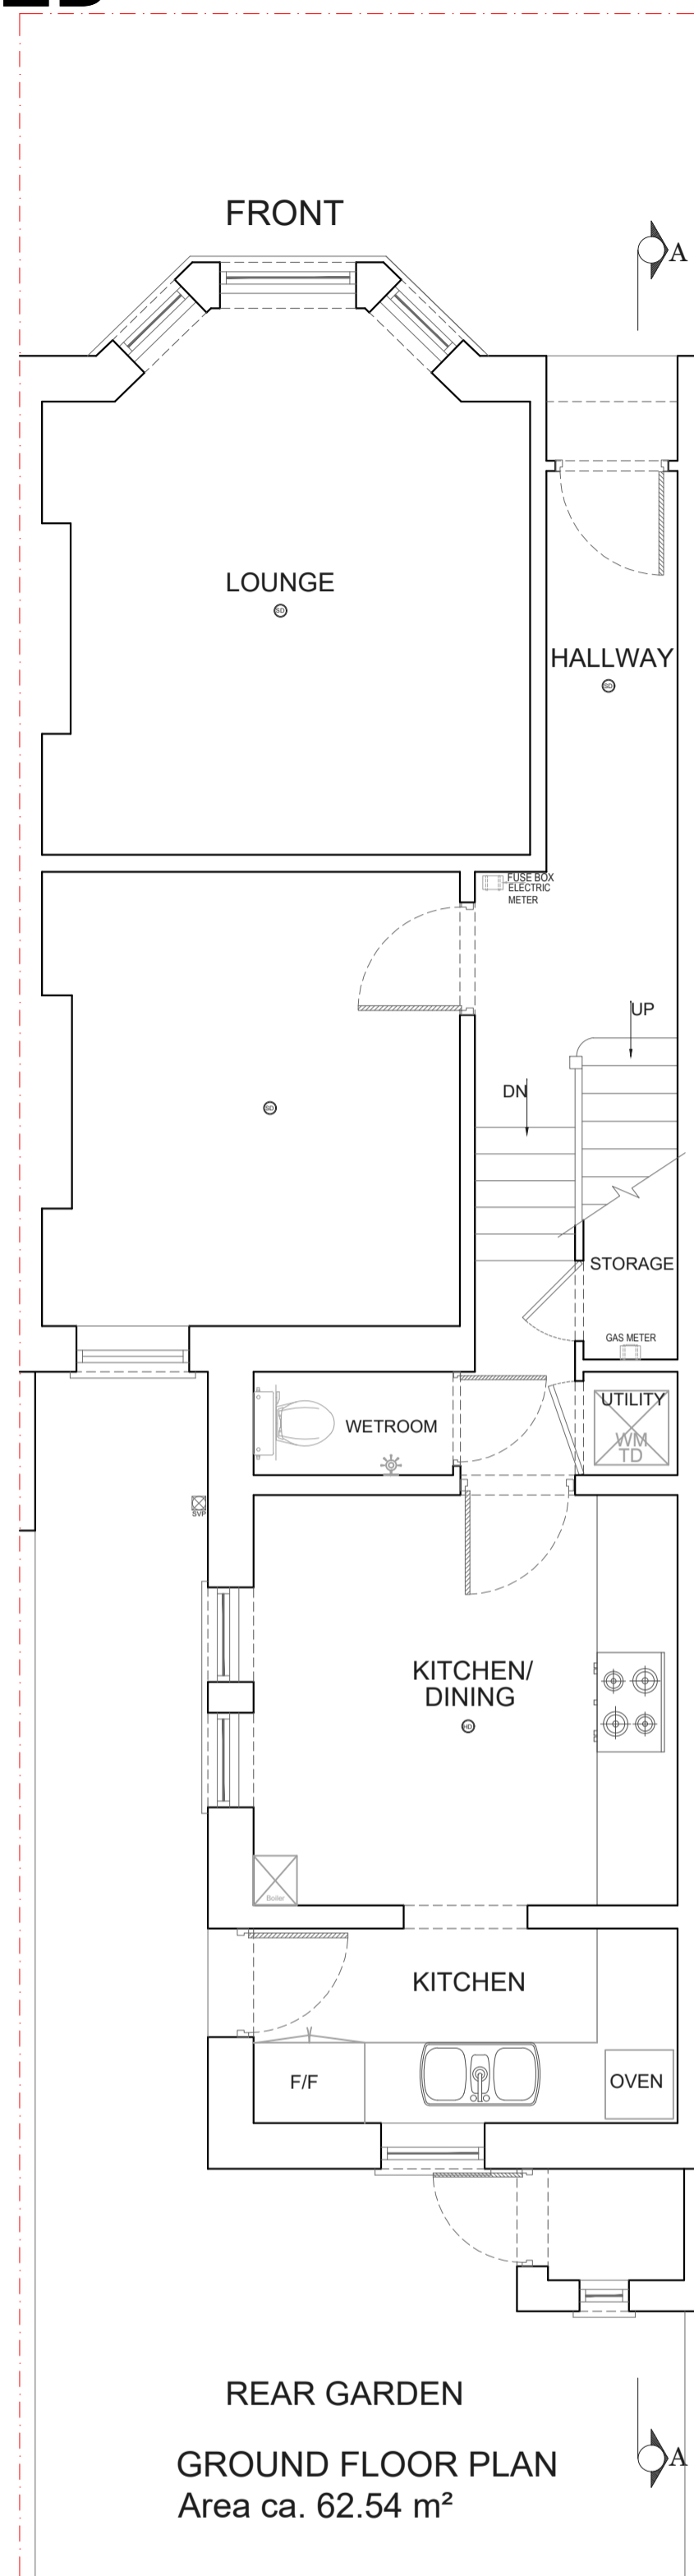


PROPOSED

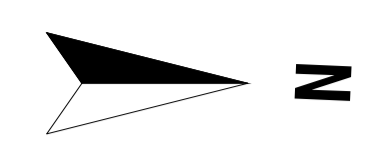

Symbol Key:

- Proposed wall
 - Boundary line
 - Details above
 - Waste drainage layout
 - Demolished
 - Rainwater layout
 - Fixtures and fittings
- New rainwater waste to be taken to new or existing soak away minimum 5metres away from any foundation. Contractor to specify new location on site.
- Timber/steel beam above sized and specified by Structural Engineer - fire proofed as per spec. and detail drawing

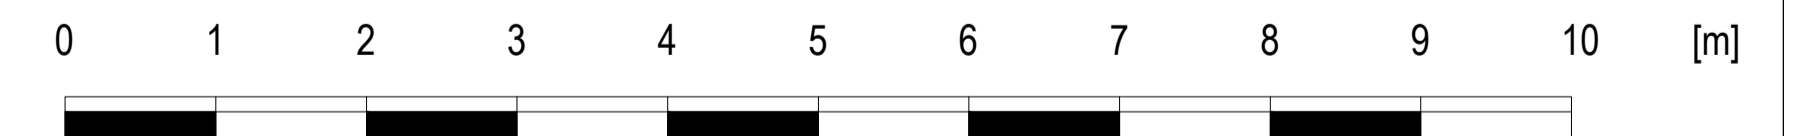

Drawn by:
A-A

Project:
30 MACKESON ROAD LONDON NW3 2LT

Date:
28.02.2025

No.:
PP-02

Client:
LIA BROWN

Drawing Title:
PROPOSED PLANS

Scale @A1:
1:50

Rev:
R3

Page:

