


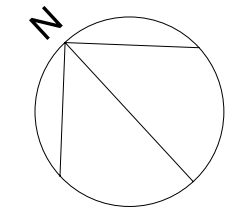
 
SITE BOUNDARY (APPLICATION LINE ONLY)

	NAME	AREA (Hectare)	AREA (Acre)
	APPLICATION BOUNDARY	0.242	0.60


Architects are to be notified of any discrepancies.
Contractors must check all dimensions on site.
This drawing is subject to copyright laws and is for use on this project only.
This drawing is to be used solely for the information as titled only.
For other information refer to the latest revision of any cross referenced drawings.
To be read in conjunction with relevant design standards/protocols

This is a colour drawing. In order to ensure any subsequent reproduction is viewed correctly it should be printed in full colour.

GROUND FLOOR OUTLINE TO THE BASEMENT LEVEL 6



EV PARKING SUMMARY- BASEMENT 6	
TOTAL LOST PARKING SPACE	12

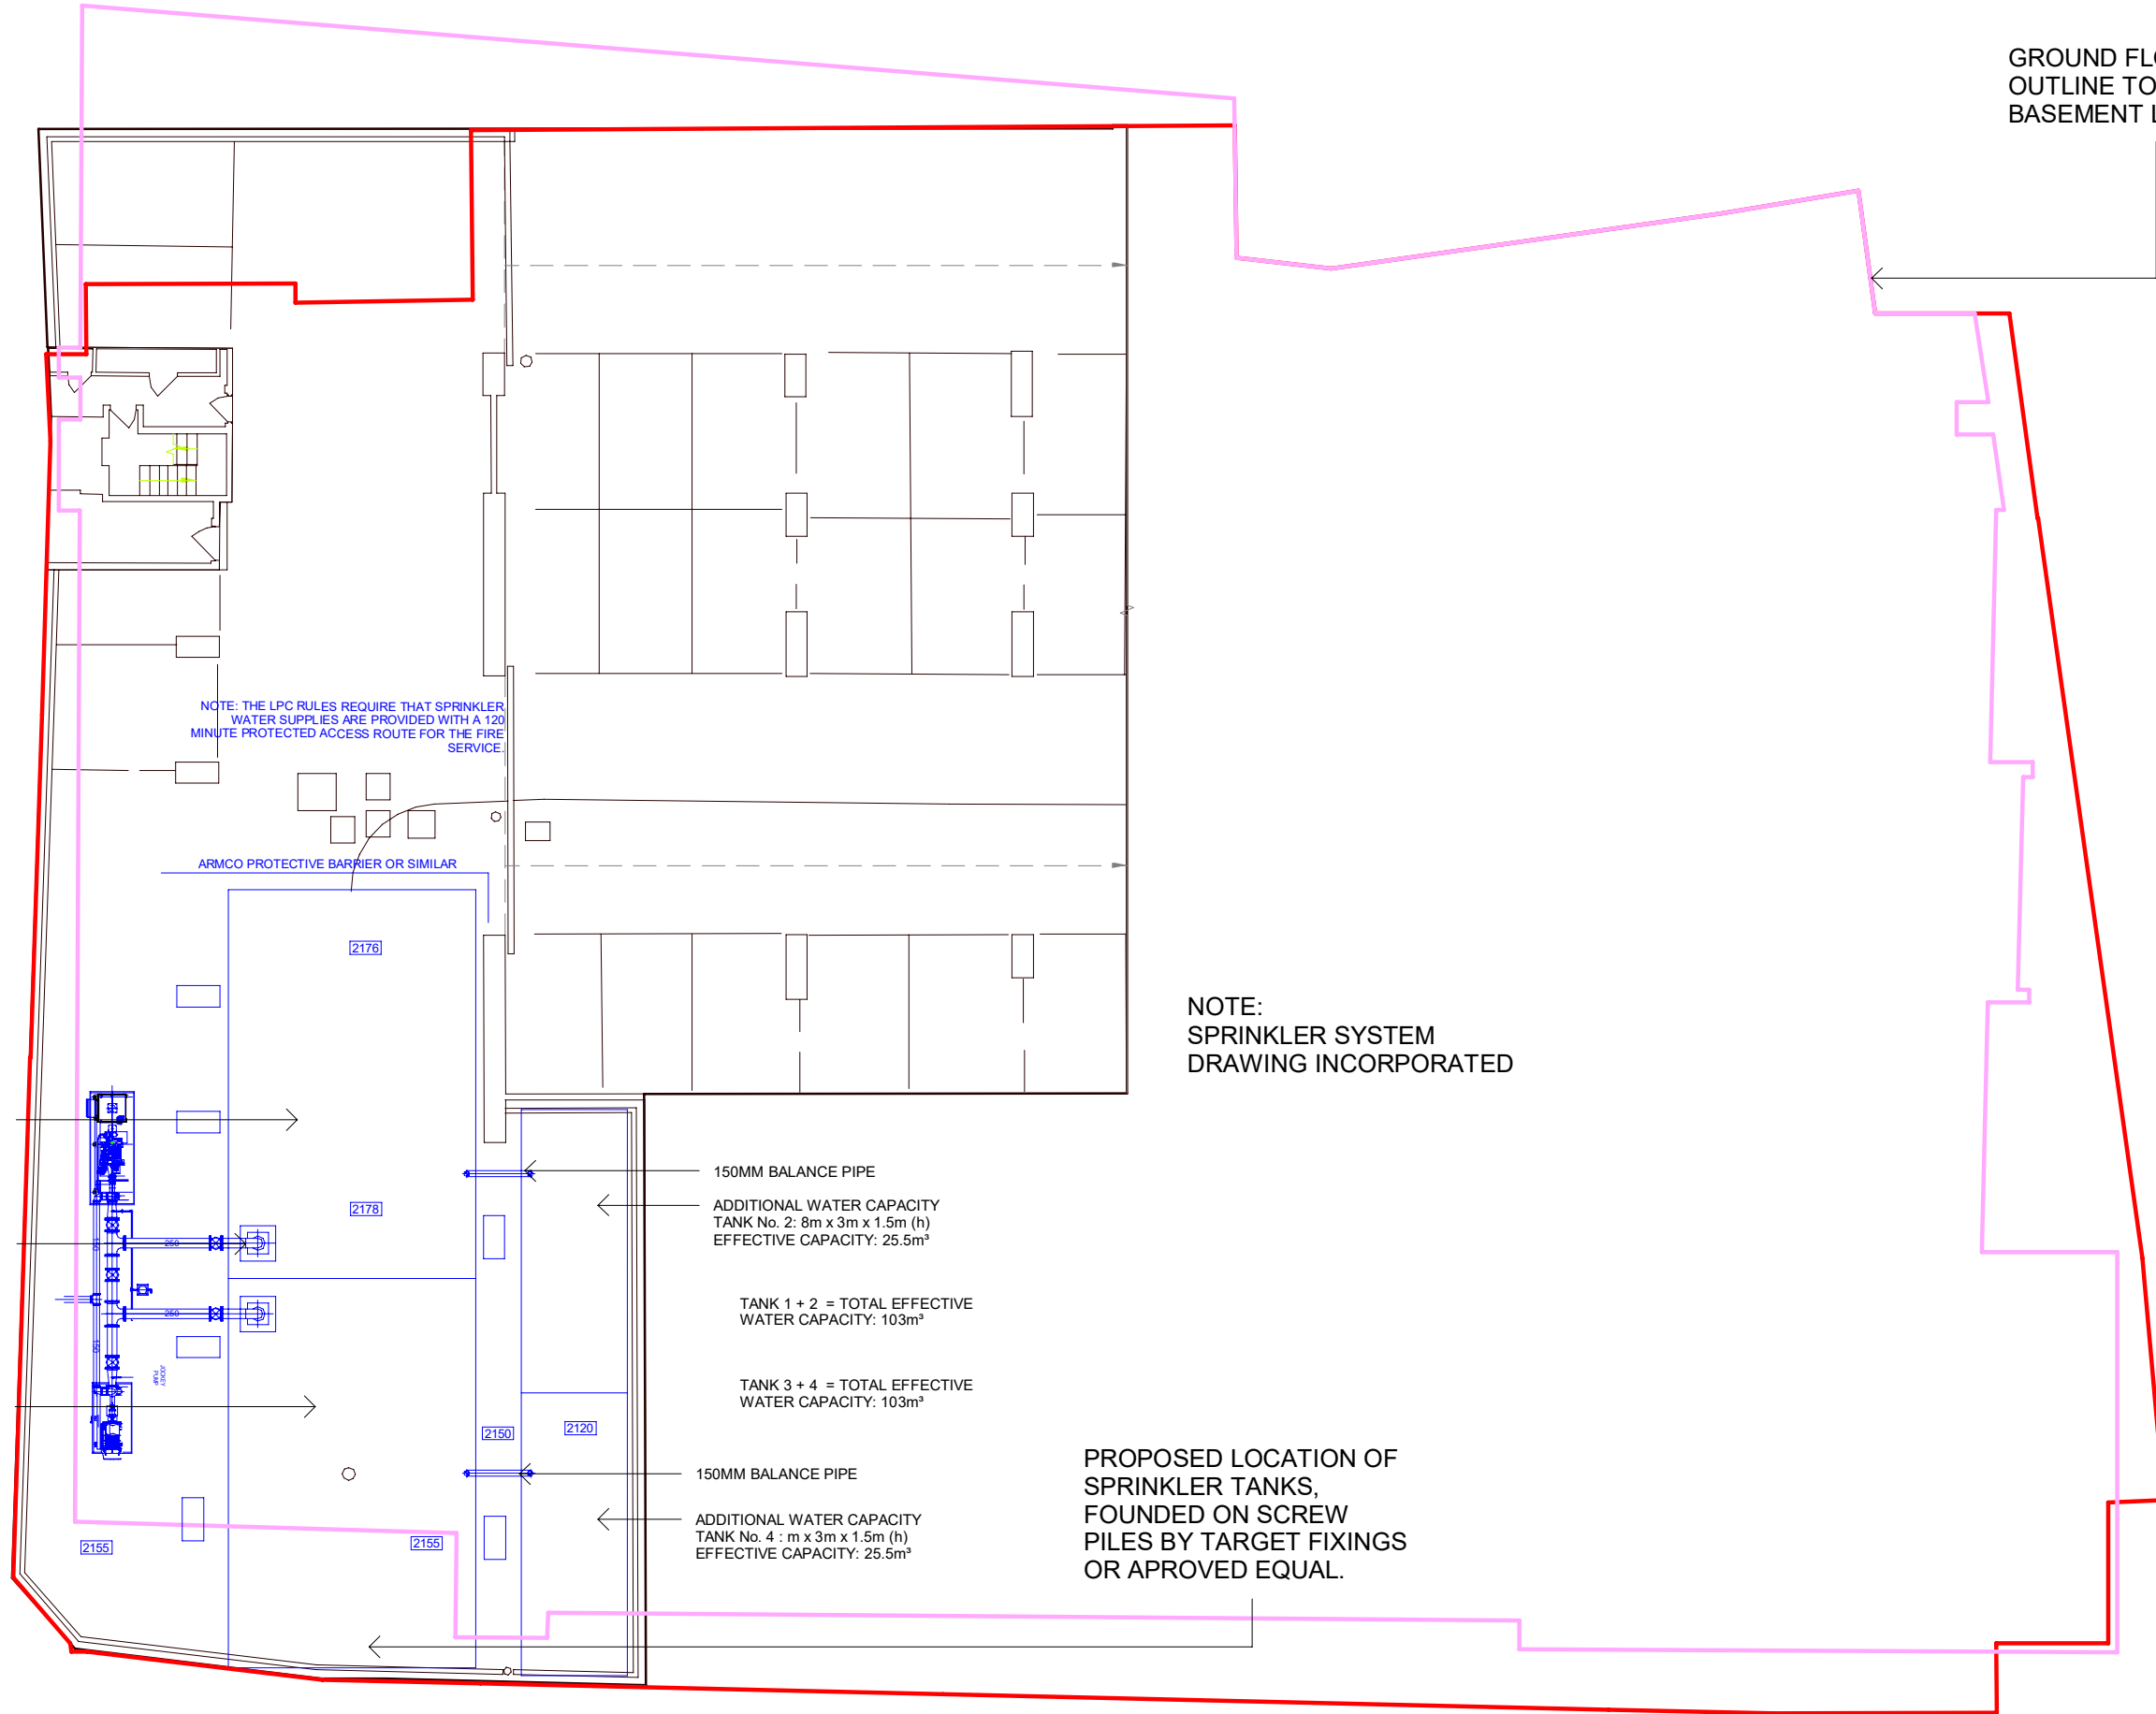

NOTE: THE LPC RULES REQUIRE THAT SPRINKLER WATER SUPPLIES ARE PROVIDED WITH A 120 MINUTE PROTECTED ACCESS ROUTE FOR THE FIRE SERVICE.

NOTE: SPRINKLER SYSTEM DRAWING INCORPORATED

PROPOSED LOCATION OF SPRINKLER TANKS, FOUNDED ON SCREW PILES BY TARGET FIXINGS OR APPROVED EQUAL.

SPRINKLER TANK No. 1
11m x 7m x 1.5m (h)
EFFECTIVE CAPACITY: 77.539m³

CONSIDER SUMP TO INCREASE TANK EFFECTIVE CAPACITY

SPRINKLER TANK No. 3
11m x 7m x 1.5m (h)
EFFECTIVE CAPACITY: 77.539m³

150MM BALANCE PIPE
ADDITIONAL WATER CAPACITY TANK No. 2: 8m x 3m x 1.5m (h) EFFECTIVE CAPACITY: 25.5m³

TANK 1 + 2 = TOTAL EFFECTIVE WATER CAPACITY: 103m³

TANK 3 + 4 = TOTAL EFFECTIVE WATER CAPACITY: 103m³

150MM BALANCE PIPE
ADDITIONAL WATER CAPACITY TANK No. 4 : m x 3m x 1.5m (h) EFFECTIVE CAPACITY: 25.5m³

Rev	Description	Date	Dm	Ckd
P2	NOTE AMENDMENT	10.02.25	TT	KR
P1	PLANNING ISSUE	31.01.25	TT	KR

Status
PLANNING



SMALLEY MARSEY RISPIN



Floor 10 The Exchange Station Parade Harrogate HG1 1TS
01423 707 757 admin@smrarchitects.co.uk

Project
NCP CAR PARK DRURY LANE, LONDON, WC2B 5NT

Client



Drawing Title
PROPOSED FLOOR PLAN- BASEMENT 6

Proj Ref	Origin	Zone	Level	Type	Role	Num	Status	Rev
7944 - SMR - 03 - ZZ - DR - A - 2013 - S3 - P2								

SMR Job Ref	Sheet	Scale	Drawn
7944-03-2013	A3	1 : 200	KR