


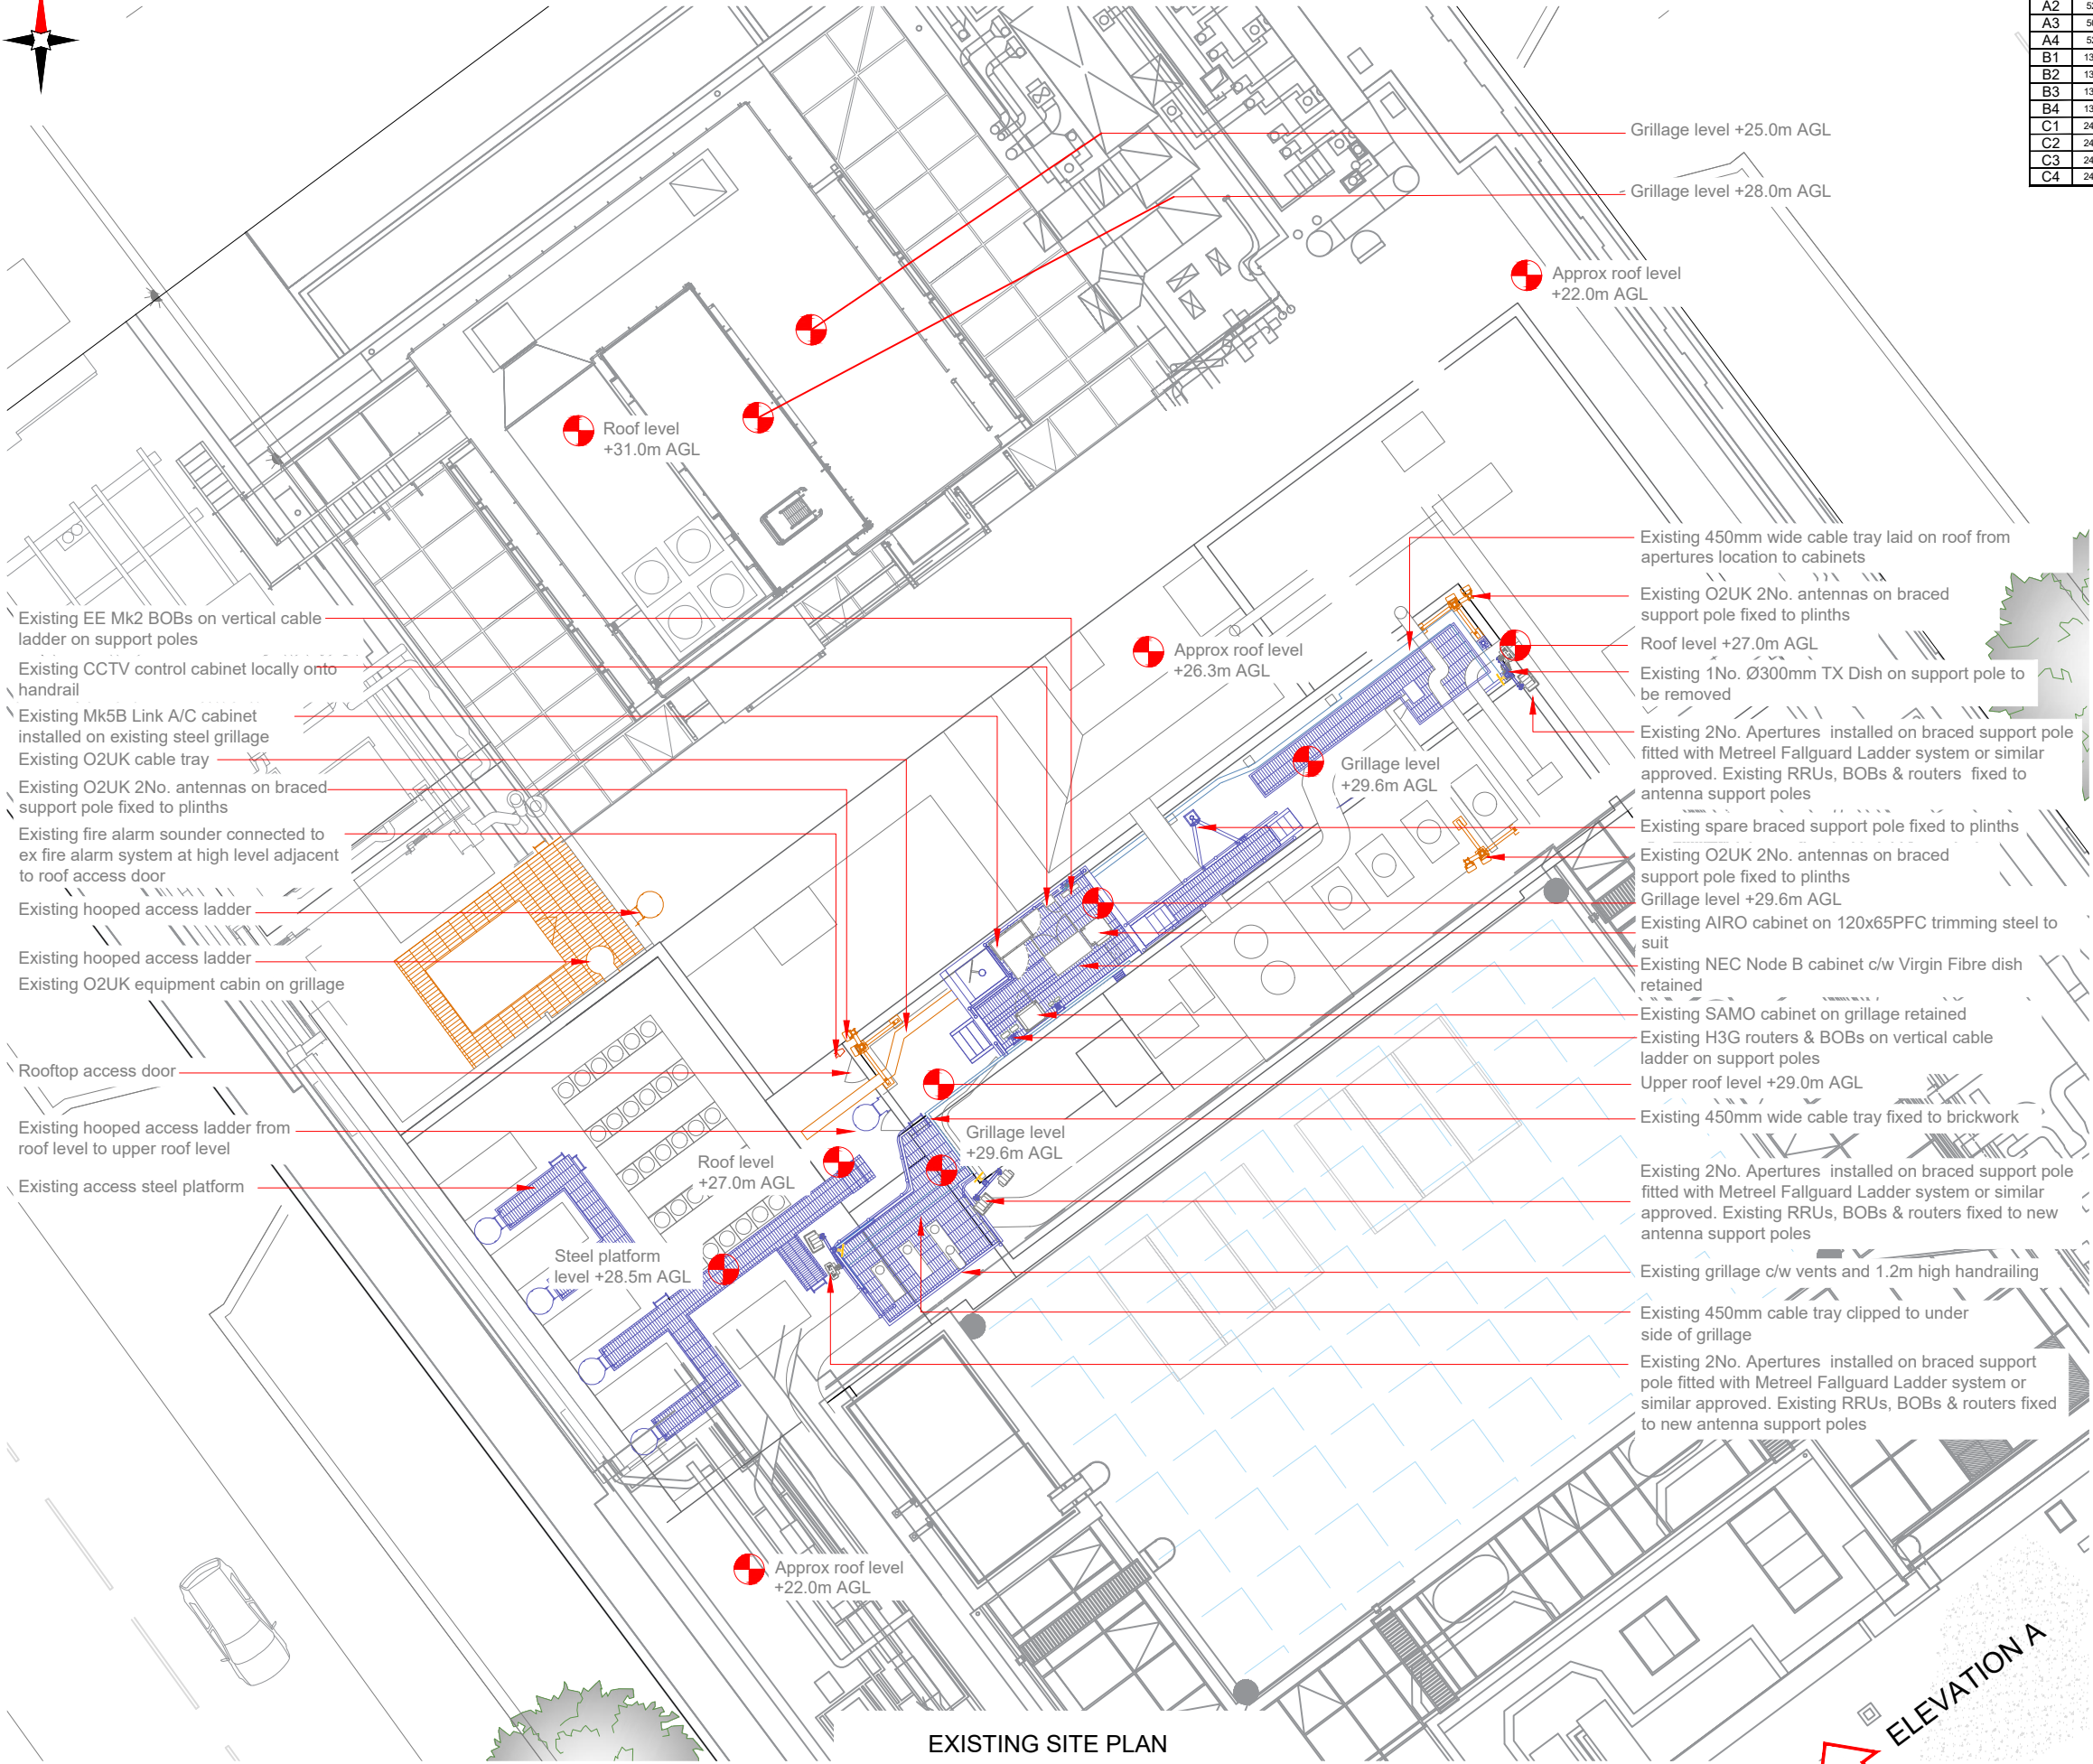

Antenna Aperture ID	Proposed Bearing	Operator/ Shared/ EE/H3G
A1	50°	EE
A2	52°	H3G
A3	50°	EE
A4	52°	H3G
B1	130°	EE
B2	130°	H3G
B3	130°	EE
B4	130°	H3G
C1	240°	EE
C2	240°	H3G
C3	240°	EE
C4	240°	H3G

Master:	MBNL / EE / H3G:	Project:	Purpose of Issue:	Issue:
M012	MBNL	L&S	Detailed Design	D4
Date:	28/04/24	Revision / Upgrade Description:		
Drawn:	I.S	Detailed Design		
Checked:	C.B			
Approved:	C.B			
Master:	MBNL / EE / H3G:	Project:	Purpose of Issue:	Issue:
M011	MBNL	L&S	Detailed Design	D3
Date:	14/09/23	Revision / Upgrade Description:		
Drawn:	I.S	Detailed Design		
Checked:	C.B			
Approved:	C.B			
Master:	MBNL / EE / H3G:	Project:	Purpose of Issue:	Issue:
M010	MBNL	L&S	Detailed Design	D2
Date:	29/08/23	Revision / Upgrade Description:		
Drawn:	I.S	Detailed Design		
Checked:	C.B			
Approved:	C.B			
Master:	MBNL / EE / H3G:	Project:	Purpose of Issue:	Issue:
M009	MBNL	L&S	Detailed Design	D1
Date:	02/06/23	Revision / Upgrade Description:		
Drawn:	I.S	Detailed Design		
Checked:	C.B			
Approved:	C.B			
Master:	MBNL / EE / H3G:	Project:	Purpose of Issue:	Issue:
M008	MBNL	L&S	General Arrangement	D
Date:	24/11/22	Revision / Upgrade Description:		
Drawn:	E. Drysdale	Rejection Comments Amended		
Checked:	L. B-Smith			
Approved:	L. B-Smith			



Hutchison 3G UK Limited
Star House, 20 Greenfield Road
Maidenhead, SL6 1EH
Tel: 01628 765 000
Fax: 01628 765 001

H3G Base Station Information Line:
0845 6043000
Available 9am-5pm Monday to Friday



Hartfield Business Park
Hartfield
Hertfordshire
AL10 9BW

Tel: 01707 315000
Fax: 01707 319001



Mobile Broadband Network Limited
Sixth Floor, Thames Tower, Station Road, Reading, RG1 1LX



Unit 27F-G
Hartlebury Trading Estate
Crown Lane
Hartlebury
Worcestershire
DY10 4JD

Site Name:	HYG & TROPICAL MED		
Site ID:	1109521		
Address:	HYGIENE & TROPICAL MEDICINE 1 KEPPEL STREET LONDON WC1E 7HT		
Title:	100 EXISTING SITE PLAN		
Project:	LIFT & SHIFT		
Purpose of Issue:	DETAILED DESIGN		
EE Cell ID:	27469	MBNL Cell ID:	CMN069
3UK Cell ID:	WC0004		
Master Drawing No:	1109521_CMN069_27469_WC0004_M012		Issue:
			D4