

Drawing Frame A1


Notes:

- Copyright: The contents of this drawing may not be reproduced in whole or in part without the written consent of Robinson Kenning & Gallagher.
- All dimensions to be checked on site by Contractor.
- Where discrepancy occurs between specification and drawings then Robinson Kenning & Gallagher must be notified immediately.


The contractor is to check and verify all building and site dimensions plus levels before work commences.
DO NOT SCALE THIS DRAWING - CHECK ALL DIMENSIONS ON SITE

DATUM : GNSS
SYSTEM REF : OSGB36 + ODN Height


ABBREVIATIONS & LEGEND:		
LEVELS & HEIGHTS CL - COVER LEVEL IL - INVERT LEVEL L - LEVEL H - HEIGHT BM - BEAM CE - CEILING J - JOISTS RA - RAFTERS E - EAVES FR - FLAT ROOF F - FANPET F - FENCE UR - UNDERSIDE OF R - RIDGE SL - SLAB T - TREE HH - HEAD HEIGHT OH - OPENING HEIGHT SH - SILL HEIGHT	GENERAL NOTES AB - ADVERTISING BOARD AC - AIR CONDITIONING UNIT AHU - AIR HANDLING UNIT AP - AIRTRIGGER ALARM PANEL ASP - ASPHALT B - BOLLARD BA - BARRIER BE - BENCH BS - BUS STOP BKA - BOLLARD BXO - BOXING OUT CH - CEILING ACCESS HATCH CHY - CHIMNEY CWD - CURB WALL DW - DWARF WALL DK - DROP KERB EDN - E DISTRIBUTION BOARD EG - EXTRACT GRILLE EM - ELECTRIC METER FP - FIRE PLACE FU - FLUE FAP - FIRE ALARM PANEL GR - GRASS GU - GUARDRAIL GM - GAS METER HWC - HOT WATER CYLINDER LAH - LOFT ACCESS HATCH LB - LITTER BIN LP - LAMP POST PE - PELICOLA PC - PELICAN CROSSING RS - PAVING SLABS PL - PAVEMENT LIGHT PB - POST BOX PW - PERIMETER WALL RG - RAILING RS - ROAD SIGN SB - SPEED BUMP SG - SIGNAGE SN - STREET NAME SIGN TB - TELEPHONE BOX TL - TRAFFIC LIGHT TM - TICKET MACHINE TP - TELEGRAPH POLE VE - VEGETATION W - WATER WD - WARDROBE WH - WATER HEATER ZC - ZEBRA CROSSING	TYPICAL DRAWING SYMBOLS SPOT LEVEL / SPOT HEIGHT SURVEY STATION SURVEY HEIGHT GATE / DOOR TREE VEGETATION TOILET / URINAL SINKS GAS HOB BATH SHOWER BIDET AC VENTILATION LIGHTS SPEAKER SMOKE DETECTOR MOTION SENSOR CCTV CAMERA FLOOR SOCKET BOX WIFI EXTENDER FIRE ALARM SIREN FIRE SPRINKLER FIRE MANUAL CALL POINT RADIATOR / AC UNIT

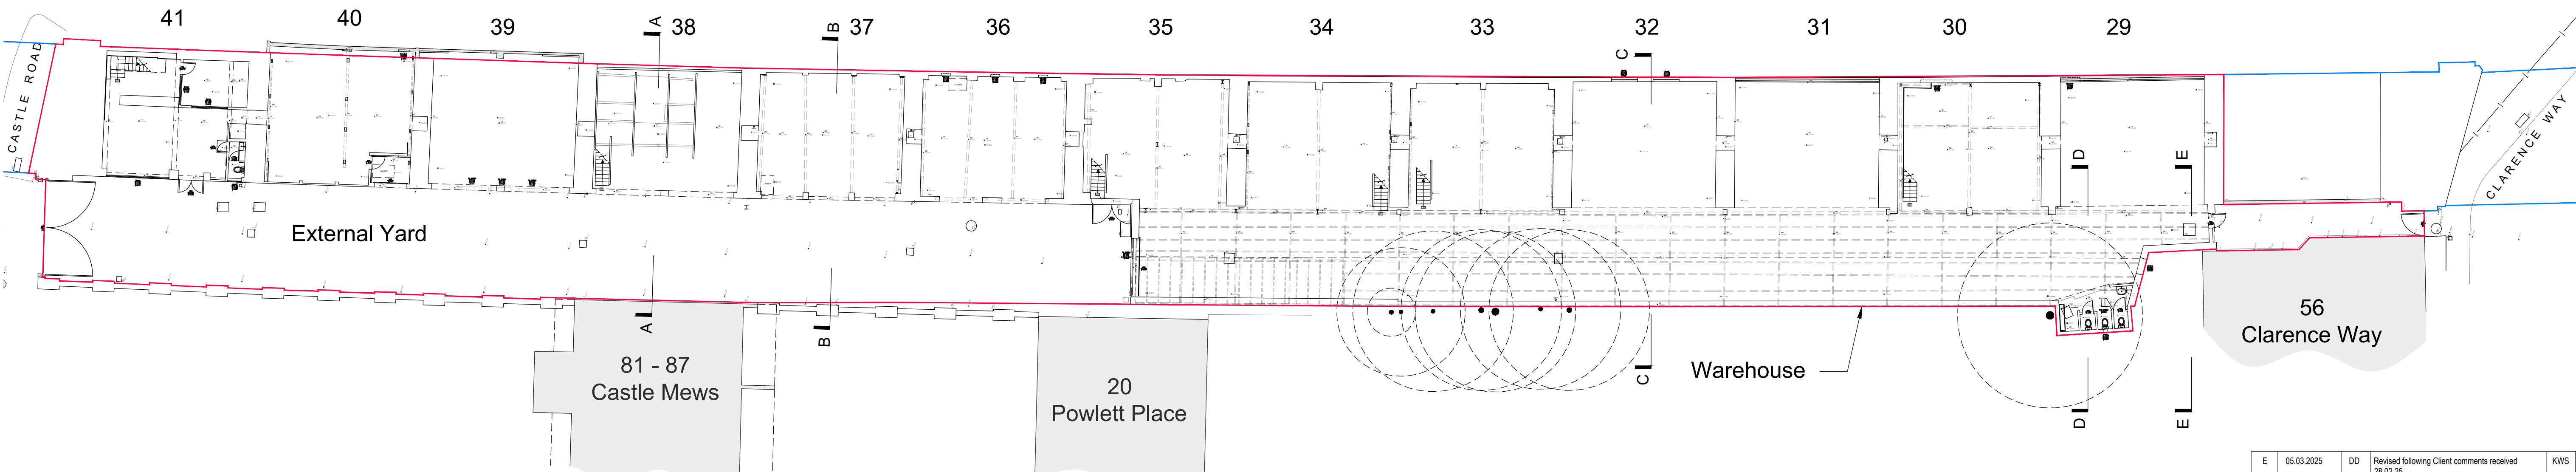

01 Existing Ground Floor Plan
Scale 1 : 200

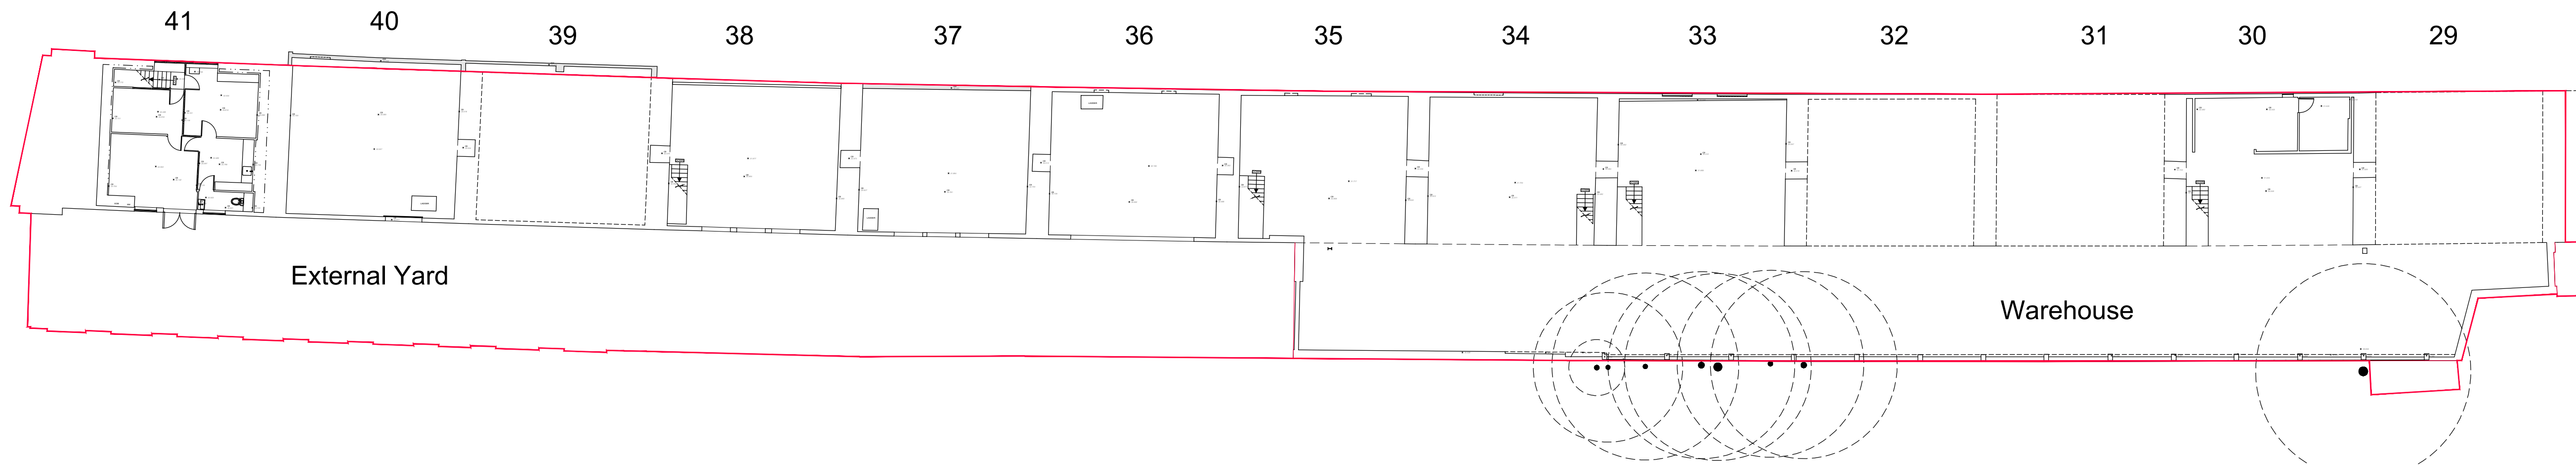

02 Existing First Floor Mezzanine Plan
Scale 1 : 200

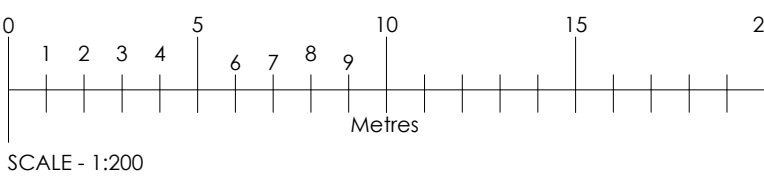

E	05.03.2025	DD	Revised following Client comments received 28.02.25	KWS	KWS
D	24.01.2025	DD	Application Site Boundary Revised	KWS	KWS
C	20.08.2024	DD	Additional section references added.	KWS	KWS
B	10.07.2024	DD	Revised in accordance with comments	KWS	KWS
A	04.07.24	DD	Revised following Client Comments	-	-
REV	DATE	BY		CHK	ATHD

DRAWING STATUS:	PLANNING
-----------------	----------

Robinson Kenning & Gallagher
Architects & Surveyors
Airport House, Purley Way, Croydon, Surrey, CR0 0XZ
T: 020 8684 8125 E: info@rkpartnership.co.uk W: www.rkpartnership.co.uk

CLIENT:
THE ARCH CO

PROJECT:
Arches 29-41 Castle Mews
Castle Road, London NW1 8SY

TITLE:
Existing Floor Plans

SCALE @ A1: 1:200	CHECKED: KWS	APPROVED: KWS
CAD FILE: 1228 EXISTING.rvt	DESIGN DRAWN: DPD	DATE: 24/06/2024
PROJECT No: 4758	DRAWING No: 23-4758-PD-002	REV: E