
 


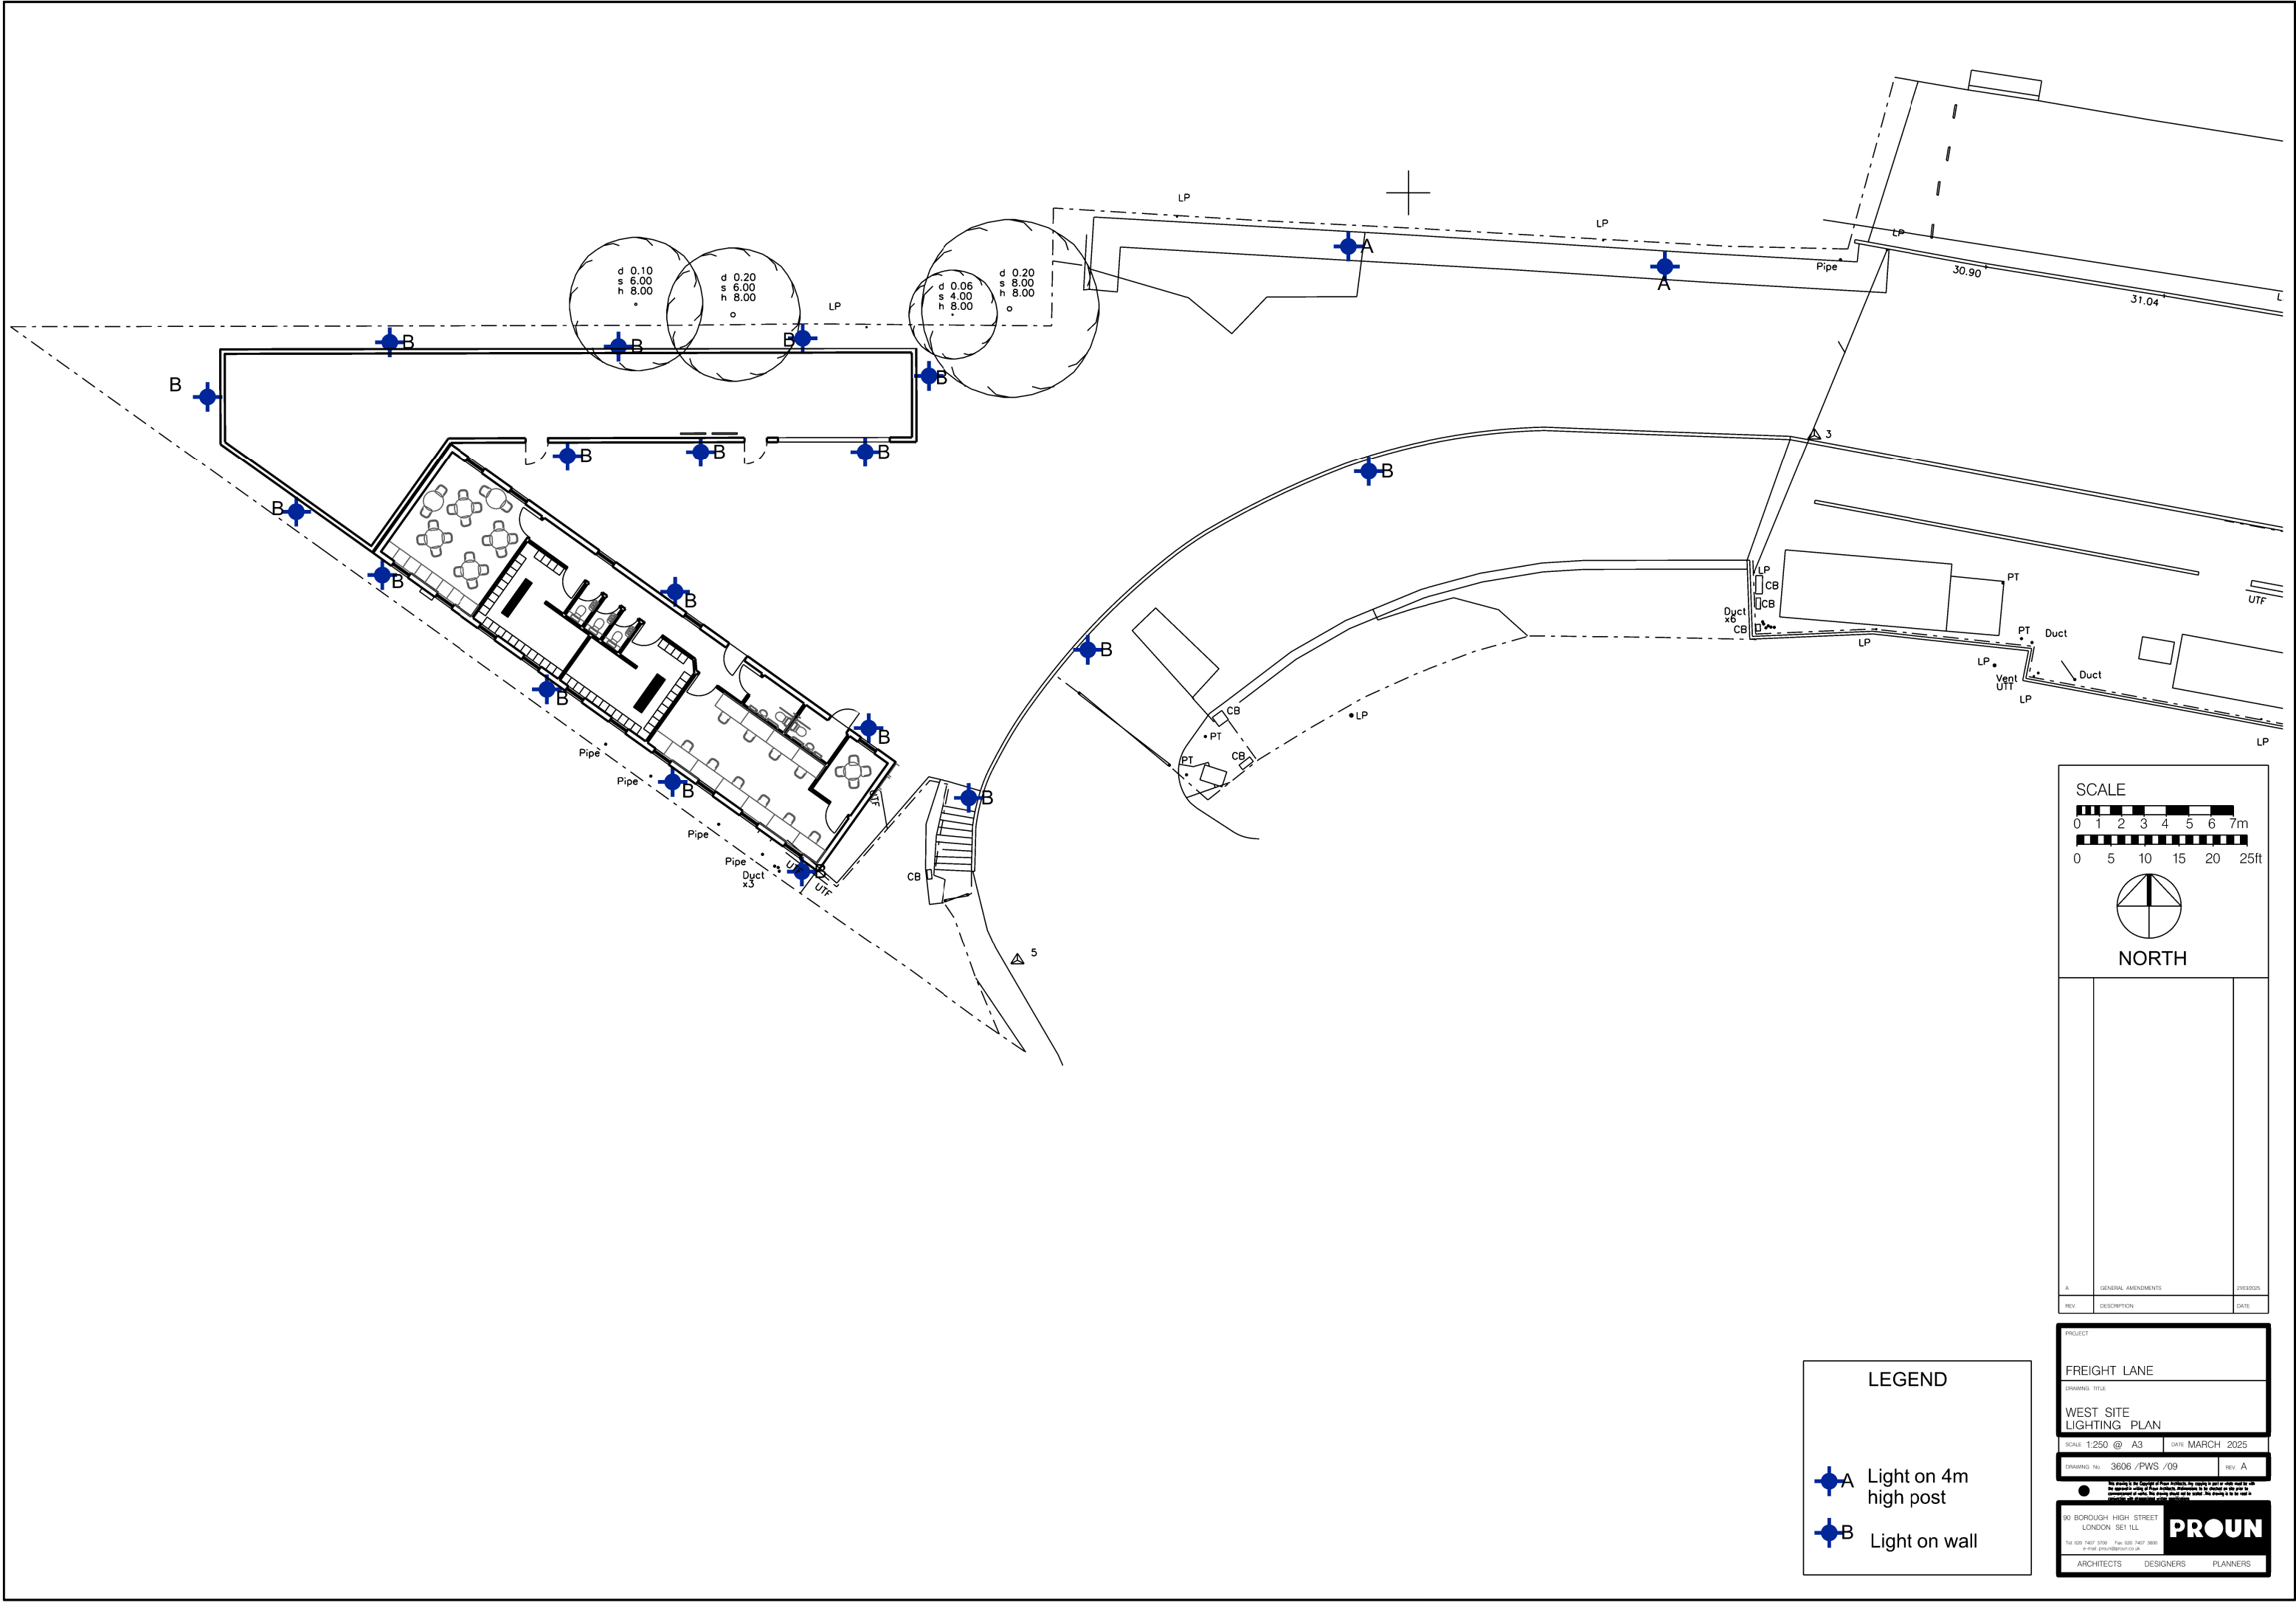

SCALE



NORTH

A		
GENERAL AMENDMENTS		
21/03/2025		
REV	DESCRIPTION	DATE

LEGEND

- Light on 4m high post
- Light on wall

PROJECT

FREIGHT LANE

DRAWING TITLE

WEST SITE LIGHTING PLAN

SCALE: 1:250 @ A3 DATE: MARCH 2025

DRAWING No: 3606 /PWS /09 REV: A

80 BOROUGH HIGH STREET LONDON SE1 1LL

Tel: 020 7407 3700 Fax: 020 7407 3800 e-mail: proun@proun.co.uk

ARCHITECTS DESIGNERS PLANNERS

PROUN