


1 PBSA Level 1 Floor Plan

1 : 100

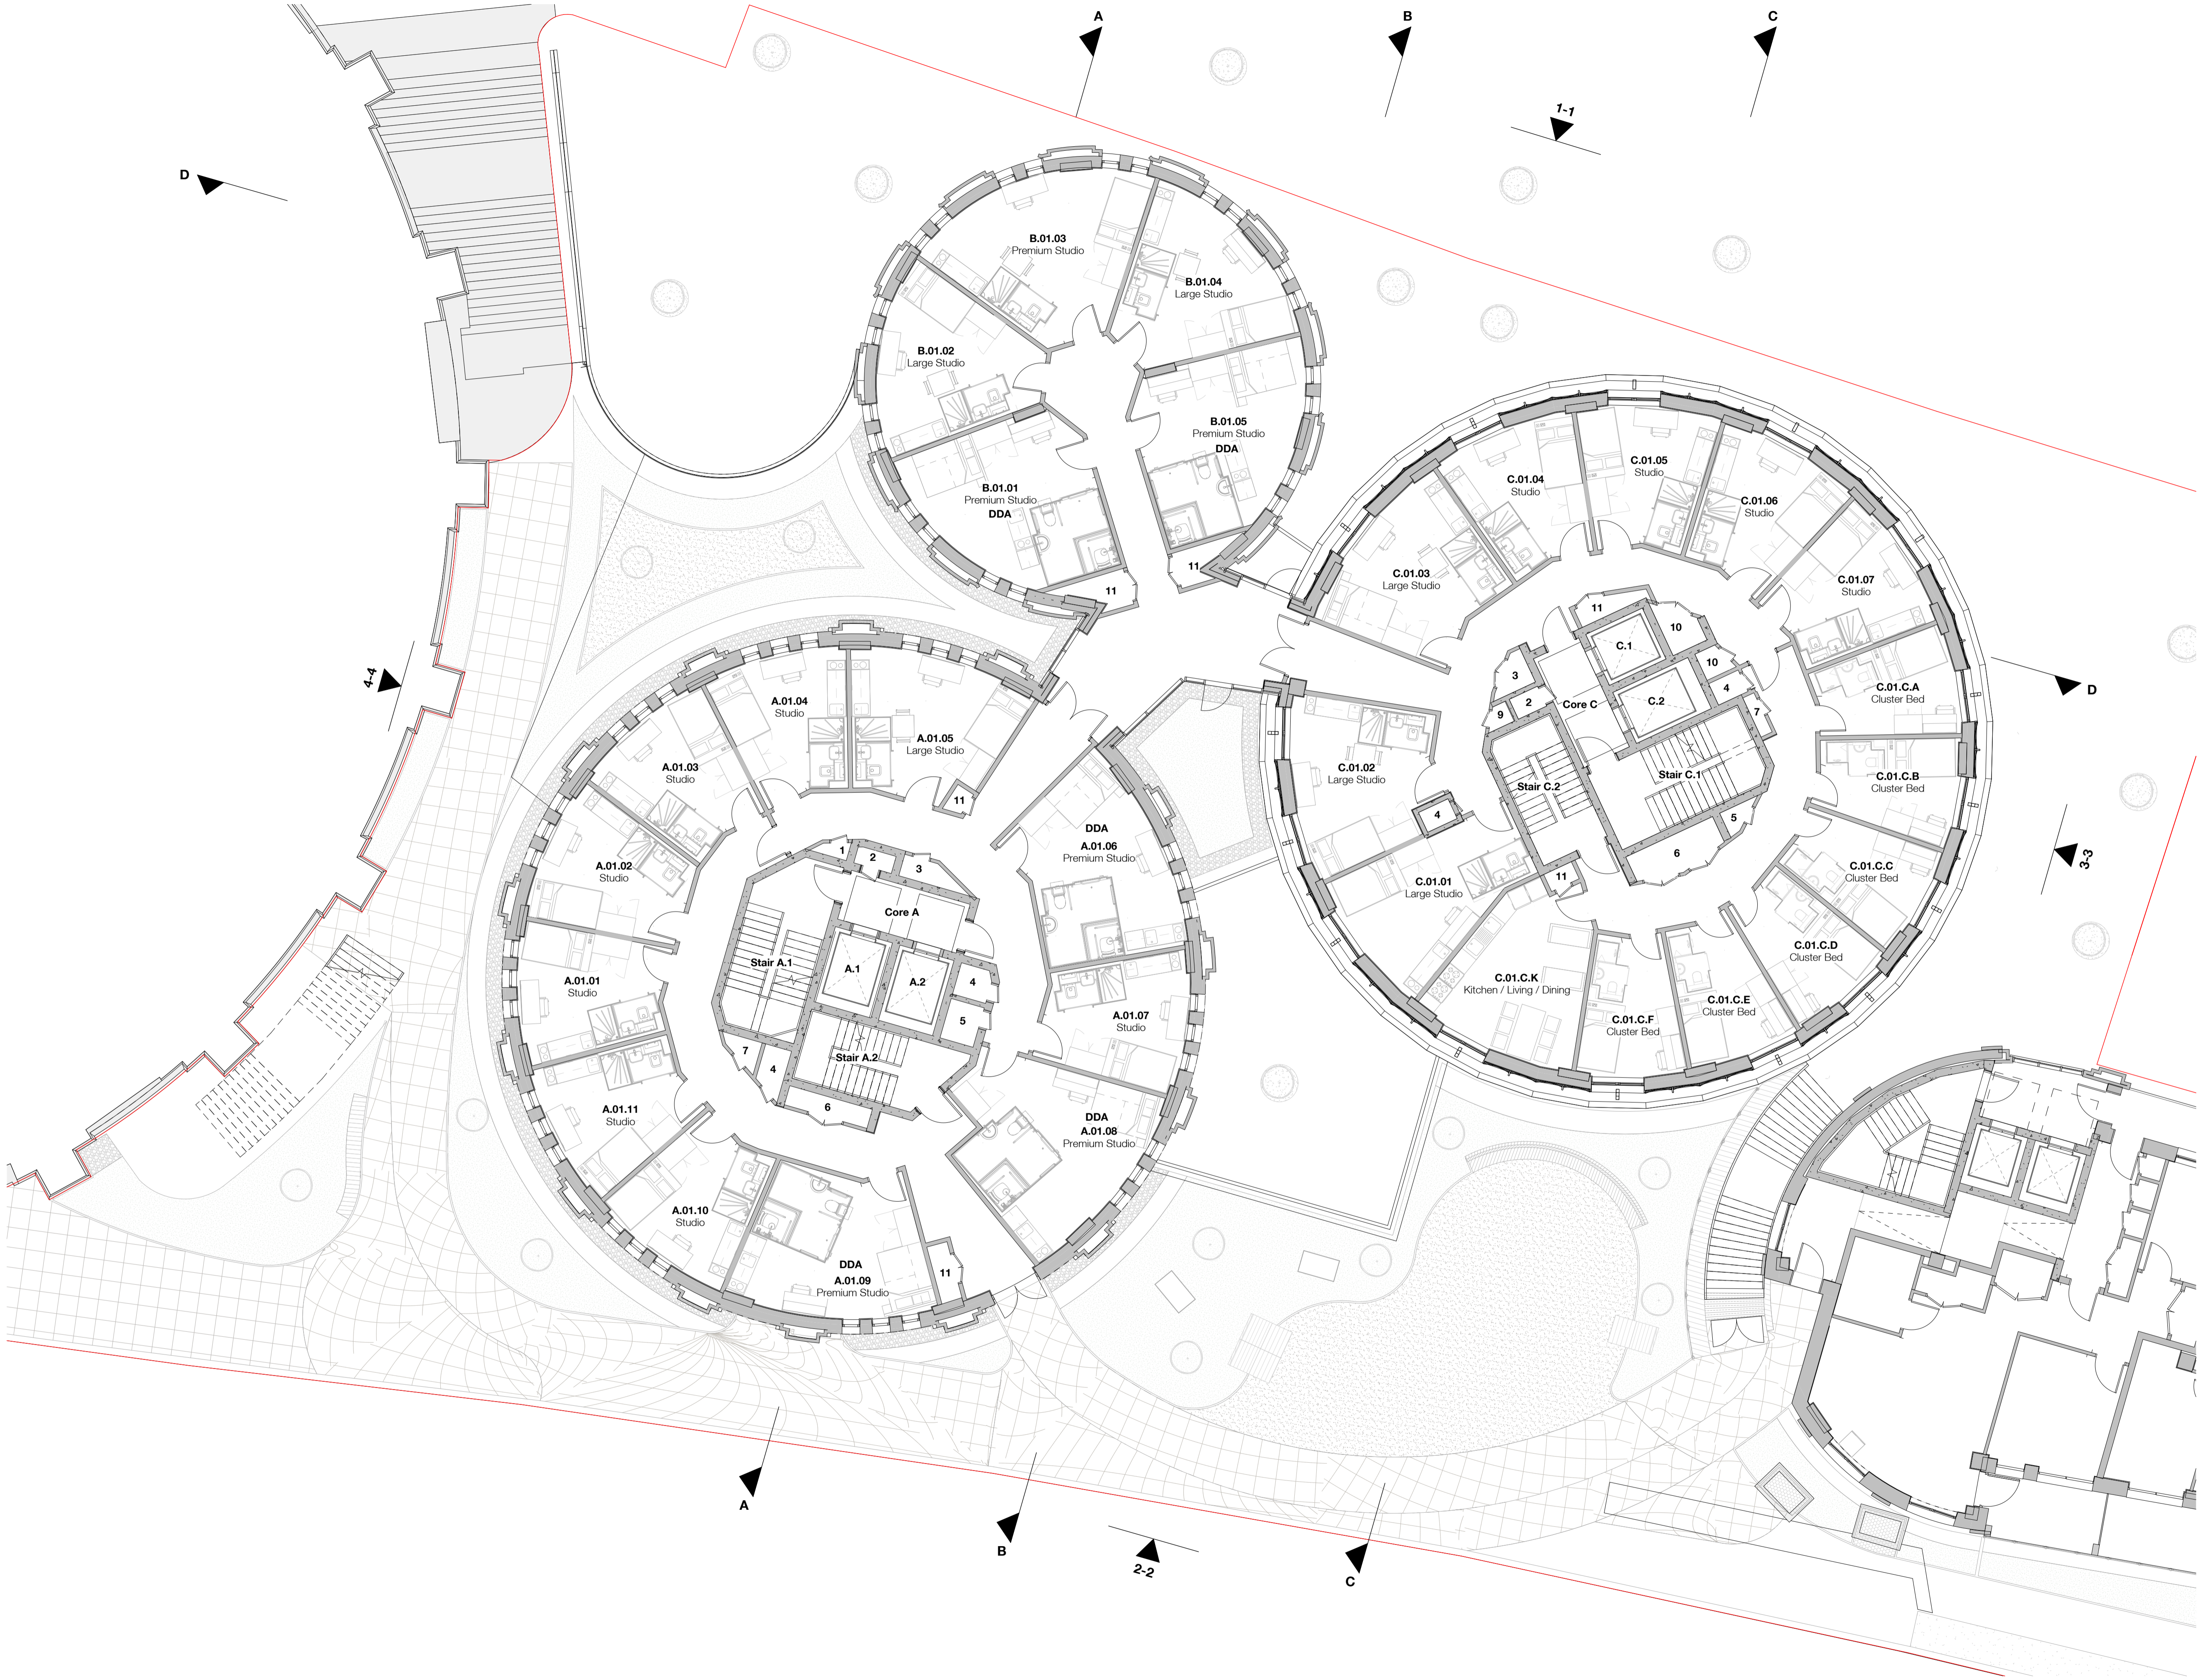

The use of this data by the recipient acts as an agreement of the following statements:  
Do not use this data if you do not agree with any of the following statements:



Ryder Architecture has co-ordinated relevant information received from third parties, but are not responsible for the content of the information received from others.

The controlled version of this drawing should be viewed in DWG or PDF format not DWG or other formats. All prints of this drawing must be made in full colour.

Where this drawing has been based upon Ordnance Survey data, it has been reproduced under the terms of Ryder Licence No. 100000144. Reproduction of this drawing in whole or in part is prohibited without the prior permission of Ordnance Survey.

Do not scale the drawing. Use figured dimensions in all cases. Check all dimensions on site. Report any discrepancies in writing to Ryder before proceeding.

 Scale 1:100 (m)

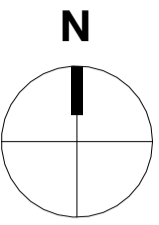

Legend:

Site Boundary

PFS Planning Consented Scheme  
Ref: 2022/3646/P

Riser Legend:

- 1 - Generator Flue
- 2 - Smoke Shaft (Inlet)
- 3 - Heating Riser
- 4 - Smoke Shaft (Outlet)
- 5 - Fire / Coms Riser
- 6 - Electrical Riser
- 7 - Water Riser
- 8 - Basement Extract and Smoke Clearance
- 9 - VRF Riser
- 10 - Commercial Flue
- 11 - MVHR Cupboards

P3	Updates for NMA	JHU	AWH	01/04/25
P2	Issued for NMA approval	ZTS	AWH	19/03/25
P1	First Issue	JHAY	JHU	02/12/24

Rev	Description	Drawn	Checked	Date
-----	-------------	-------	---------	------

Suitability  
For Information

Project  
Regal Chalk Farm Limited  
Chalk Farm Road  
100-100A Chalk Farm Road, London, NW1 8EH

Drawing Title

PBSA Level 1 Floor Plan\_Proposed

Drawing Number  
356\_P20.131

Project Number	Scale at A1	Status	Revision
11464-00	1 : 100	S2	P3

info@ryderarchitecture.com  
www.ryderarchitecture.com

Ryder