


AC POSITION INTEGRATED IN WARDROBE - JOINERY TO BE ADAPTED ACCORDINGLY  
CONDENSER POSITION INTEGRATED IN WARDROBE - JOINERY TO BE ADAPTED ACCORDINGLY

LOWER GROUND FLOOR PLAN

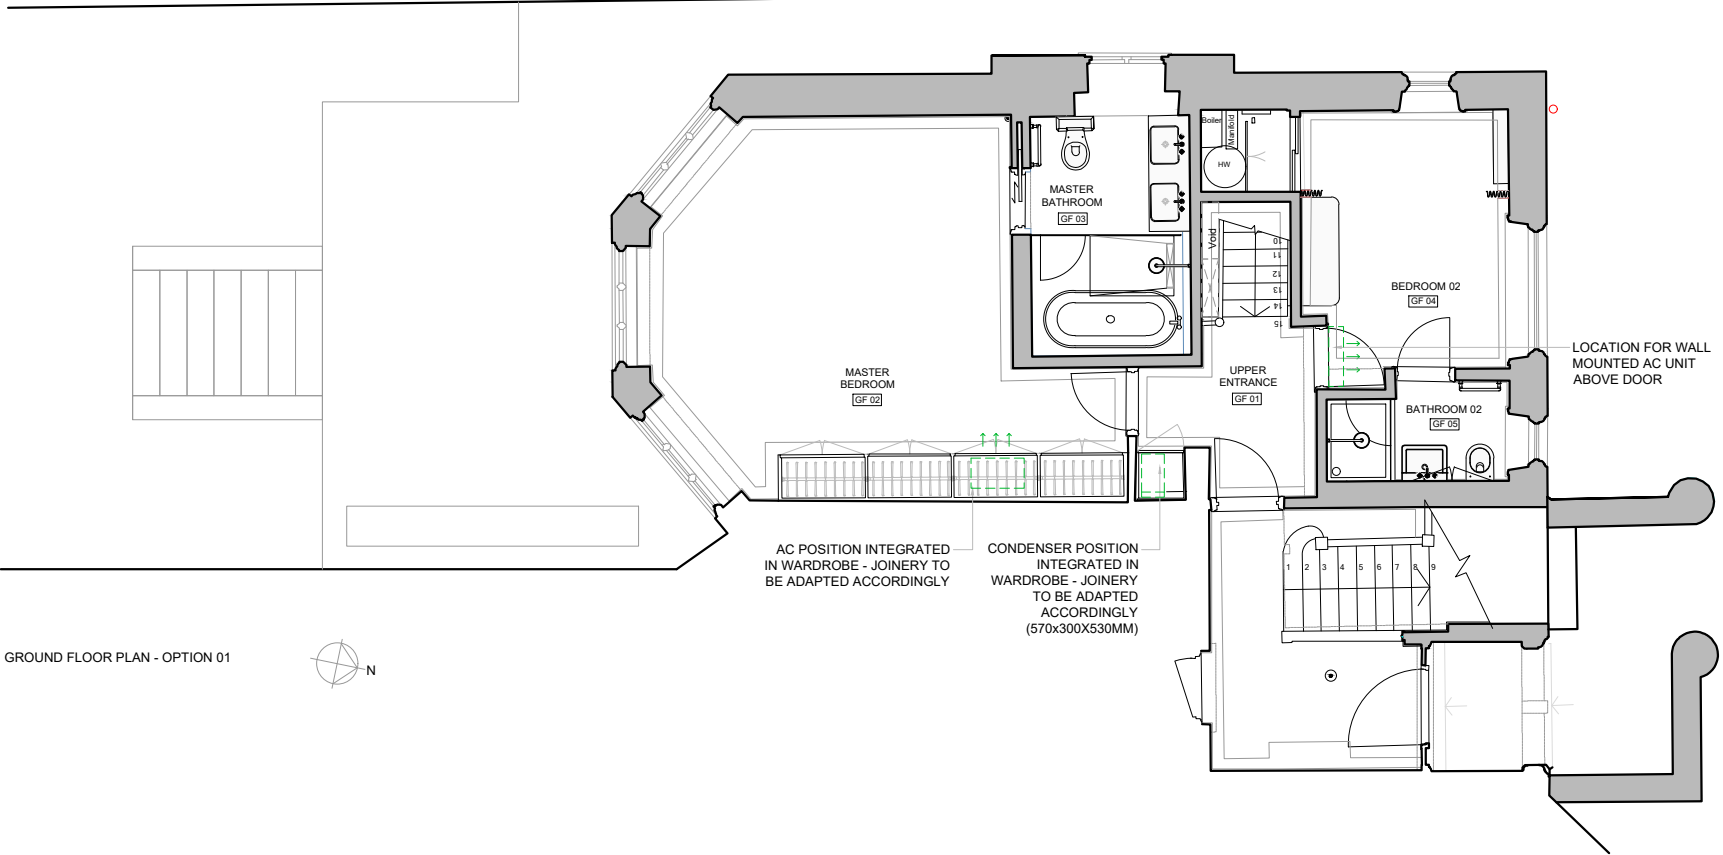

AC POSITION INTEGRATED IN WARDROBE - JOINERY TO BE ADAPTED ACCORDINGLY

CONDENSER POSITION INTEGRATED IN WARDROBE - JOINERY TO BE ADAPTED ACCORDINGLY (570x300x530MM)

LOCATION FOR WALL MOUNTED AC UNIT ABOVE DOOR

GROUND FLOOR PLAN - OPTION 01



A - 24.11.05 - RL - ISSUED FOR PLANNING

HAZEL COLLINS DESIGN  
x  
STUDIO VIRIDIANA  
INTERIOR ARCHITECTURE & DESIGN  
WWW.STUDIOVIRIDIANA.COM - WWW.HAZELCOLLINS.COM  
84 BAYNES MEWS, NW3 5BH

# GENERAL ARRANGEMENT - AC

ETON AVENUE, LONDON

PROJECT	ETON AVENUE
TITLE	GENERAL ARRANGEMENT
DWN BY	RL
DATE	24/09/27
SCALE	1:50 @ A1 / 1:100@A3
DWG. No	EA/GA/AC/01
REV.	A

All dimensions in mm unless otherwise noted. All dimensions to be checked on site. Drawing not to be scaled. PDF copies to be printed at actual size. All drawings are design intent and not valid for construction/fabrication. All discrepancies to be reported to the designer.