

DO NOT SCALE


THE CONTRACTOR IS TO CHECK AND VERIFY ALL BUILDING AND SITE DIMENSIONS, LEVELS AND SEWER INVERT LEVELS AT CONNECTION POINTS BEFORE WORK STARTS.

THIS DRAWING IS TO BE READ AND CHECKED IN CONJUNCTION WITH ENGINEERS AND OTHER SPECIALIST DRAWINGS.


THE DRAWING AND THE WORKS DEPICTED ARE THE COPYRIGHT OF REED WATTS ARCHITECTS AND MAY NOT BE REPRODUCED EXCEPT BY WRITTEN PERMISSION.

KEY:

 SCOPE OF DEMOLITION

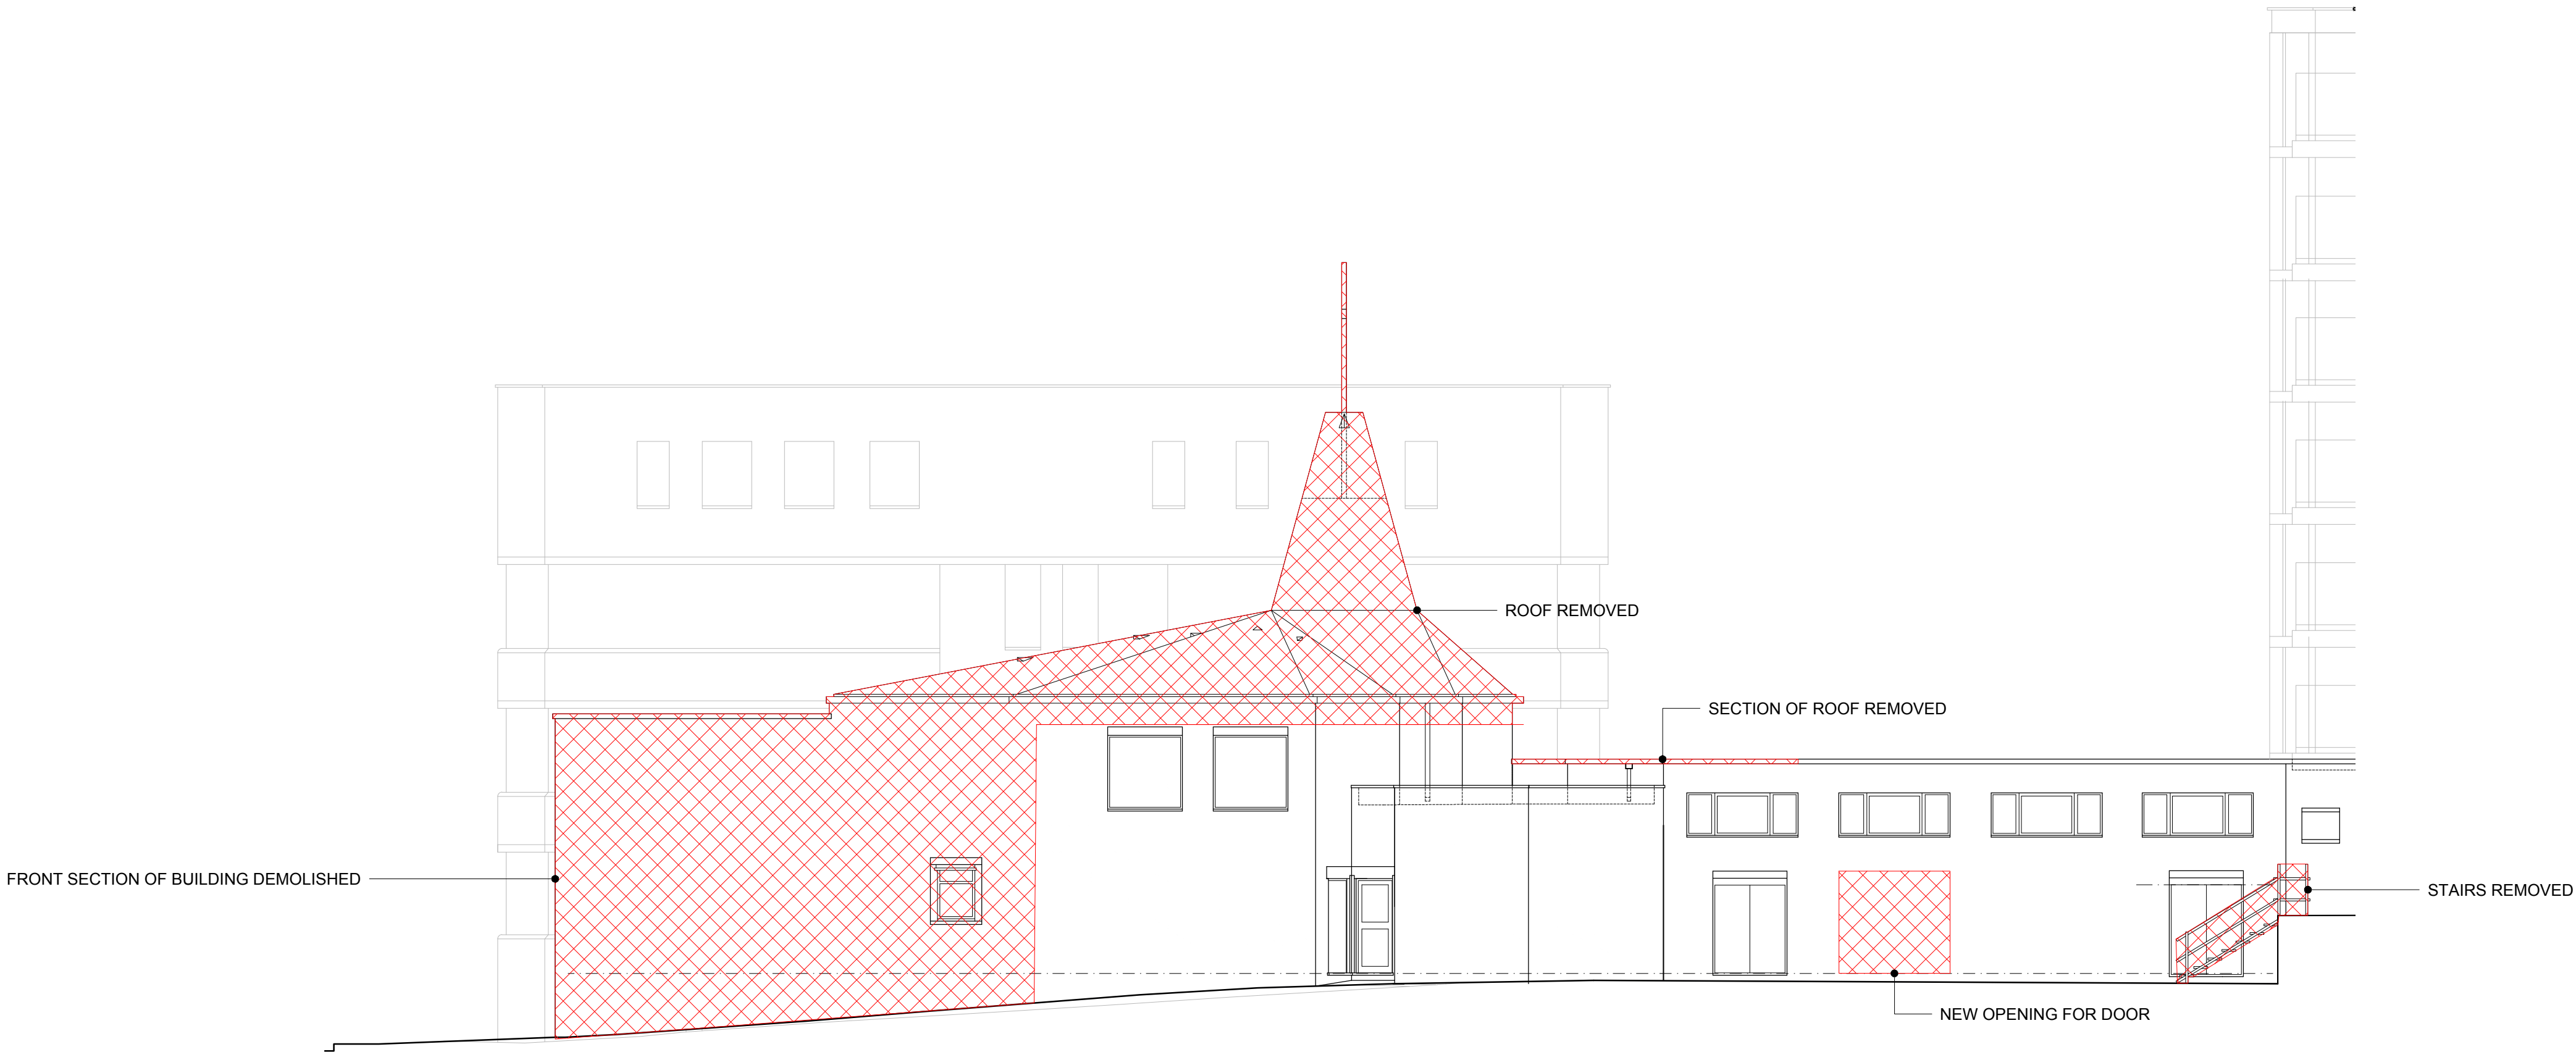

NORTH ELEVATION

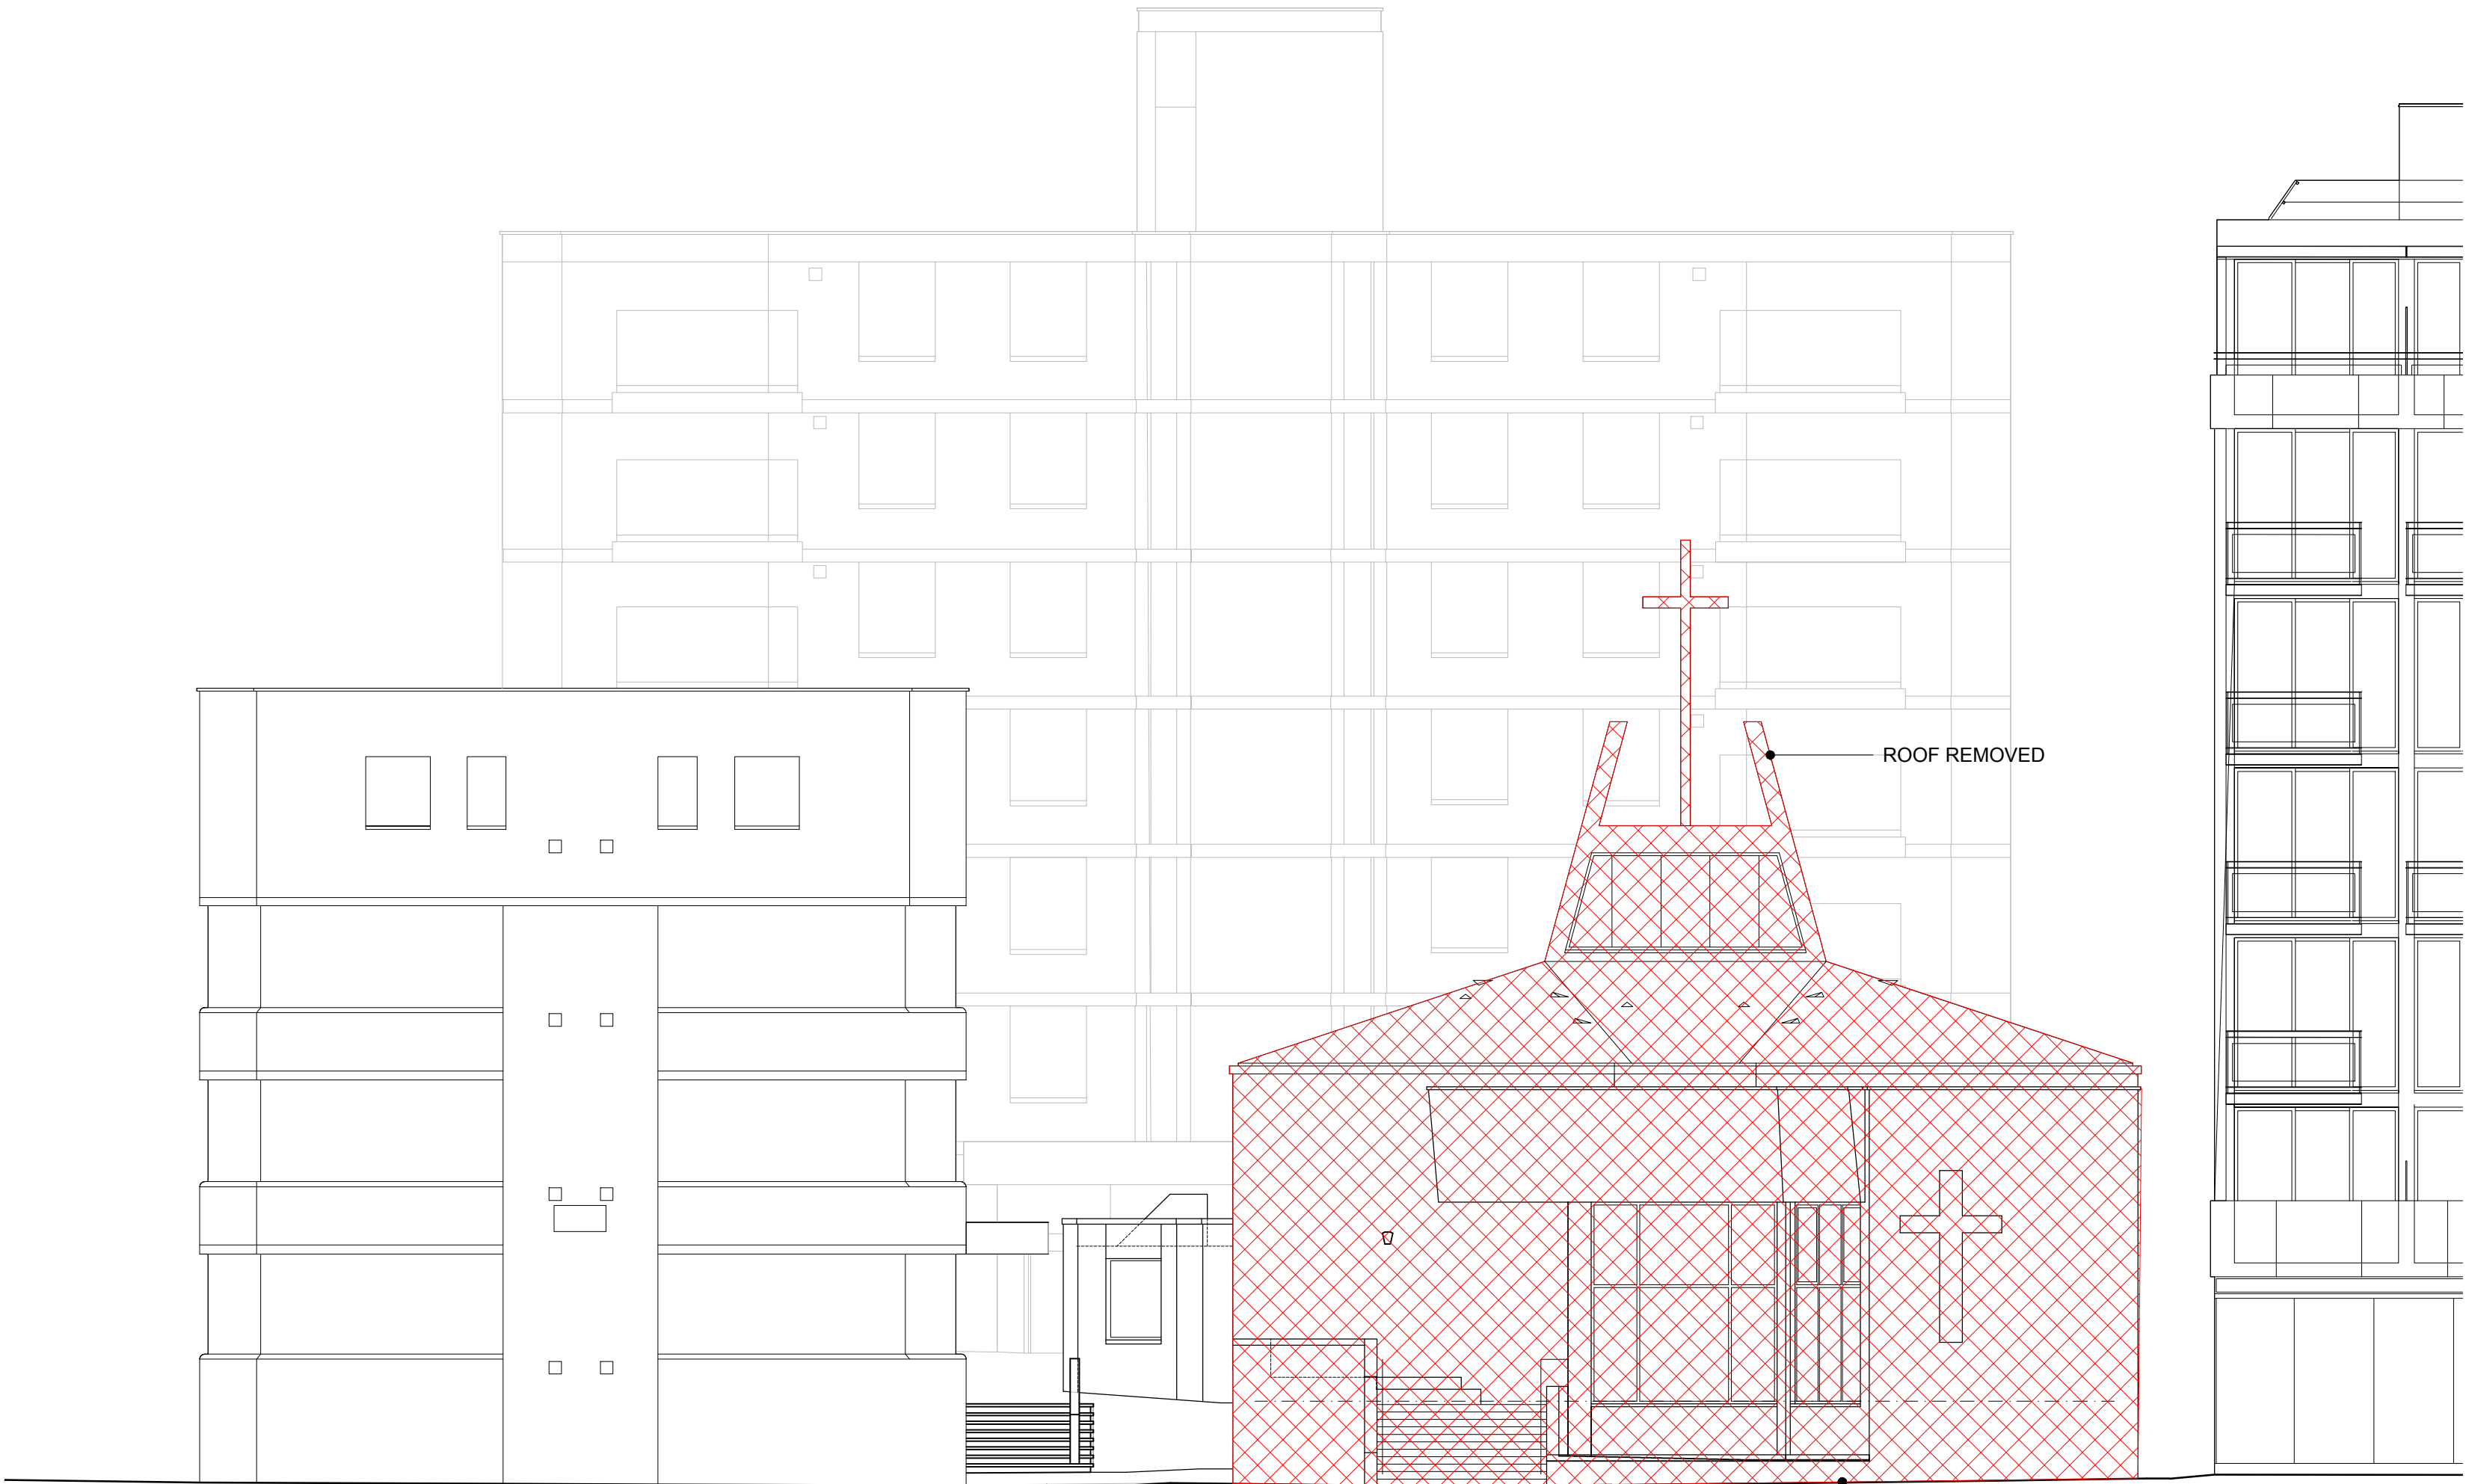

WEST ELEVATION

0 1 2 5m

01 07.06.24 STAGE 1 ISSUE FOR COSTING

REV DATE DESCRIPTION

REED
WATTS

www.reedwatts.com
studio@reedwatts.com

PROJECT 2401 LIGHTHOUSE LONDON CHURCH

DRAWING

EXISTING ELEVATIONS 1

DRAWING NO 2401(0)030 REVISION 01

SCALE 1:100 @ A1 1:200 @ A3 DATE 20.05.24

STATUS
PRELIMINARY