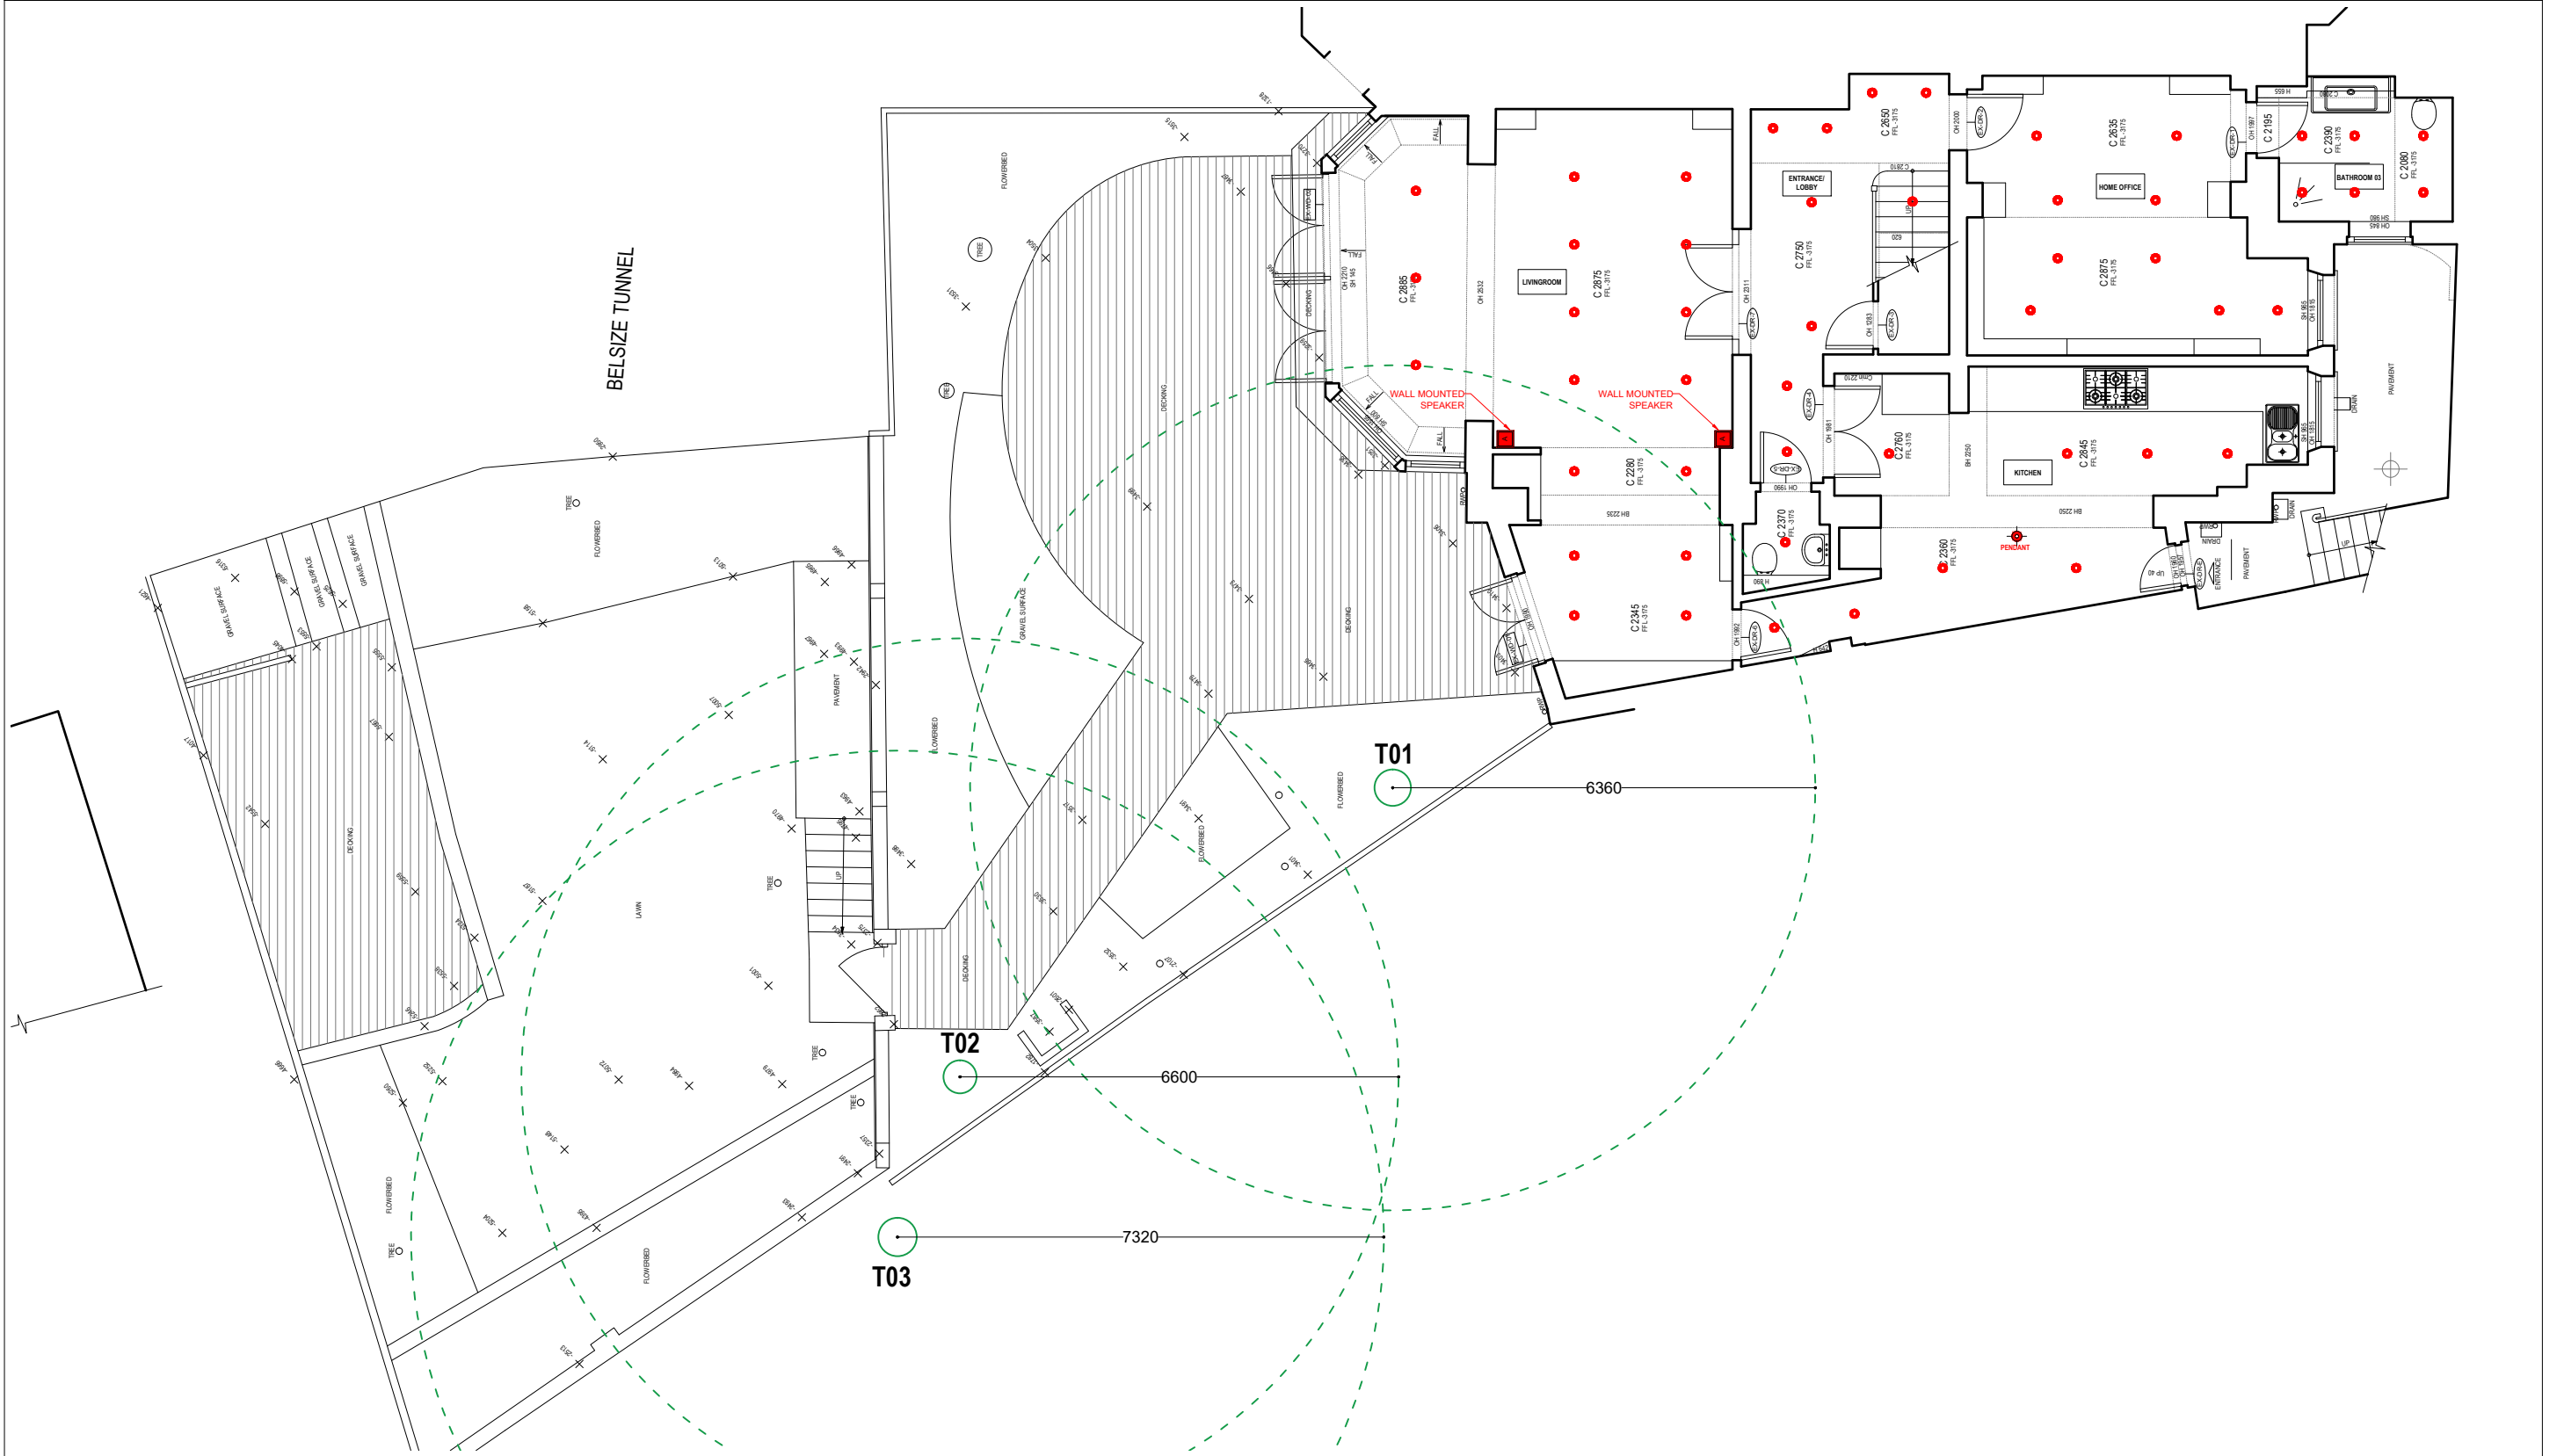


1000_EXISTING

LBMV architects Luigi Montefusco Ltd 72 Haverstock Hill NW3 2BE London M+44 (0) 7837344073 T+44 (0) 207 483 3880	DRAWINGS STATUS PLANNING PERMISSION		A3	DRAWN UG - CA	CHECKED LM	GENERAL NOTE - This drawing should be removed from currency immediately when a revised version is issued. - All dimensions to be checked on site by the contractor. Discrepancies to be reported before proceeding with the works. - This drawing is copyrighted. - All dimensions in mm's.	LEGEND					
	PROJECT TITLE REAR EXTENSION		DATE 06.02.2018	SCALE								
	12 Lyndhurst Gardens NW3 5NR		DRAWING TITLE									
			JOB NO 0066	DRAWING NO A1000								

EXISTING LOWER GROUND FLOOR PLAN - EXISTING LIGHTING LAYOUT

SCALE 1:100



LBMV architects

Luigi Montefusco Ltd
72 Haverstock Hill
NW3 2BE London
M+44 (0) 7837344073
T+44 (0) 207 483 3880

DRAWINGS STATUS
PLANNING PERMISSION

A3

DRAWN
UG - CA

CHECKED
LM

PROJECT TITLE
REAR EXTENSION

DATE	06.02.2018
------	------------

SCALE
1:100@A3

12 Lyndhurst Gardens
NW3 5NR

DRAWING TITLE

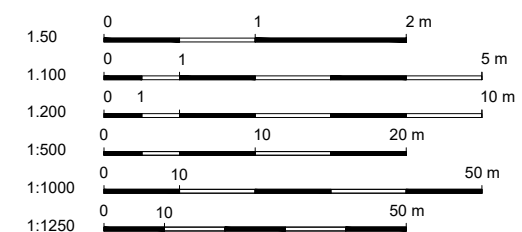
EXISTING LOWER GROUND
FLOOR PLAN - **EXISTING
LIGHTING LAYOUT**

JOB NO
0066

DRAWING NO	A1001
------------	-------

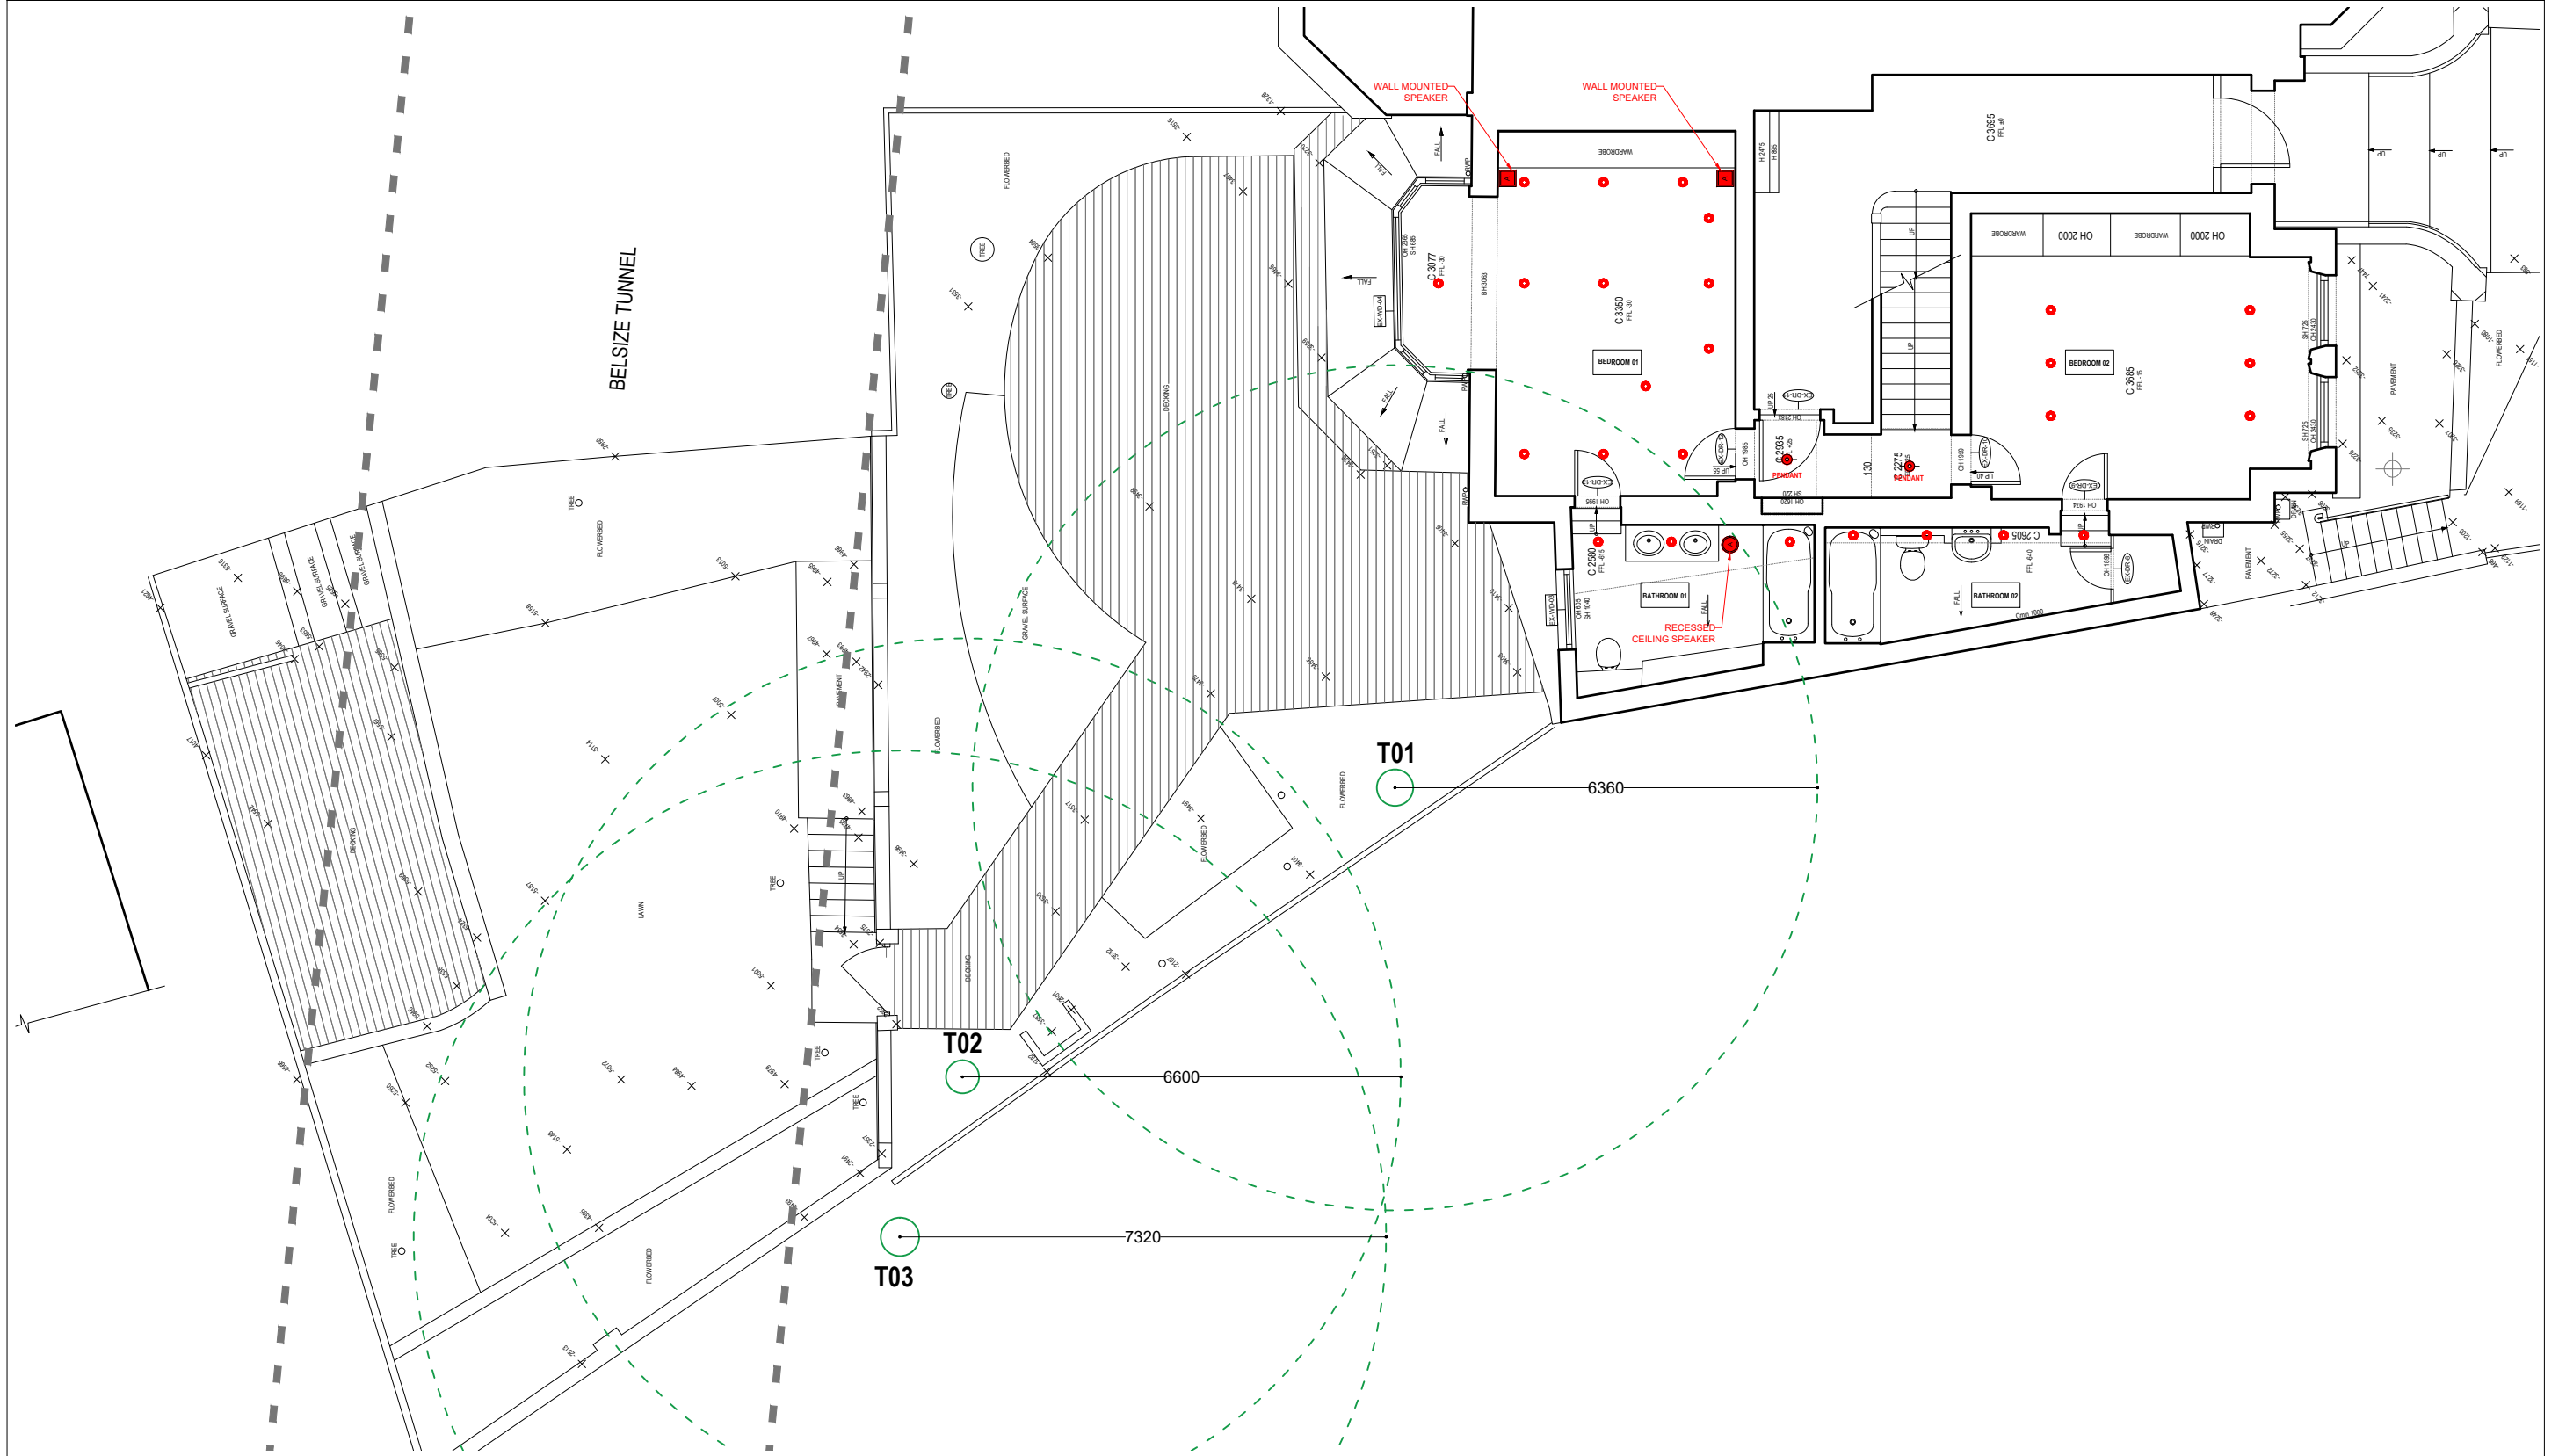
1	GENERAL NOTE - This drawing should be removed from currency immediately when a revised version is issued. - All dimensions to be checked on site by the contractor. Discrepancies to be reported before proceeding with the works. - This drawing is copyrighted. - All dimensions in mm's.
---	---

	LEGEND
--	--------

[illegible]

EXISTING GROUND FLOOR PLAN - EXISTING LIGHTING LAYOUT

SCALE 1:100



LBMV architects

Luigi Montefusco Ltd
72 Haverstock Hill
NW3 2BE London
M+44 (0) 7837344073
T+44 (0) 207 483 3880

DRAWINGS STATUS
PLANNING PERMISSION

A3

DRAWN
UG - CA

CHECKED
LM

GENERAL NOTE
- This drawing
is not to scale

- All dimensions
Discrepancies
works

DRAWING TITLE

 
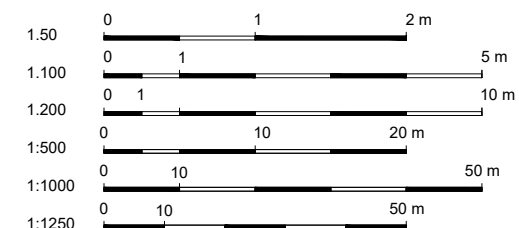
EXISTING GROUND FLOOR
PLAN - **EXISTING LIGHTING
LAYOUT**

JOB NO
0066

DRAWING NO	A1002
------------	-------

GENERAL NOTE	- This drawing should be removed from currency immediately when a revised version is issued. - All dimensions to be checked on site by the contractor. Discrepancies to be reported before proceeding with the works. - This drawing is copyrighted. - All dimensions in mm's.
--------------	---

	LEGEND
--	--------

[illegible]