


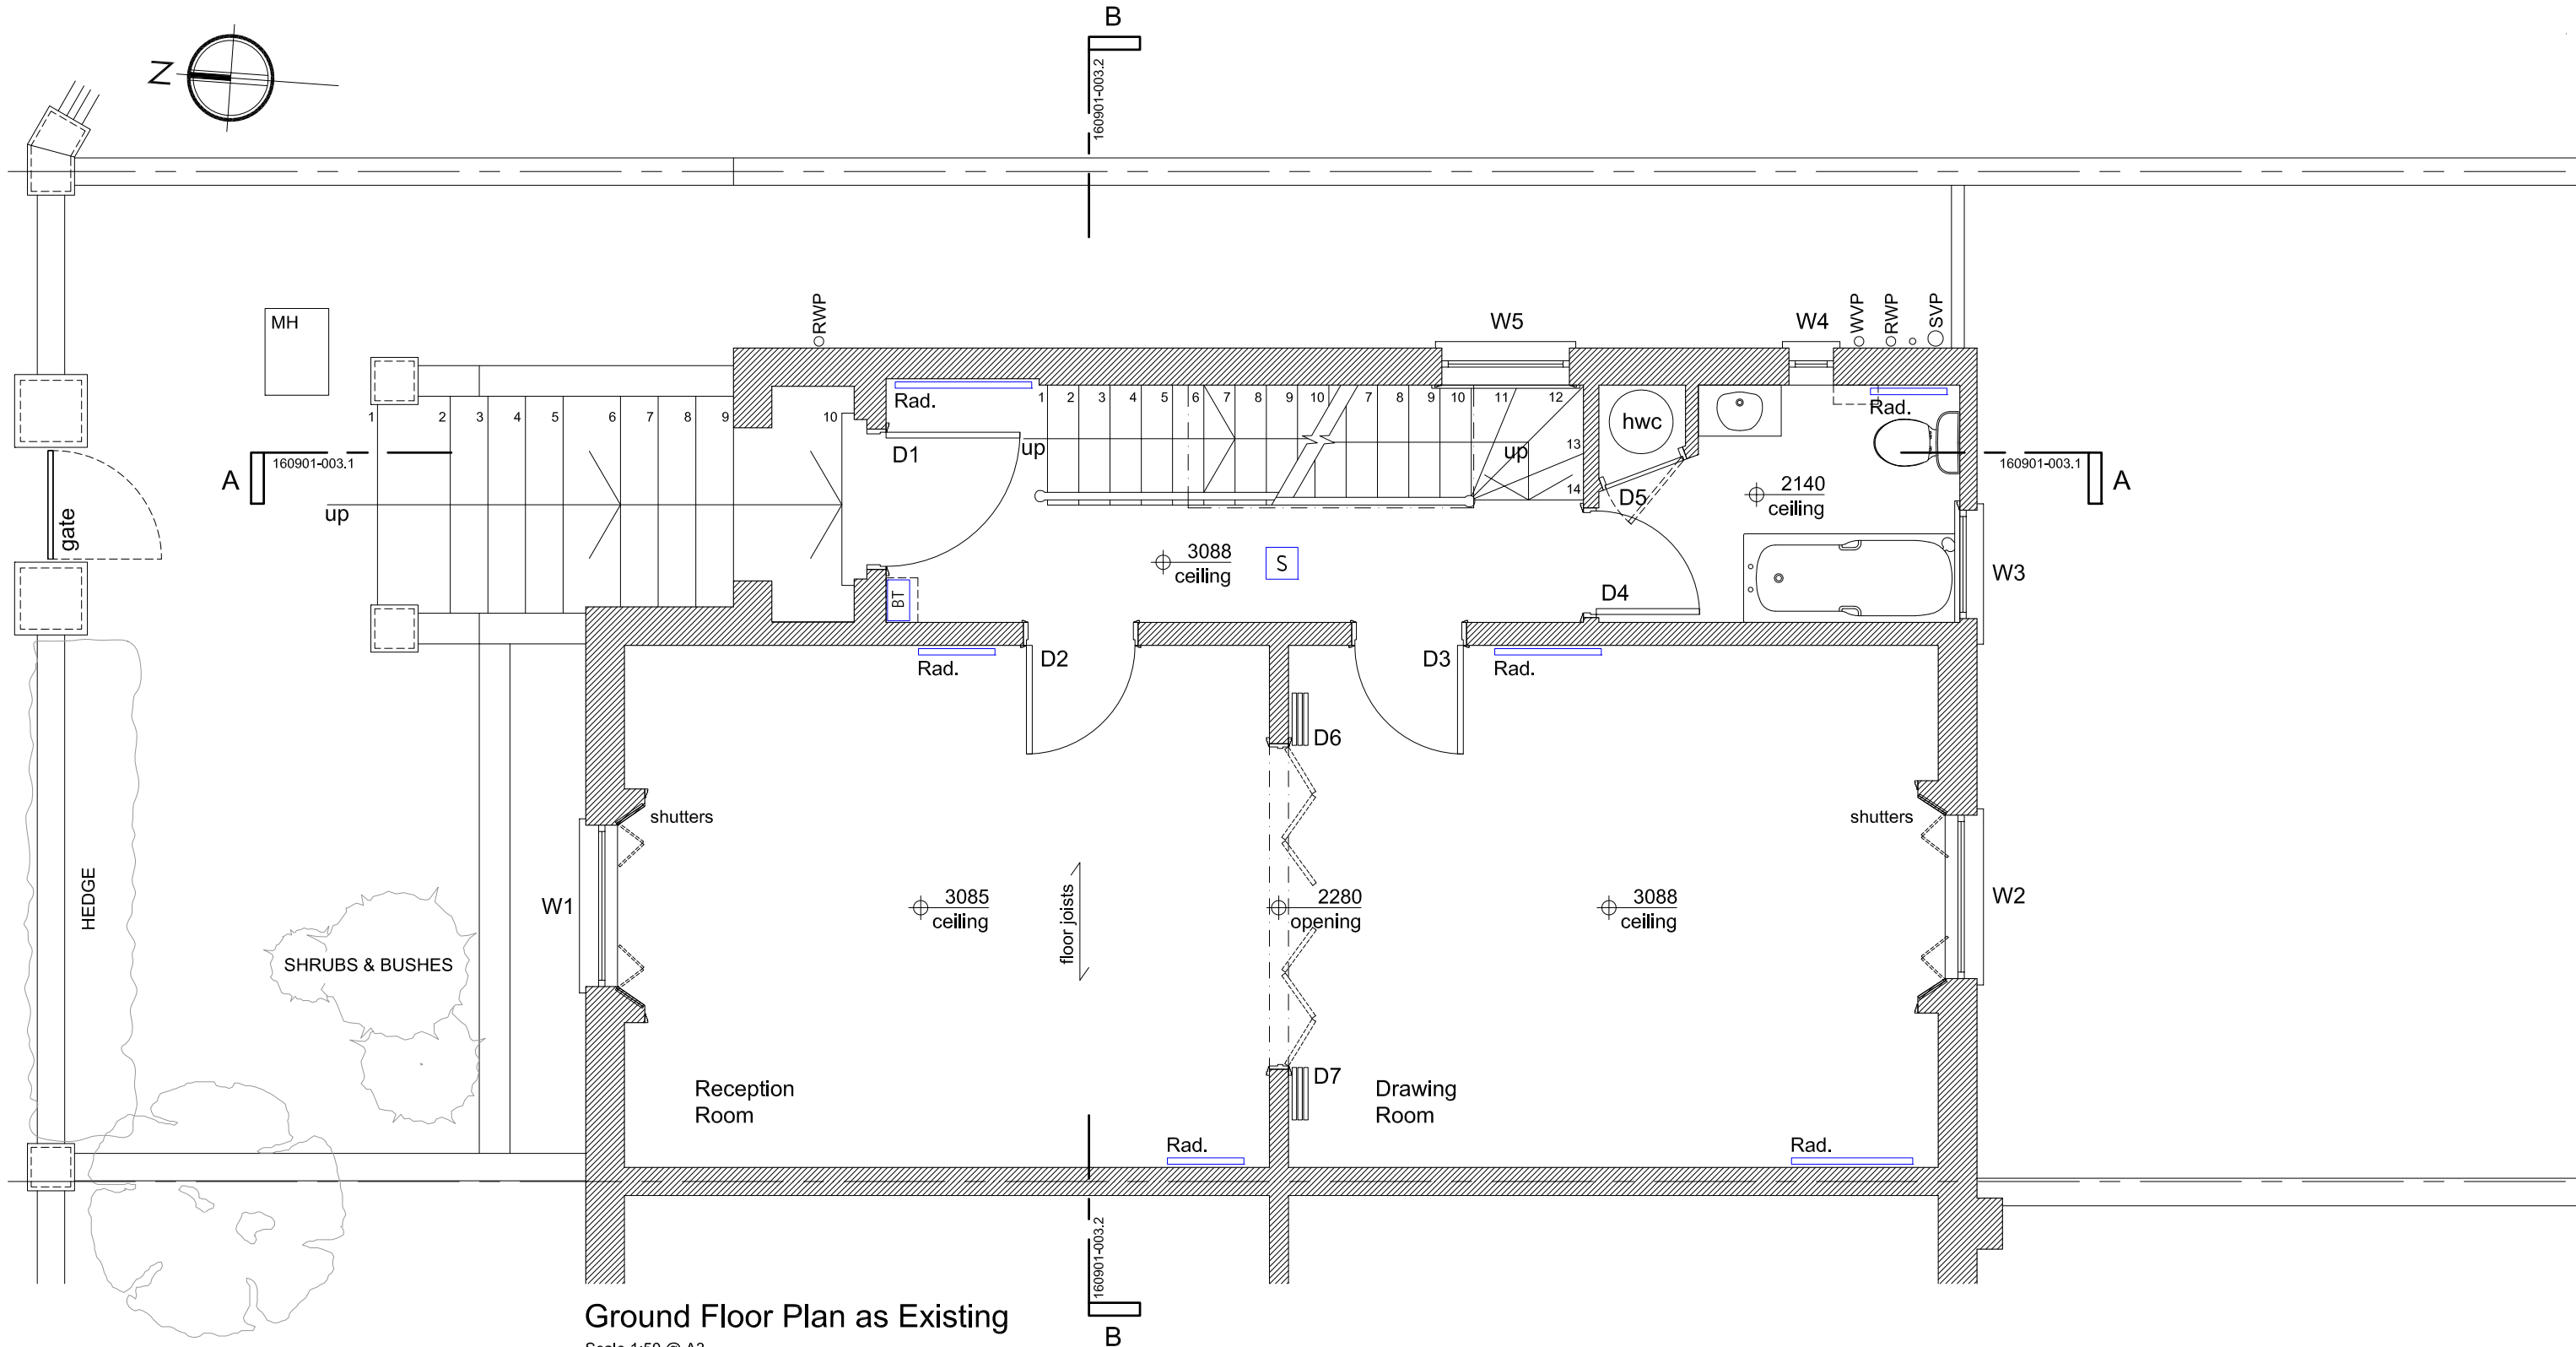

KEY

- Existing Electrical mains / meter
- Existing Electrical distribution / switchgear
- Gas Meter
- Telecom box
- Existing Ceiling mounted smoke detector
- Existing Extractor fan

Ground Floor Plan as Existing  
Scale 1:50 @ A3

Notes:  
1. All sizes to be taken and checked on site by the contractor prior to preparation of shop drawings or fabrication of parts.  
2. This drawing should not be scaled. Any discrepancies to be brought to the immediate attention of the designer.  
COPYRIGHT OF DESIGN AND DRAWING RESERVED

Issue Purpose  
**PLANNING**

|             |                               |
|-------------|-------------------------------|
| Project     | 1 PROVOST RD, LONDON NW3 4ST  |
| Title       | GROUND FLOOR PLAN AS EXISTING |
| Project No. | 160901                        |
| Scale       | 1:50 @ A3                     |
| Drawn       | CAD                           |

Dwg. No. 160901-001.2  
Date SEPT 2016  
Revision

**absolute detail**  
t + f 01628 528492  
m 07824 641414  
e alison@absolutedetail.me  
w absolutedetail.me