

0 200mm 400mm

NOTES:

-

REVISIONS:

- 11.04.2025 First Issued
A 02.06.2025 For Planning

PAUL MELLON CENTRE
LIBRARIAN'S OFFICE ROOF LANTERN

EXISTING
LANTERN DETAILS

DRAWING NO:

(25) 130A

SCALE:


1:10@A1

DATE:


11.04.25

WRIGHT & WRIGHT ARCHITECTS


89/91 Bayham Street
London NW1 0AG
TEL 020 7428 9393
FAX 020 7428 9394
ww@wrightandwright.co.uk
www.wrightandwright.co.uk

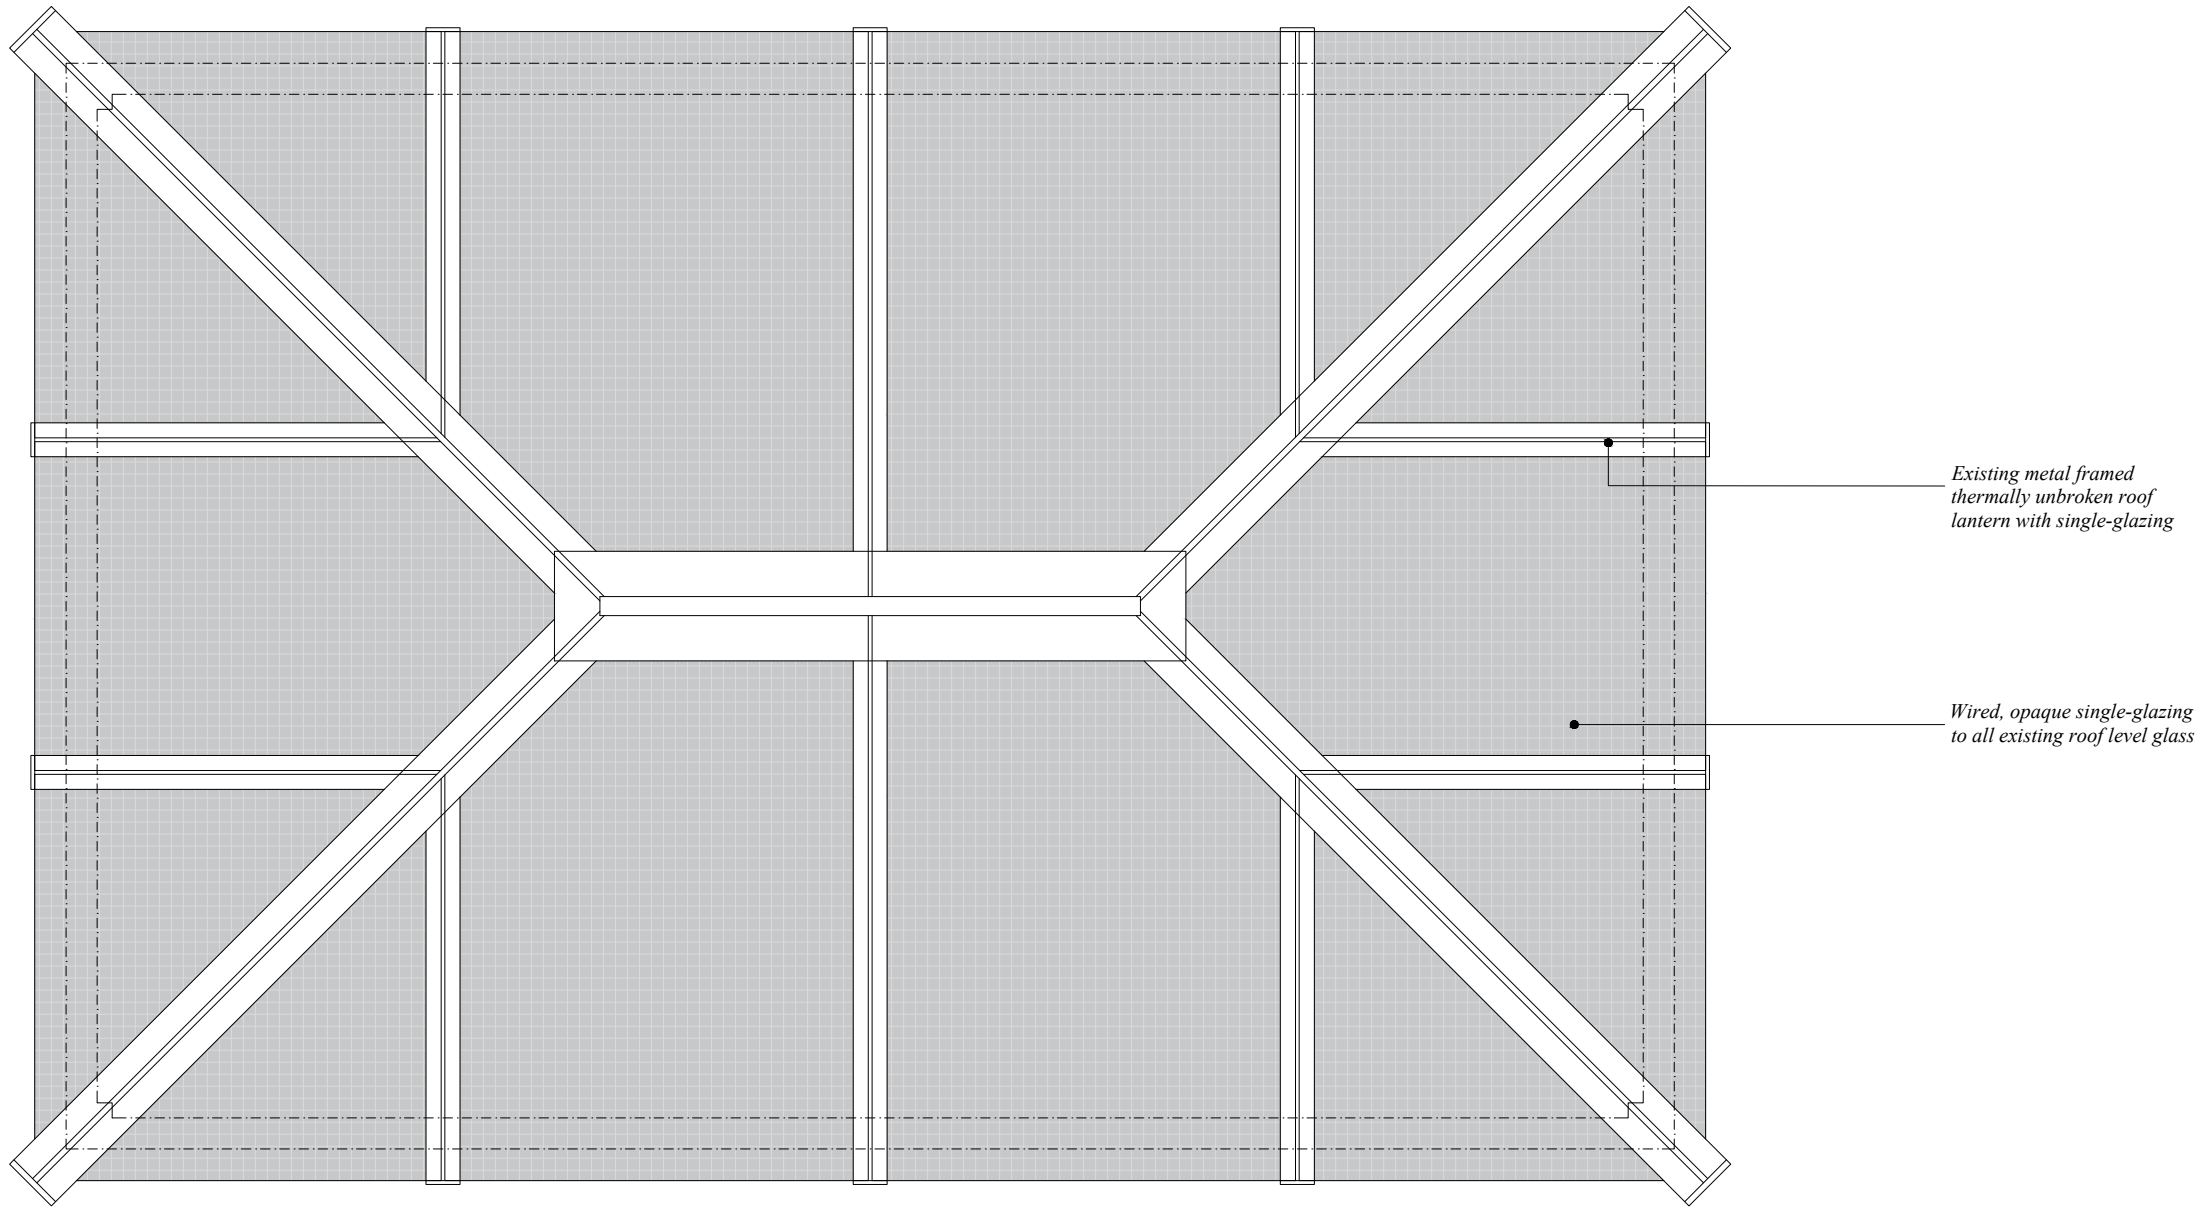

Existing Lantern Roof Plan (Extract)

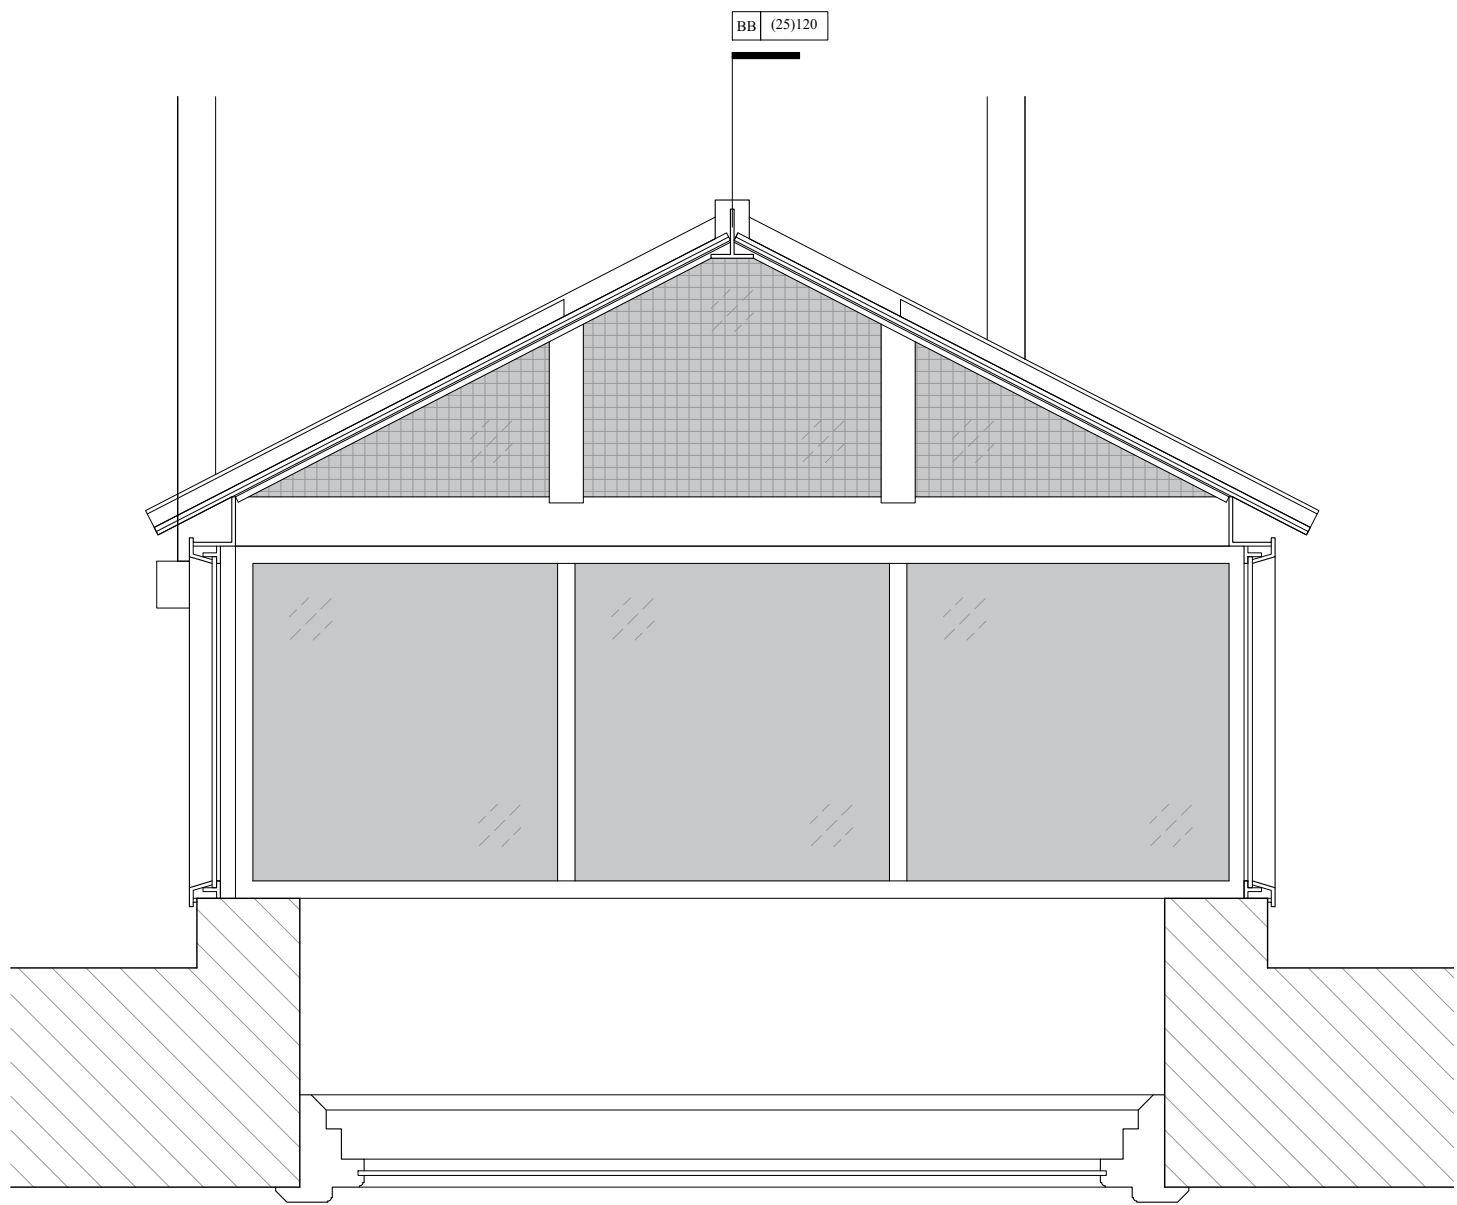

Existing Short Section/ Internal Elevation

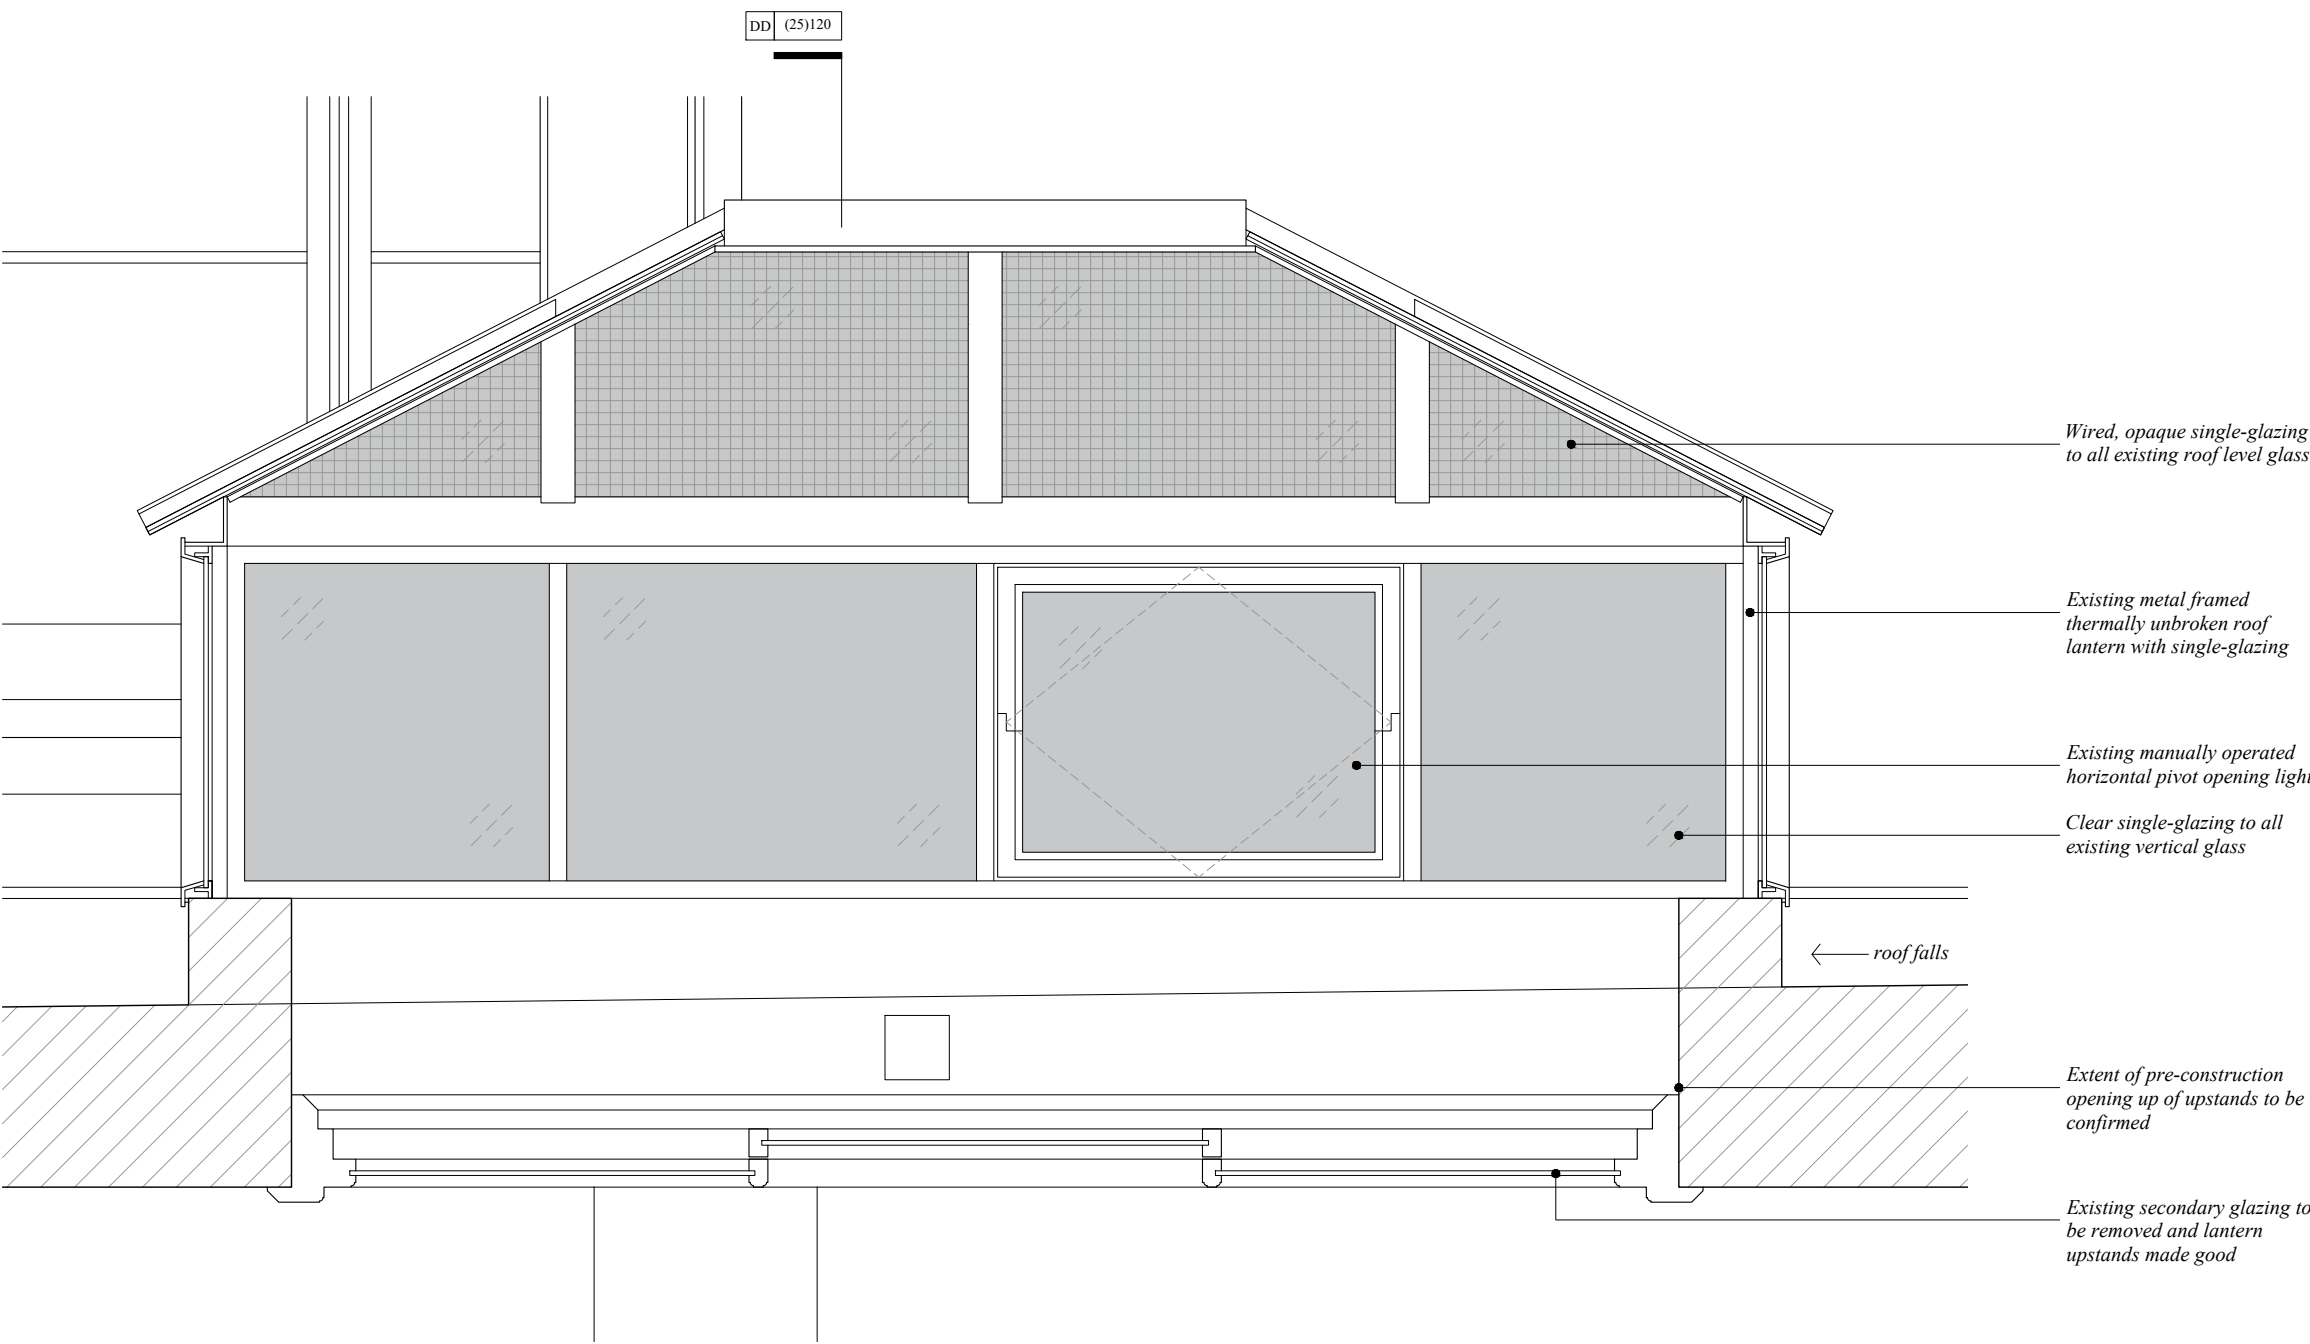

Existing Long Section/ Internal Elevation