


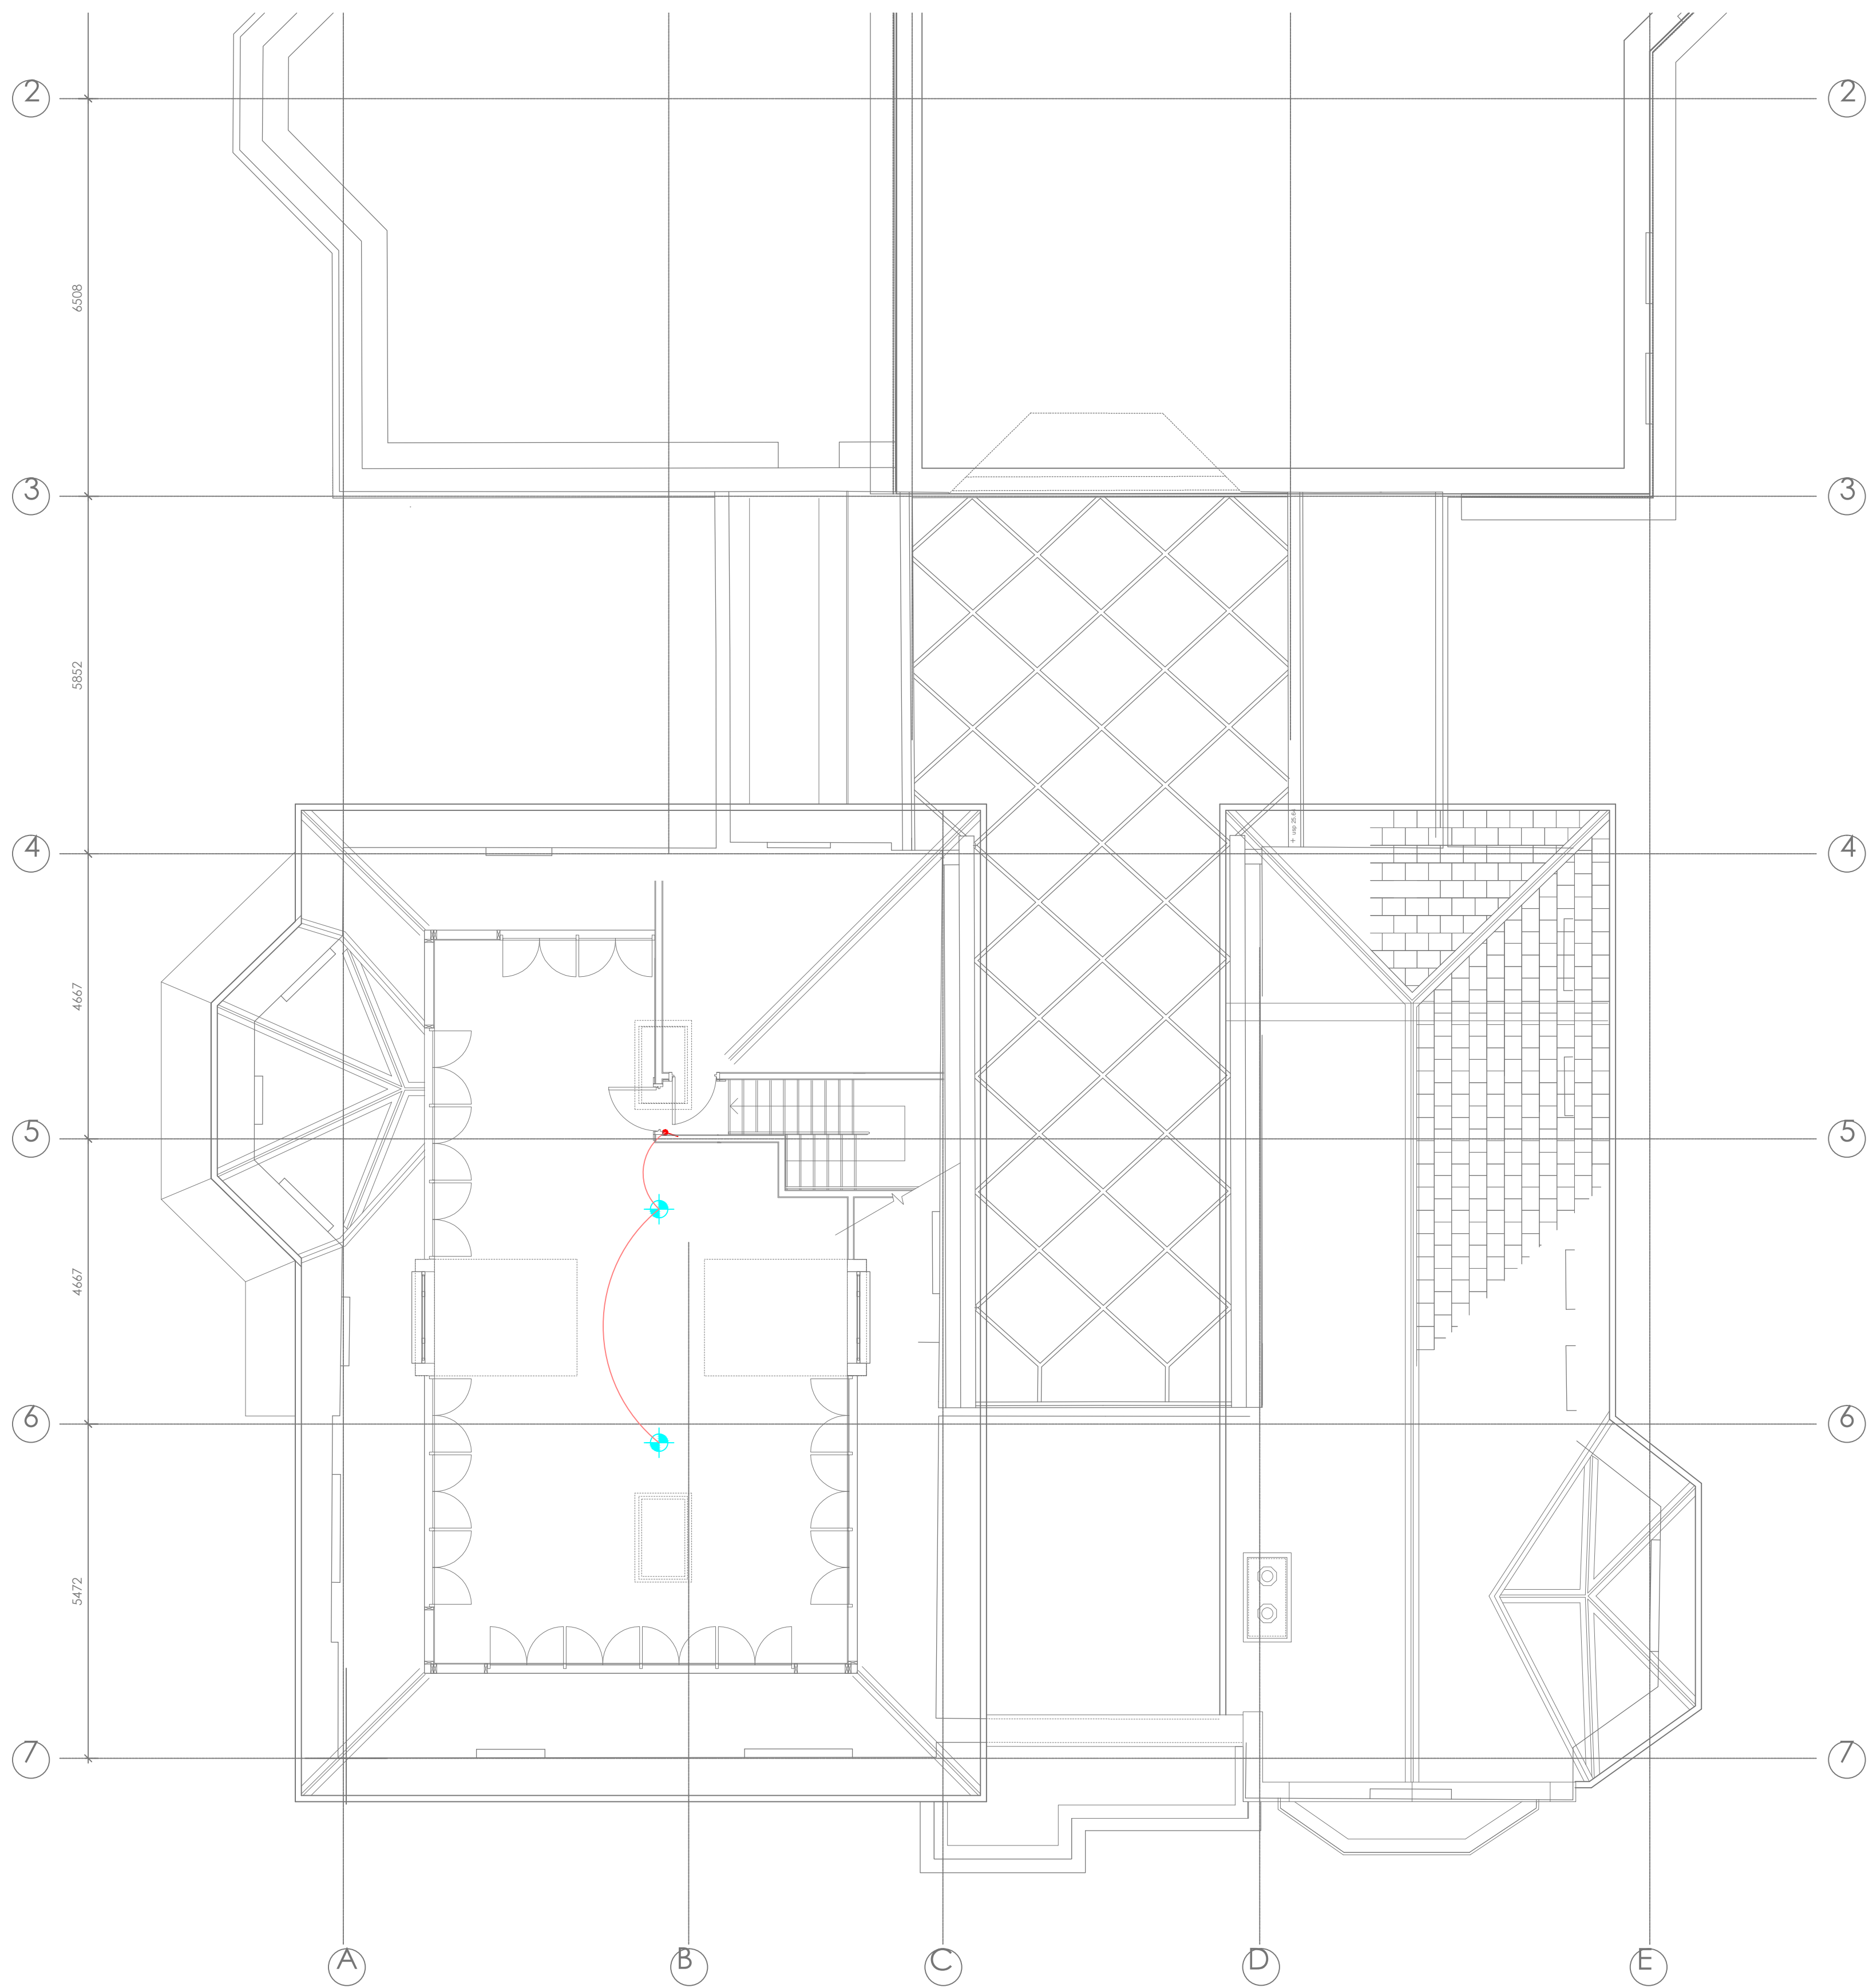


DO NOT SCALE from this drawing
Contractors must verify all dimensions
on site before setting out, commencing
work, or making any shop drawings.

- LIGHT SWITCH
- 2 GANG LIGHT SWITCH
- CEILING PENDANT LIGHT
- CEILING RECESSED LIGHT
- WALL MOUNTED LIGHT



REV.	DATE	DESCRIPTION	BY	CHKD
<div><div>mgpartnership Building Services Consulting Engineers Tel: 01883 621200 Fax: 01883 621201 Email Address: engineers@mgpartnership.com</div><div>Surrey House, Whyteleafe Business Village, Whyteleafe Hill, Whyteleafe, Surrey, CR3 0AT</div><div> ISO 14001 REGISTERED FIRM</div><div> ISO 9001 REGISTERED FIRM</div></div>				
CLIENT DECENT HOME BUILDERS LTD				
PROJECT THE ELMS, FITZROY PARK				
TITLE LIGHTING LAYOUT ROOF LEVEL				
DRAWN VME		CHECKED O.B	APPROVED R.K.	
DATE 01/12/13		SCALE @ A0 1:50		
DRAWING NUMBER ELM/25/10/313			REV 00	