

RISER / PLANT KEY


- MECHANICAL SERVICES
- ELECTRICAL & COMMS SERVICES
- PUBLIC HEALTH SERVICES
- FIRE SERVICES
- FUTURE TENANT SPACE

INDICATIVE SERVICE DISTRIBUTION

- VENTILATION SUPPLY DUCTWORK ROUTE
- VENTILATION EXTRACT DUCTWORK ROUTE
- TOILET/BIN EXTRACT DUCTWORK ROUTE
- PUBLIC HEALTH DRAINAGE ROUTE
- DOMESTIC WATER DISTRIBUTION ROUTE
- ELECTRICAL DISTRIBUTION ROUTE
- FIRE DISTRIBUTION ROUTE
- COMMS DISTRIBUTION ROUTE
- GAS DISTRIBUTION ROUTE
- CONDENSER WATER PIPE DISTRIBUTION ROUTE

DESCRIPTION

- ① TENANT A LTHW/CHW/PH RISER
- ② TENANT B LTHW/CHW/PH RISER
- ③ TENANT A ELEC/COMMS RISER
- ④ TENANT B ELEC/COMMS RISER
- ⑤ RESIDENTIAL GAS AND BCWS
- ⑥ RESIDENTIAL ELECTRICAL RISER
- ⑦ LANDLORD ELECTRICAL RISER
- ⑧ BOILER FLUES
- ⑨ WC/SHOWER/BIN STORE EXTRACT RISER
- ⑩ MAIN AHU DISCHARGE RISER TO ABOVE
- ⑪ POTENTIAL FUTURE TENANT PLANT ZONE AND GAS METER CUPBOARD
- ⑫ RESIDENTIAL DRY RISER

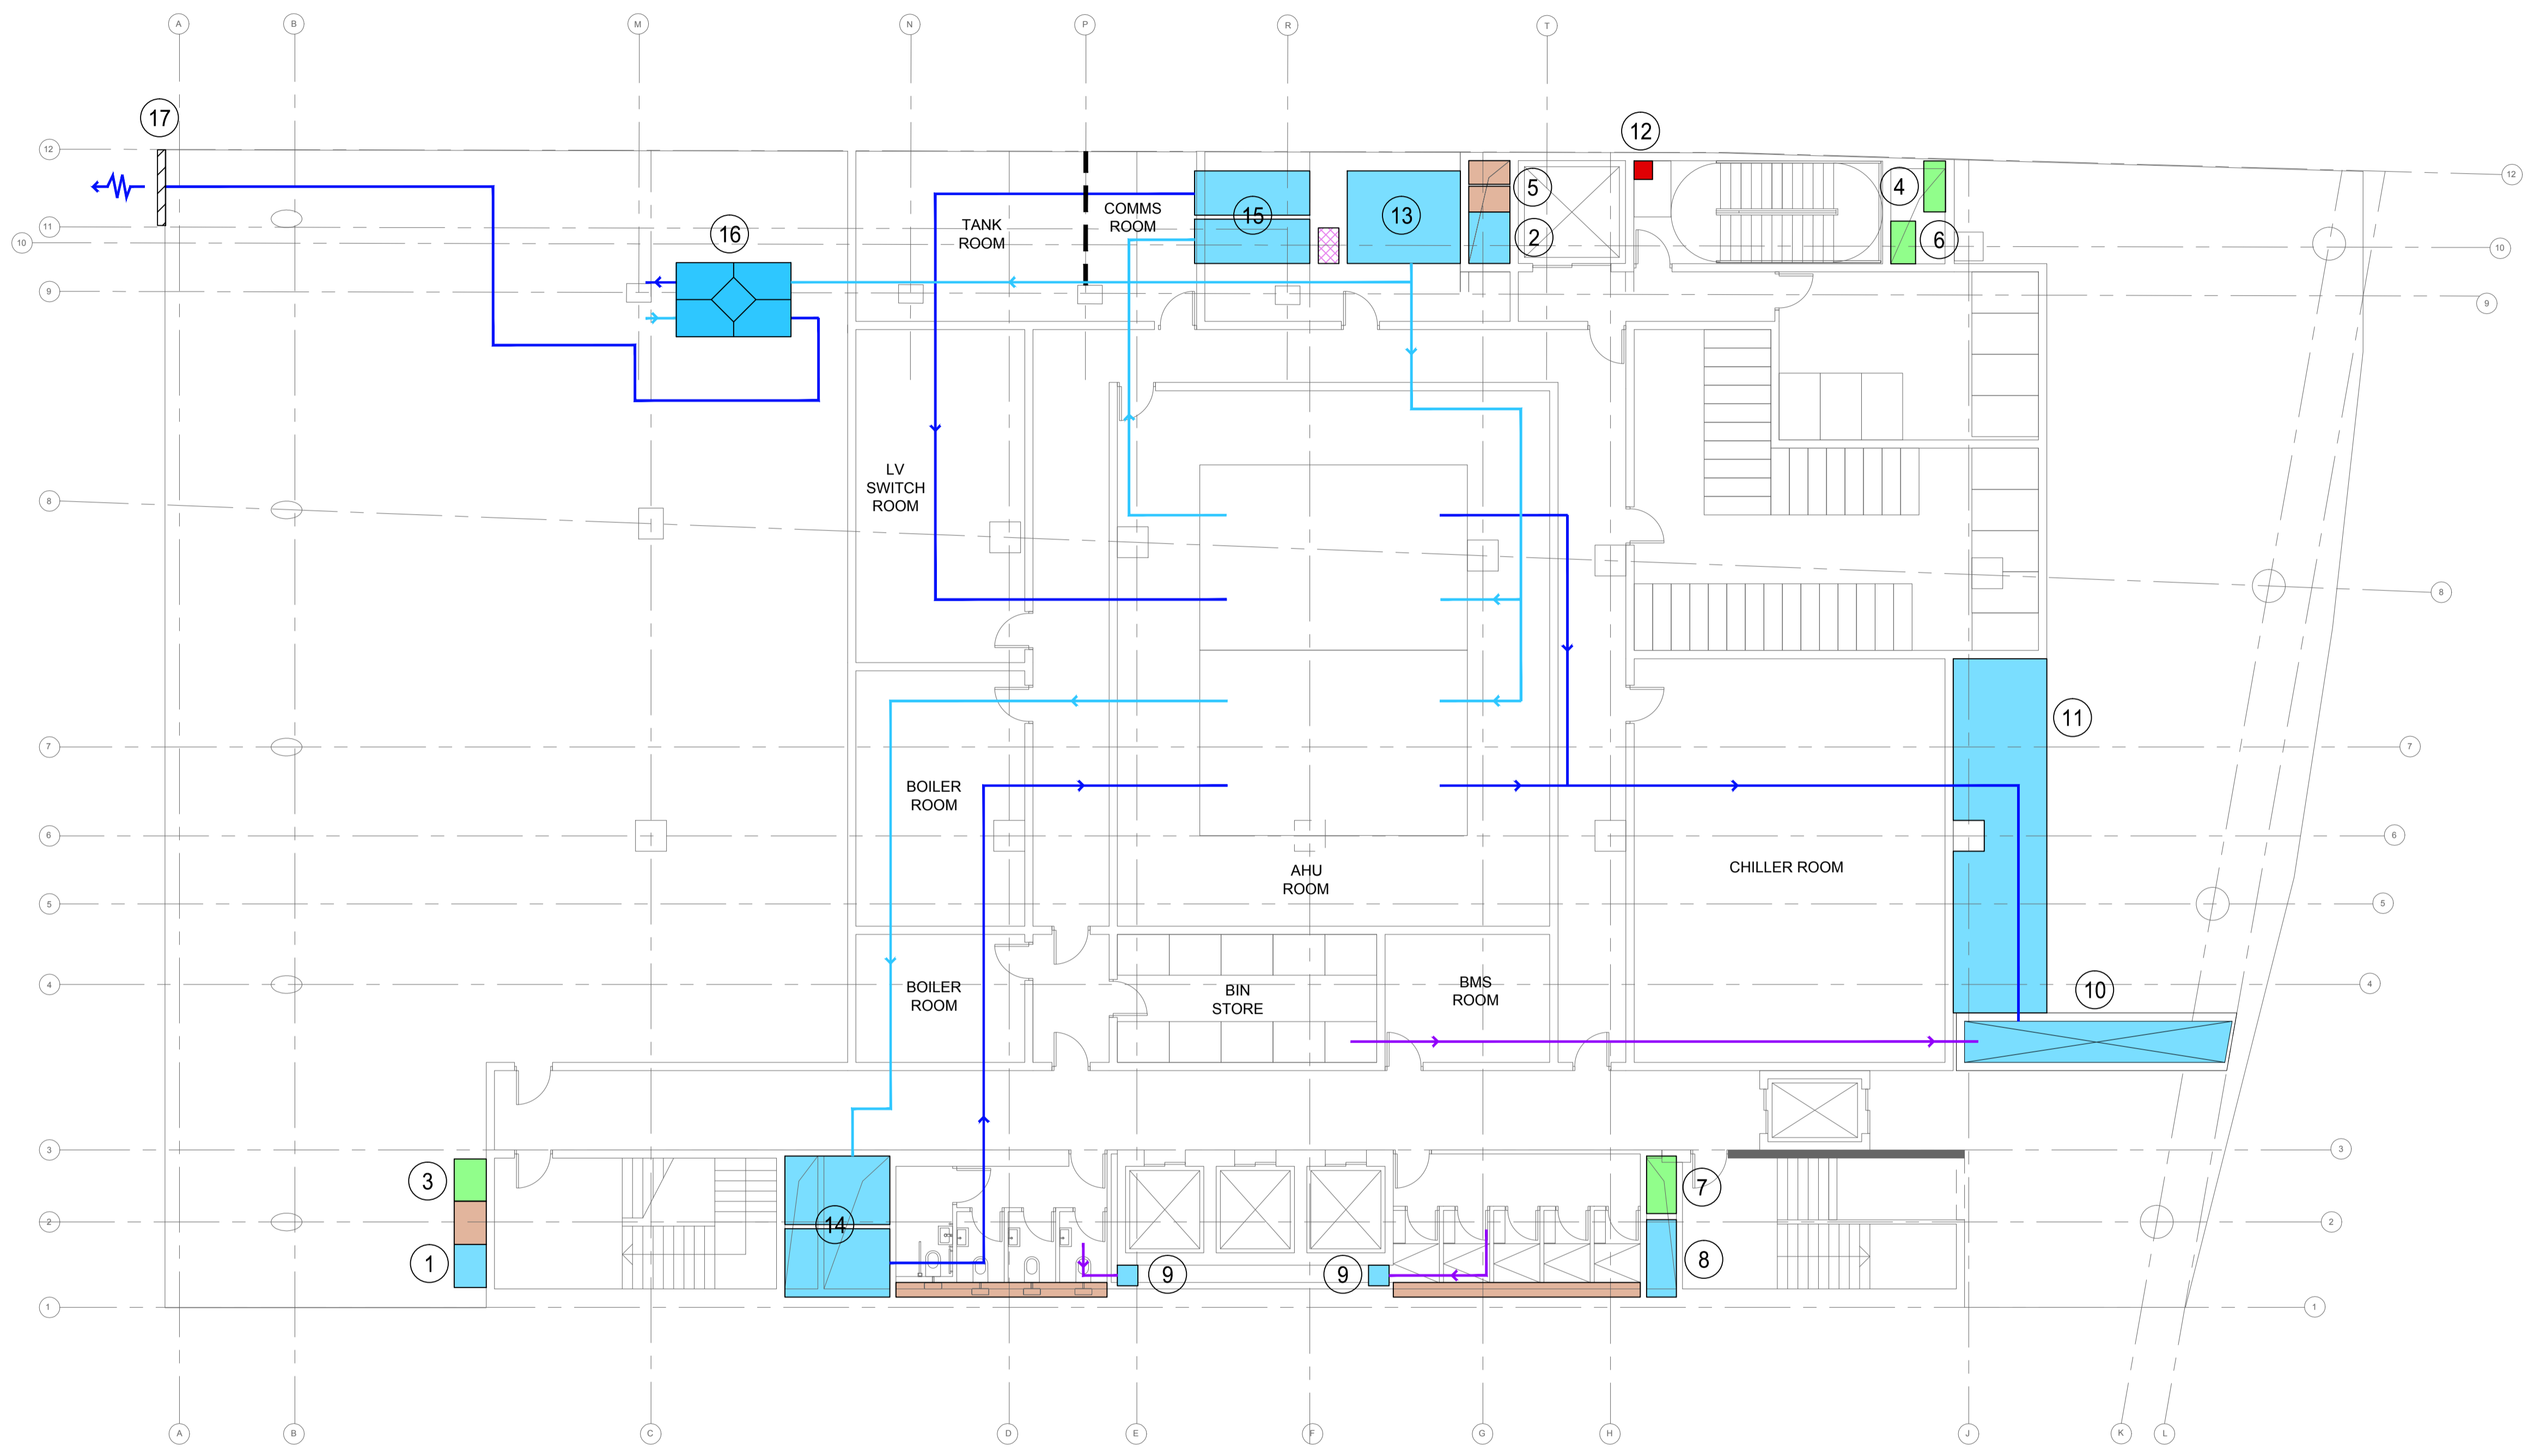

- ⑬ FRESH AIR RISER
- ⑭ TENANT A SUPPLY AND EXTRACT DUCTWORK
- ⑮ TENANT B SUPPLY AND EXTRACT DUCTWORK
- ⑯ VENTILATION UNIT WITH HEAT RECOVERY AT HIGH LEVEL.
- ⑰ EXHAUST AIR GRILL

Rev.	Description	Date	Rev.	Description	Date	Rev.	Description	Date
P01	STAGE C ISSUE	21.06.13						

NDY QA SYSTEM
 REASON FOR ISSUE
 STAGE C
 AUTHORISATION
 By:DT.:21 Jun 2013
 VERIFICATION OF LATEST AMENDMENT
 By:RP.:21 Jun 2013

Norman Disney & Young
 CONSULTING ENGINEERS
 Classic House, 180 Old Street
 London EC1V 9RQ
 United Kingdom
 T +44 207 553 9494
 F +44 207 553 9499
 www.ndy.com
 NDY CONSULTING LTD
 A registered company in England & Wales
 Company Registration No. 3890817

This drawing is diagrammatic and shows the general arrangement of equipment. Any information involving measurement of the works shall be taken from architectural and structural drawings, workshop drawings by others and conditions at the site. The works shall comply with the contract conditions and Statutory Regulations.

Project: **BEWLAY HOUSE**

Title: **COMBINED SERVICES BASEMENT LEVEL**

Scale: 1:100 @ A1 Date: JUN 2013 Drawn: DC Designed: RP Project No: u13357-001A

Set Of: P01
 Drawing No: **CS-0B-001 P01**