


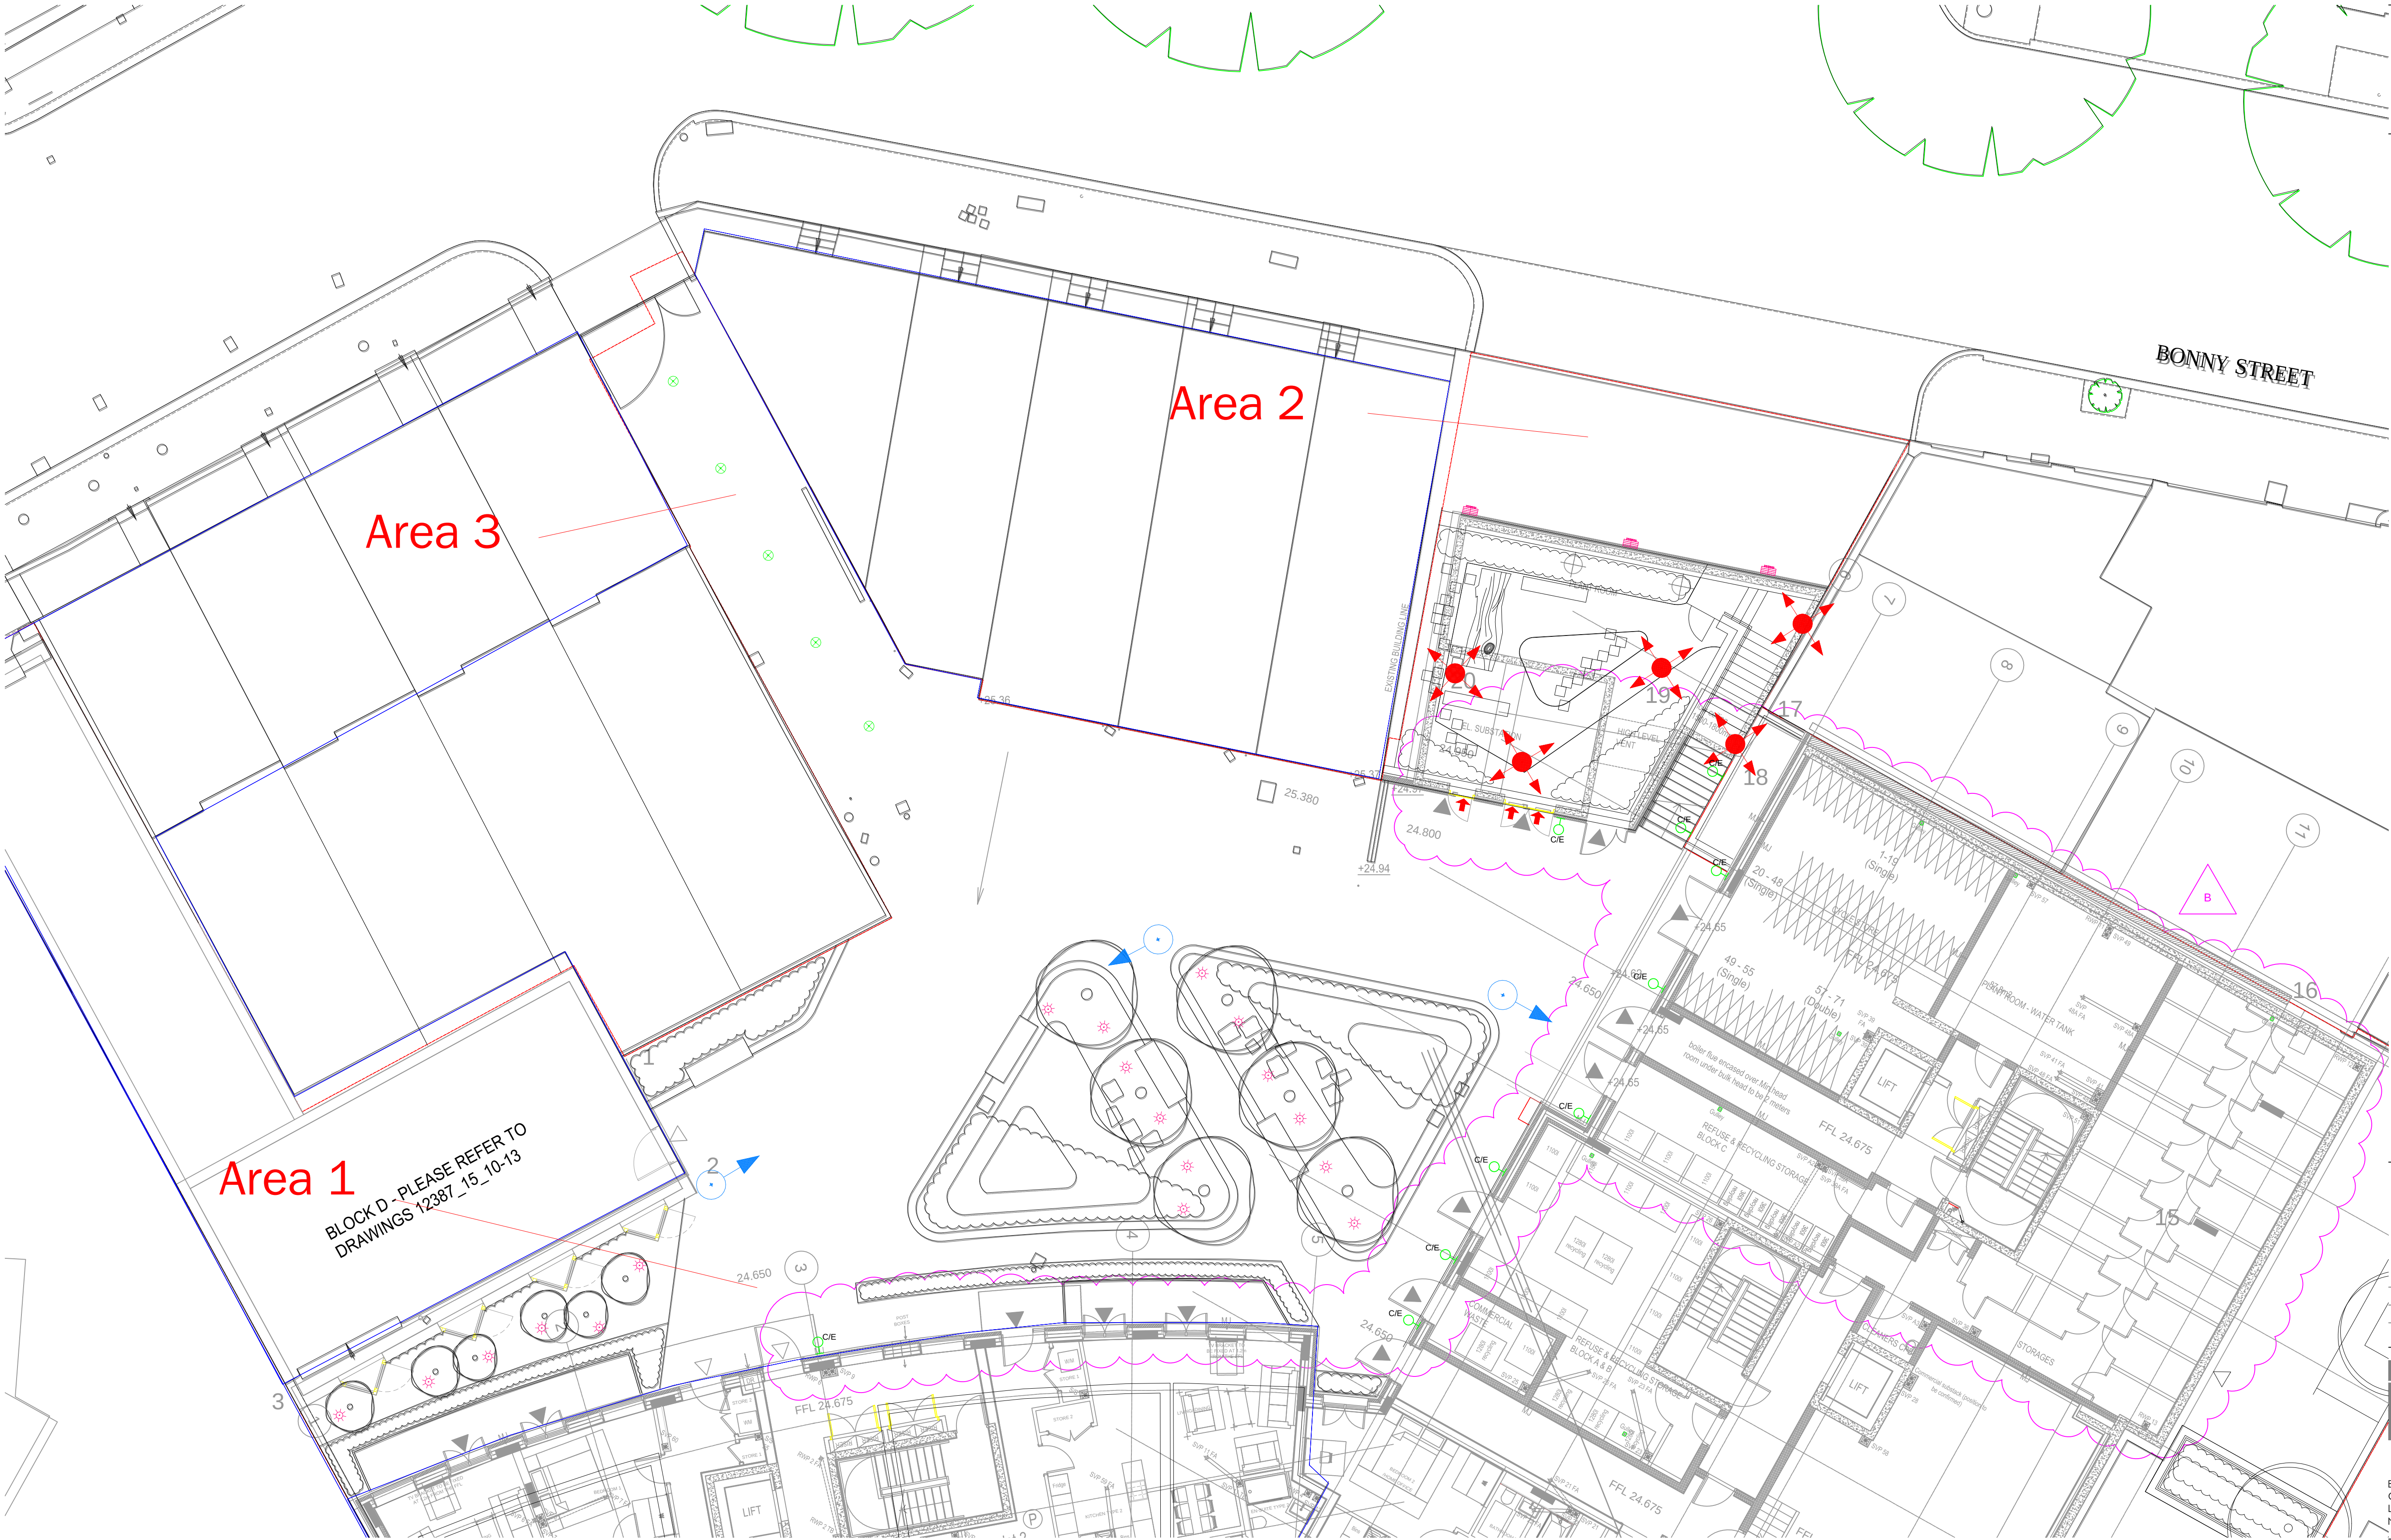

All dimensions to be verified on site by Main Contractor before the start of any shop drawings or work whatsoever either on their own behalf or that of sub-contractors.

Report any discrepancies to the Contract Administrator at once.

This drawing is to be read with all relevant Architect's and Engineers' drawings and other relevant information.

© Ingleton Wood LLP

LEGEND: DO NOT SCALE

B	23.09.13	Roof lighting removed & Lighting Schedule Updated	KS	PK
A	28.02.13	Lighting revised	KS	MM
Revision:	Date:	Description:	Drw:	Chk:



Vision, form and function

Colchester
874 The Crescent
Colchester Business Park
Colchester CO4 9YQ
T: 01206 224270
F: 01206 943715
www.ingletonwood.co.uk

Billericay
Colchester
London
Norwich

Project: Twyman House
Camden Road
London
NW1 9LR

Drawing Title: Proposed External Lighting

Client: Willmott Dixon

Drawn:	Checked:	Date:	Scale:	Paper Size:
KS	MM	20.02.13	1:100	A1
Job No.:	Dwg No.:	Stage:	Revision:	
42099	505	Construction	B	

Luminaire Schedule				
Symbol	Qty	Label	Arrangement	Description
	3	NBDD-LED-260-E (60W) RAL 7016	SINGLE	Auriga PS 60W LED-1, Tempered safety glass, LED, 5m Column 5CT76
	5	AU-PST110/LED	SINGLE	Aurora 240V Aluminium IP54 Fixed 6W LED Post Light
	3	ABLF9/B	SINGLE	Ansell Bricklight 9W PL-S Black
	31	AU-DUR201	SINGLE	Aurora 240V Stainless Steel IP67 Fixed Round LED
	5	AU-DU686	SINGLE	Aurora 240V Stainless Steel IP67 Fixed LED Driveover