



A-1.0

NOTE:
ALL DIMENSIONS TO BE CHECKED ON SITE PRIOR TO ANY WORK COMMENCING DRAWINGS TO BE READ IN CONJUNCTION WITH ALL REFERENCED DRAWINGS, MATERIALS AND FINISHES SCHEDULES

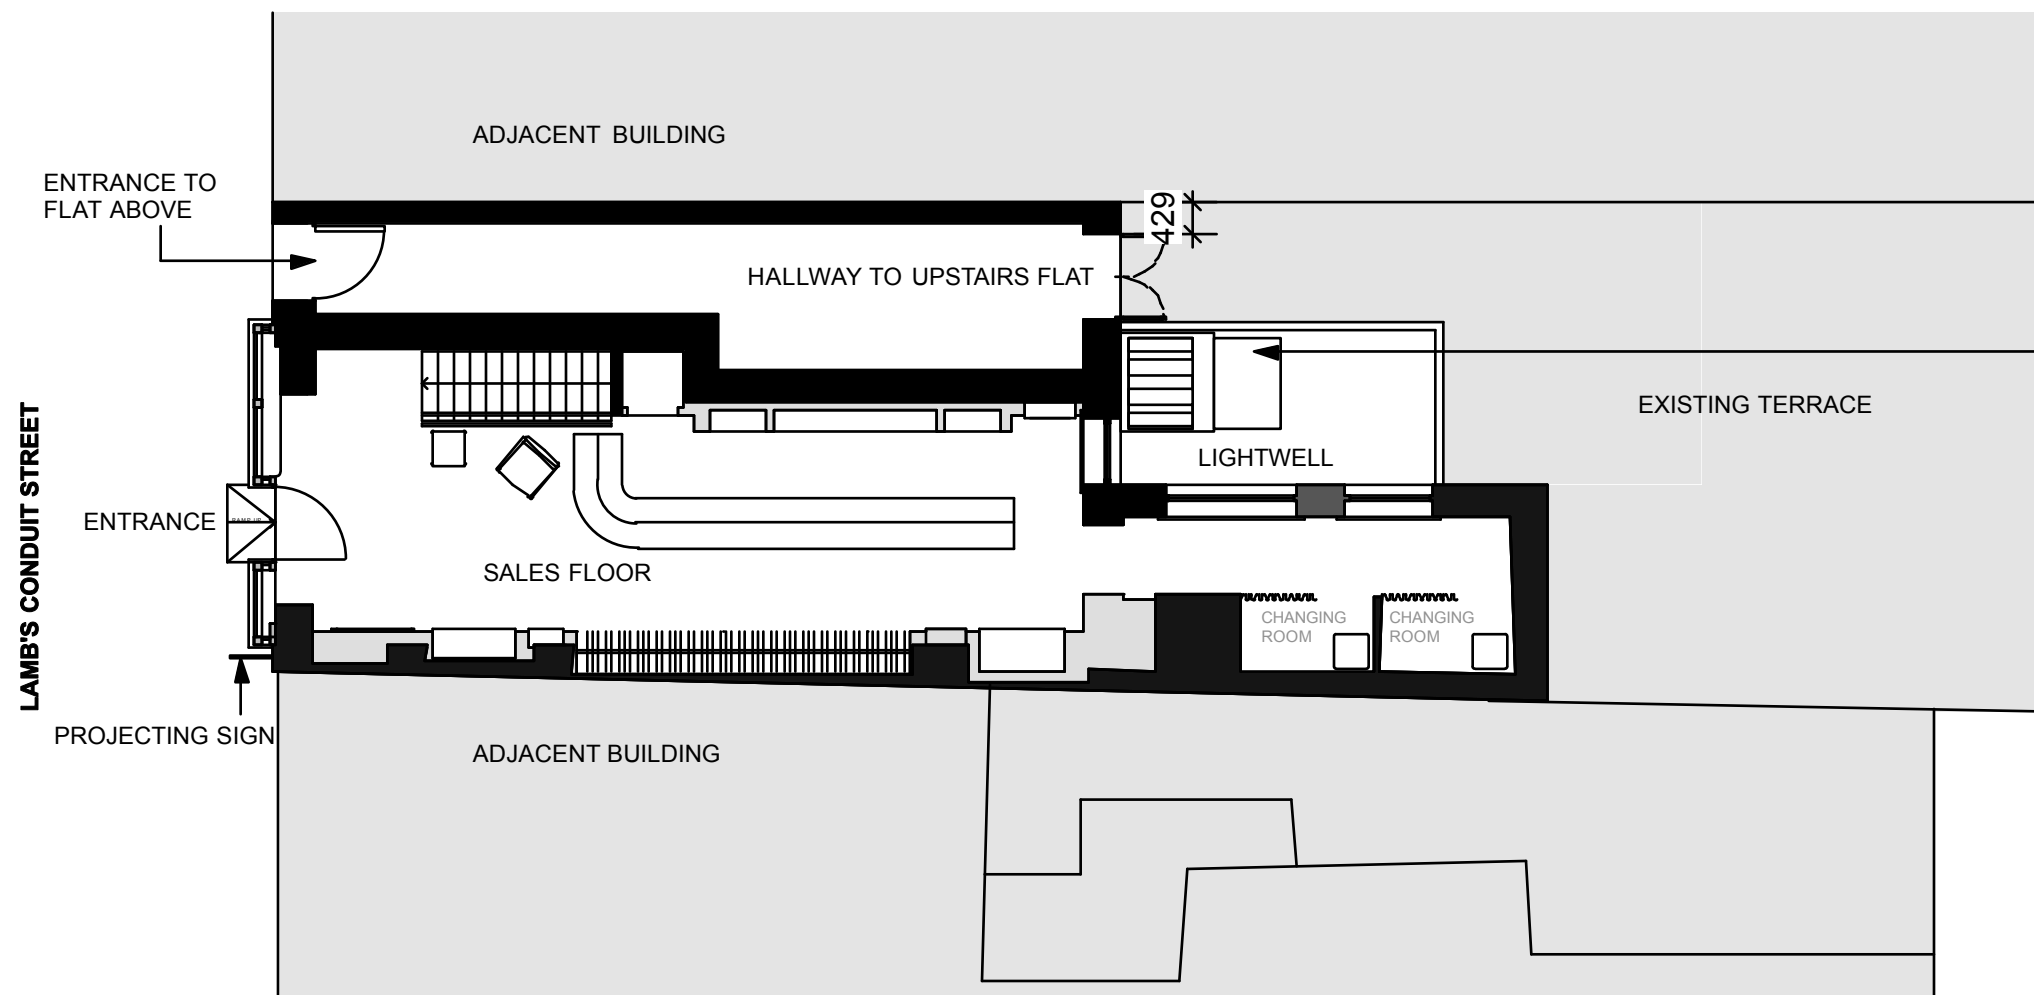

DOTTED LINES INDICATE - OUTDOOR ACOUSTIC ENCLOSURE TO HOUSE A/C CONDENSER UNITS TTD TO LOWER GROUND IN LIGHTWELL

1 PROPOSED GROUND FLOOR PLAN
SCALE: 1 : 100 @ A3

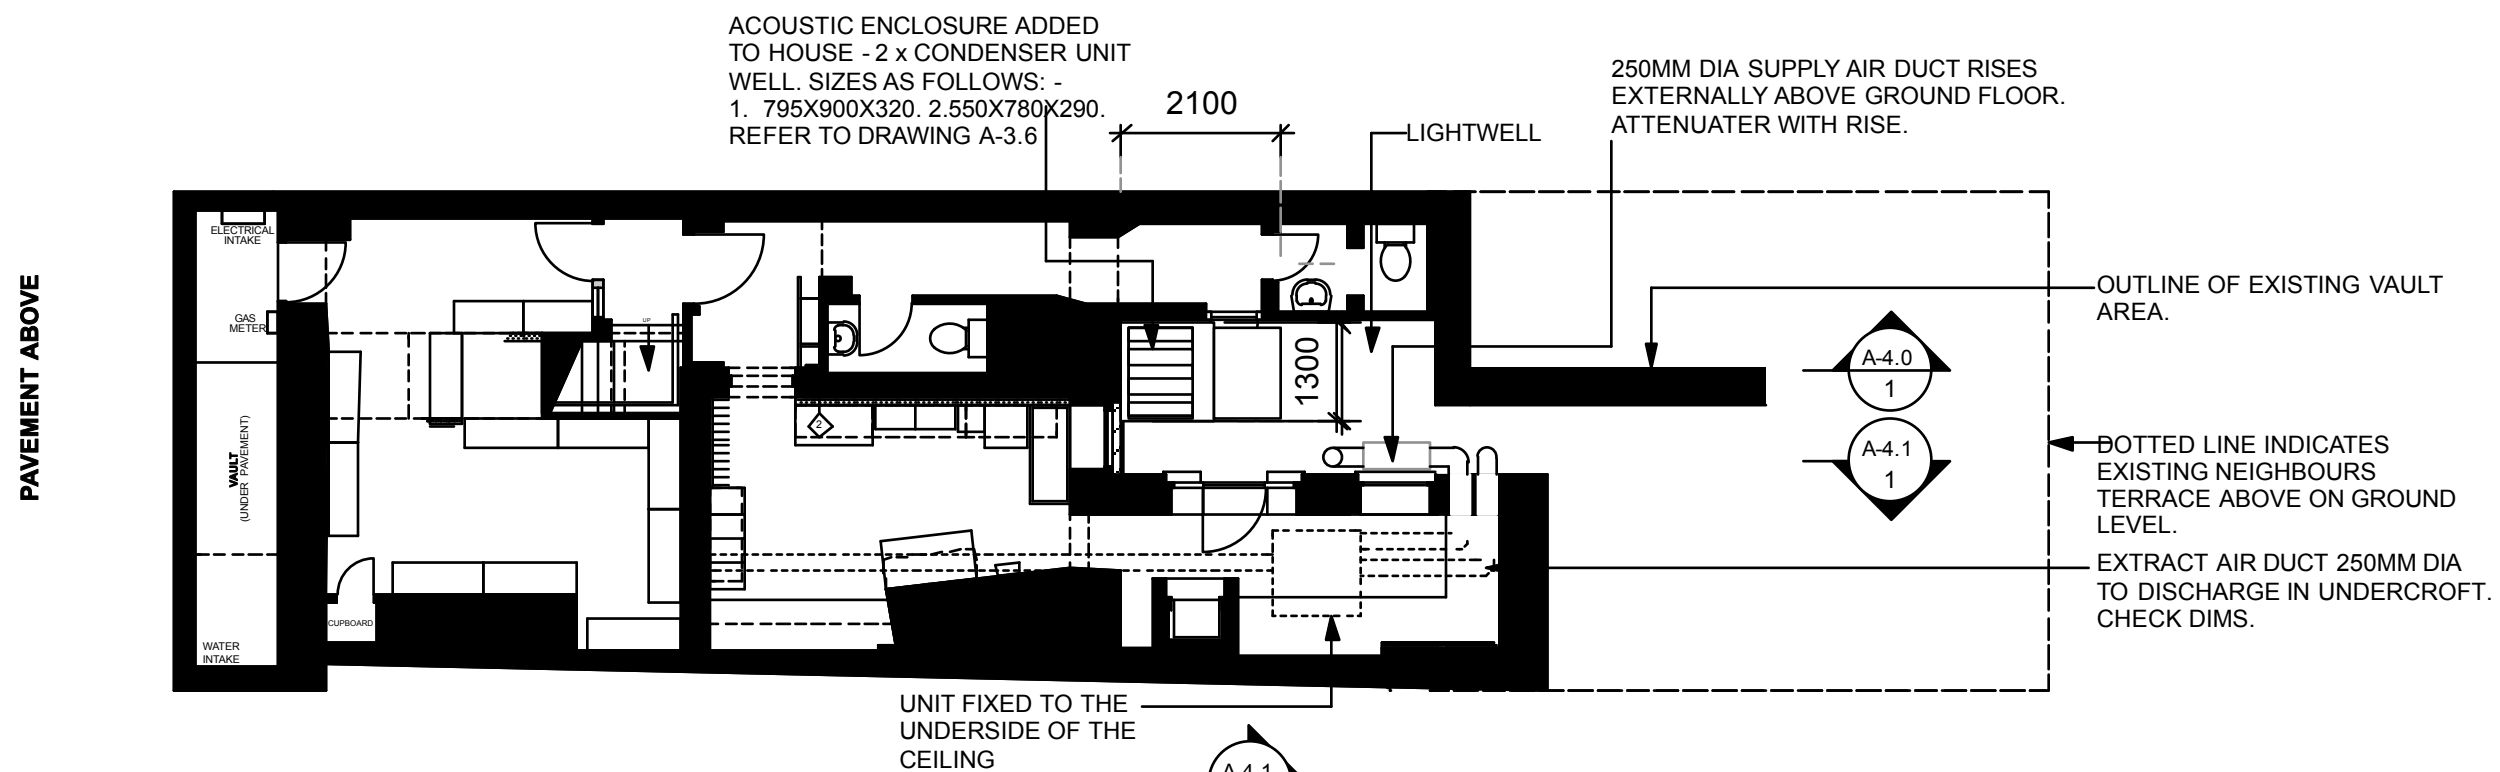

ACOUSTIC ENCLOSURE ADDED TO HOUSE - 2 x CONDENSER UNIT WELL. SIZES AS FOLLOWS: -
1. 795X900X320. 2. 550X780X290.
REFER TO DRAWING A-3.6

250MM DIA SUPPLY AIR DUCT RISES EXTERNALLY ABOVE GROUND FLOOR. ATTENUATER WITH RISE.

OUTLINE OF EXISTING VAULT AREA.

DOTTED LINE INDICATES EXISTING NEIGHBOURS TERRACE ABOVE ON GROUND LEVEL.

EXTRACT AIR DUCT 250MM DIA TO DISCHARGE IN UNDERCROFT. CHECK DIMS.

UNIT FIXED TO THE UNDERSIDE OF THE CEILING

2 PROPOSED LOWER GROUND FLOOR
SCALE: 1 : 100 @ A3

DRAWING ISSUE FOR PLANNING

Portland Design Associates Ltd
First Floor
63 Gee Street
London EC1V 3RS
T +44(0)20 7017 8780
F +44(0)20 7017 8781

Revision	Date	Amendment	Signature
REV A	18.08.13	Condenser unit re-located	CJ
REV B	2.09.13	Acoustic enclosure added, ducting updated	CJ

Client:
JCREW

Project:
38 LAMBS CONDUIT STREET, LONDON, WC1N 3LD

Drawing Title:
PROPOSED GROUND & LOWER GROUND FLOORS

Date	Scale	Signature
01.07.13	1:100 @ A3	CJ
Job Number	Drawing Number	
04037	A-1.0	

Copyright © 2009 Portland Design Associates Limited
All rights reserved.
No part of this design work may be reproduced without prior permission of the copyright owners.
All dimensions and site levels on this drawing to be checked on site and any discrepancies reported to the designer prior to commencement of the work.
No dimensions to be scaled from this drawing. If in doubt ask.

PORTLAND.