



WORK TO BE FIGURED DIMENSIONS ONLY. CHECK DIMENSIONS ON SITE BEFORE COMMENCING WORK. ANY DISCREPANCIES TO BE REPORTED BACK TO THIS OFFICE. DO NOT SCALE FROM THIS DRAWING.

- PLEASE REFER TO OTHER DRAWINGS IN THE SERIES:
- xxxx/01-1 Existing Plans
 - xxxx/02-1 Proposed Plans
 - xxxx/03-1 Building Control Plans
 - xxxx/03-2 Building Control Notes
 - xxxx/04-1 Mechanical Services Layout
 - xxxx/05-1 Electrical Power & Communications
 - xxxx/06-1 Lighting Layout
 - xxxx/07-1 Heating and Ventilation Layout

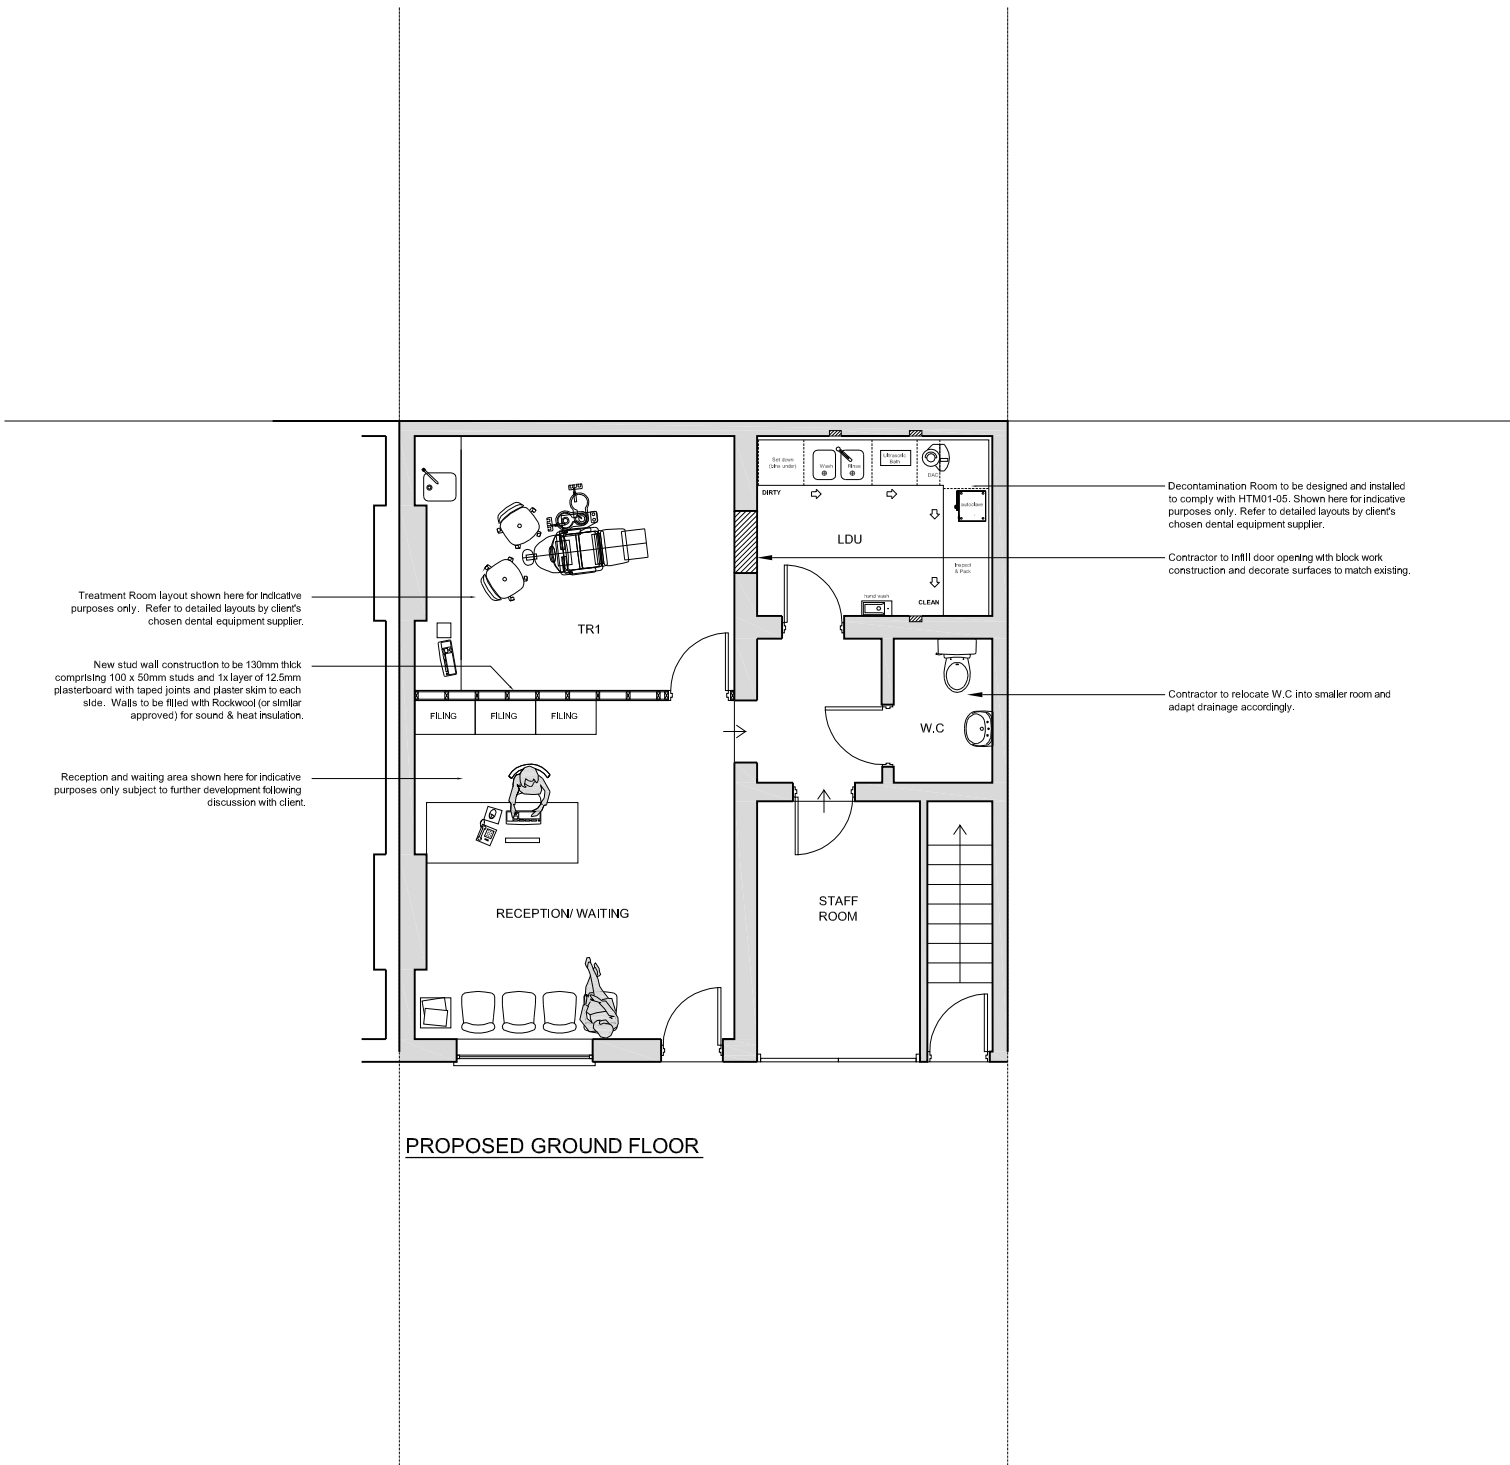

PROPOSED PLAN

 © Copyright Dental Design & Planning Consultants Ltd.



DDPC www.ddpc.co.uk
info@ddpc.co.uk
company no. 8102726

Client	
Dr M Hammond	
Job	
New Dental Practice	
Location	
19a Canfield Place London NW6 3BT	
Drawing	
Proposed Plan	
Date	04/09/2013
Scale	1:50 @ A1, 1:100 @ A3
Drawn	EK/ RL
Checked	GB
Drawing No.	

4 0 1 6 / 0 2 - 1