



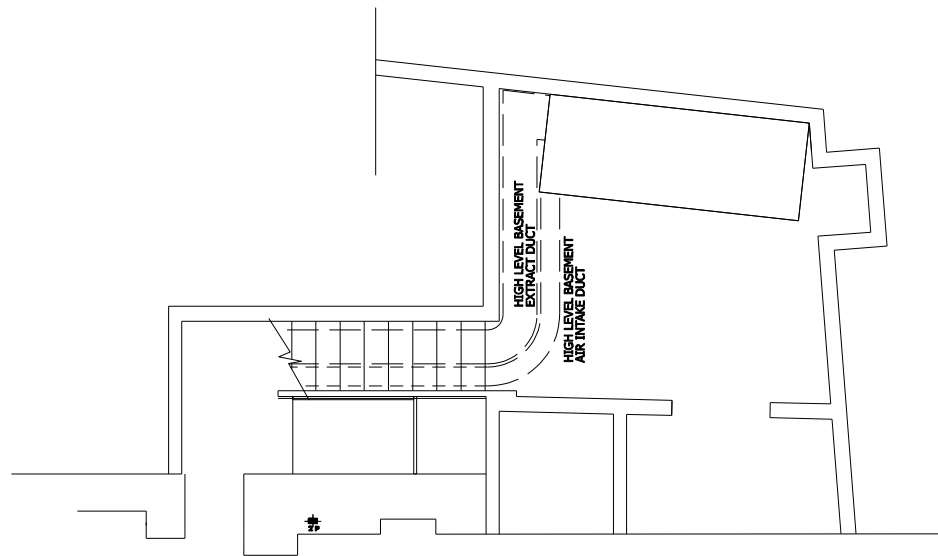

BASEMENT PLAN PROPOSED DUCT LAYOUT

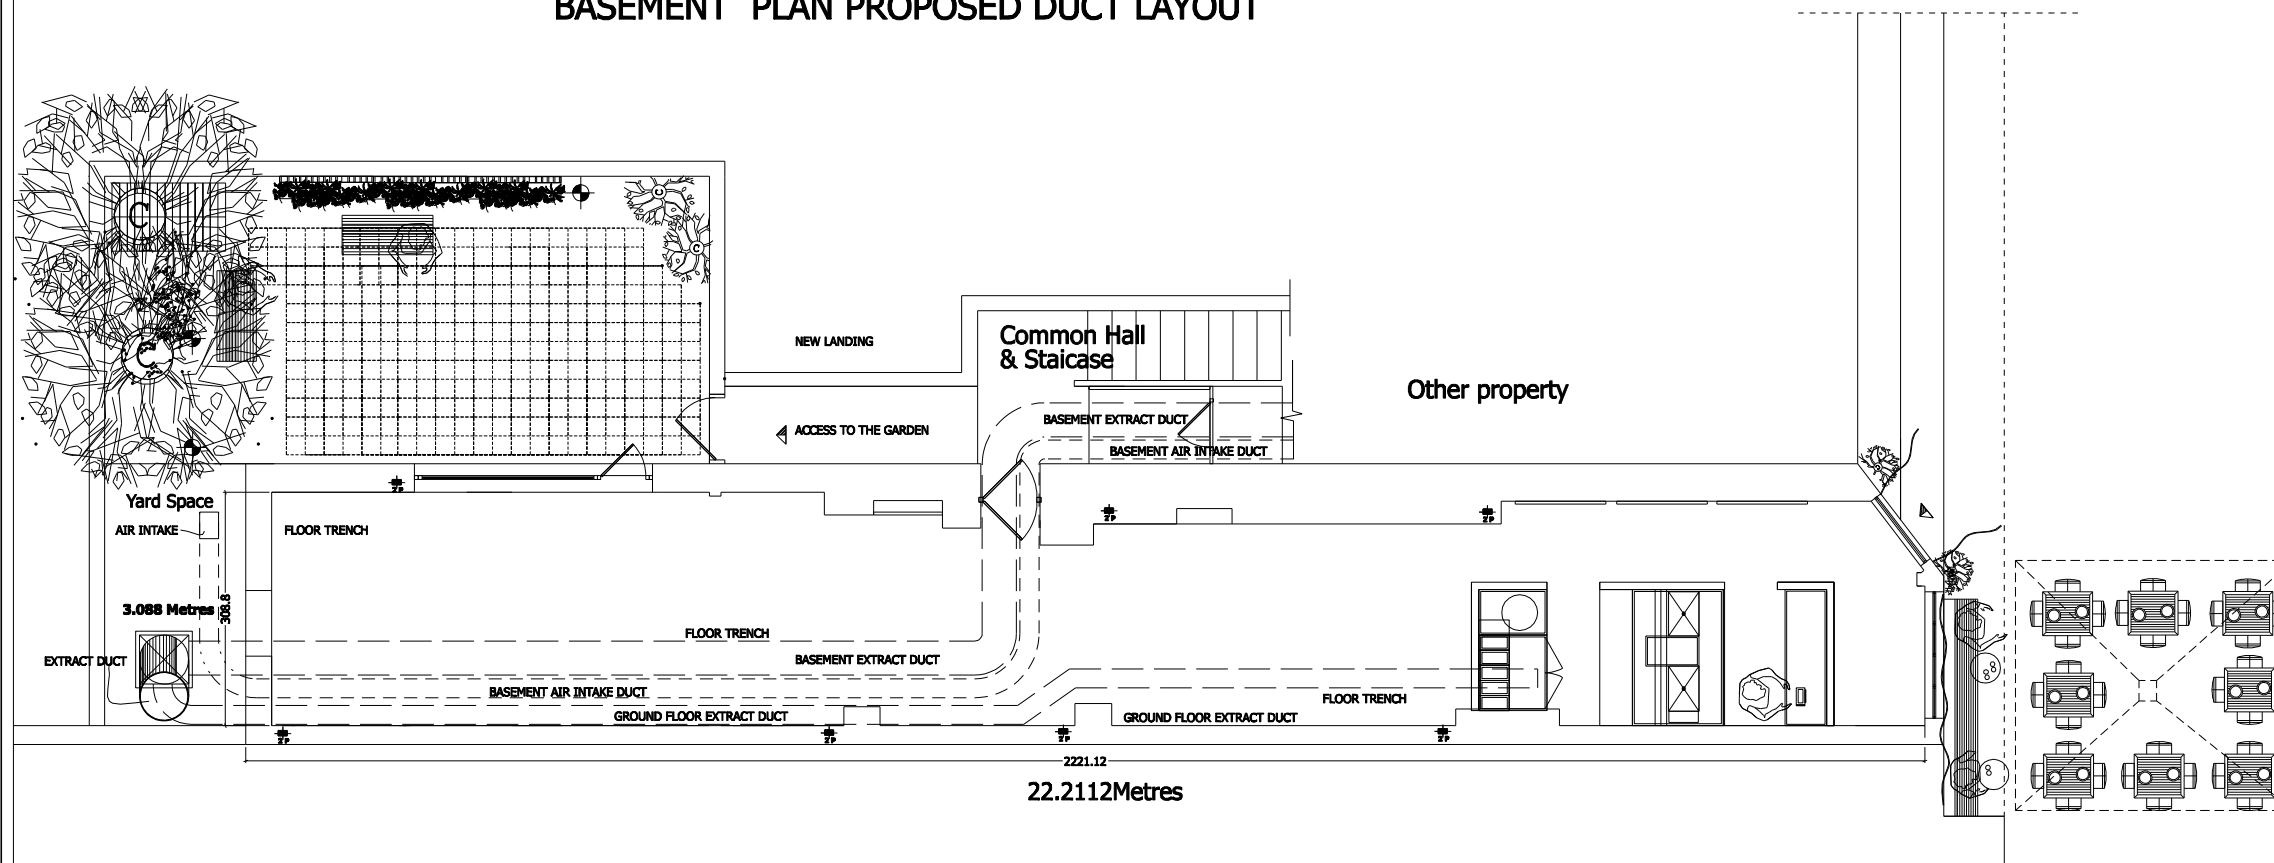

GROUND FLOOR PLAN PROPOSED DUCT LAYOUT

LIGHTHOUSE

CHARTERED ARCHITECTS AND DESIGNERS
LONDON GLASGOW BELFAST

261 FINCHLEY ROAD
HAMPSTEAD
LONDON N18 7AA
Tel: 0760 157 2004
Fax: +44 207 794 4291

Conditions
1. This drawing is the property of Lighthouse and is issued only for the purpose stated below.
2. All dimensions and conditions must be checked on site and any discrepancies must be reported immediately to Lighthouse.
3. All materials must be erected, installed and fixed according to manufacturers instructions.
Approved:
The signatures below confirm approval of the drawing by the client and contractors.

client approval
contractor approval

Client

MR. MOLLURA

Project

71 HAMPSTEAD HIGH STREET

Title

PROPOSED GROUND FLOOR PLAN
DUCTWORK & KITCHEN LAYOUT

Scale

1:100 @ A3

Date

09/08/13

Drawing Number

HH 21

Issued only for:

PLANNING

Rev

Rev Description

Sig Date