

TPS

Taylor Project Services LLP

**3 Gower Street
London, WC1B 3HB**

PLANNING

Mechanical Services




THE BEDFORD ESTATES


Revision A


July 2013

Taylor Project Services LLP
No1 Cornhill
London EC3V 3ND
Tele: 020 7743 6602

GENERAL NOTES

 TO BE STRIPPED OUT

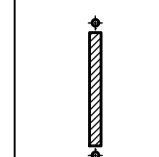 RADIATOR

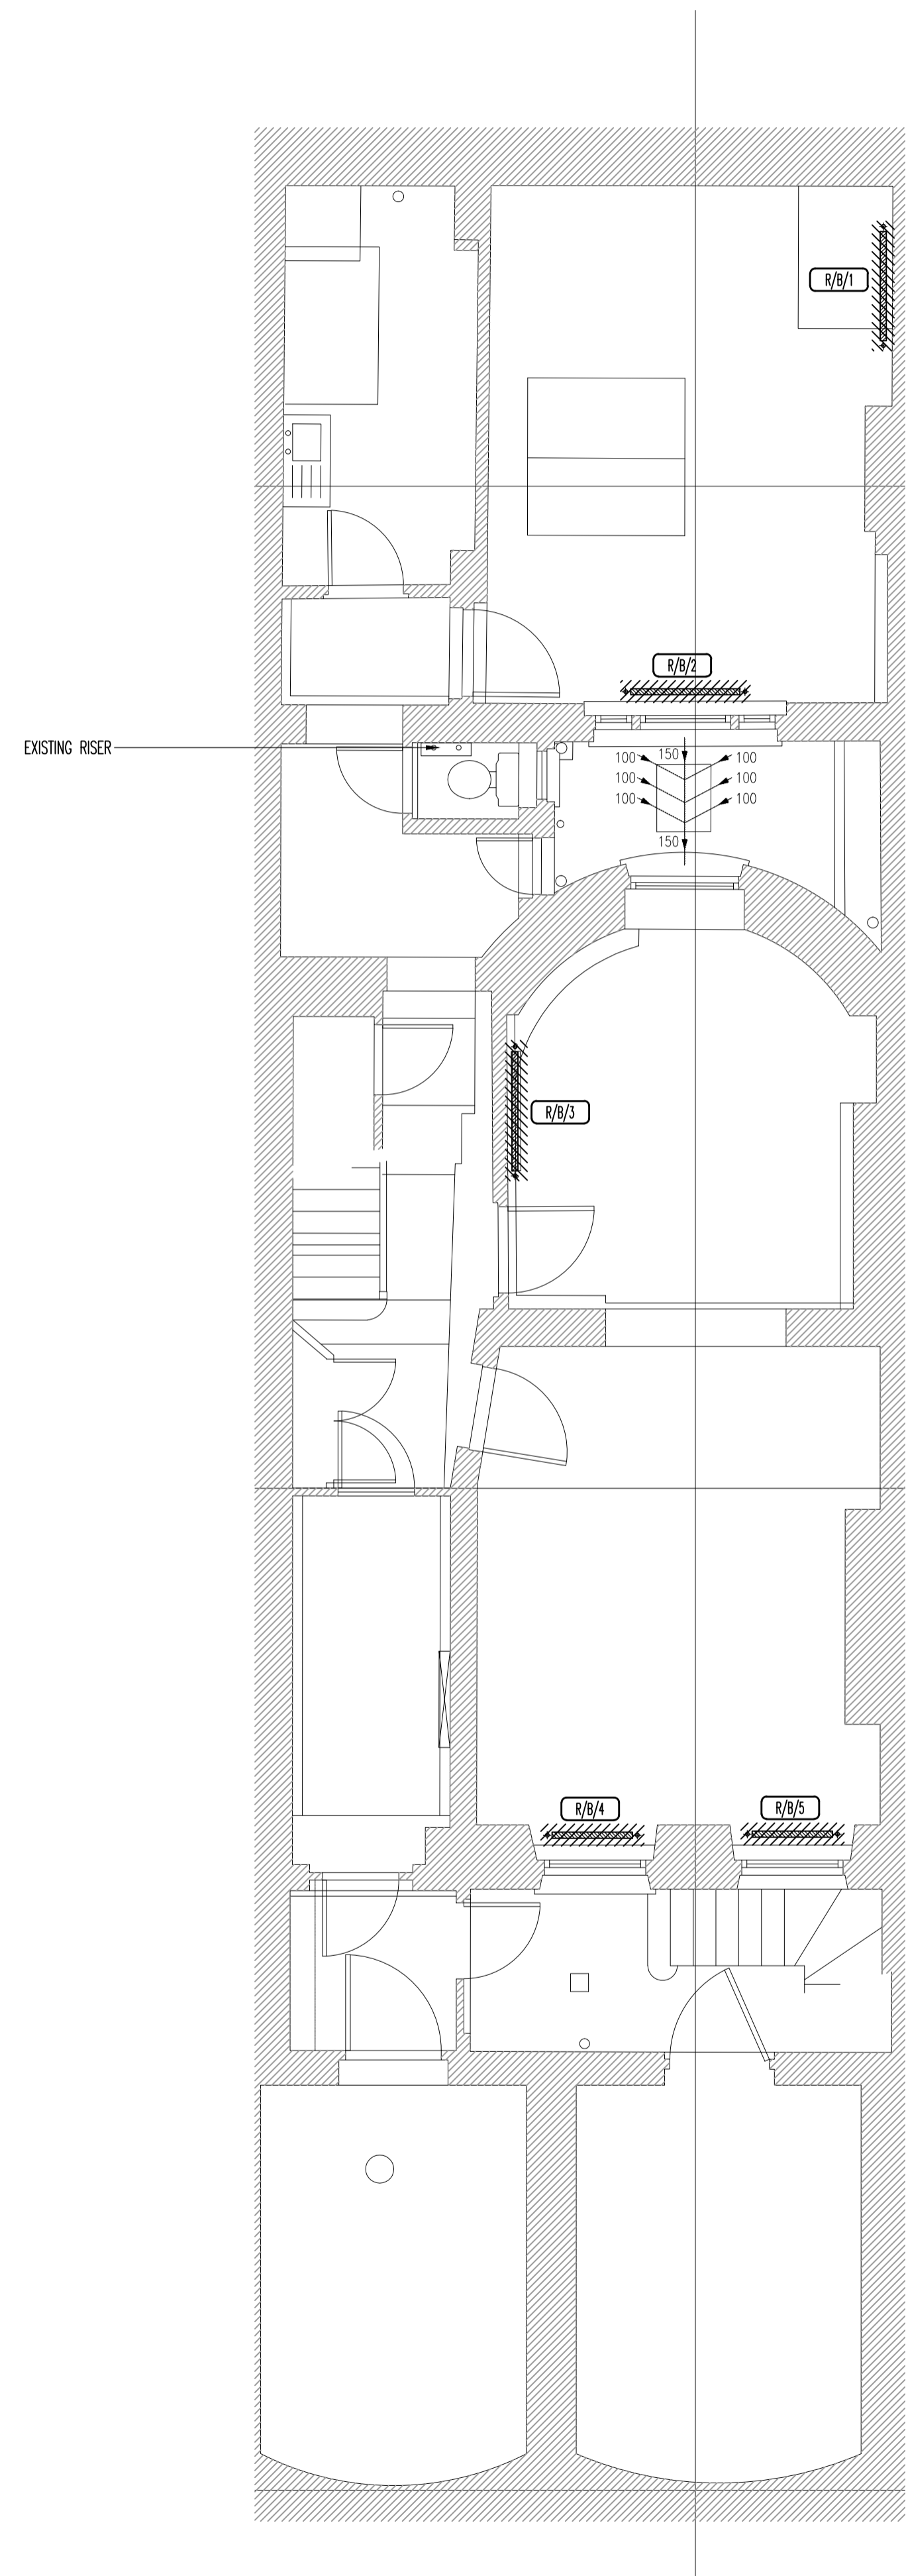

PLANNING


Rev	Date	Description
A	JUL.13	LAYOUTS UPDATED EXISTING RISER SHOWN & RE-USED
0	FEB.13	PLANNING ISSUE

TPS

Taylor Project Services LLP

No.1 Cornhill
London, EC3V 3ND
Tel 020 7743 6602
www.taylorprojectservices.com

Client:



THE BEDFORD ESTATES
29a Montague Street
London
WC1B 5JL
Tel: 020 462 2865
Fax: 020 255 1729

Project
3 GOWER STREET
LONDON
WC1

Drawing Title
BASEMENT LEVEL
EXISTING SERVICES LAYOUT

Scale 1:50 @ A1 Date 07.02.13
Drawn L.R. Checked G.N.T.

 
 
 


Drawing Status
PLANNING


Revision 0 A

Drawing No. TPS/3GS/B/E



GENERAL NOTES

-  VRV UNIT POSITION
-  ELECTRIC HEATER
-  CONDENSER
-  REFRIGERANT PIPEWORK RUN
-  VRV UNIT BS BOX

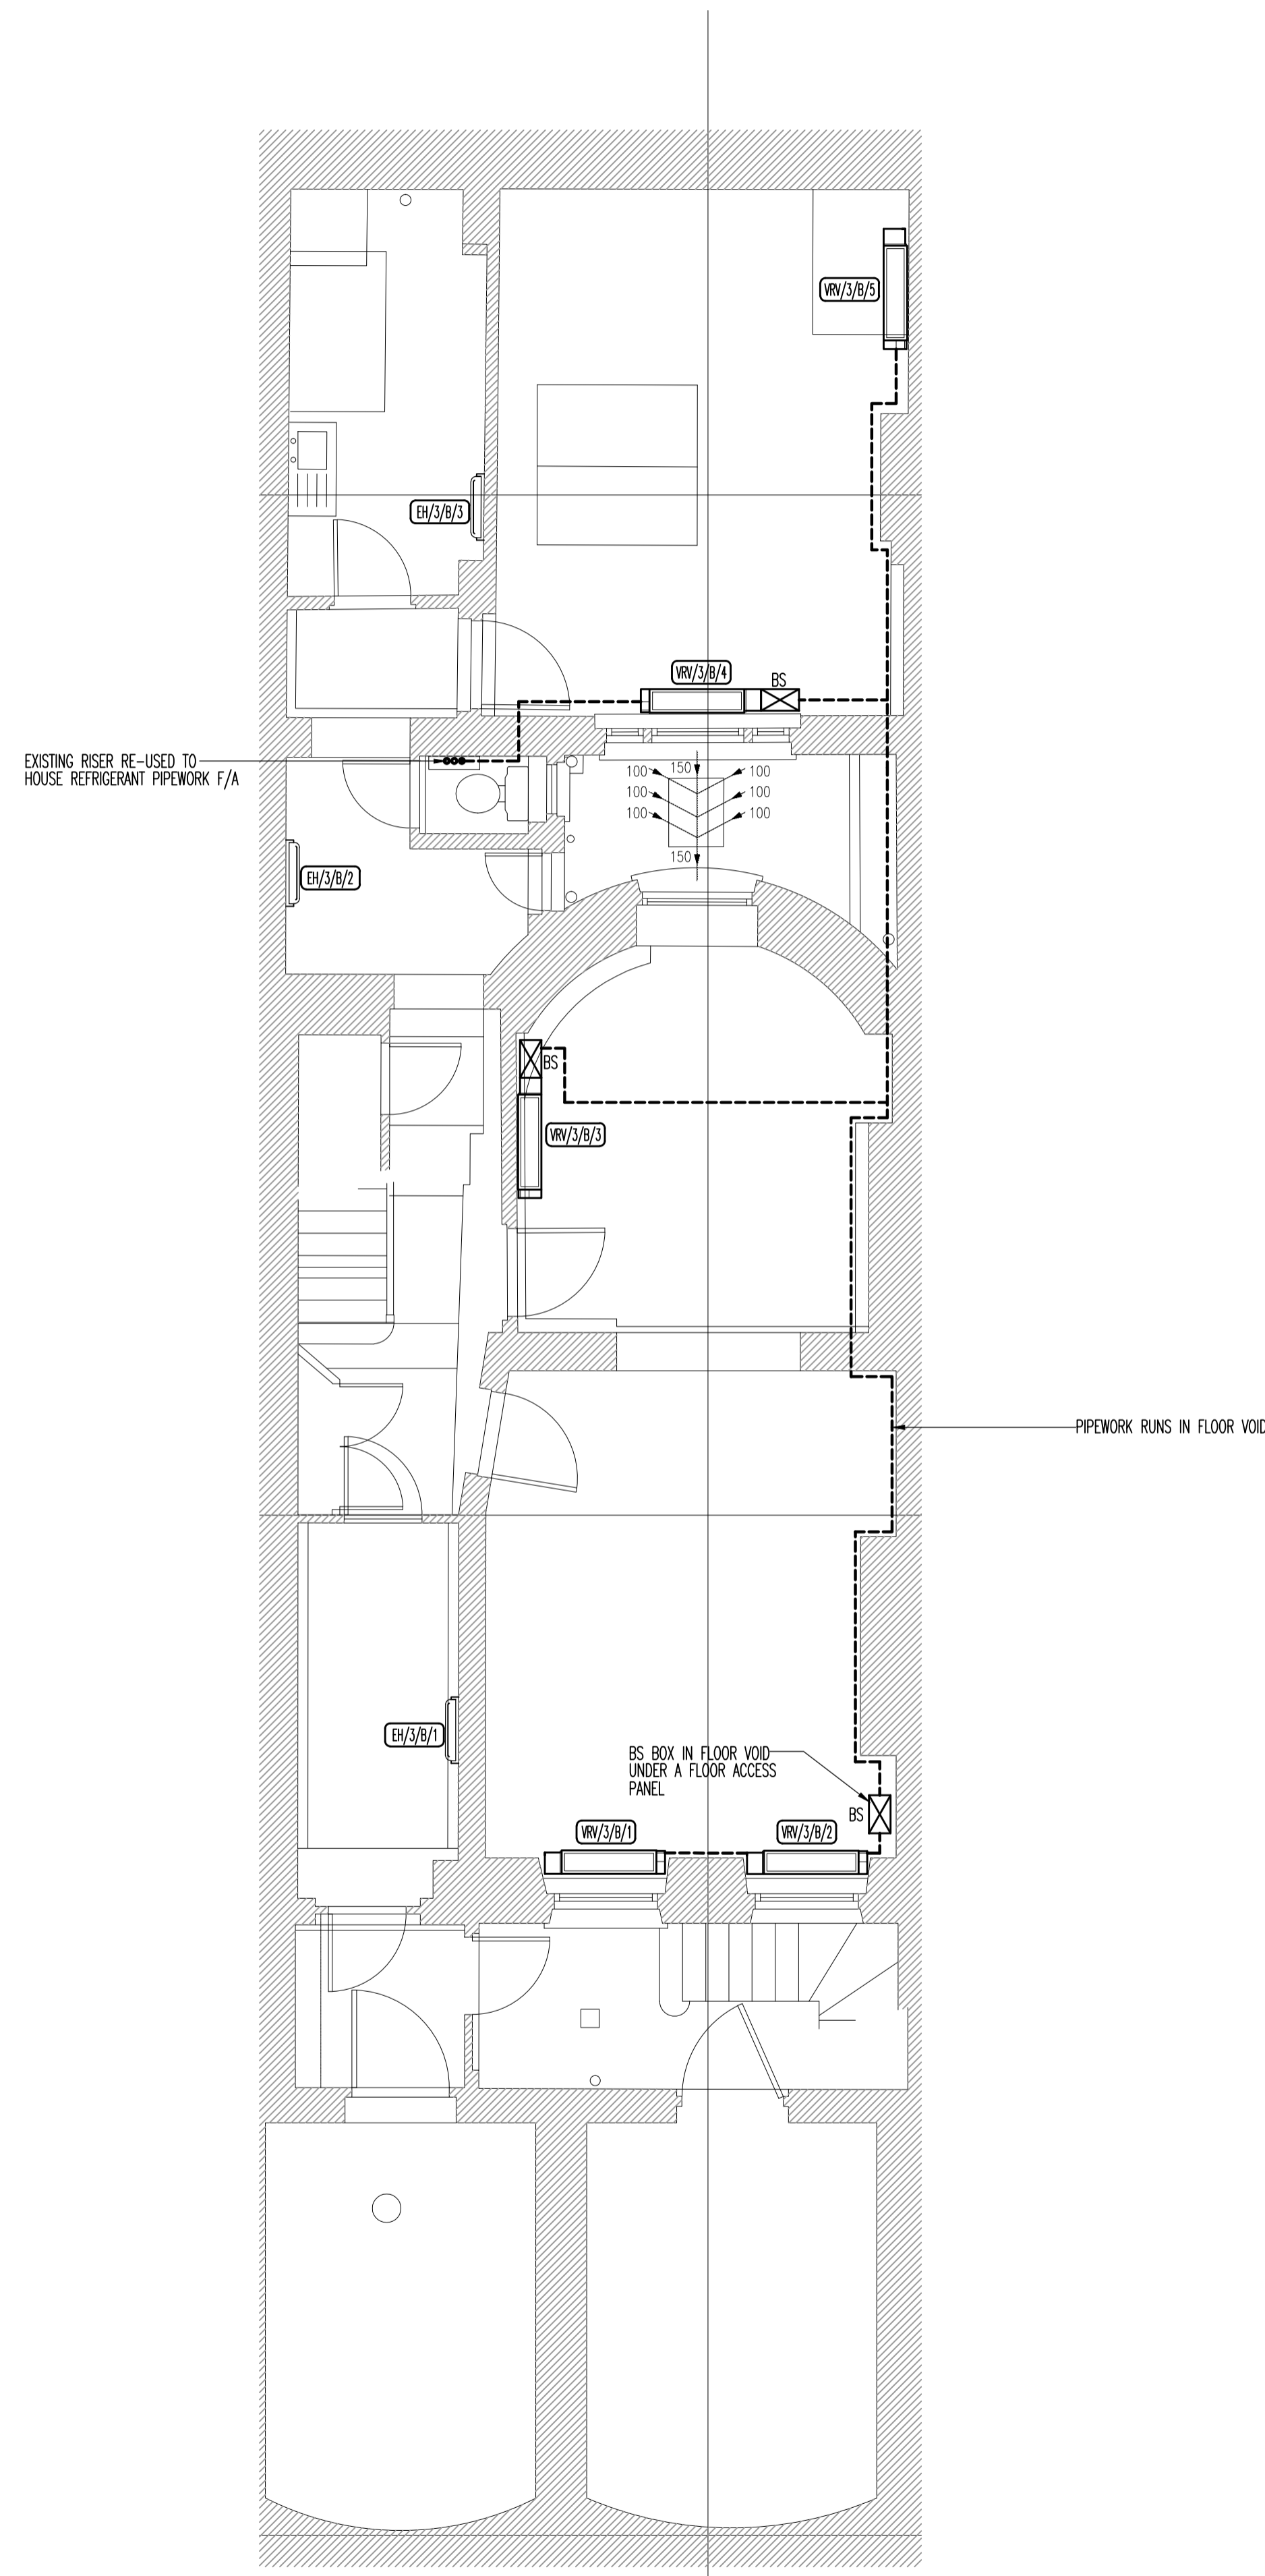

PLANNING


Rev	Date	Description
A	JUL.13	LAYOUTS UPDATED EXISTING RISER SHOWN & RE-USED
0	FEB.13	PLANNING ISSUE

TPS

Taylor Project Services LLP

No.1 Cornhill
London, EC3V 3ND
Tel: 020 7743 6602
www.taylorprojectservices.com

Client:



THE BEDFORD ESTATES
29a Montague Street
London
WC1B 5JL
Tel: 0771 466 2865
Fax: 0771 286 1729

Project
**3 GOWER STREET
LONDON
WC1**

Drawing Title
**BASEMENT LEVEL
PROPOSED
VRV POSITIONS**

Scale: 1:50 @ A1 Date: 07.12.12
Drawn: L.R. Checked: G.N.T.



Drawing Status: **PLANNING**

Revision: 0 A

Drawing No.: **TPS/3GS/B/VRV/P**



GENERAL NOTES

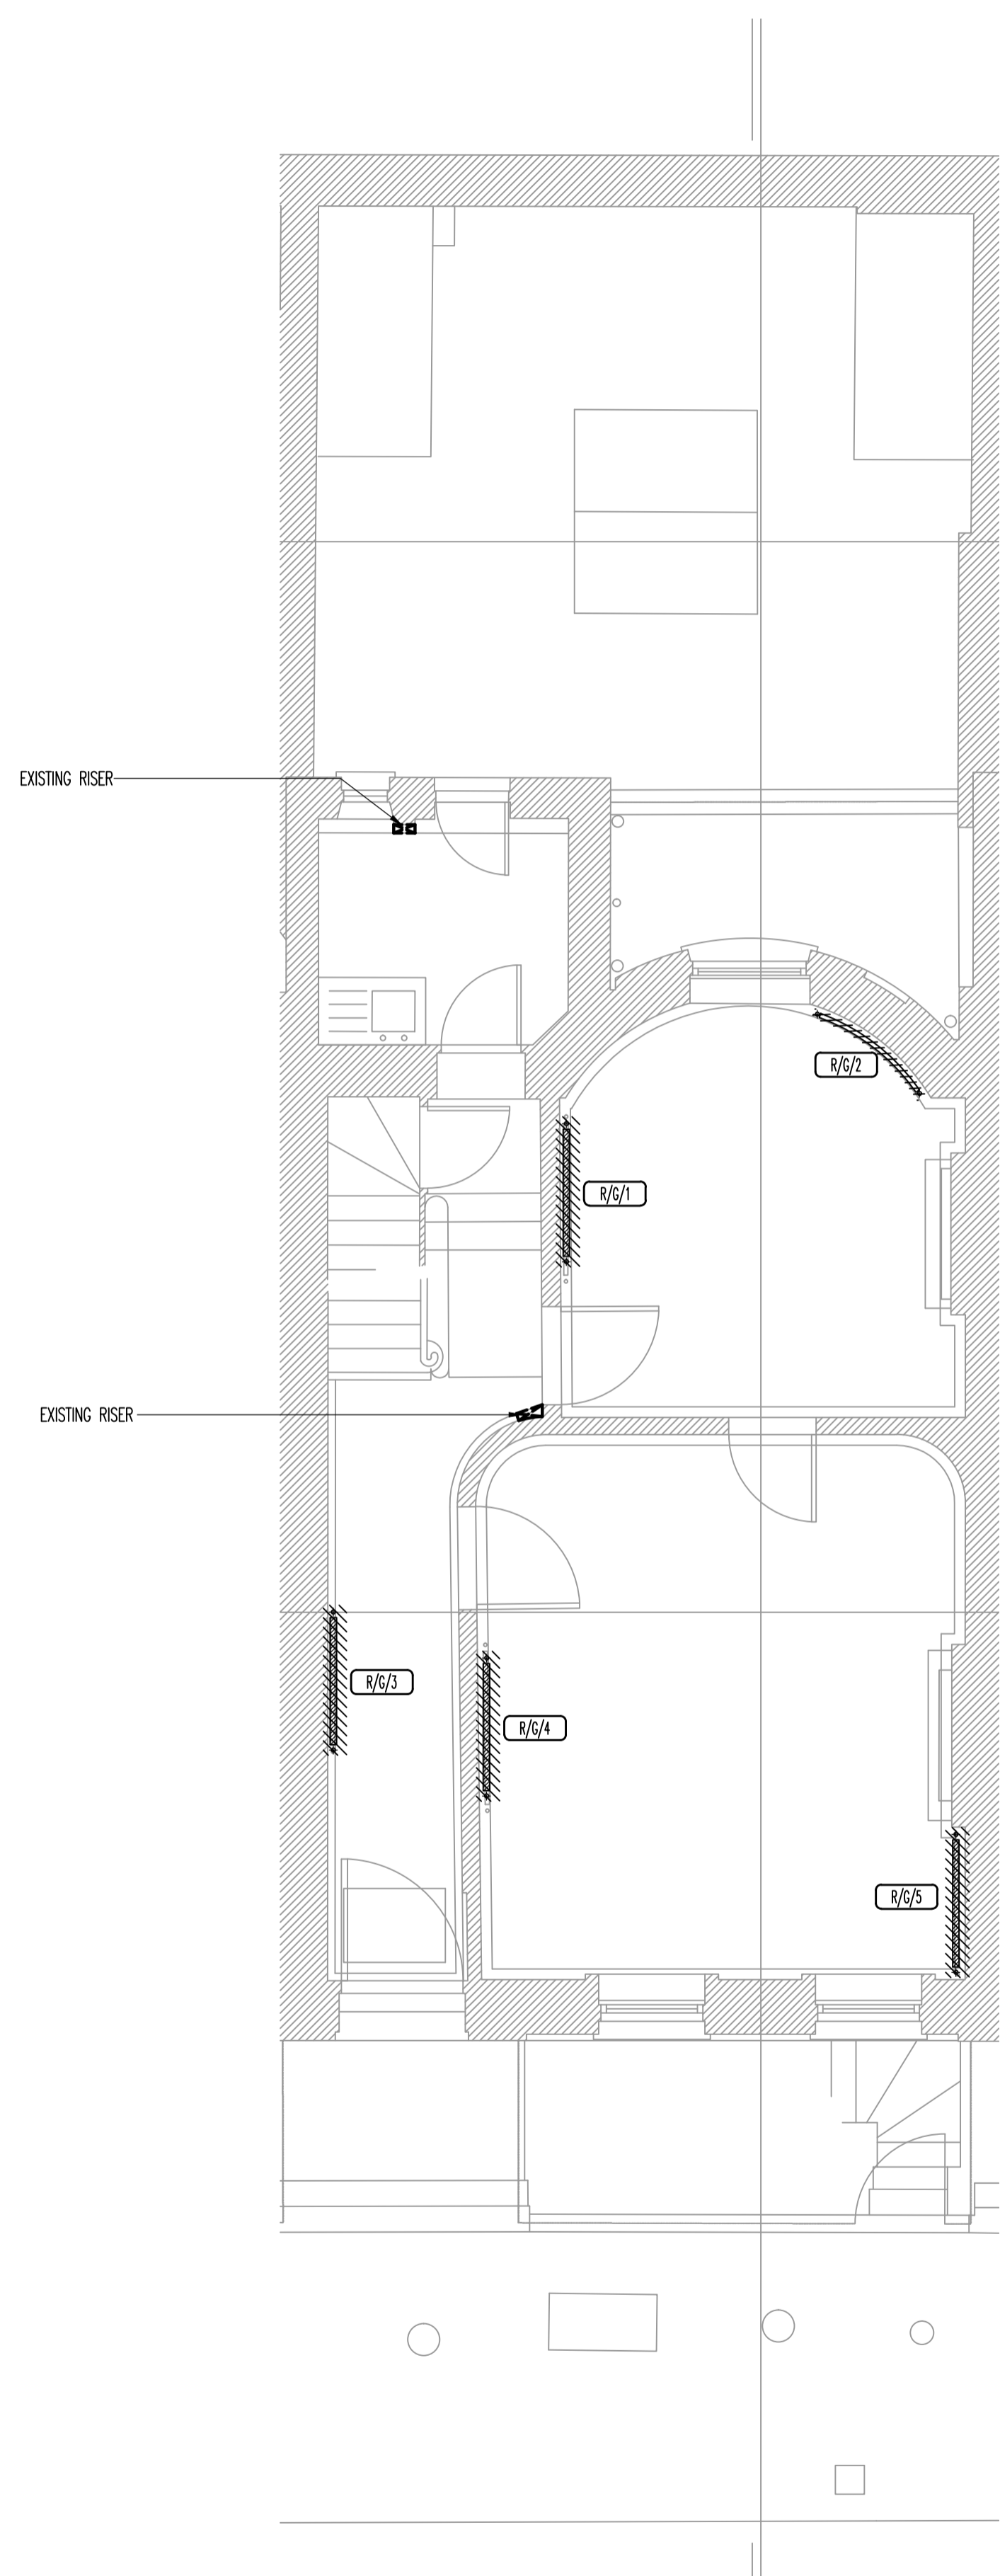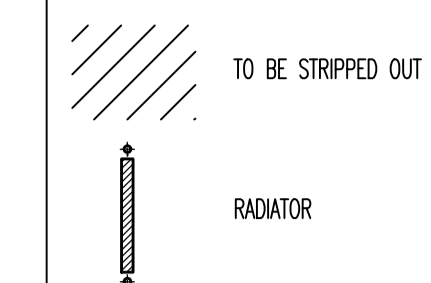

PLANNING


Rev	Date	Description
A	JUL.13	COLOUR ADDED TO CONDENSER UNIT EXISTING RISERS SHOWN & RE-USED
0	FEB.13	PLANNING ISSUE

TPS

Taylor Project Services LLP

No.1 Cornhill
London, EC3V 3ND
Tel 020 7743 6602
www.taylorprojectservices.com

Client:



THE BEDFORD ESTATES
29a Montague Street
London
WC1B 5SL
Tel: 0771 466 2865
Fax: 0771 266 1709

Project
3 GOWER STREET
LONDON
WC1


Drawing Title
GROUND FLOOR
EXISTING SERVICES LAYOUT

Scale	1:50 @ A1	Date	07.02.13
Drawn	L.R.	Checked	G.N.T.






Drawing Status
PLANNING

Revision	0	A																		
----------	---	---	--	--	--	--	--	--	--	--	--	--	--	--	--	--	--	--	--	--

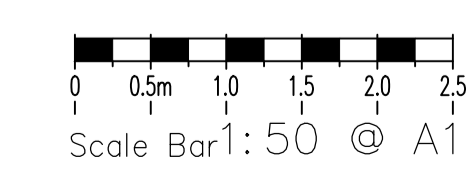Drawing No.
TPS/3GS/G/E

   

GENERAL NOTES

-  VRV UNIT POSITION
-  ELECTRIC HEATER
-  CONDENSER
-  REFRIGERANT PIPEWORK RUN
-  VRV UNIT BS BOX


PROPOSED CONDENSER POSITION ON BASEMENT ROOF
UNIT DIMS: 1300(L)x765(W)x1680(H)
UNITY TO BE RE-PAINTED - RAL 7013 (BROWN GREY)

EXISTING RISER RE-USED TO
HOUSE REFRIGERANT PIPEWORK
REFRIGERANT PIPEWORK T/B

EXISTING RISER RE-USED TO
HOUSE REFRIGERANT PIPEWORK

PIPEWORK RUNS IN FLOOR VOID

BS BOX IN FLOOR VOID
UNDER A FLOOR ACCESS
PANEL

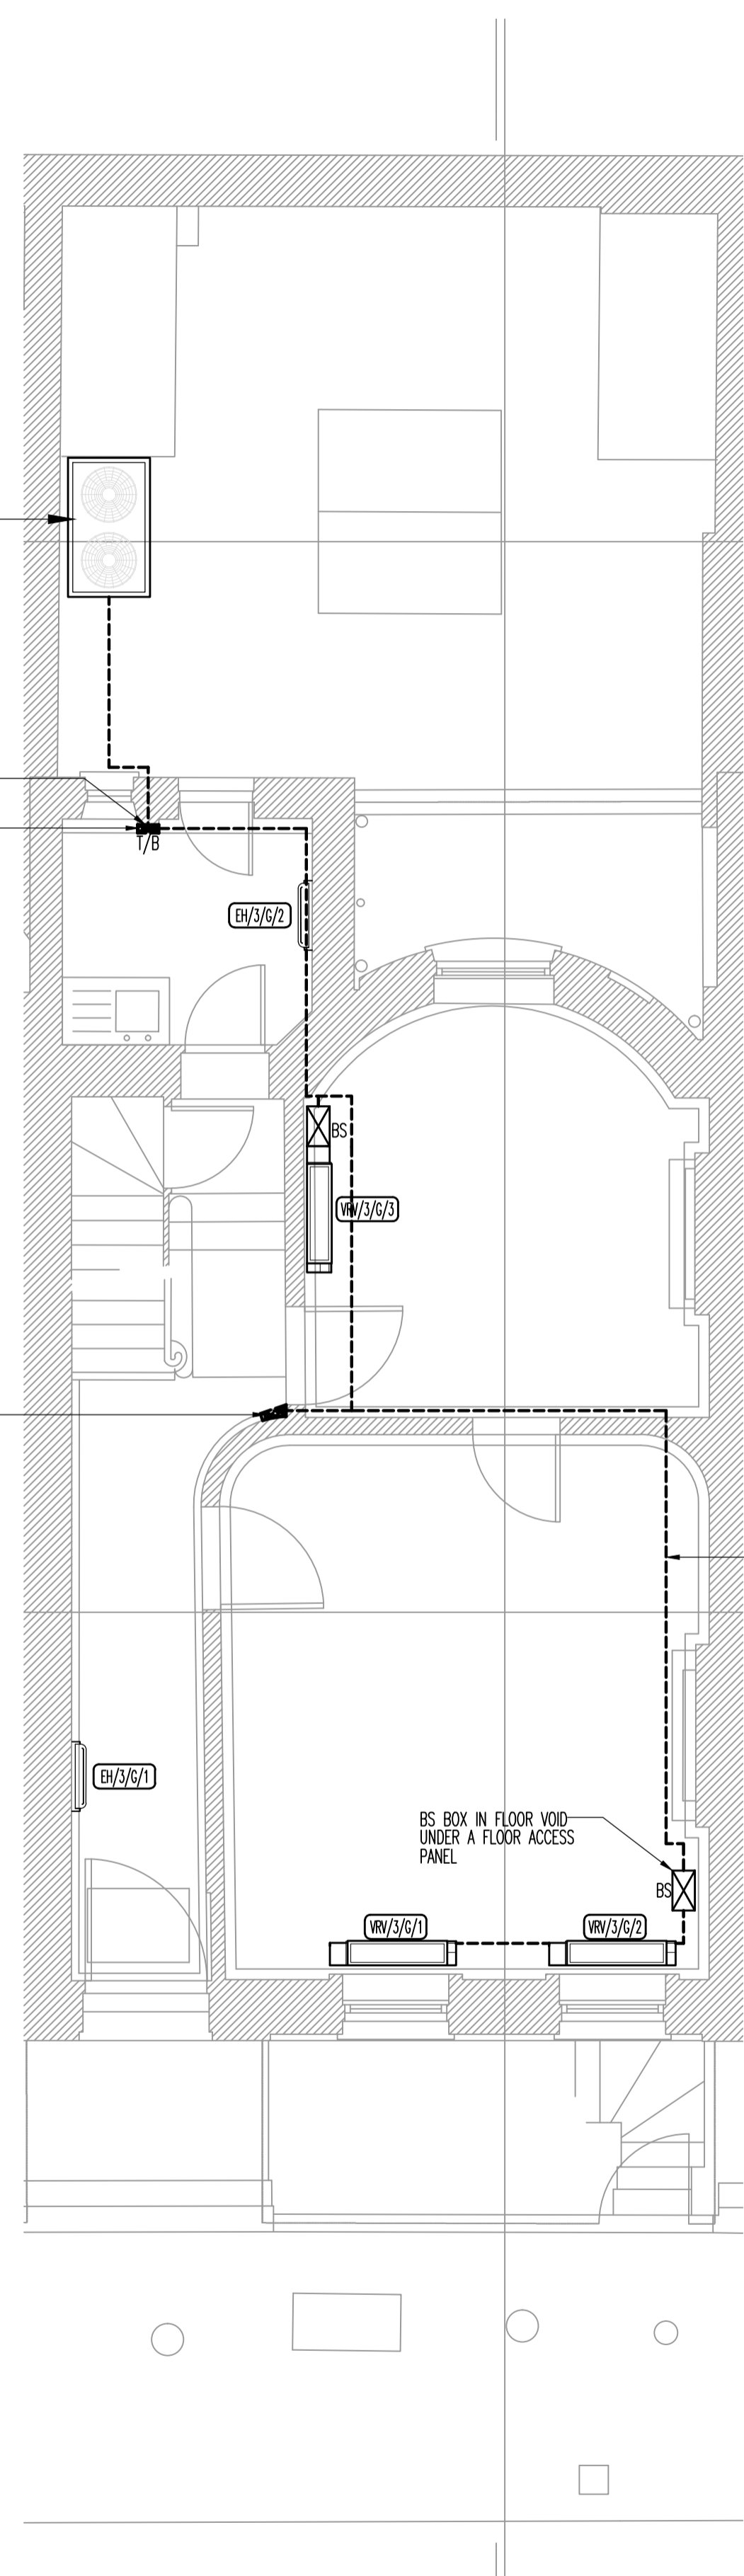

PLANNING


Rev	Date	Description
A	JUL.13	COLOUR ADDED TO CONDENSER UNIT EXISTING RISERS SHOWN & RE-USED
0	FEB.13	PLANNING ISSUE

TPS

Taylor Project Services LLP

No.1 Cornhill
London, EC3V 3ND
Tel: 020 7743 6602
www.taylorprojectservices.com

Client:



THE BEDFORD ESTATES
29a Montague Street
London
WC1B 5SL
Tel: 0771 486 2865
Fax: 0771 286 1709

Project
**3 GOWER STREET
LONDON
WC1**

Drawing Title
**GROUND FLOOR
PROPOSED
VRV POSITIONS**

Scale: 1:50 @ A1 Date: 07.02.13
Drawn: L.R. Checked: G.N.T.



Drawing Status: **PLANNING**

Revision: 0 A

Drawing No. **TPS/3GS/G/VRV/P**



GENERAL NOTES

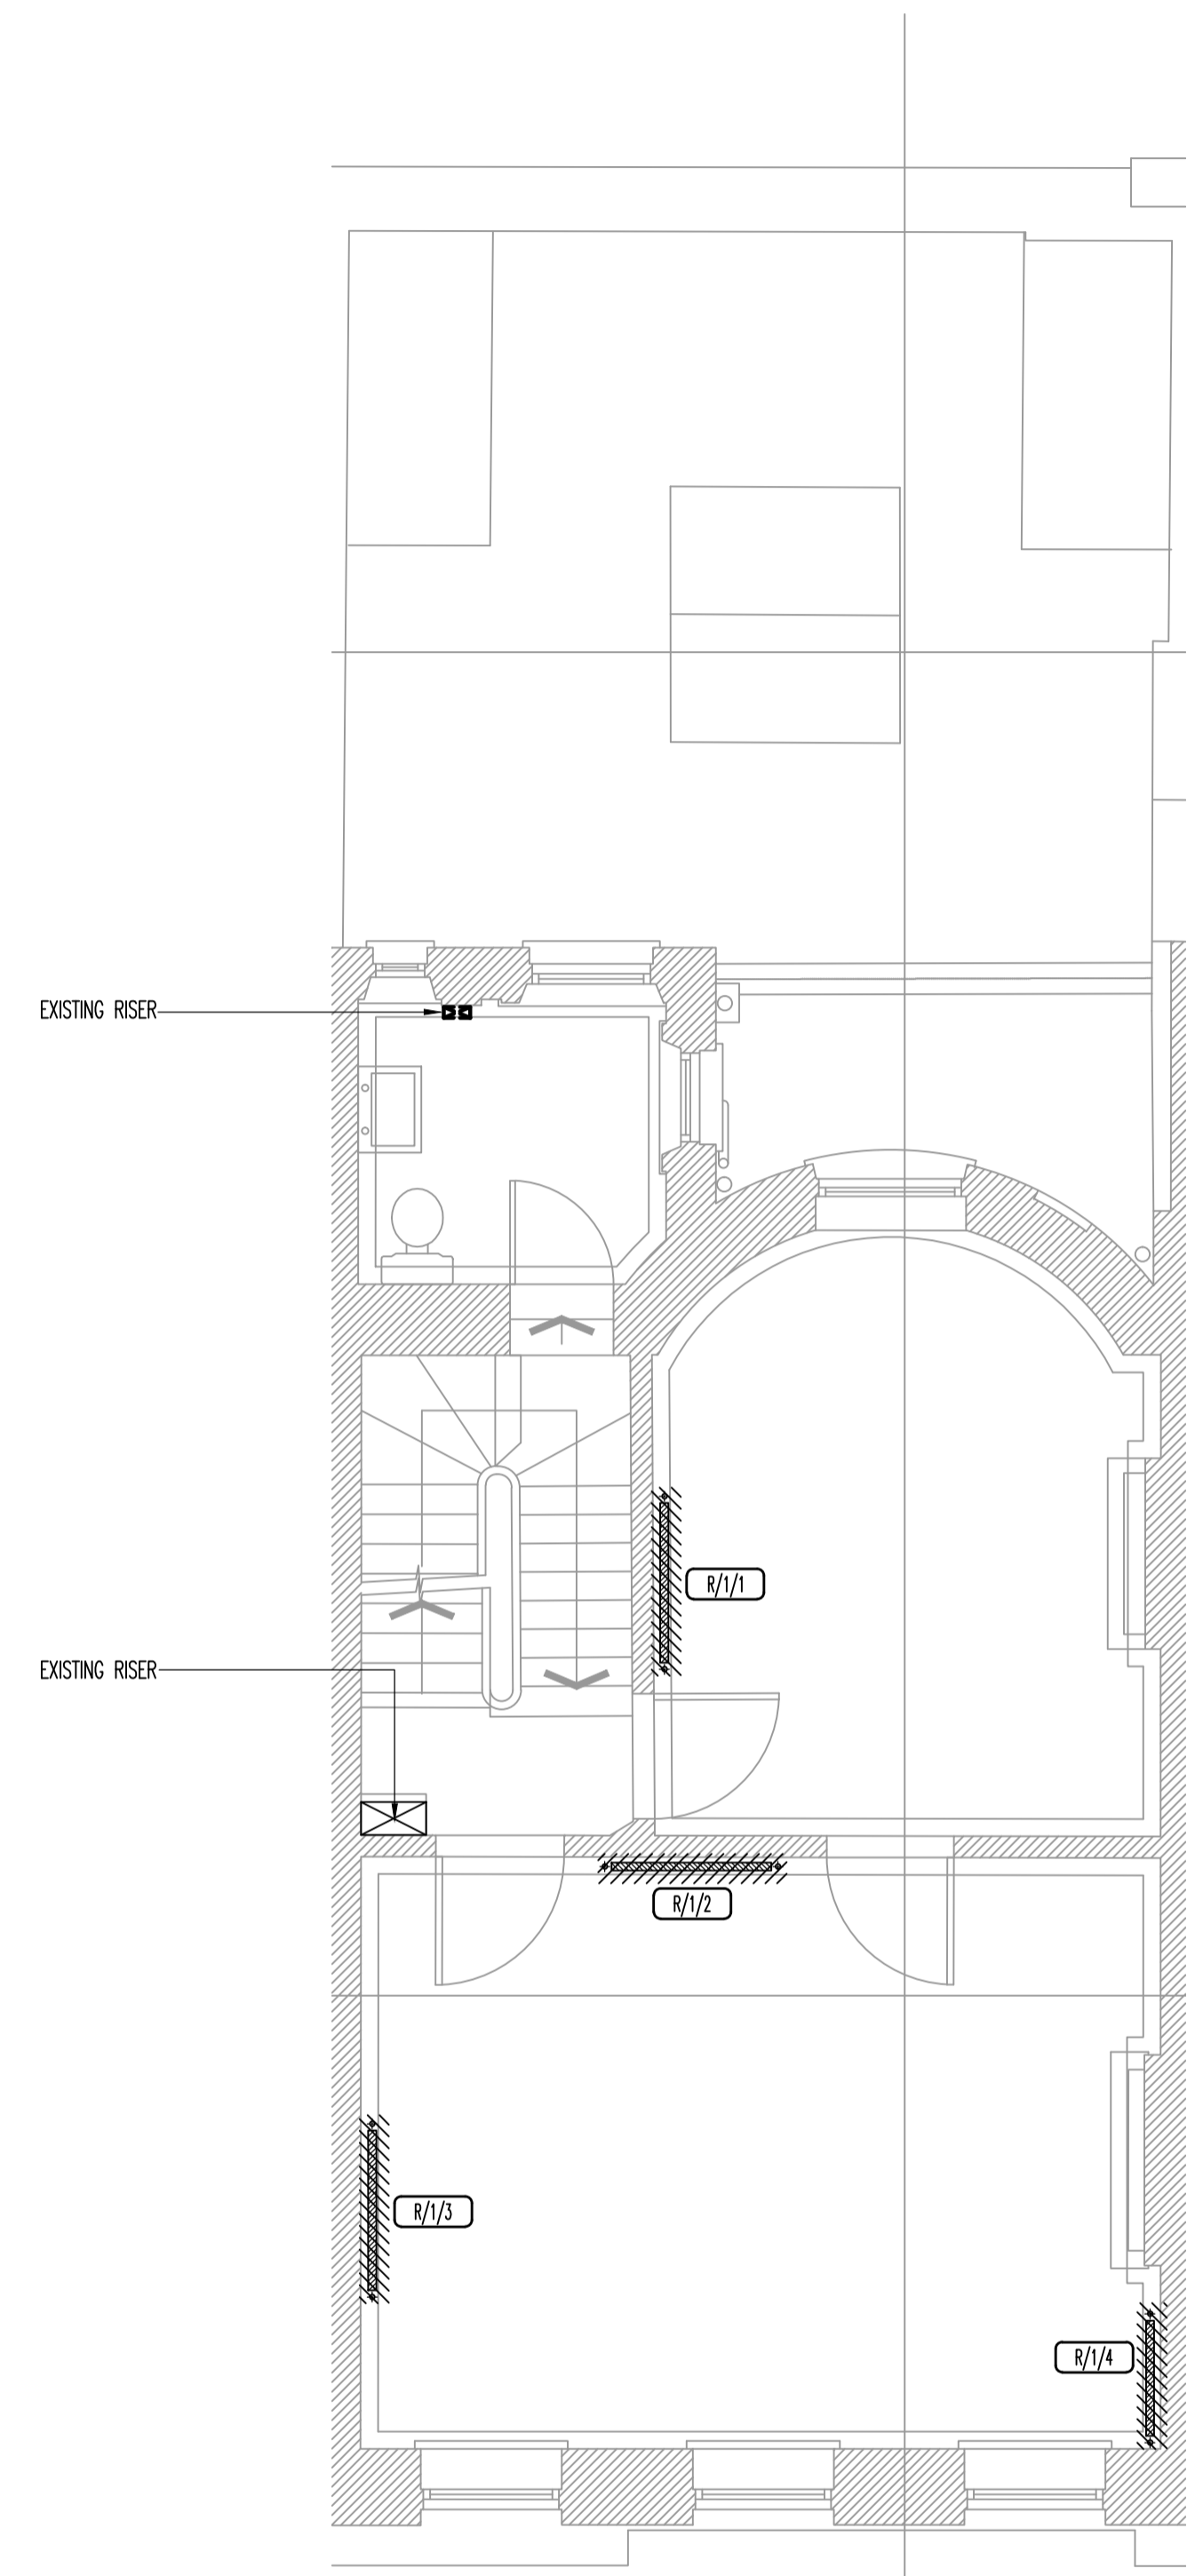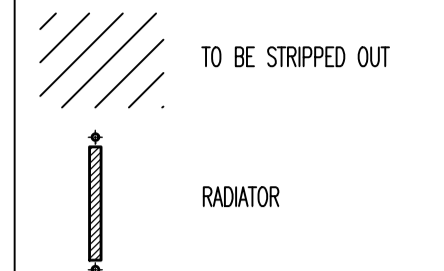

No.3 Gower Street

PLANNING

Rev	Date	Description
A	JUL.13	LAYOUTS UPDATED EXISTING RISER SHOWN & RE-USED
0	FEB.13	PLANNING ISSUE

TPS

Taylor Project Services LLP
 No.1 Cornhill
 London, EC3V 3ND
 Tel 020 7743 6602
 www.taylorprojectservices.com

Client:

29a Montague Street
 London
 WC1B 5SL
 Tel: 0771 406 2865
 Fax: 0771 205 1709

Project
**3 GOWER STREET
 LONDON
 WC1**

Drawing Title
**FIRST FLOOR
 EXISTING SERVICES LAYOUT**

Scale	1:50 @ A1	Date	07.02.13
Drawn	L.R.	Checked	G.N.T.


Drawing Status
PLANNING

Revision	0	A																		
----------	---	---	--	--	--	--	--	--	--	--	--	--	--	--	--	--	--	--	--	--

Drawing No.
TPS/3GS/1/E



GENERAL NOTES

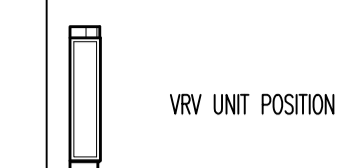

VRV UNIT POSITION



ELECTRIC HEATER




CONDENSER



REFRIGERANT PIPEWORK RUN



VRV UNIT BS BOX

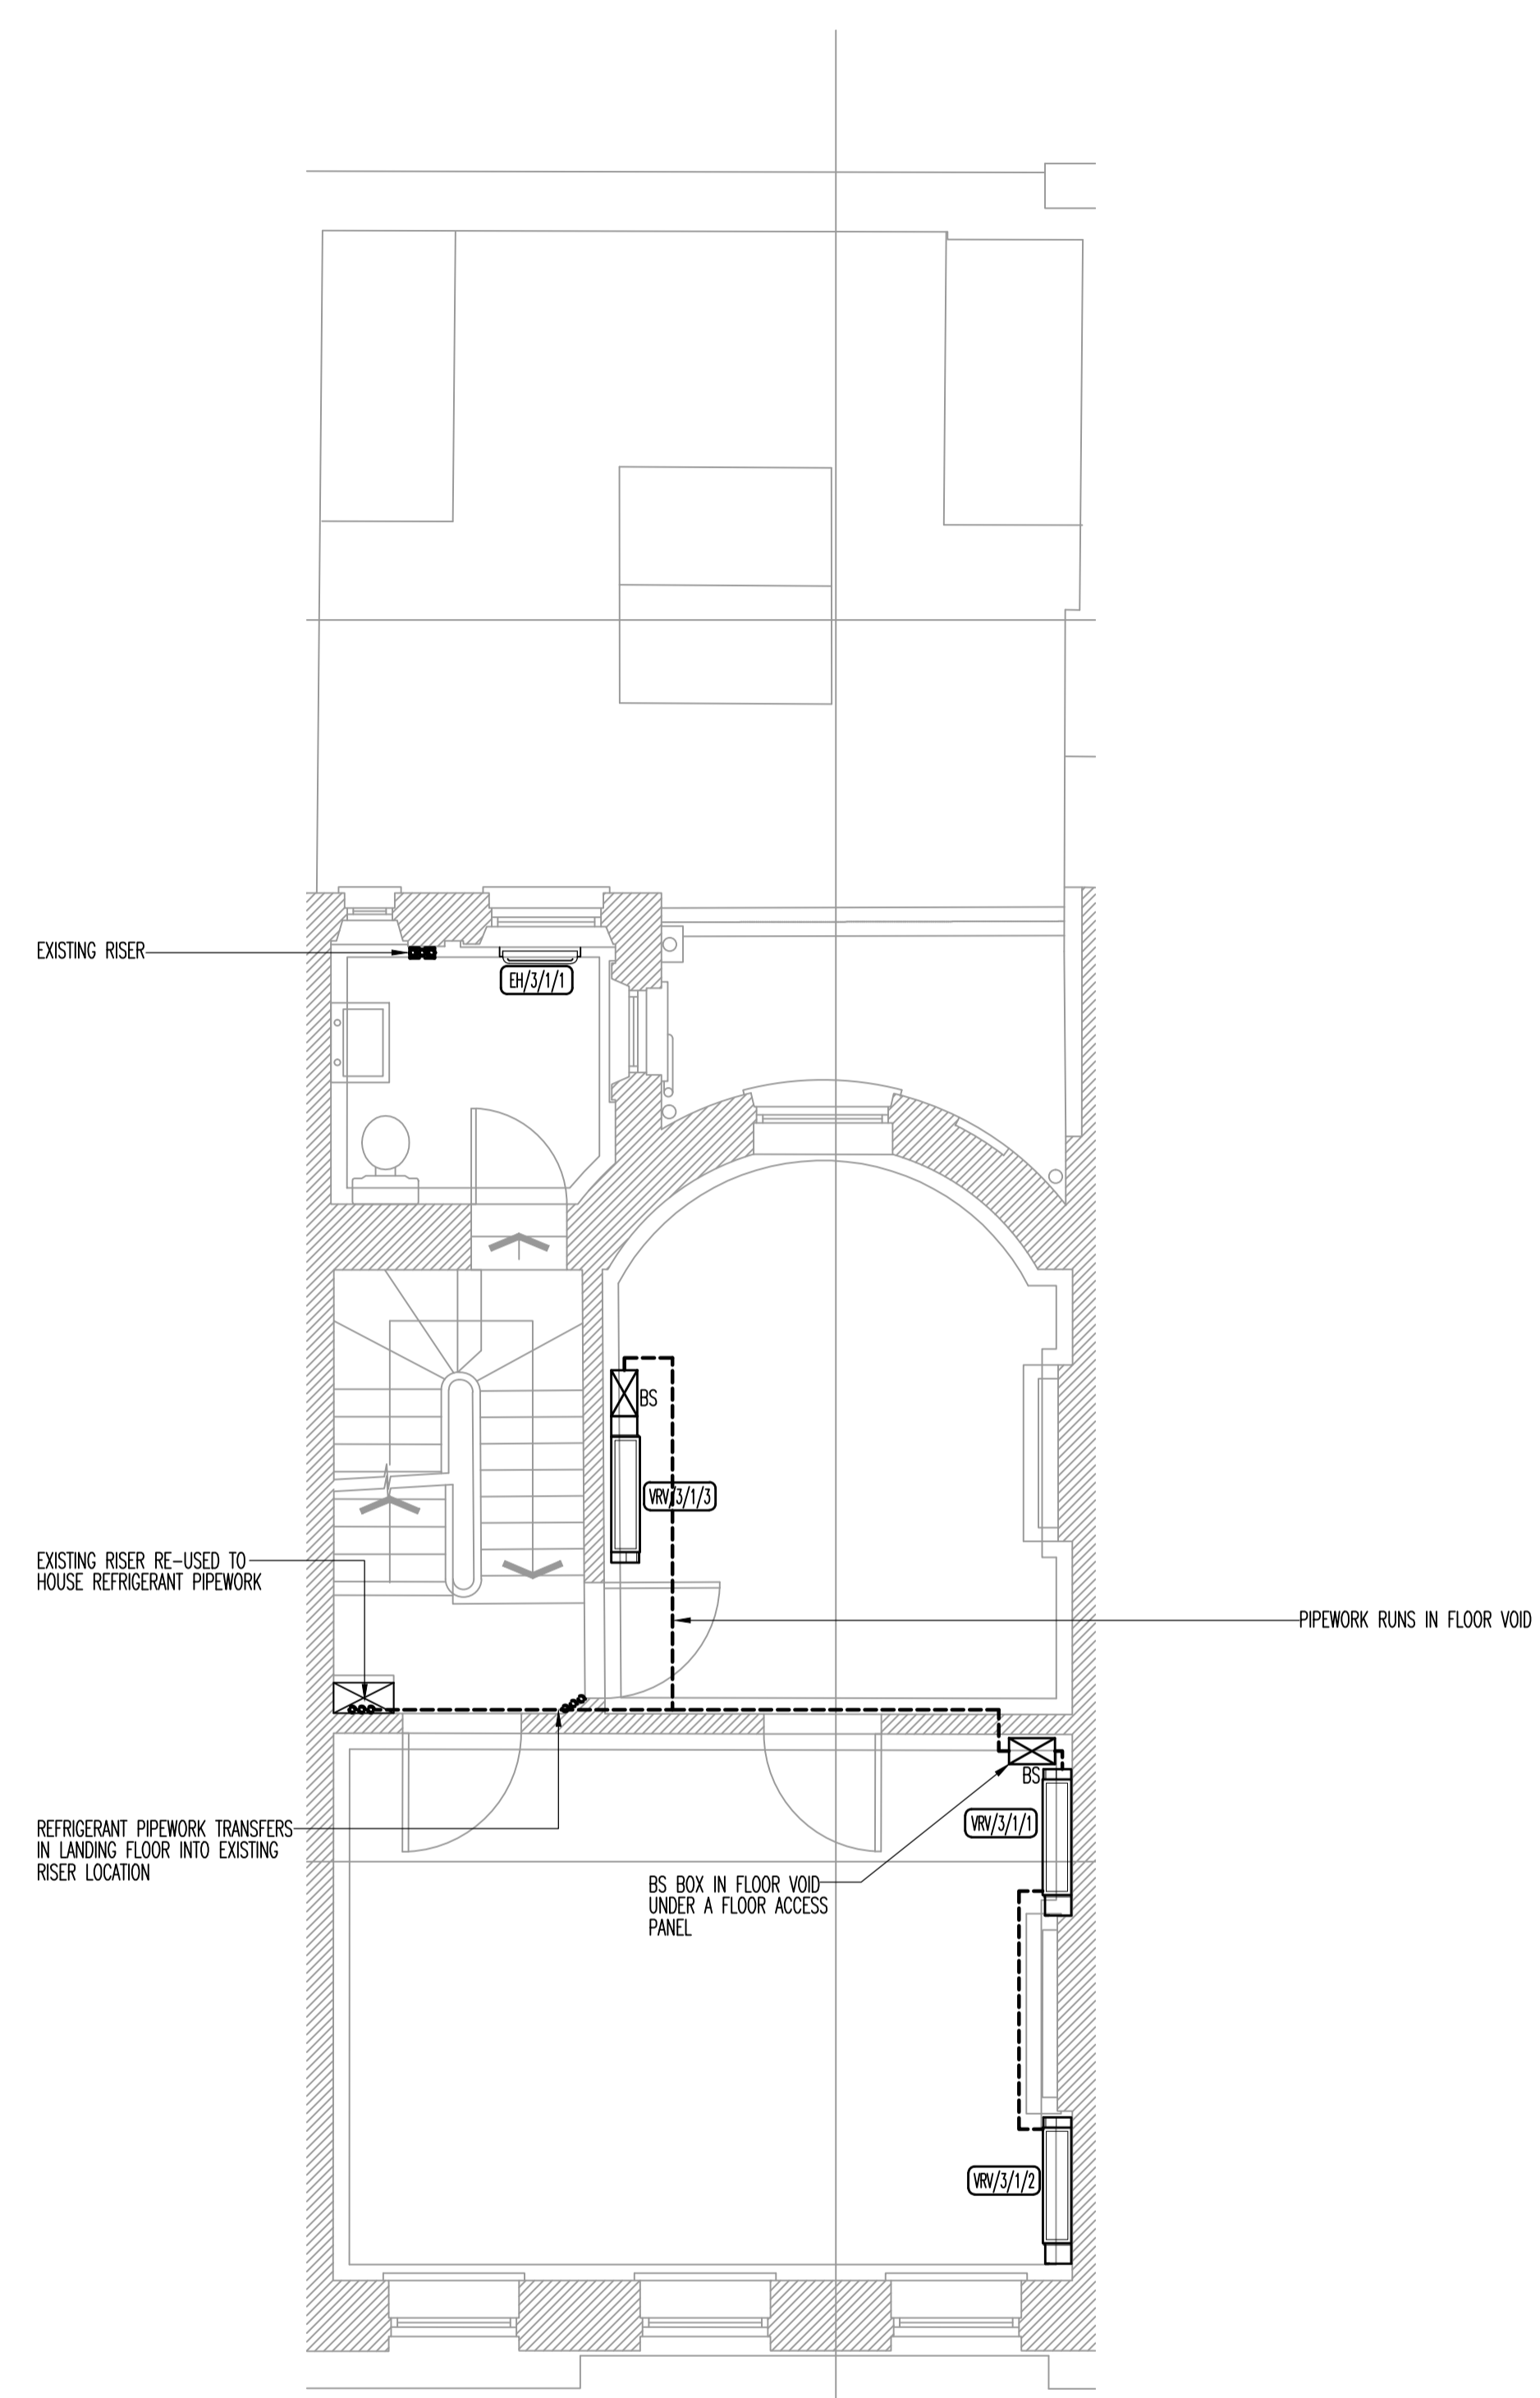

No.3 Gower Street

PLANNING


A	JUL.13	LAYOUTS UPDATED EXISTING RISER SHOWN & RE-USED
0	FEB.13	PLANNING ISSUE
Rev	Date	Description

TPS

Taylor Project Services LLP

No.1 Cornhill
London, EC3V 3ND
Tel: 020 7743 6602
www.taylorprojectservices.com

Client:



THE BEDFORD ESTATES
29a Montague Street
London
WC1B 5SL
Tel: 0771 486 2865
Fax: 0771 286 1709

Project
3 GOWER STREET
LONDON
WC1

Drawing Title
FIRST FLOOR
PROPOSED
VRV POSITIONS

Scale	1:50 @ A1	Date	07.02.13
Drawn	L.R.	Checked	G.N.T.


Drawing Status
PLANNING


Revision	0	A																	
----------	---	---	--	--	--	--	--	--	--	--	--	--	--	--	--	--	--	--	--


Drawing No. TPS/3GS/1/VRV/P



GENERAL NOTES

 TO BE STRIPPED OUT

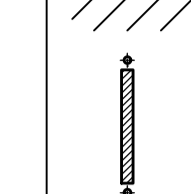 RADATOR

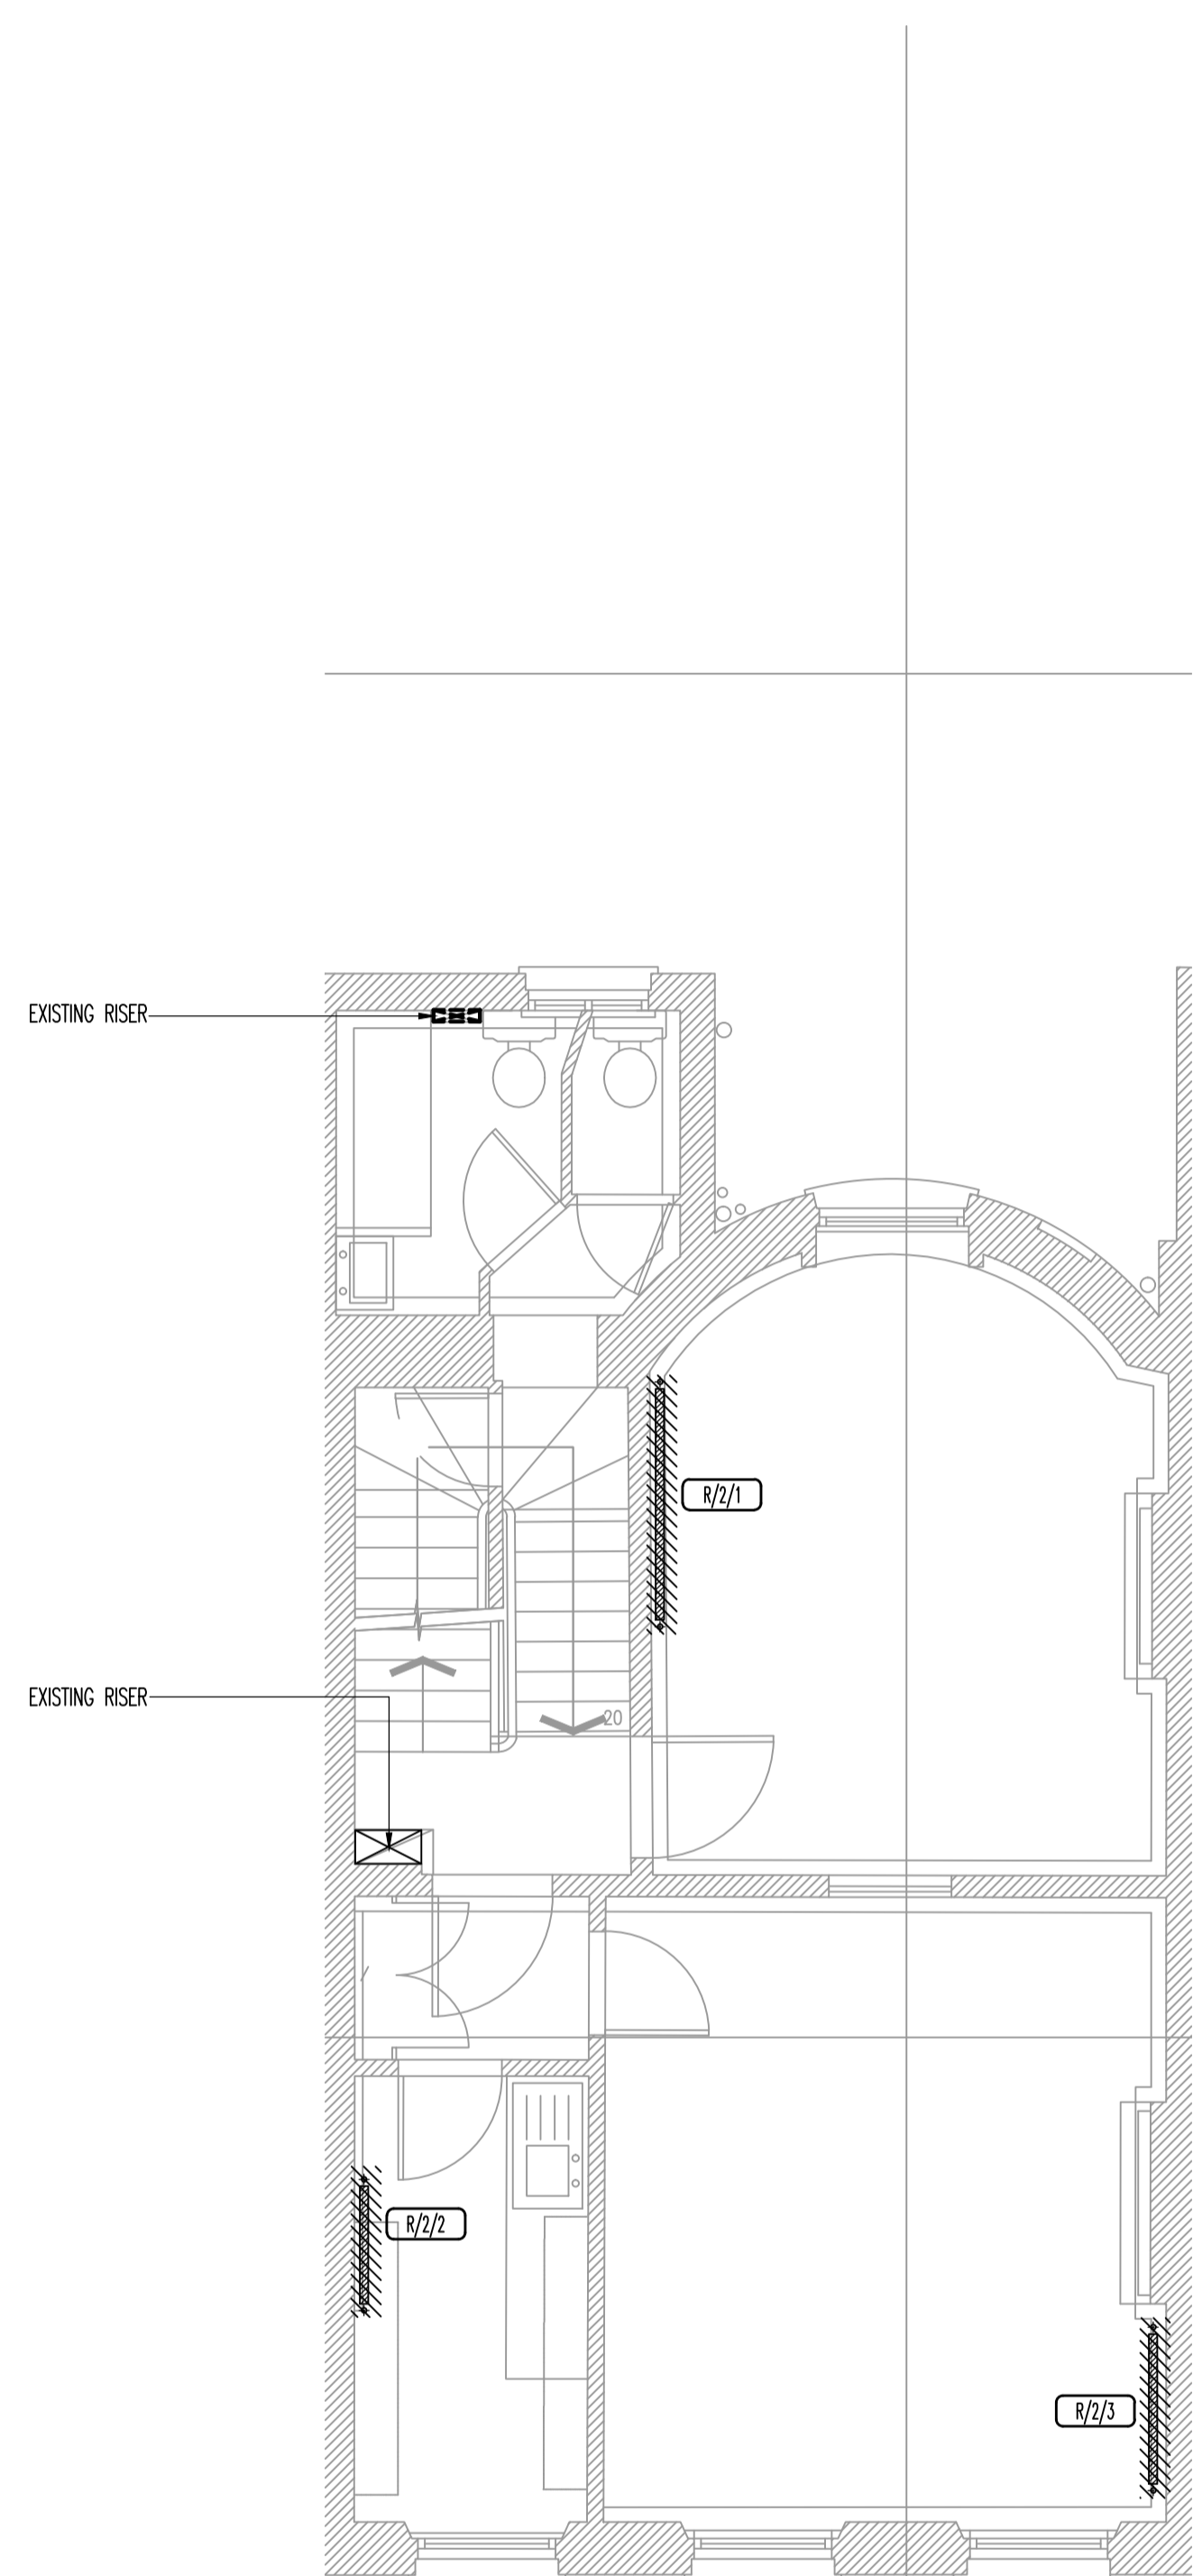

No.3 Gower Street

PLANNING


Rev	Date	Description
A	JUL.13	LAYOUTS UPDATED EXISTING RISER SHOWN & RE-USED
0	FEB.13	PLANNING ISSUE

TPS

Taylor Project Services LLP

No.1 Cornhill
London, EC3V 3ND
Tel 020 7743 6602
www.taylorprojectservices.com

Client:



THE BEDFORD ESTATES
29a Montague Street
London
WC1B 5SL
Tel: 0771 406 2865
Fax: 0771 205 1709

Project
3 GOWER STREET
LONDON
WC1

Drawing Title
SECOND FLOOR
EXISTING SERVICES LAYOUT

Scale 1:50 @ A1 Date 07.02.13

Drawn L.R. Checked G.N.T.


 
 
 

Drawing Status
PLANNING


Revision 0 A

Drawing No. TPS/3GS/2/E



GENERAL NOTES


-  VRV UNIT POSITION
-  ELECTRIC HEATER
-  CONDENSER
-  REFRIGERANT PIPEWORK RUN
-  VRV UNIT BS BOX

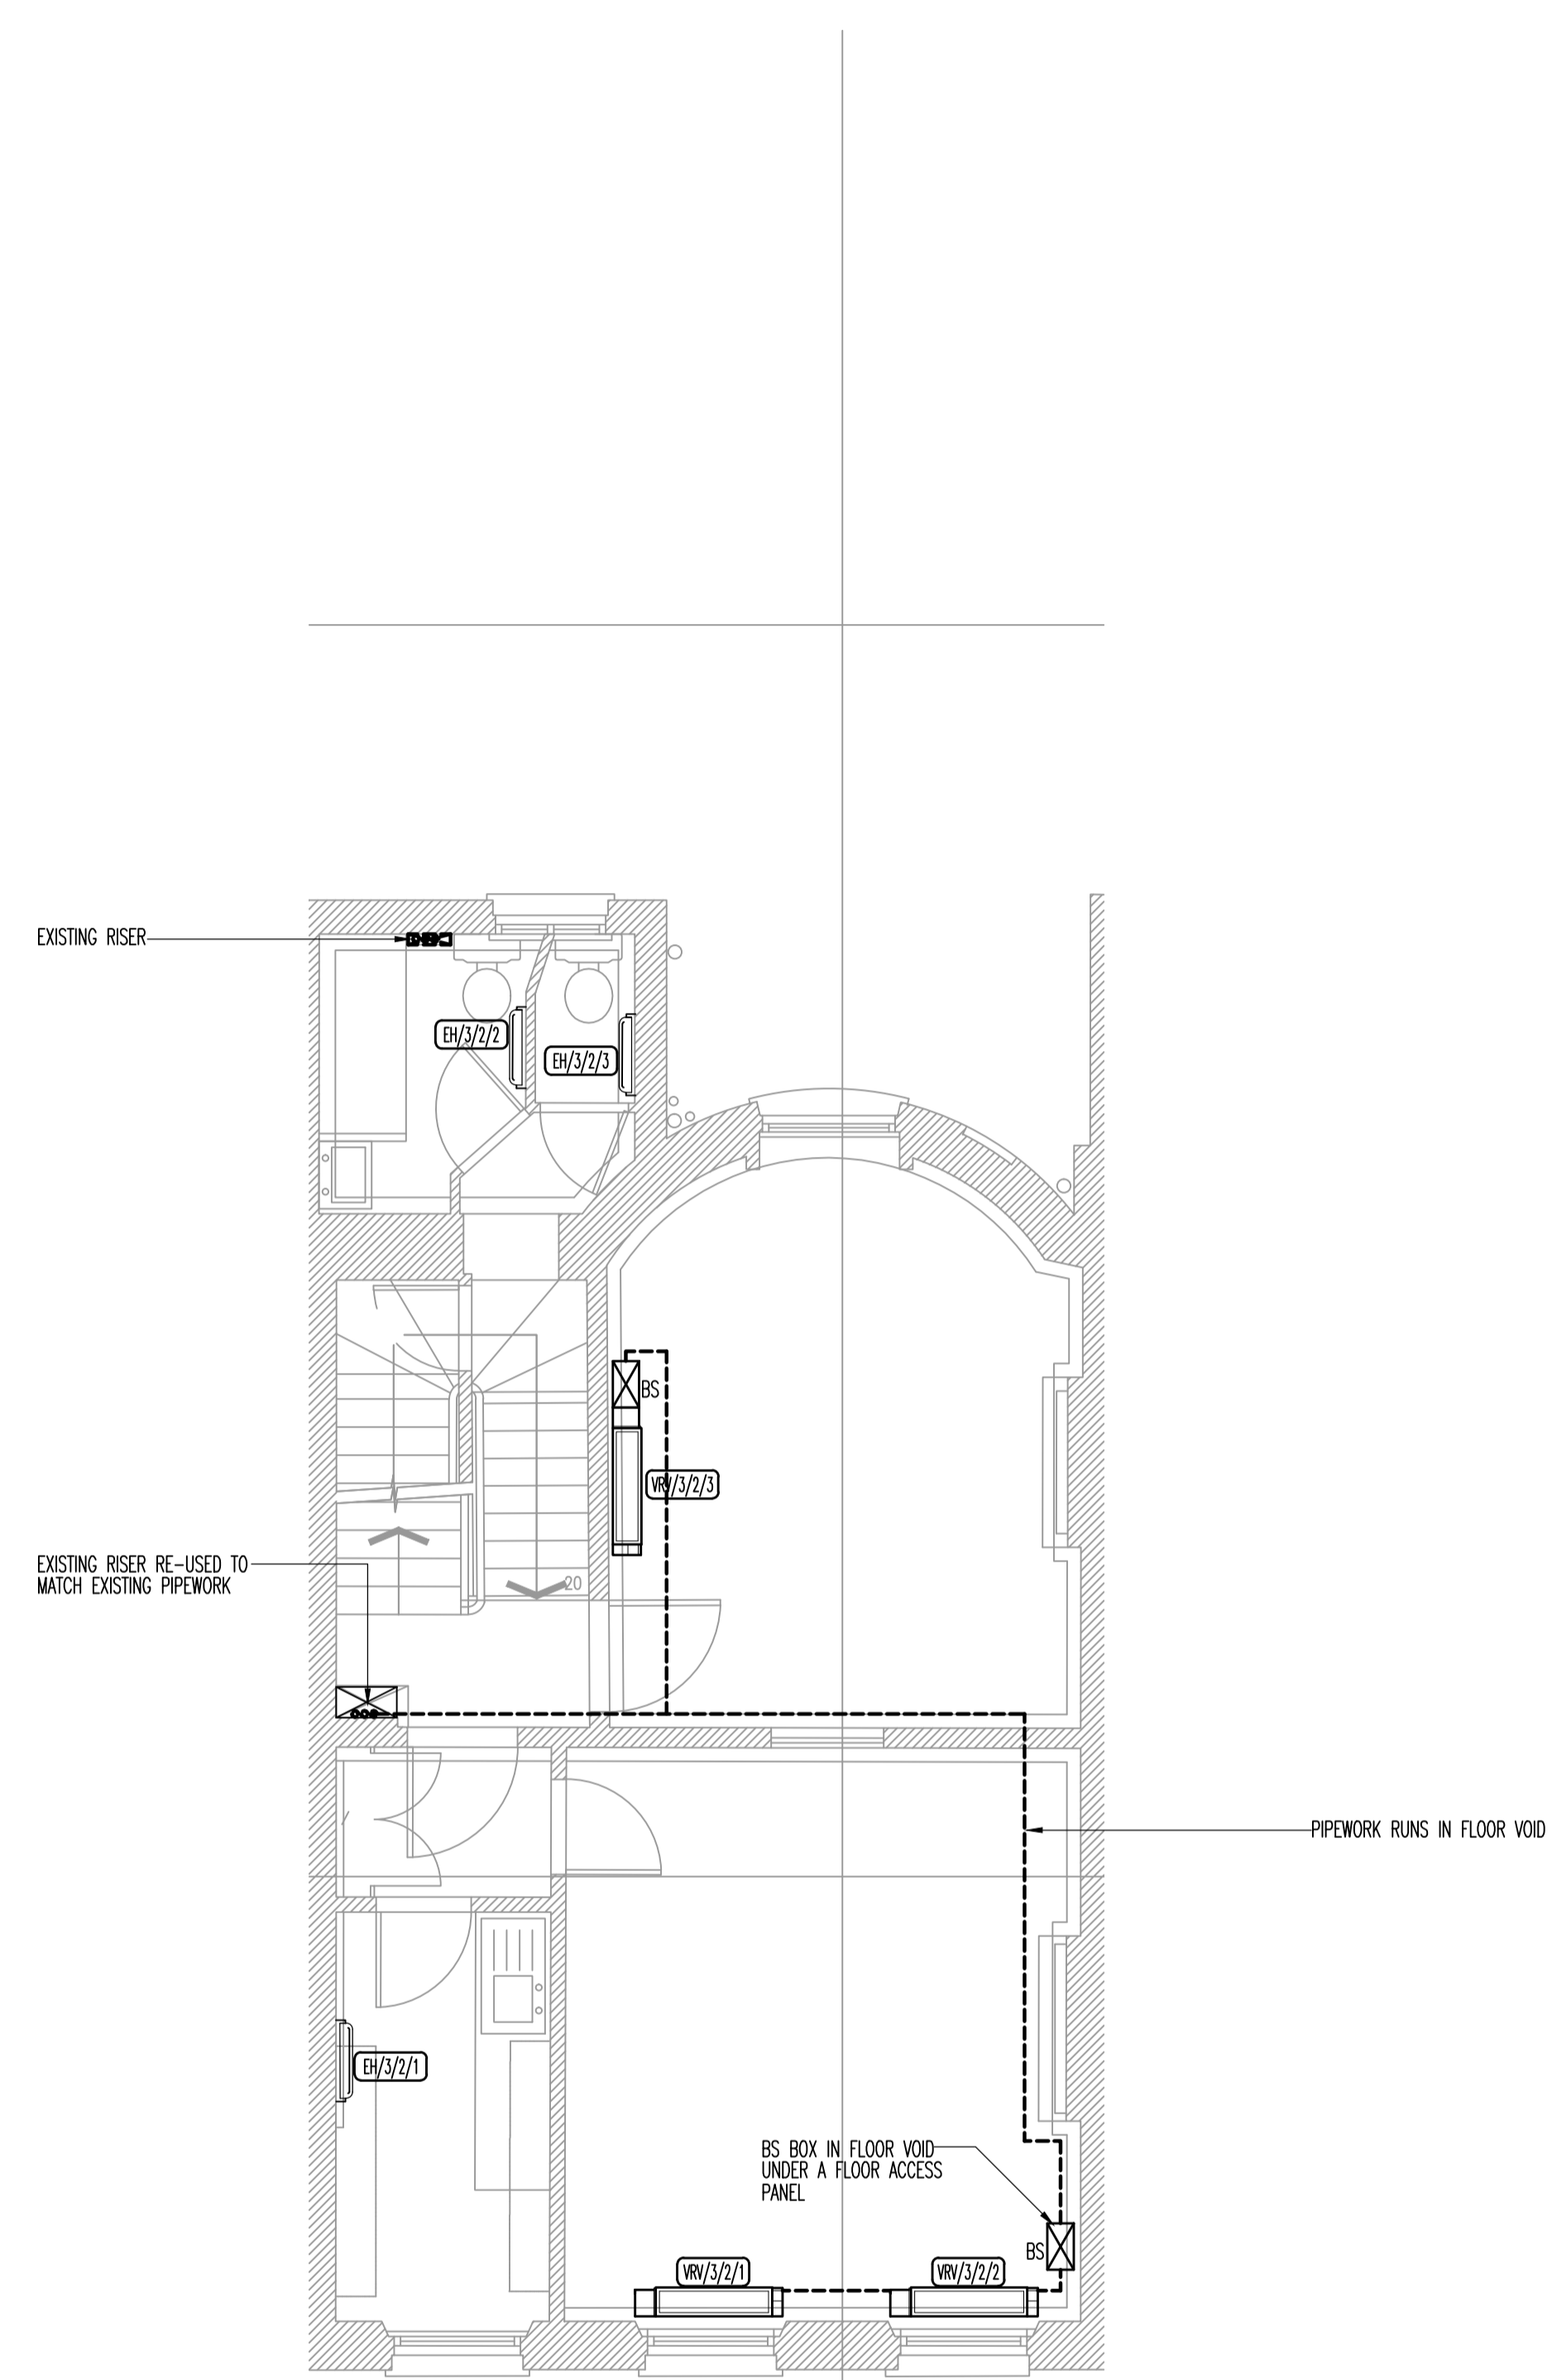

PLANNING

Rev	Date	Description
A	JUL.13	LAYOUTS UPDATED EXISTING RISER SHOWN & RE-USED
0	FEB.12	PLANNING ISSUE

TPS
Taylor Project Services LLP
No.1 Cornhill
London, EC3V 3ND
Tel: 020 7743 6602
www.taylorprojectservices.com

Client:  **THE BEDFORD ESTATES**
29a Montague Street
London
WC1B 5DL
Tel: 0771 466 2865
Fax: 0771 266 1709

Project
**3 GOWER STREET
LONDON
WC1**

Drawing Title
**SECOND FLOOR
PROPOSED
VRV POSITIONS**

Scale: 1:50 @ A1 Date: 07.02.13
Drawn: L.R. Checked: G.N.T.

Drawing Status: **PLANNING**

Revision: 0 A


Drawing No. **TPS/3GS/2/VRV/P**



GENERAL NOTES

TO BE STRIPPED OUT

RADIATOR

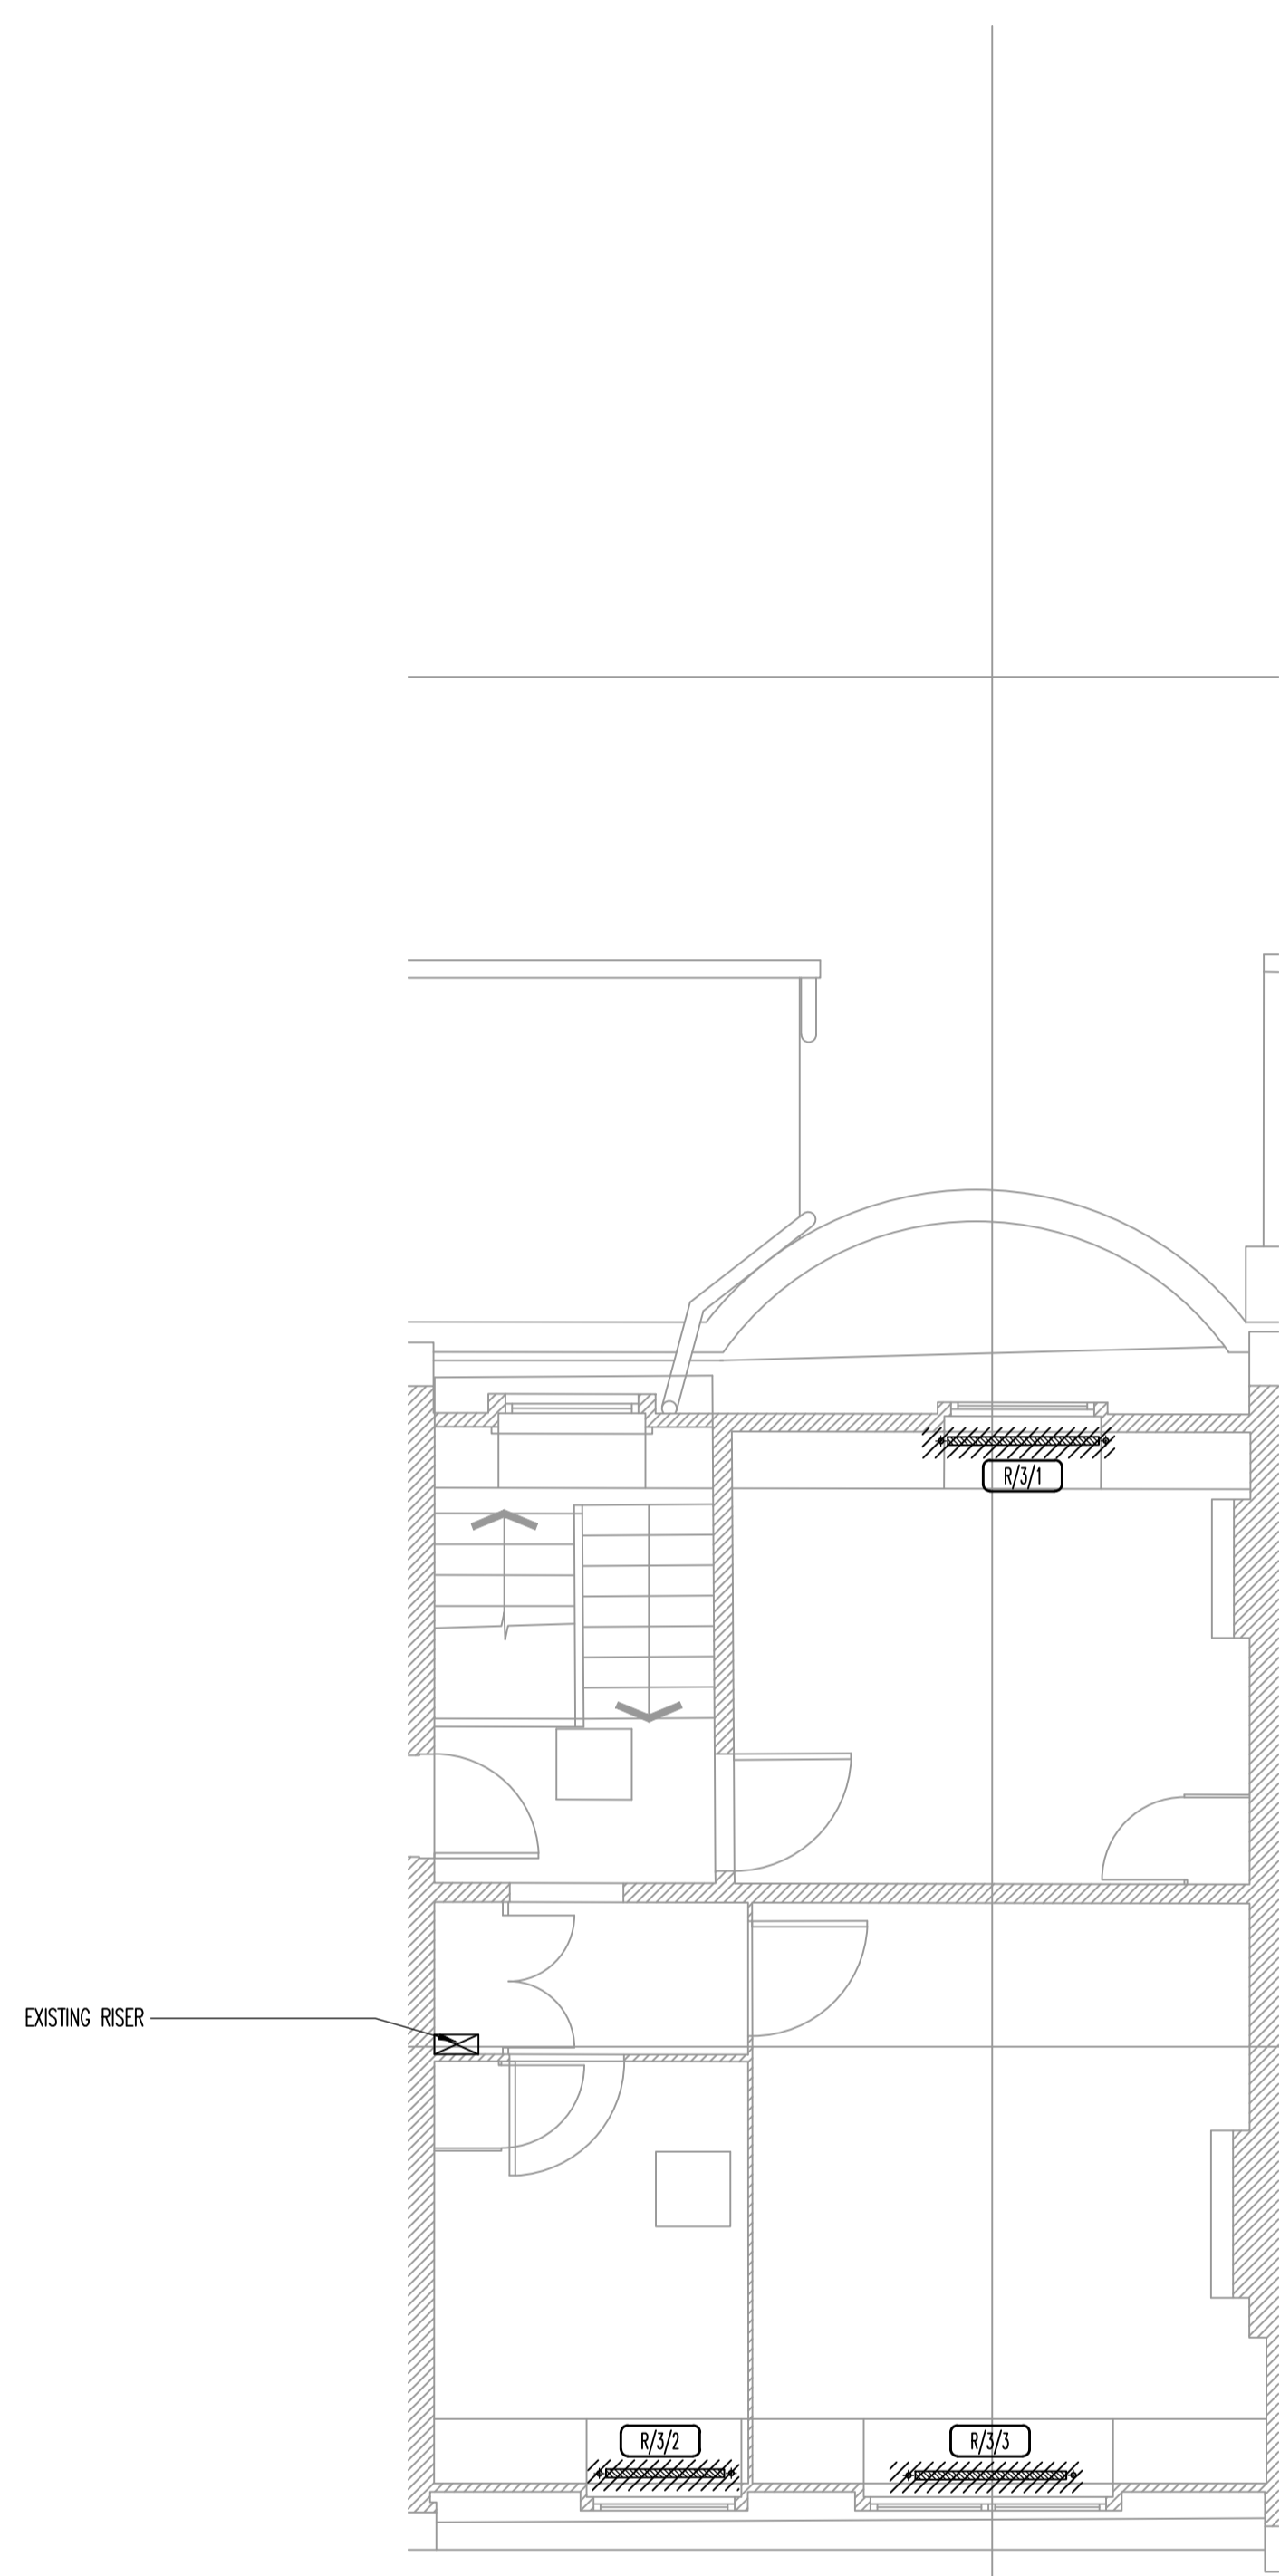

No.3 Gower Street

PLANNING


Rev	Date	Description
A	JUL.13	LAYOUTS UPDATED EXISTING RISER SHOWN & RE-USED
0	FEB.13	PLANNING ISSUE

TPS

Taylor Project Services LLP

No.1 Cornhill
London, EC3V 3ND
Tel 020 7743 6602
www.taylorprojectservices.com

Client:



THE BEDFORD ESTATES

29a Montague Street
London
WC1B 5SL
Tel: 0771 406 2865
Fax: 0771 205 1709

Project
3 GOWER STREET
LONDON
WC1


Drawing Title
THIRD FLOOR
EXISTING SERVICES POSITIONS

Scale	1:50 @ A1	Date	07.02.13
Drawn	L.R.	Checked	G.N.T.


 
 
 

Drawing Status
PLANNING


Revision	0	A																		
----------	---	---	--	--	--	--	--	--	--	--	--	--	--	--	--	--	--	--	--	--

Drawing No. TPS/3GS/3/E

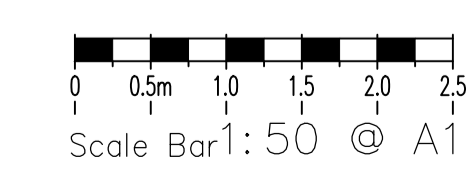

GENERAL NOTES

-  VRV UNIT POSITION
-  ELECTRIC HEATER
-  CONDENSER
-  REFRIGERANT PIPEWORK RUN
-  VRV UNIT BS BOX

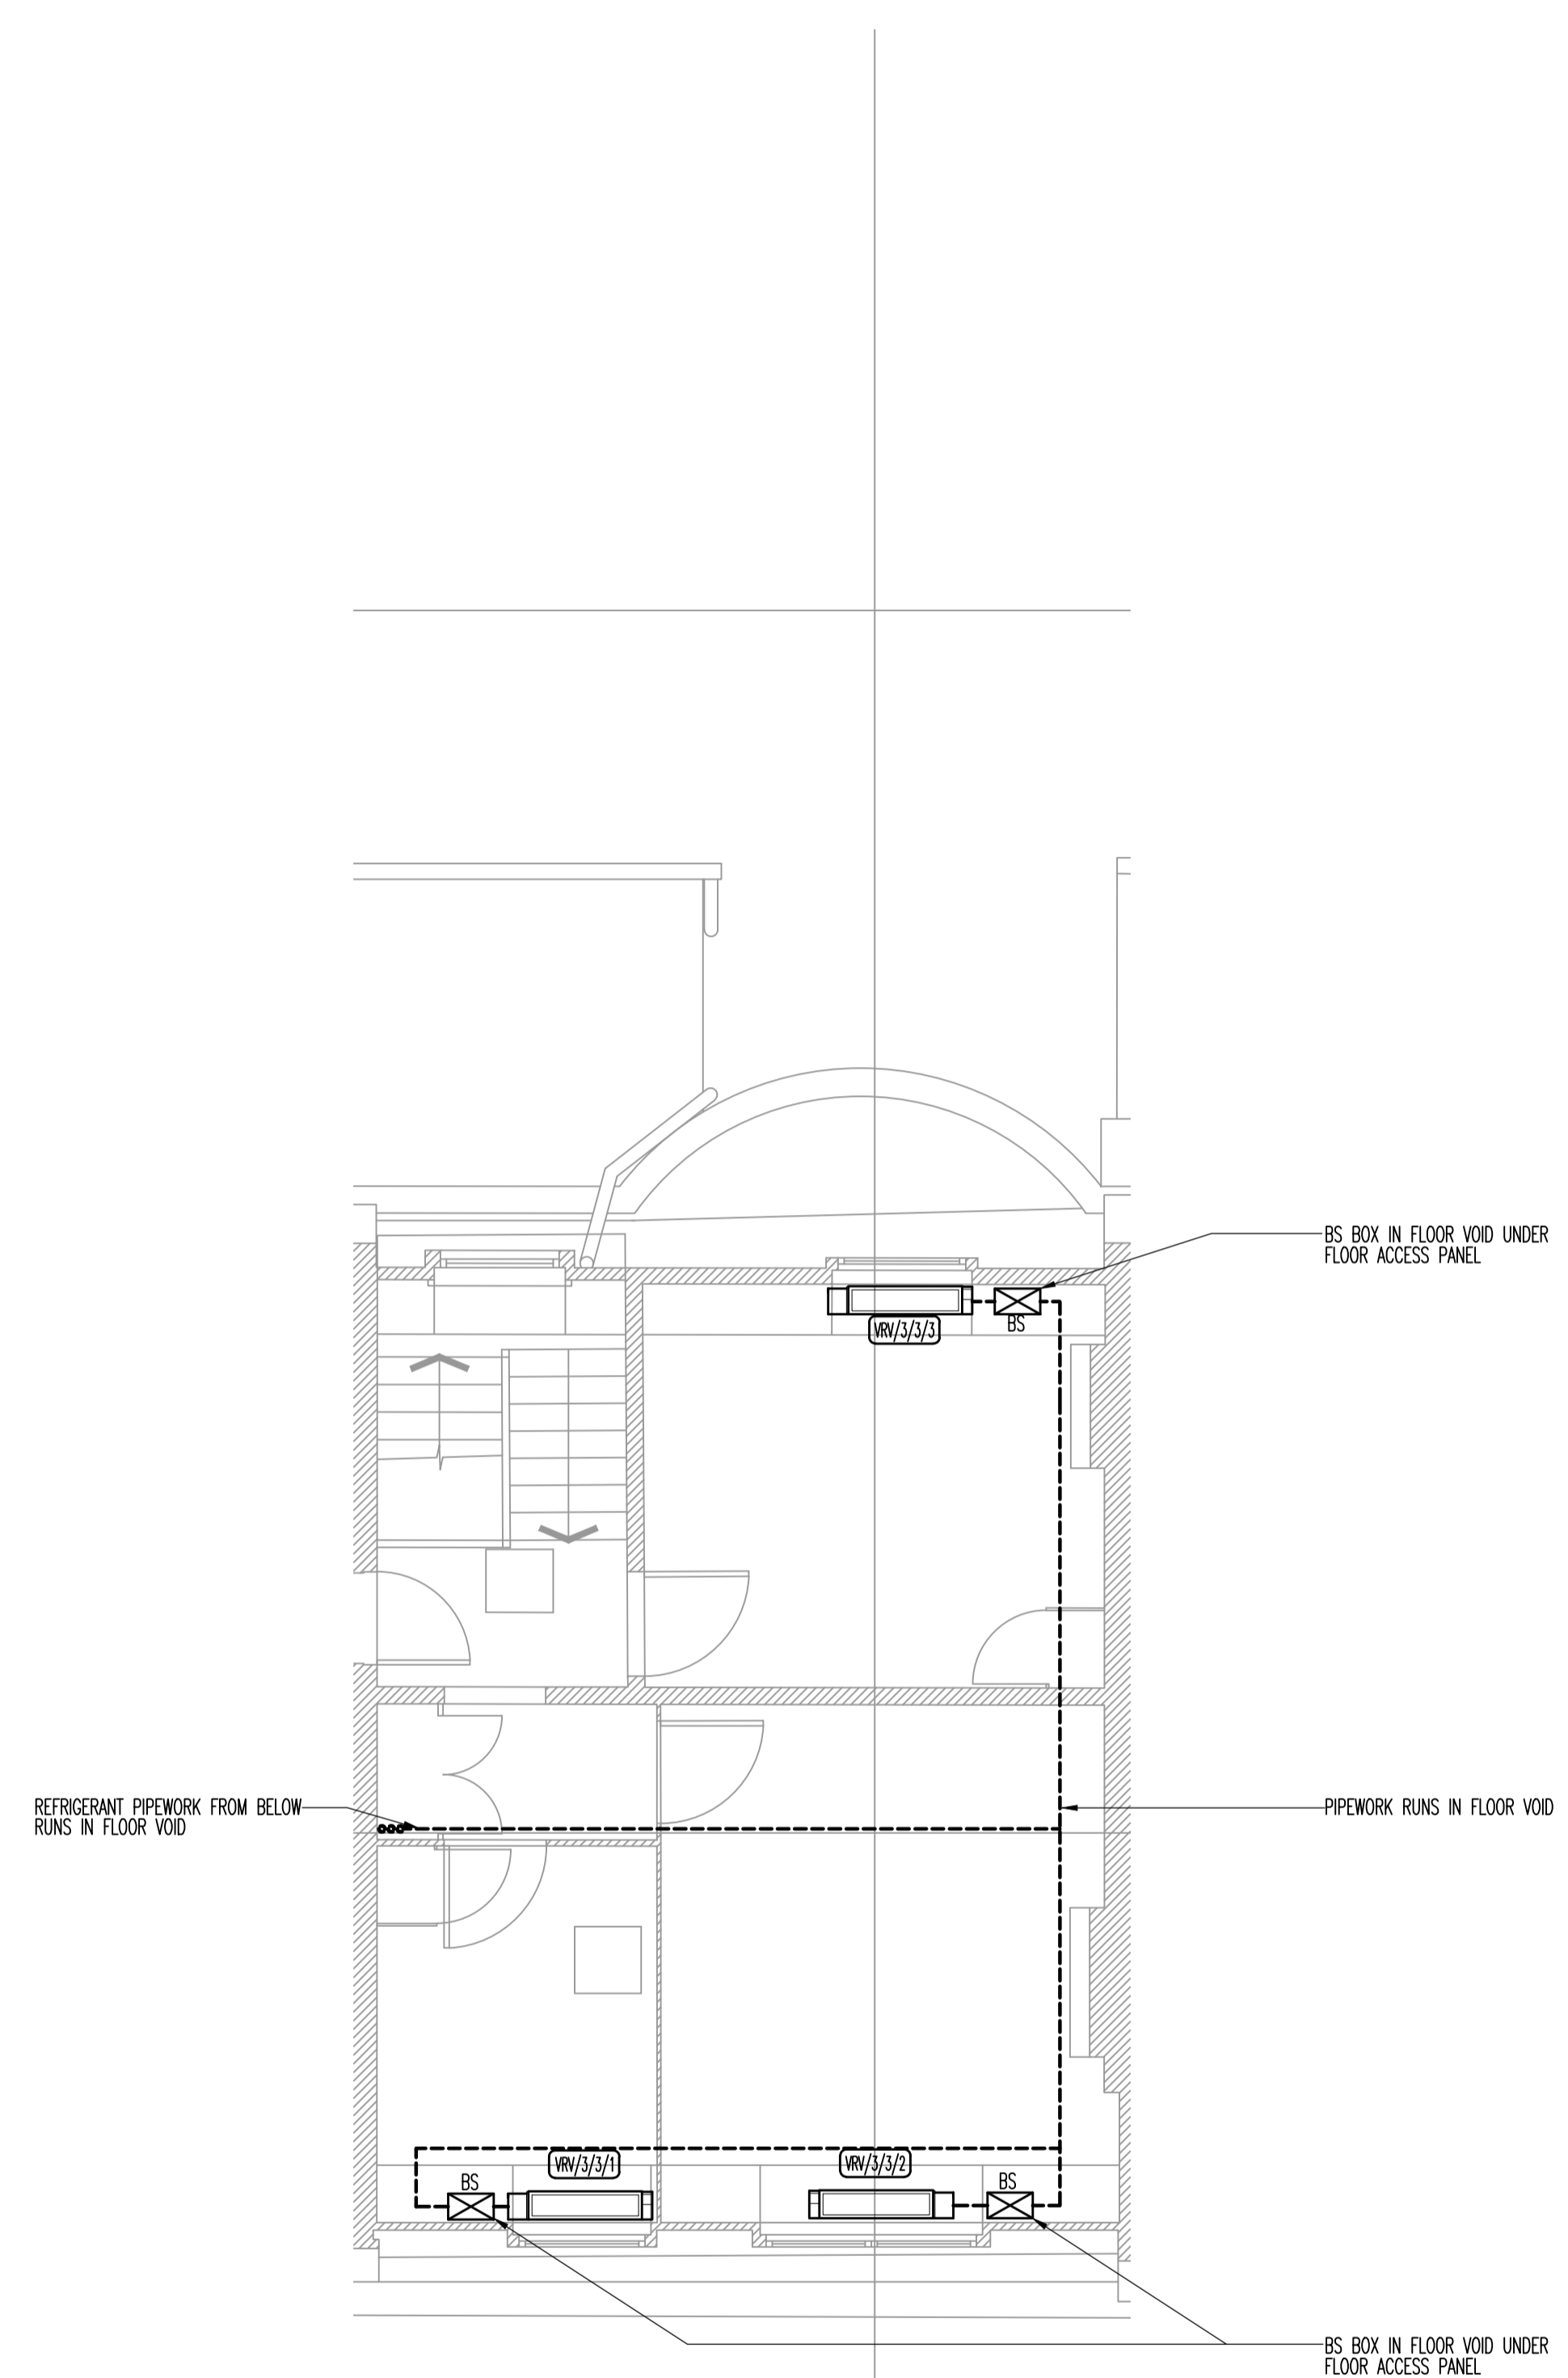

PLANNING


Rev	Date	Description
A	JUL.13	LAYOUTS UPDATED EXISTING RISER SHOWN & RE-USED
0	FEB.12	PLANNING ISSUE

TPS

Taylor Project Services LLP

No.1 Cornhill
London, EC3V 3ND
Tel 020 7743 6602
www.taylorprojectservices.com

Client:



THE BEDFORD ESTATES
29a Montague Street
London
WC1B 5SL
Tel: 0771 406 2885
Fax: 0771 285 1709

Project
**3 GOWER STREET
LONDON
WC1**

Drawing Title
**THIRD FLOOR
PROPOSED
VRV POSITIONS**

Scale	1:50 @ A1	Date	07.02.13
Drawn	L.R.	Checked	G.N.T.


Drawing Status
PLANNING

Revision	0	A							
----------	---	---	--	--	--	--	--	--	--


Drawing No. **TPS/3GS/3/VRV/P**



GENERAL NOTES

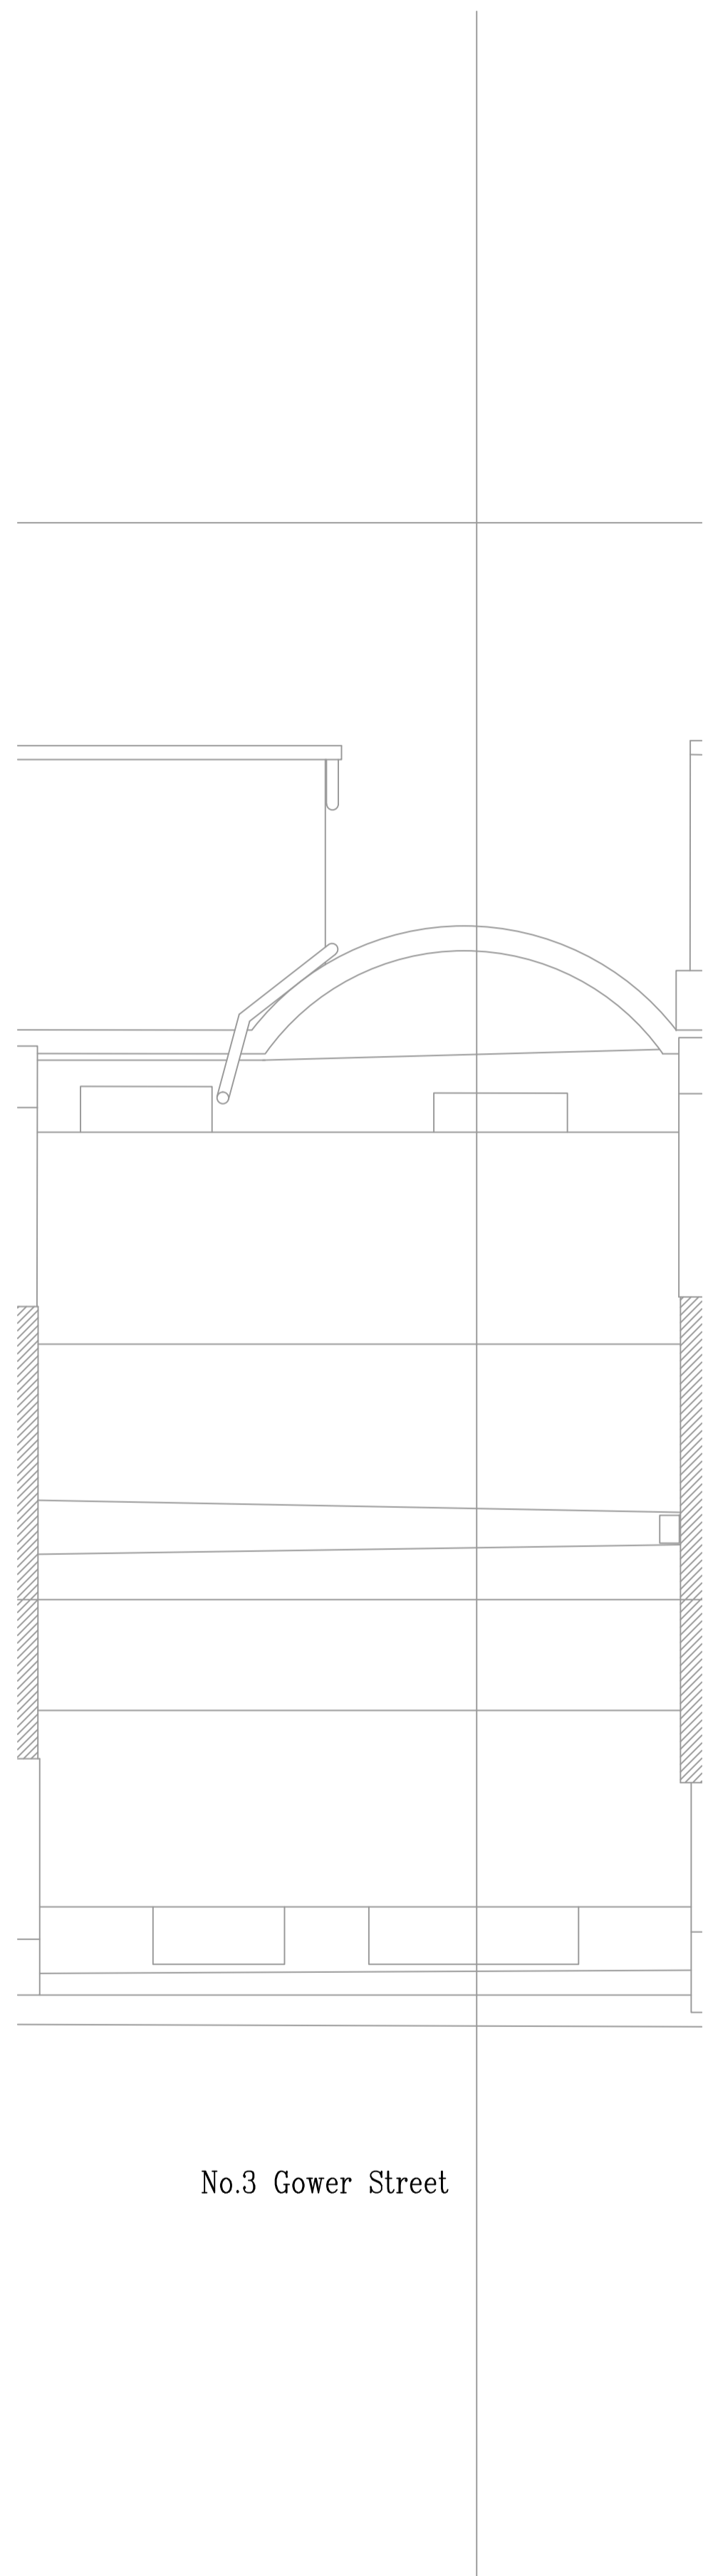

No.3 Gower Street

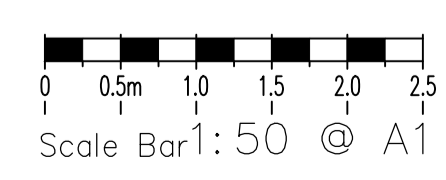

PLANNING


0	FEB.13	PLANNING ISSUE
Rev	Date	Description

TPS

Taylor Project Services LLP

No.1 Cornhill
London, EC3V 3ND
Tel 020 7743 6602
www.taylorprojectservices.com

Client:



THE BEDFORD ESTATES

29a Montague Street
London
WC1B 5JL
Tel: 0771 456 2865
Fax: 0771 255 1729

Project
3 GOWER STREET
LONDON
WC1

Drawing Title
ROOF
EXISTING SERVICES LAYOUT


Scale	1:50 © A1	Date	07.02.13
Drawn	L.R.	Checked	G.N.T.

Drawing Status
PLANNING


Revision	0																		
----------	---	--	--	--	--	--	--	--	--	--	--	--	--	--	--	--	--	--	--

Drawing No. TPS/3GS/R/E

GENERAL NOTES

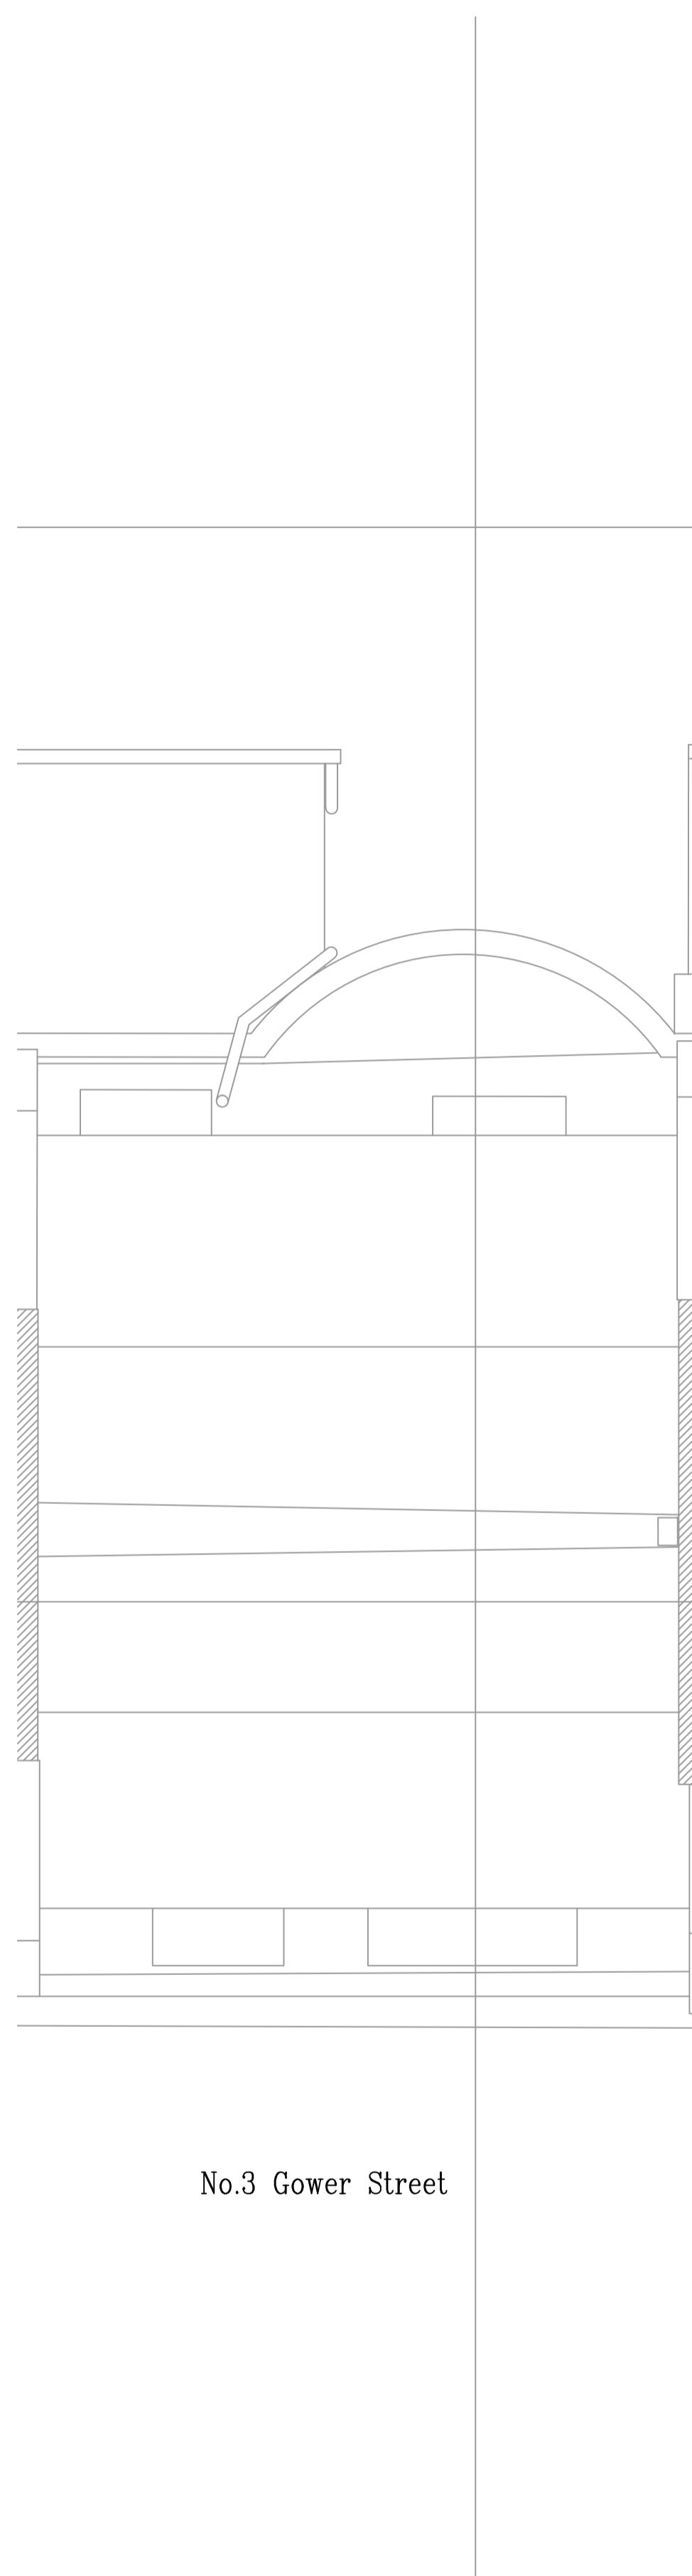

No.3 Gower Street

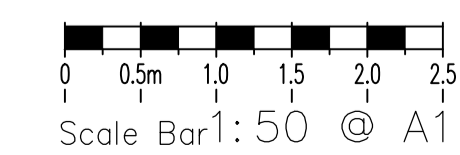

PLANNING

0	FEB.13	PLANNING ISSUE
Rev	Date	Description

TPS

Taylor Project Services LLP

No.1 Cornhill
London, EC3V 3ND
Tel 020 7743 6602
www.taylorprojectservices.com

Client:



Project

3 GOWER STREET
LONDON
WC1

Drawing Title

ROOF
PROPOSED
VRV POSITIONS

Scale 1:50 © A1

Date 07.02.13

Drawn L.R.

Checked G.N.T.

Drawing Status

PLANNING

Revision 0

Drawing No.

TPS/3GS/R/VRV/P

GENERAL NOTES



NO.3 GOWER STREET



PLANNING


0	FEB.13	PLANNING ISSUE
Rev	Date	Description

TPS

Taylor Project Services LLP

No.1 Cornhill
London, EC3V 3ND
Tel 020 7743 6602
www.taylorprojectservices.com

Client:



THE BEDFORD ESTATES

29a Montague Street
London
WC1B 5JL
Tel: 0771 456 2865
Fax: 0771 286 1709

Project
3 GOWER STREET
LONDON
WC1

Drawing Title
EXISTING
FRONT ELEVATION

Scale	1:50 @ A1	Date	07.02.13
Drawn	L.R.	Checked	G.N.T.

Drawing Status
PLANNING

Revision	0								
----------	---	--	--	--	--	--	--	--	--

Drawing No.
TPS/3GS/EL/F/E

GENERAL NOTES



NO.3 GOWER STREET

PLANNING


Rev	Date	Description
0	FEB.13	PLANNING ISSUE

TPS

Taylor Project Services LLP

No.1 Cornhill
London, EC3V 3ND
Tel 020 7743 6602
www.taylorprojectservices.com

Client:



THE BEDFORD ESTATES
29a Montague Street
London
WC1B 5JL
Tel: 0771 406 2865
Fax: 0771 286 1709

Project
**3 GOWER STREET
LONDON
WC1**

Drawing Title
**PROPOSED
FRONT ELEVATION**

Scale	1:50 @ A1	Date	07.02.13
Drawn	L.R.	Checked	G.N.T.


Drawing Status
PLANNING

Revision	0													
----------	---	--	--	--	--	--	--	--	--	--	--	--	--	--


Drawing No.
TPS/3GS/EL/F/P



GENERAL NOTES

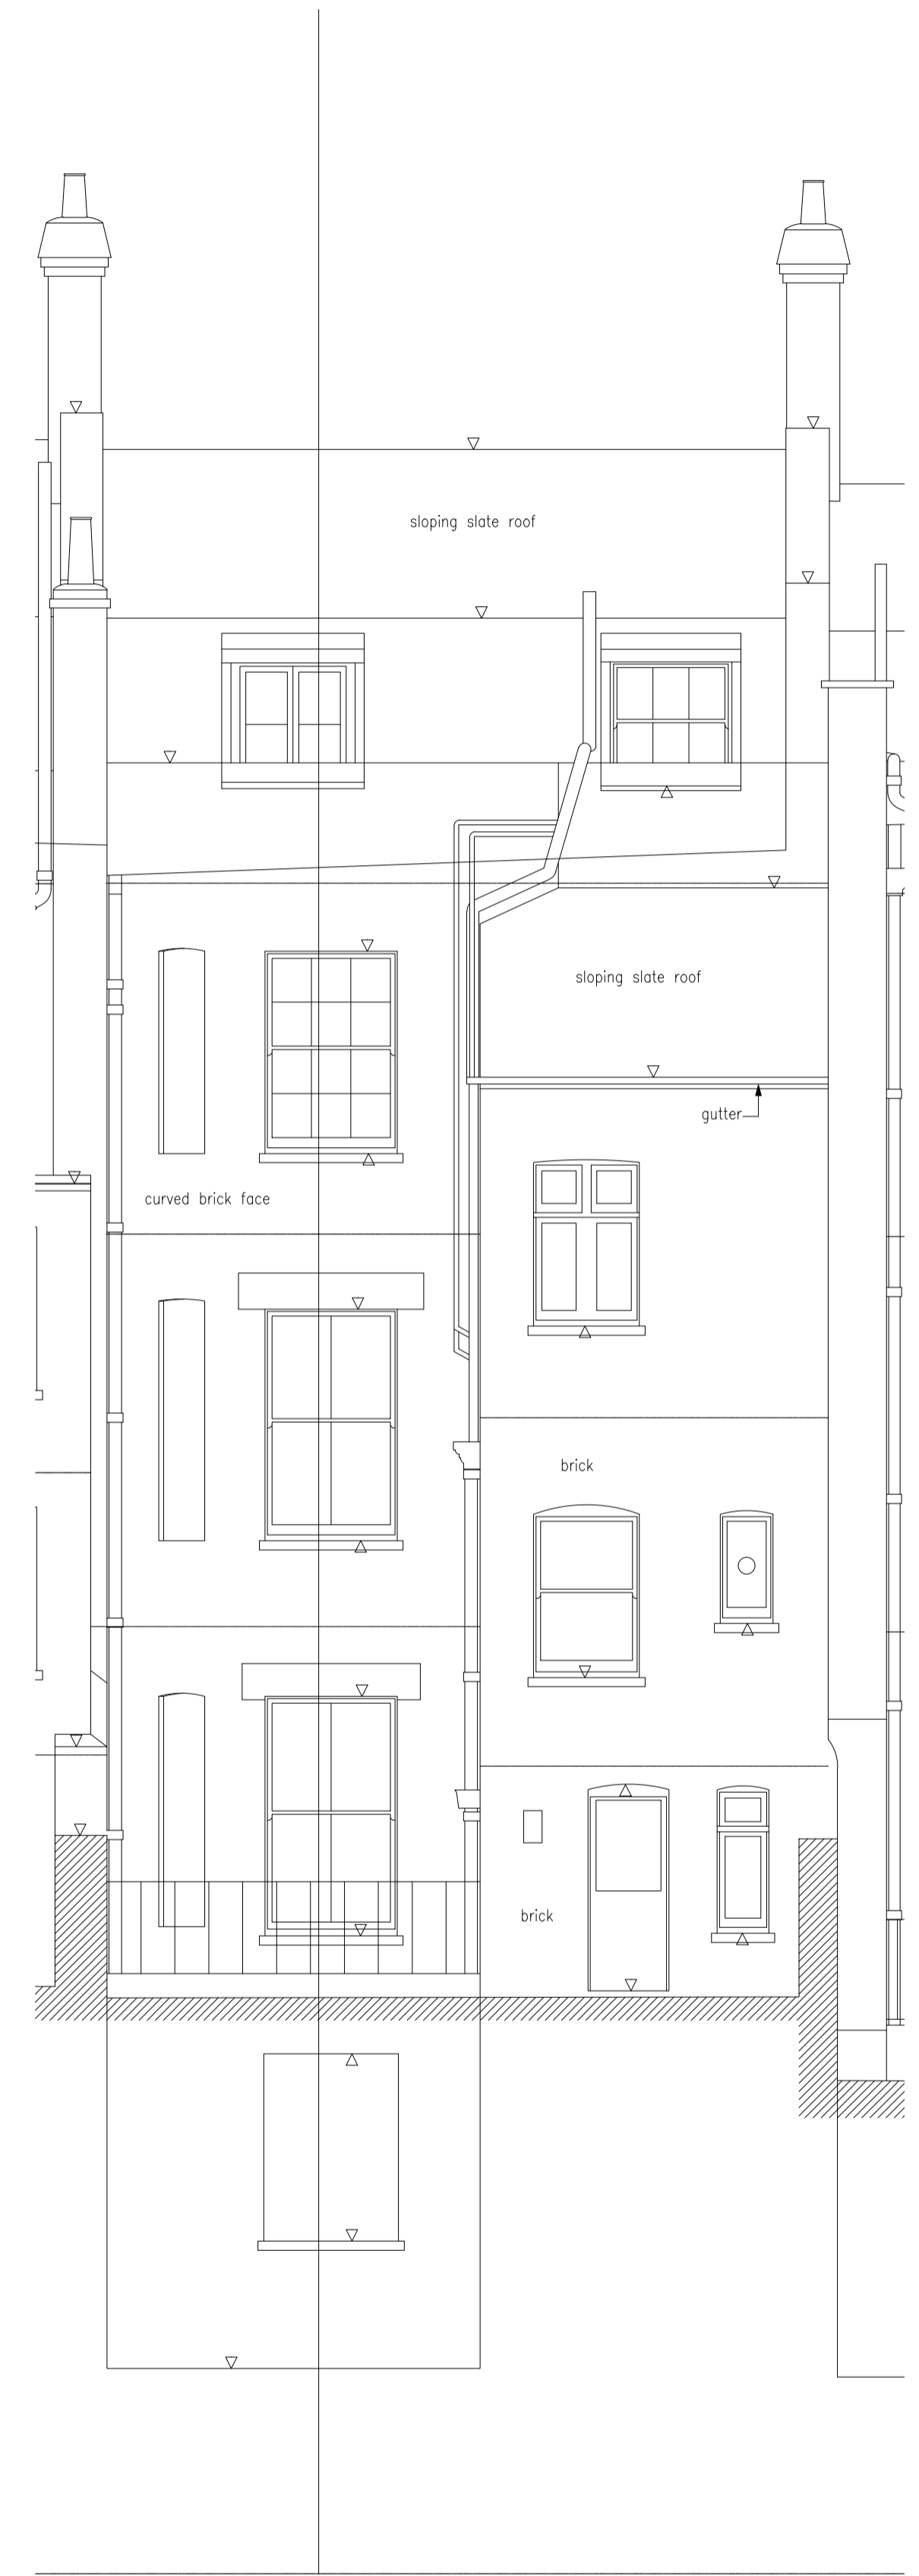

NO.3 GOWER STREET

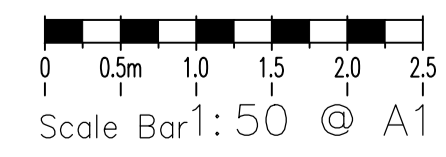

PLANNING


Rev	Date	Description
0	FEB.13	PLANNING ISSUE

TPS

Taylor Project Services LLP

No.1 Cornhill
London, EC3V 3ND
Tel 020 7743 6602
www.taylorprojectservices.com

Client:

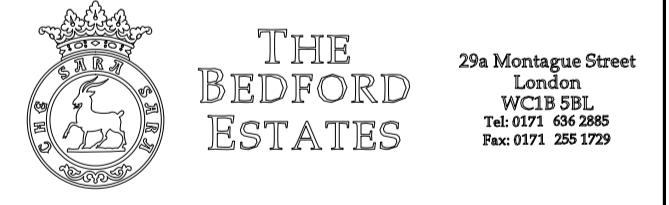

Project

3 GOWER STREET
LONDON
WC1

Drawing Title

EXISTING
REAR ELEVATION

Scale 1:50 @ A1

Date 07.02.13

Drawn L.R.

Checked G.N.T.

Drawing Status

PLANNING

Revision 0

Drawing No.

TPS/3GS/EL/R/E

GENERAL NOTES



NO.3 GOWER STREET

PLANNING

Rev	Date	Description
A	MAY.13	CONDENSER DETAIL ADDED
0	FEB.13	PLANNING ISSUE

TPS

Taylor Project Services LLP

No.1 Cornhill
London, EC3V 3ND
Tel: 020 7743 6602
www.taylorprojectservices.com

Client:



THE BEDFORD ESTATES
29a Montague Street
London
WC1B 5JL
Tel: 0771 406 2865
Fax: 0771 286 1709

Project
3 GOWER STREET
LONDON
WC1


Drawing Title
PROPOSED
REAR ELEVATION

Scale	1:50 @ A1	Date	07.02.13
Drawn	L.R.	Checked	G.N.T.

Drawing Status
PLANNING


Revision	0	A																	
----------	---	---	--	--	--	--	--	--	--	--	--	--	--	--	--	--	--	--	--

Drawing No.
TPS/3GS/EL/R/P

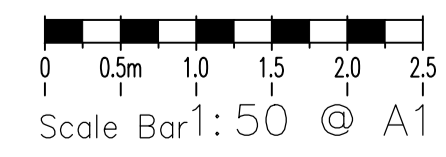


THIS DRAWING MUST NOT BE REPRODUCED WITHOUT PRIOR CONSENT.
DO NOT SCALE FROM THIS DRAWING.
THIS DRAWING IS COPYRIGHTED


GENERAL NOTES

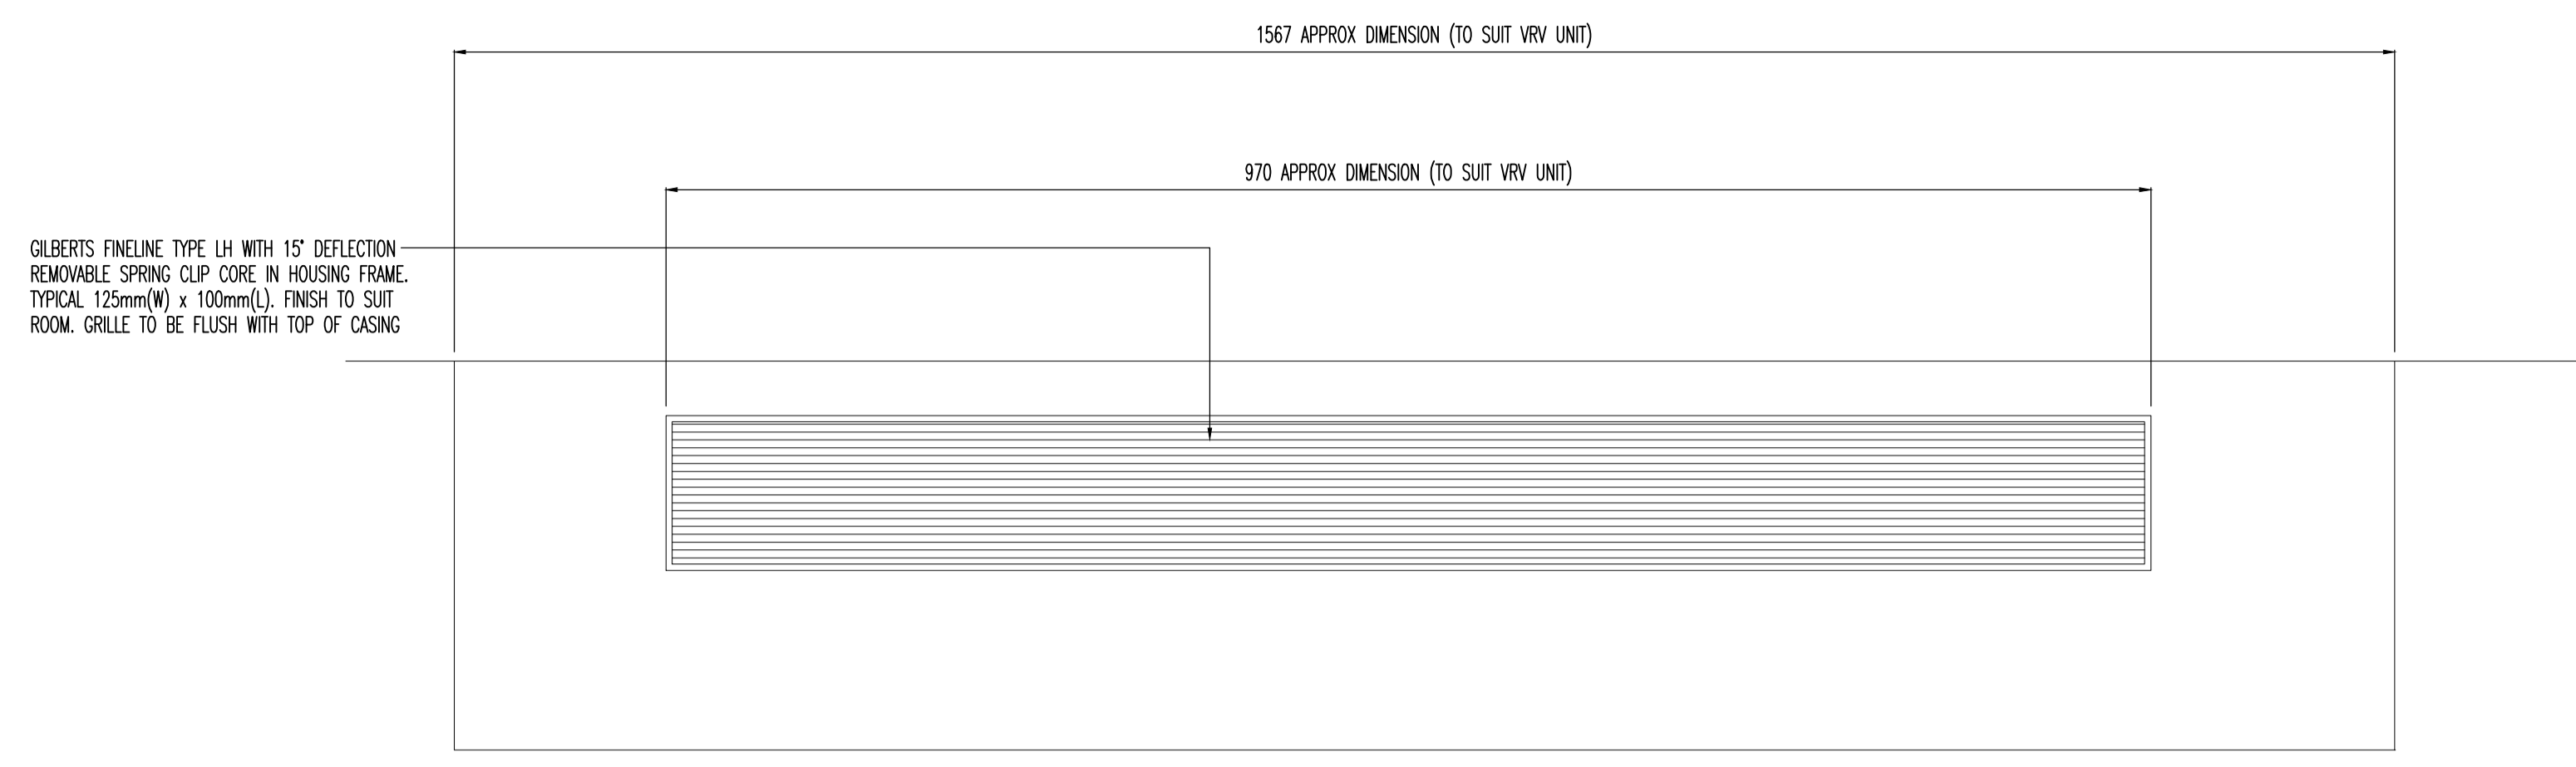


TOP VIEW

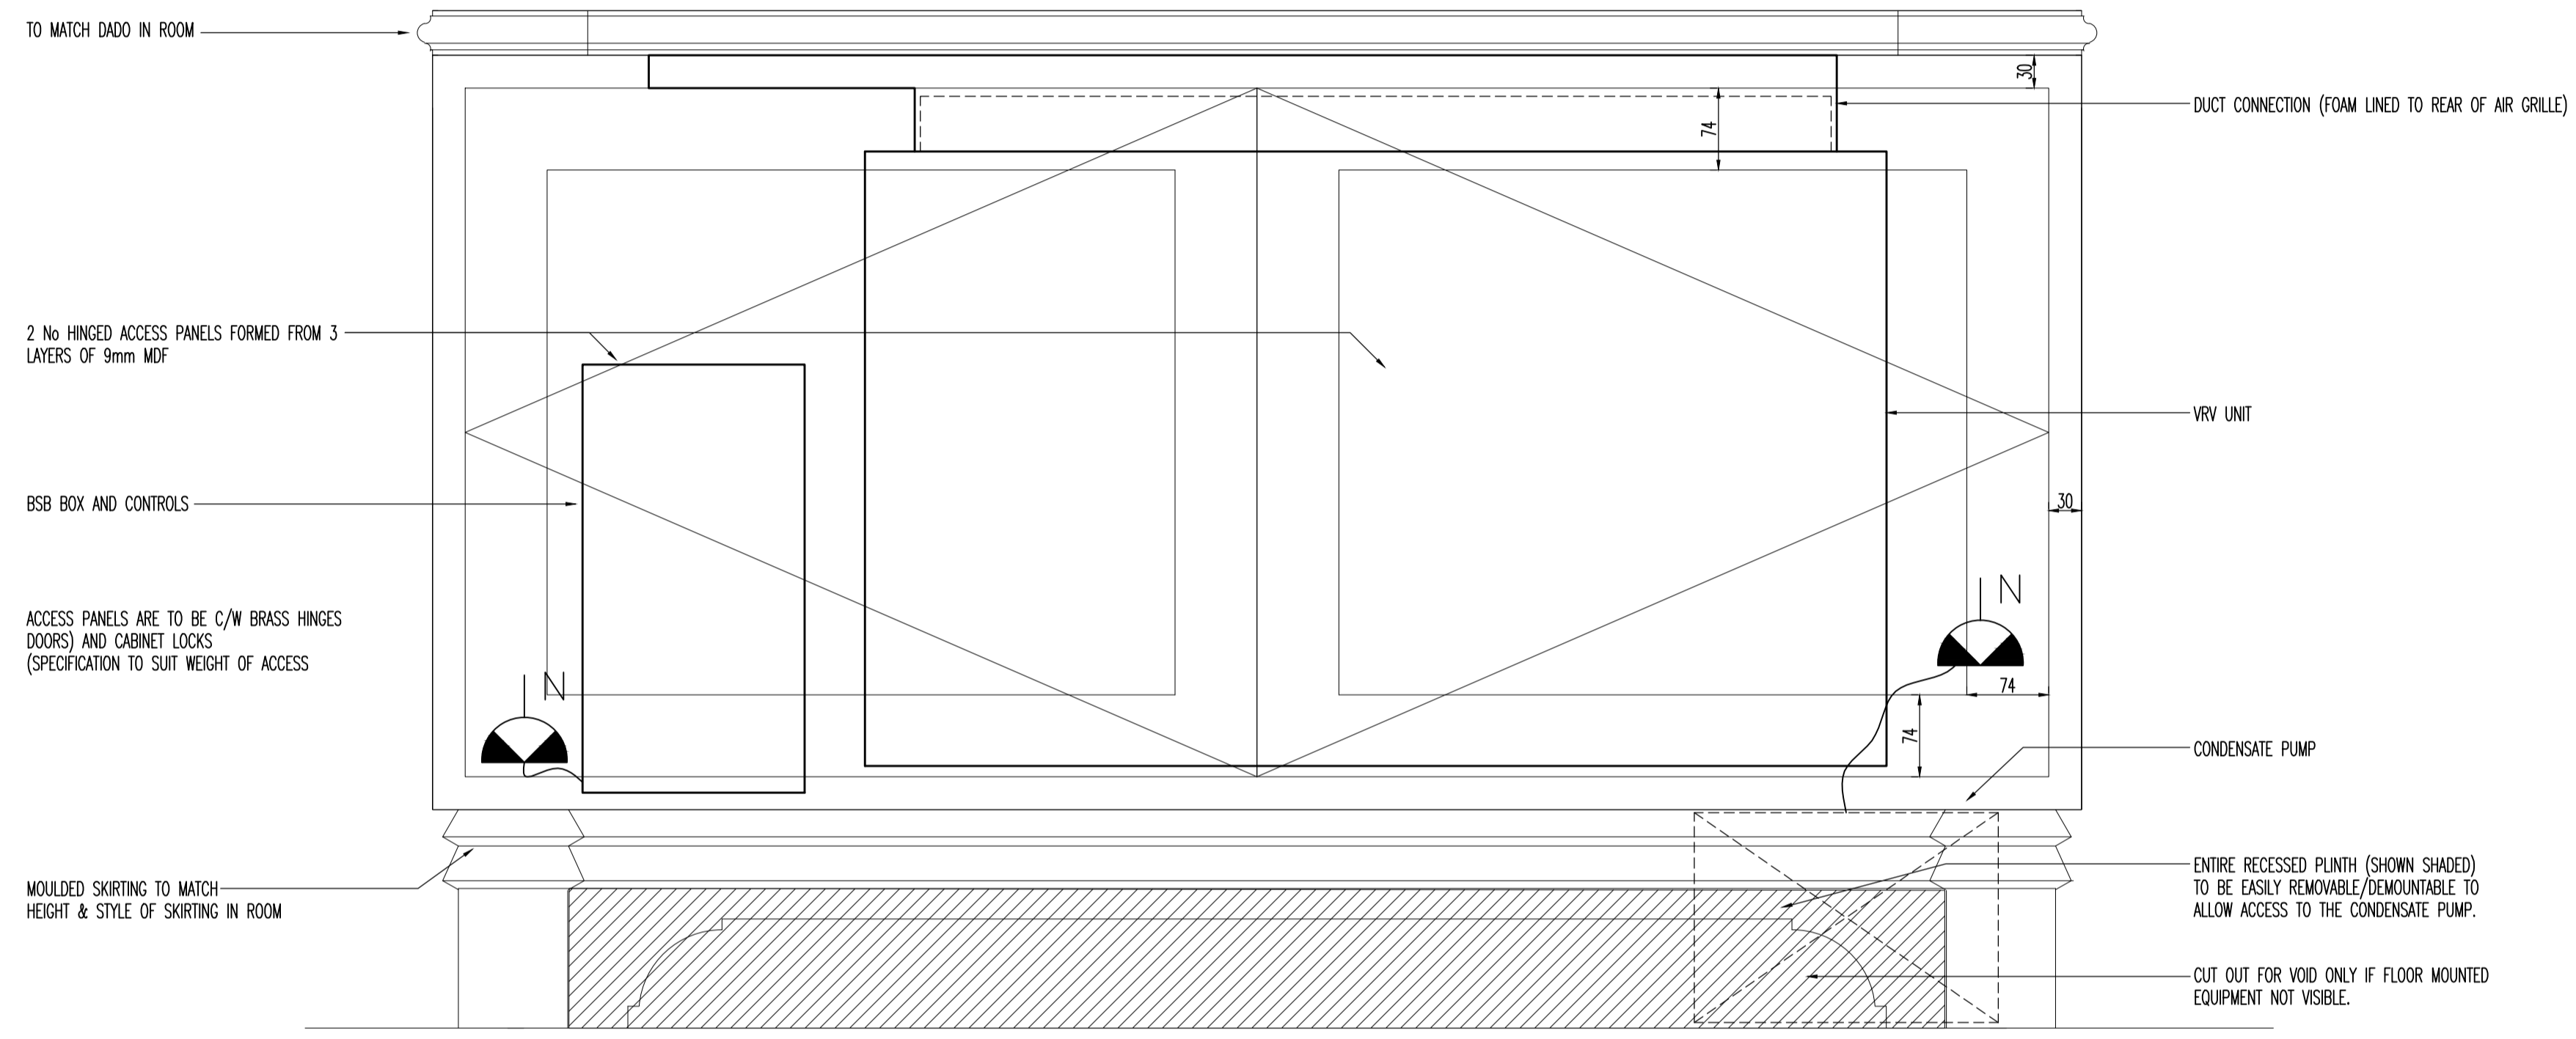


FRONT VIEW

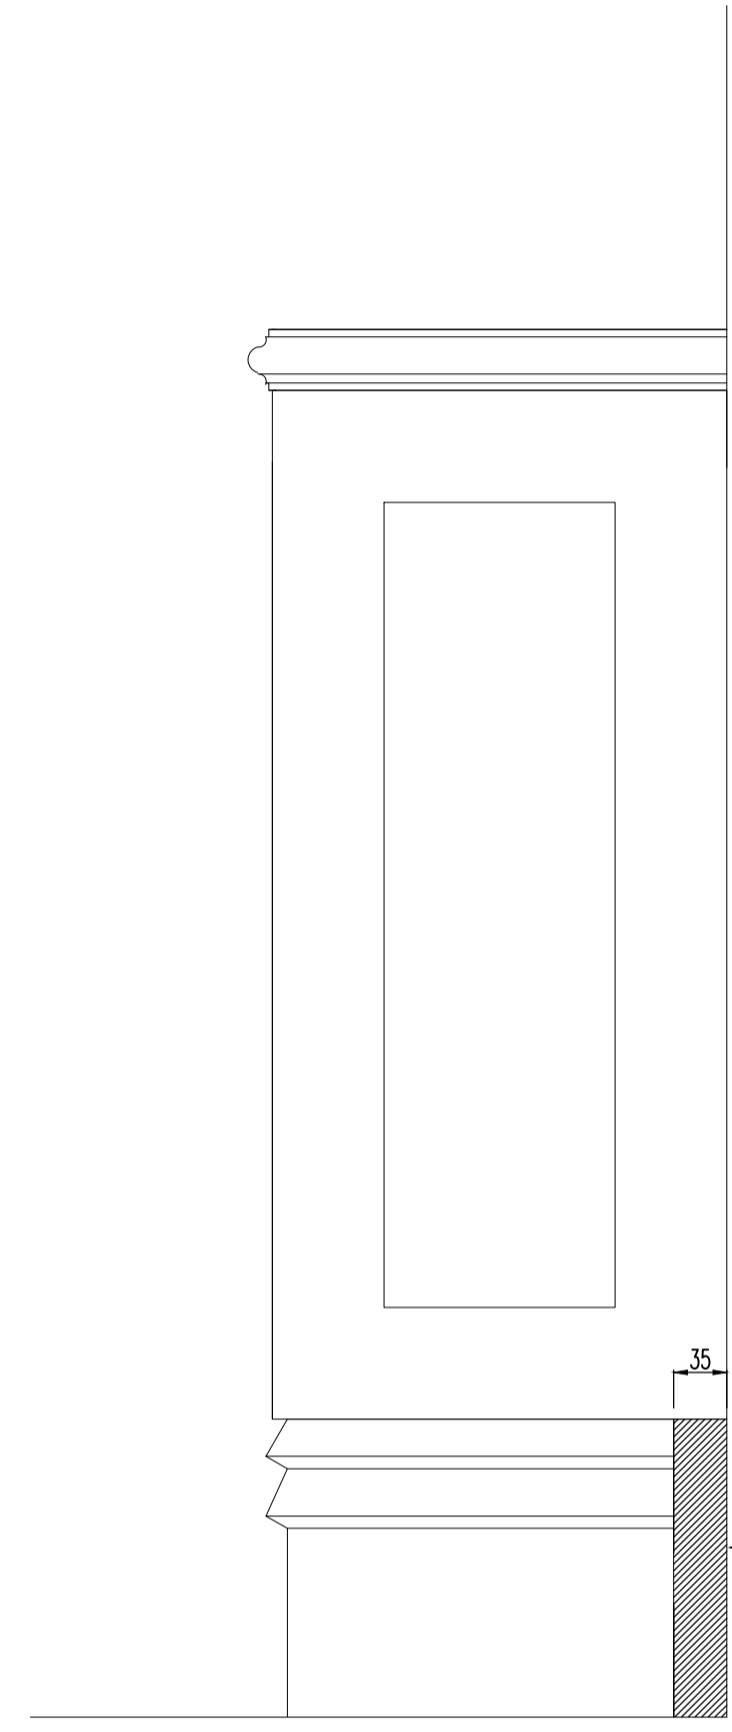


SIDE VIEW

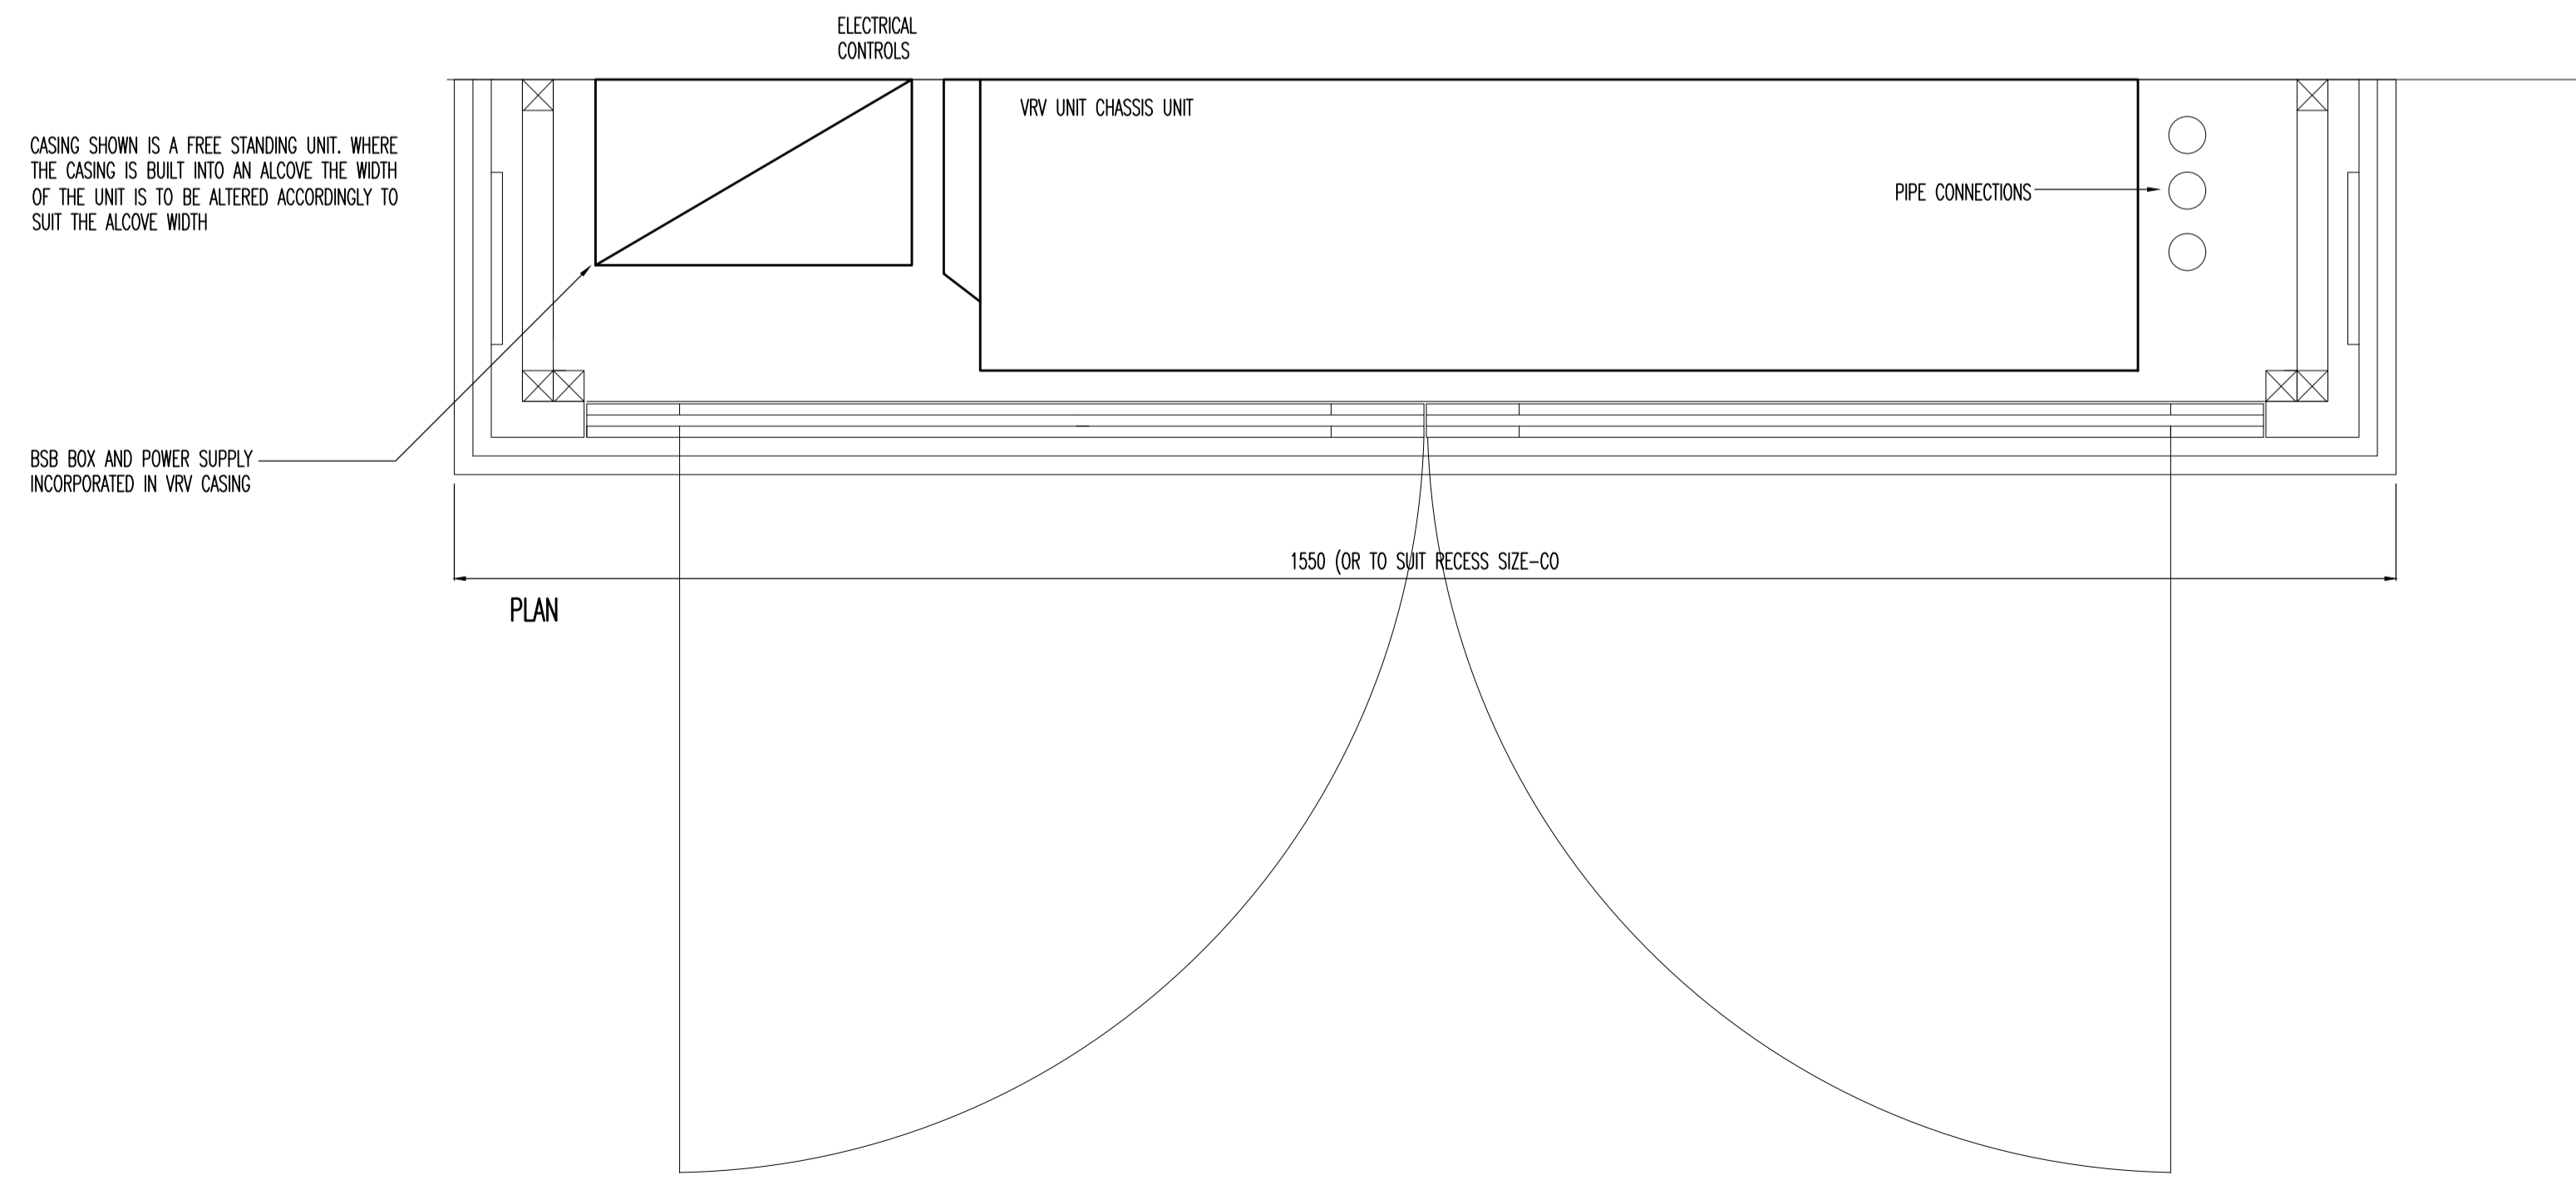

PLAN

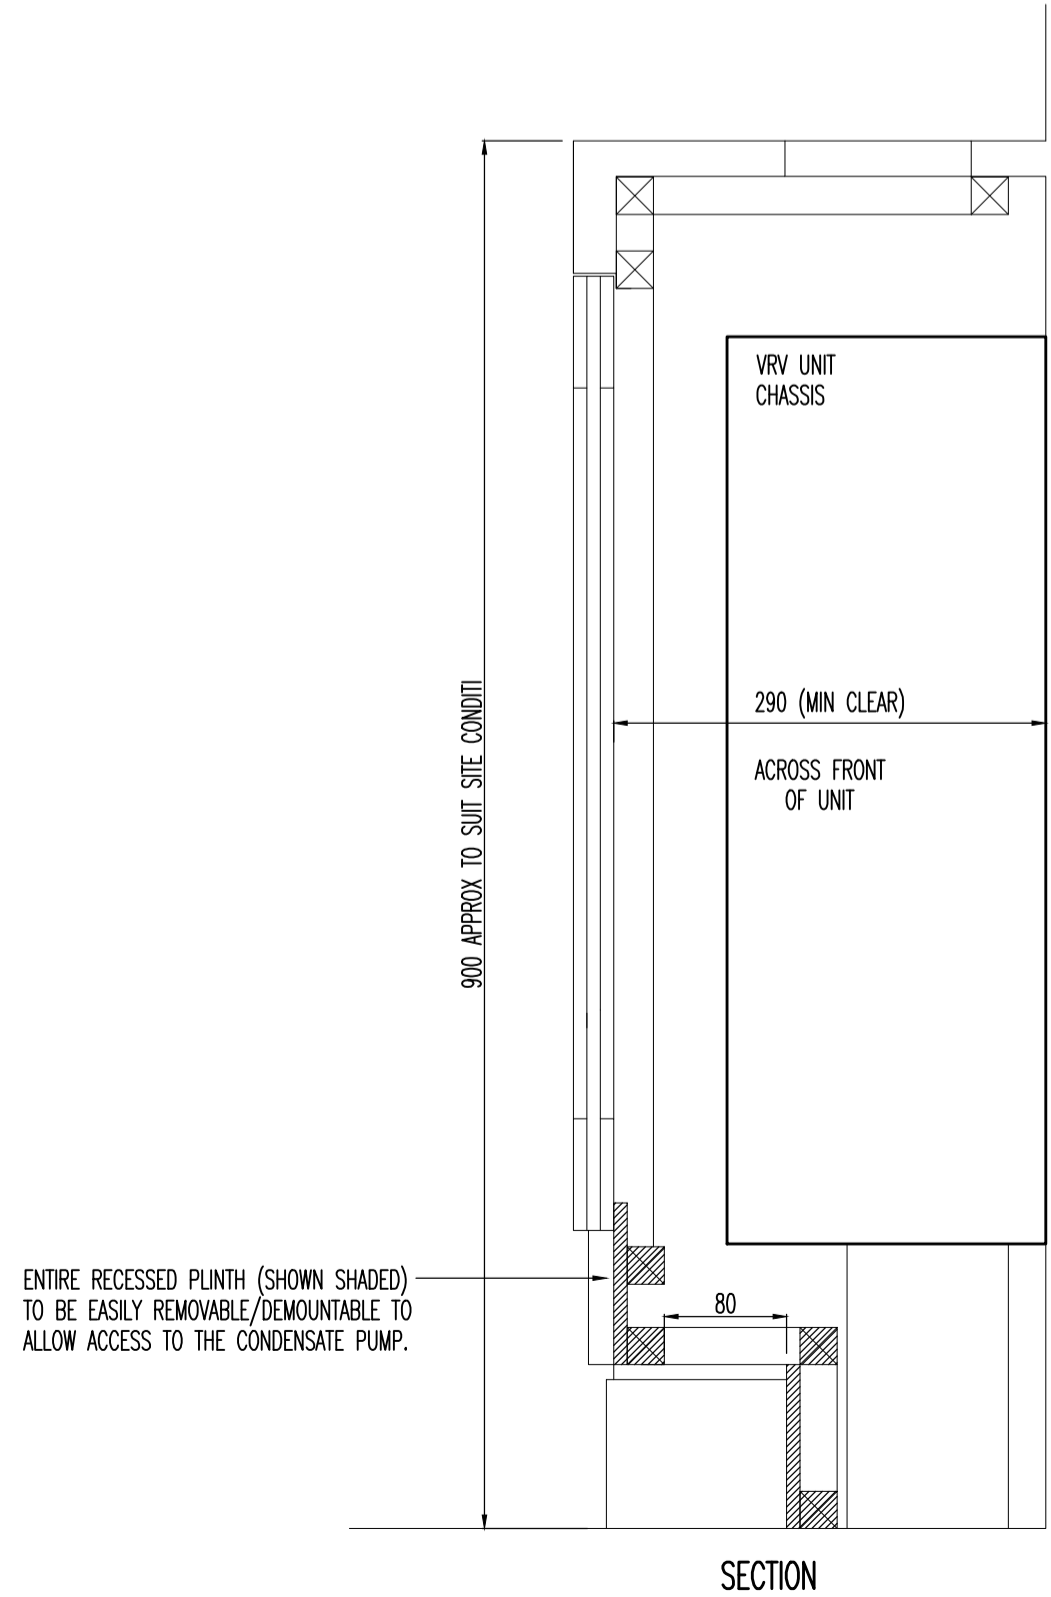

SECTION

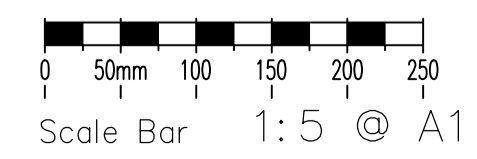

PLANNING

0	FEB.13	PLANNING ISSUE
Rev	Date	Description

TPS

Taylor Project Services LLP
No.1 Cornhill
London EC3V 3ND
Tel 020 7743 6602
www.taylorprojectservices.com

Client

29a Montague Street
London
WC1B 5BL
Tel 0771 862888
Fax 0771 2581229

Project

3 GOWER STREET
LONDON
WC1

Drawing Title

VRV JOINERY CASING DETAIL

Scale	1:5 @ A1	Date	07.02.13
Drawn	R.J.L.	Checked	G.N.T.

Drawing Status


PLANNING

Revision	0								
----------	---	--	--	--	--	--	--	--	--


Drawing No. TPS/3GS/VRV/J

THIS DRAWING MUST NOT BE REPRODUCED WITHOUT PRIOR CONSENT.
DO NOT SCALE FROM THIS DRAWING.
THIS DRAWING IS COPYRIGHTED


GENERAL NOTES

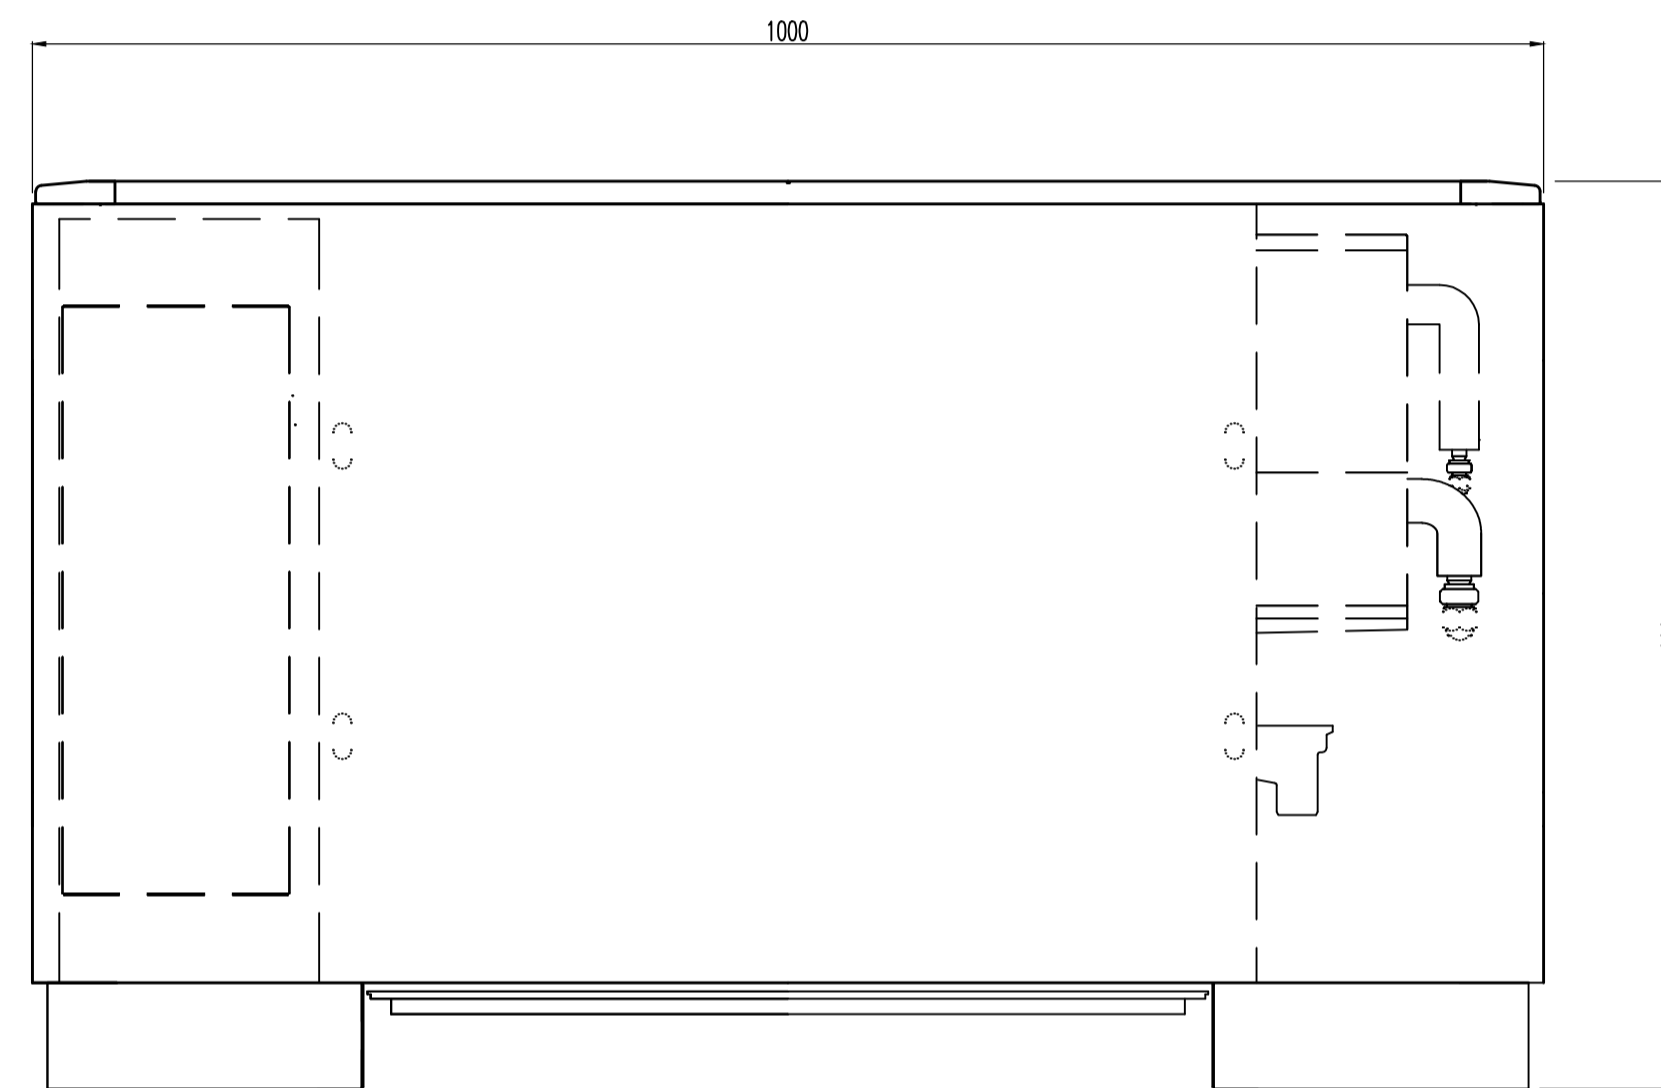

FRONT VIEW


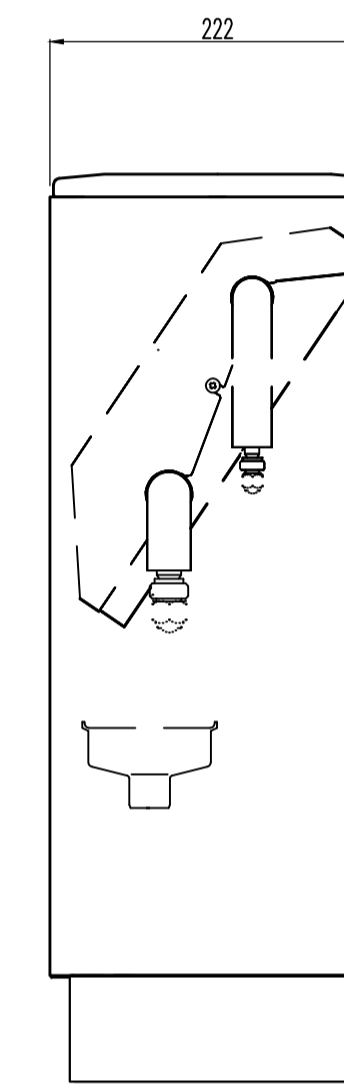


SECTION

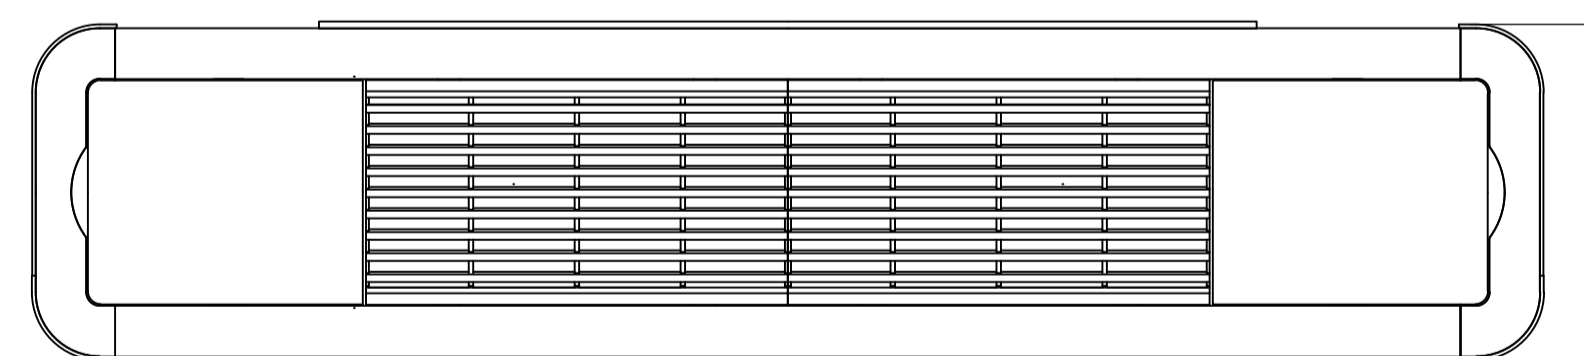

PLAN

DAIKIN PROPRIETARY METAL CASED VRV UNITS

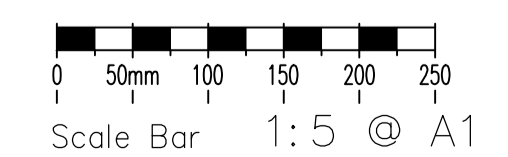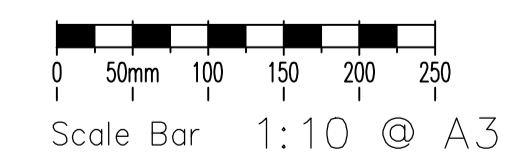

PLANNING


0	FEB.13	PLANNING ISSUE
Rev	Date	Description

TPS

Taylor Project Services LLP

No.1 Cornhill
London EC3V 3ND
Tel 020 7743 6602
www.taylorprojectservices.com

Client



THE BEDFORD ESTATES

29a Montague Street
London
WC1B 5BL
Tel: 0201 626 2885
Fax: 0201 256 1729

Project

3 GOWER STREET
LONDON
WC1

Drawing Title

VRV STANDARD CASING DETAIL

Scale	1:5 @ A1	Date	07.02.13
Drawn	R.J.L.	Checked	G.N.T.

Drawing Status


PLANNING

Revision	0																		
----------	---	--	--	--	--	--	--	--	--	--	--	--	--	--	--	--	--	--	--


Drawing No.

TPS/3GS/VRV/M

NOTES

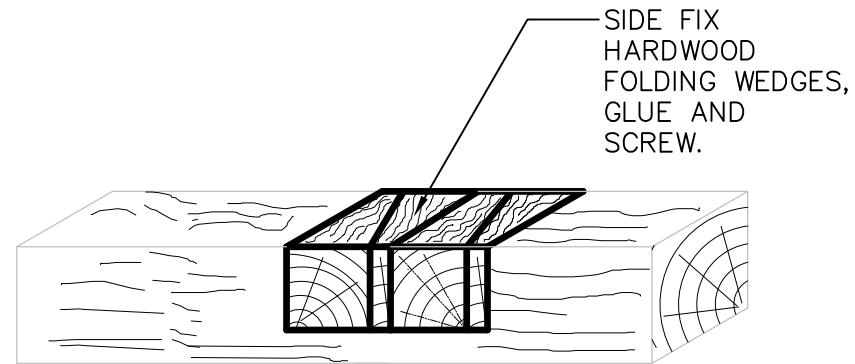


NOTCH REPAIR DETAIL
FOR LONG NOTCH
FOR NOTCHES GREATER THAN 25mm DEEP.

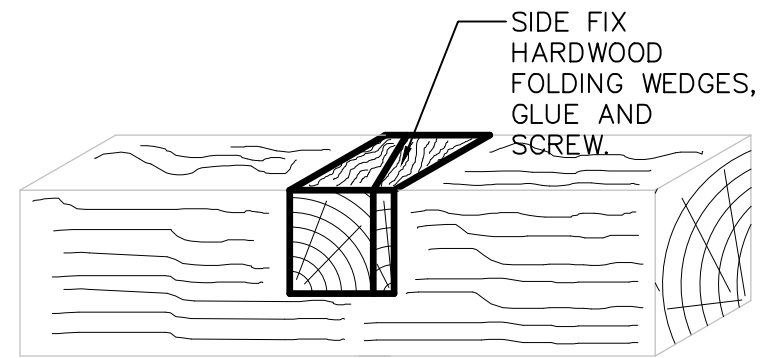


NOTCH REPAIR DETAIL 2
FOR NOTCHES GREATER THAN 25mm DEEP.

NOTES

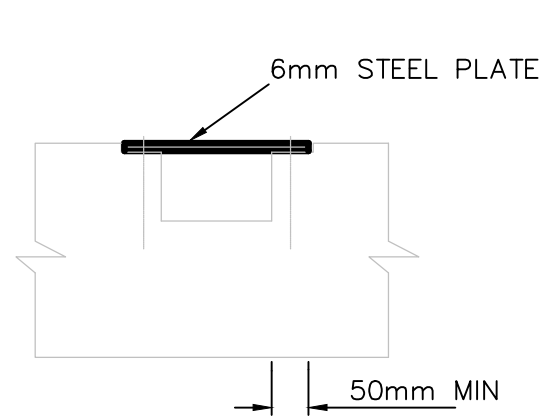


NOTCH REPAIR DETAIL 1
FOR NOTCHES UPTO 25mm DEEP AND OVER SERVICES

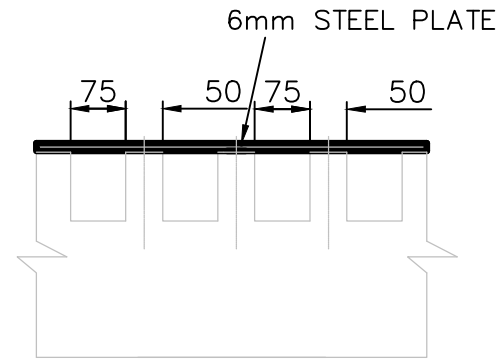

MULTI-NOTCH DETAIL 2
FOR NOTCHES UPTO 25mm DEEP AND OVER SERVICES



PLAN ON NOTCH REPAIR

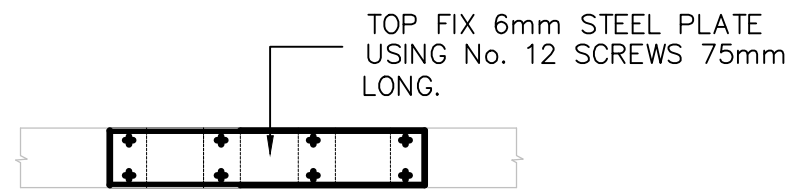

PLAN ON MULTI-NOTCH REPAIR