


ENTRANCE FROM  
EUSTON ROAD

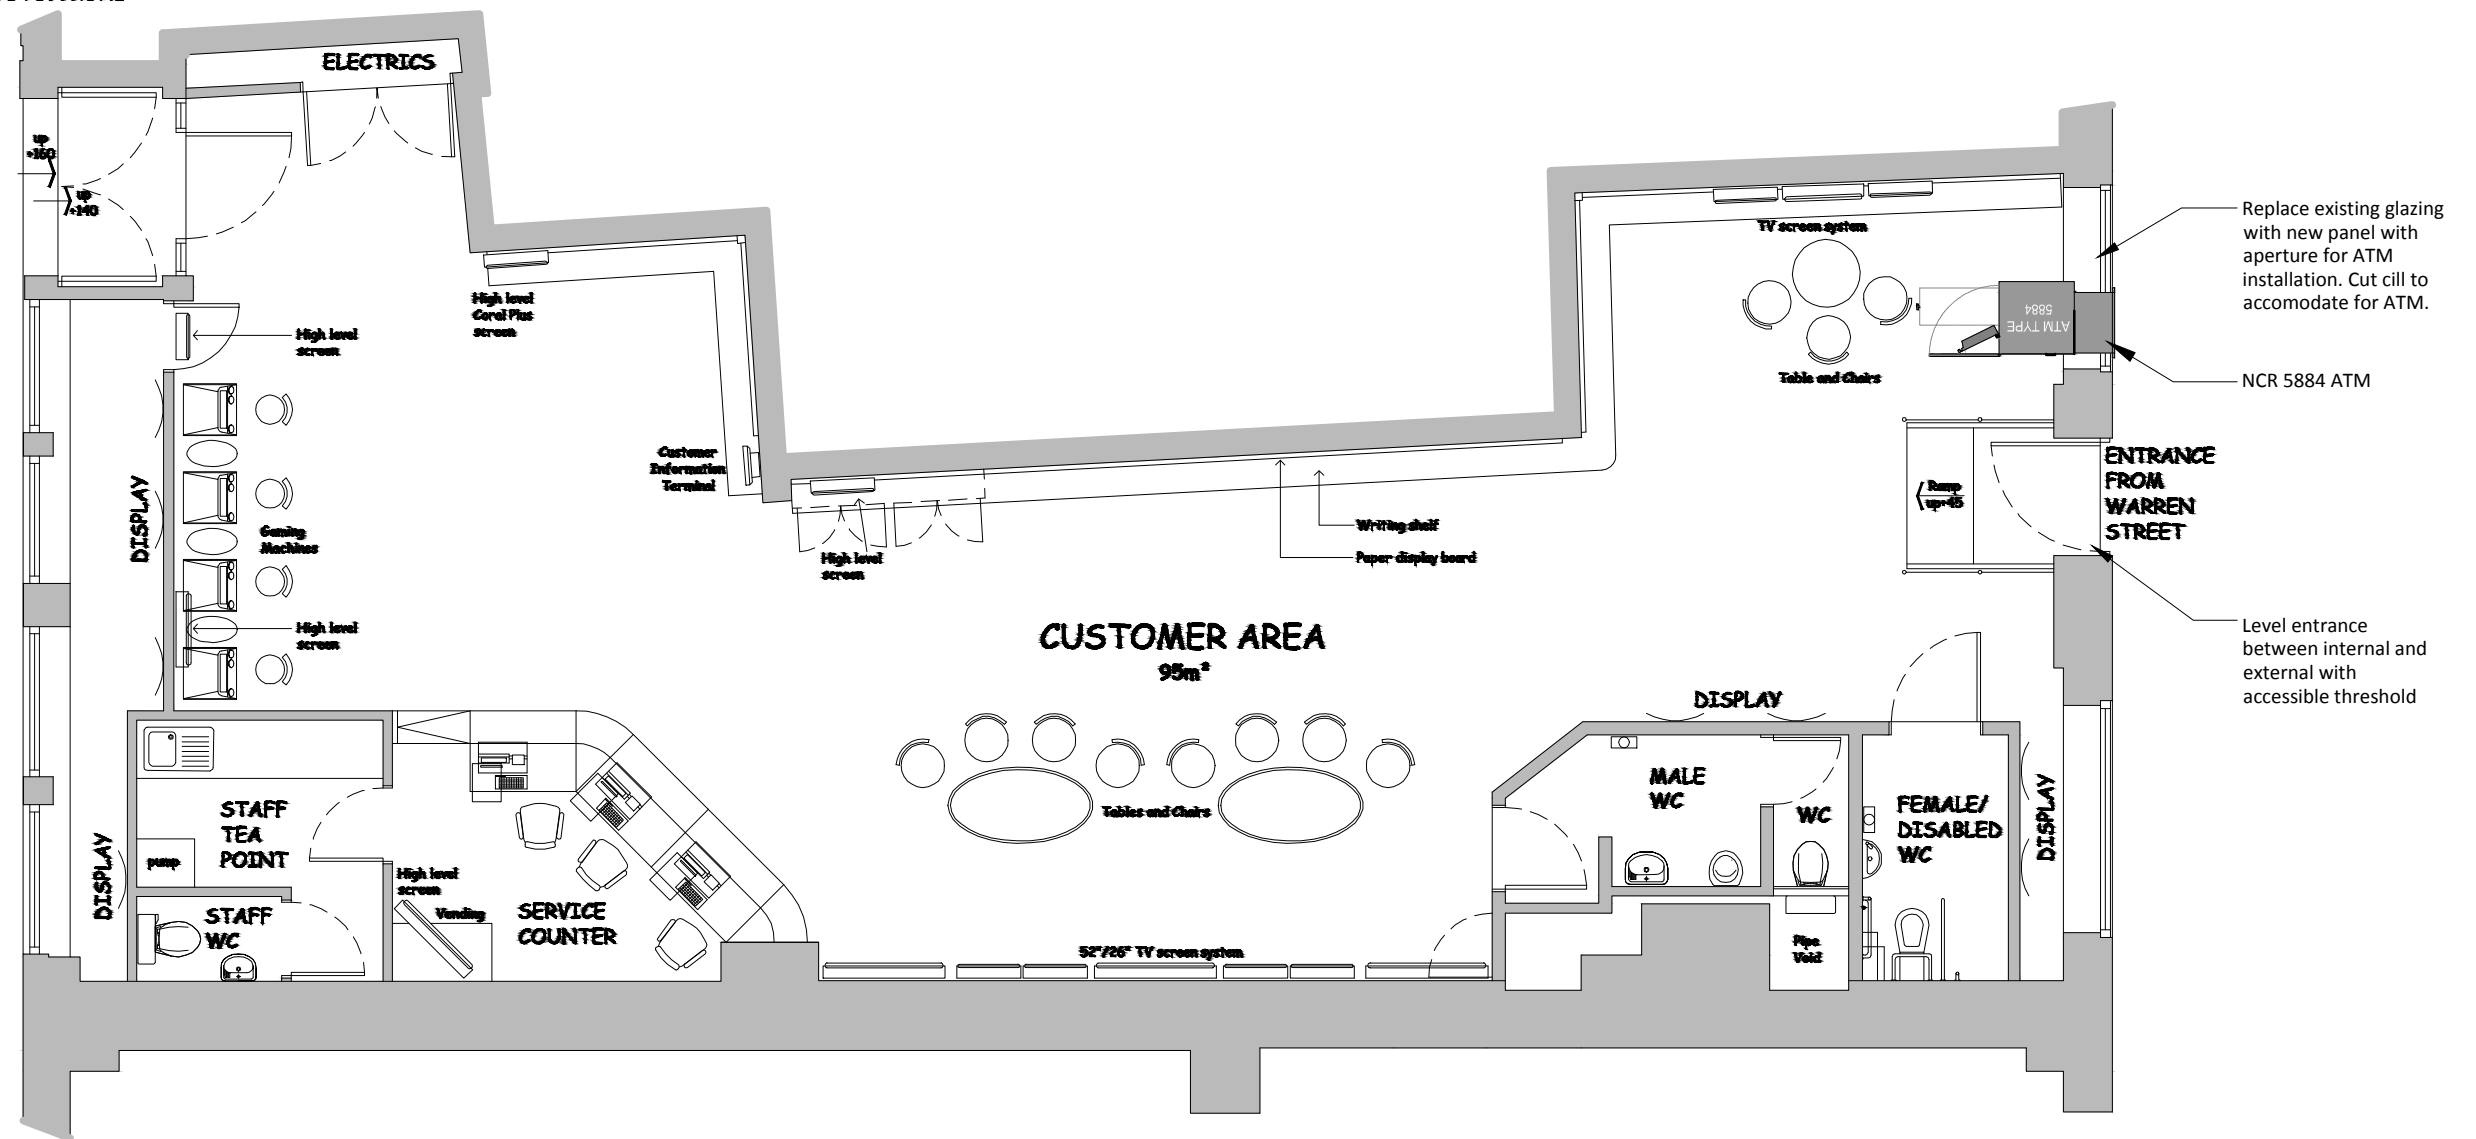


GROUND FLOOR PLAN

EXISTING PLAN  
SCALE 1:200 @ A3

NOTES:

1. Window cill to be cut to accommodate for ATM.
2. MBH 120 Circuit breaker required for main supply. Comms situated behind counter

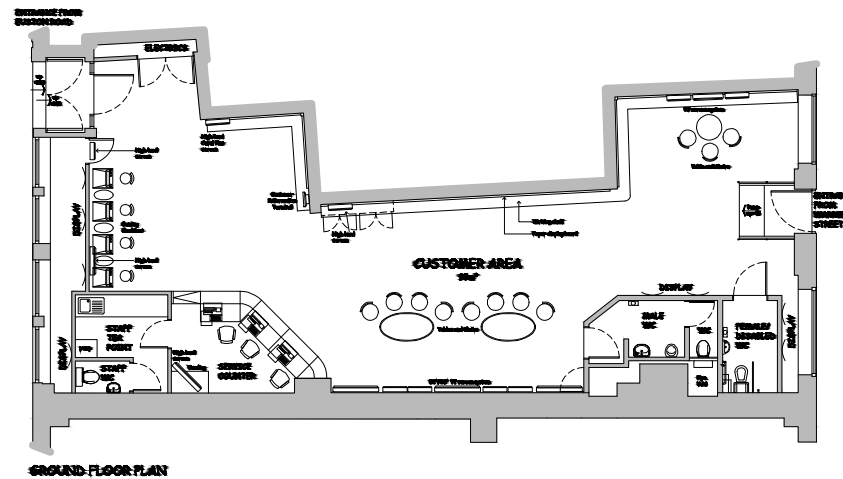

GROUND FLOOR PLAN

Project	IFC3040 Coral Warren Street
Dwg No.	P-101
Date	12/02/13

Title	Ground Floor Plan
Scale @	Various @ A3
Dwn	DS

Address	75 Warren Street
	London
	W1T 5PF



KINGS SECURITY SYSTEMS  
ATM DIVISION  
Unit 4 St. Dunstons Technology Park  
Off Ripley Street  
Bradford BD4 7HH  
01274 377500  
atm@kingslid.co.uk